


**LEGEND**

DRAINAGE AREA (x)      AREA (XXX) (ha.)  
 0.XX

5 YEAR RUNOFF COEFFICIENT

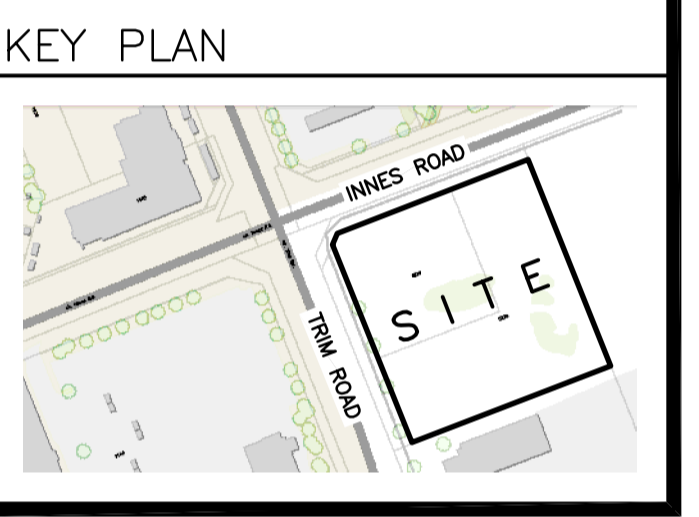

No.	DATE	REVISION
2	DEC 21-22	ISSUED FOR APPROVAL
1	DEC 19-22	ISSUED FOR COORDINATION

**D. B. GRAY ENGINEERING INC.**  
 Stormwater Management - Grading & Drainage - Storm & Sanitary Sewers - Watermain  
 700 Long Point Circle      613-425-8044  
 Ottawa, Ontario      d.gray@dbgrayengineering.com

Project  
**PROPOSED 3-STORY DYMON STORAGE BUILDING**  
 5210 INNES ROAD  
 OTTAWA, ONTARIO

**DRAINAGE PLAN**

Engineer's Seal

NOT VALID UNLESS SIGNED & DATED

Drawn: D.B.G.  
 H. Scale: 1:250  
 V. Scale:  
 Date: DEC 19-22  
 Job No.: 21025

Drawing No.  
**C-7**  
 of 7