


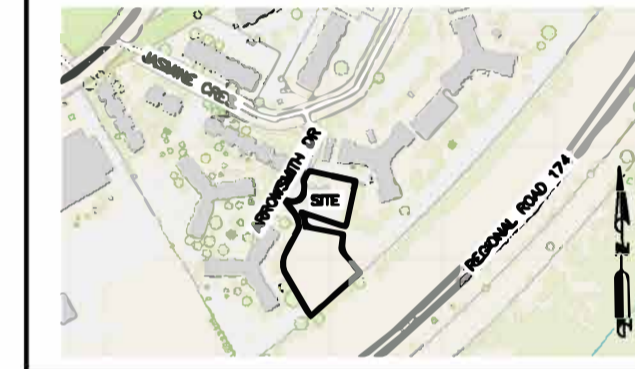

REFER TO NOTES, & DETAILS
ON DRAWINGS C-10 & C-11

KEY PLAN



No.	DATE	REVISION
4	JAN 17-25	ISSUED FOR ZONING
3	DEC 6-24	ISSUED FOR BUILDING PERMIT
2	DEC 21-22	ISSUED FOR APPROVAL
1	DEC 19-22	ISSUED FOR COORDINATION

D. B. GRAY ENGINEERING INC.


Stormwater Management - Grading & Drainage - Storm & Sanitary Sewers - Watermain
700 Long Point Circle 613-425-8044
Ottawa, Ontario d.gray@dbgrayengineering.com

Project

**PROPOSED 6-STORY
MIXED-USE BUILDING
2040 ARROWSMITH DRIVE
OTTAWA, ONTARIO**

Drawing Title

SITE PLAN

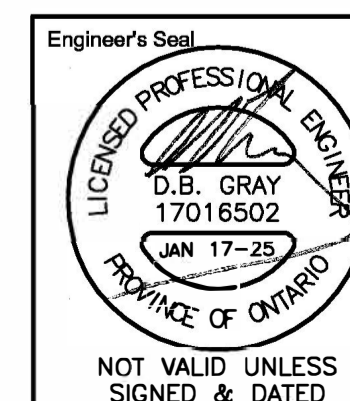

NOT VALID UNLESS
SIGNED & DATED

Drawn D.B.G.
H. Scale 1:400
V. Scale
Date NOV 29-22
Job No. 22062

Drawing No.
C-1
of 17

#18936

D07-12-23-0014