

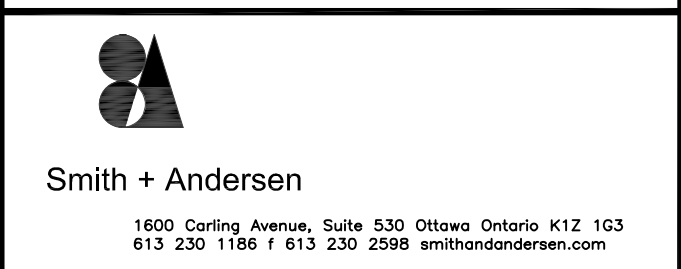
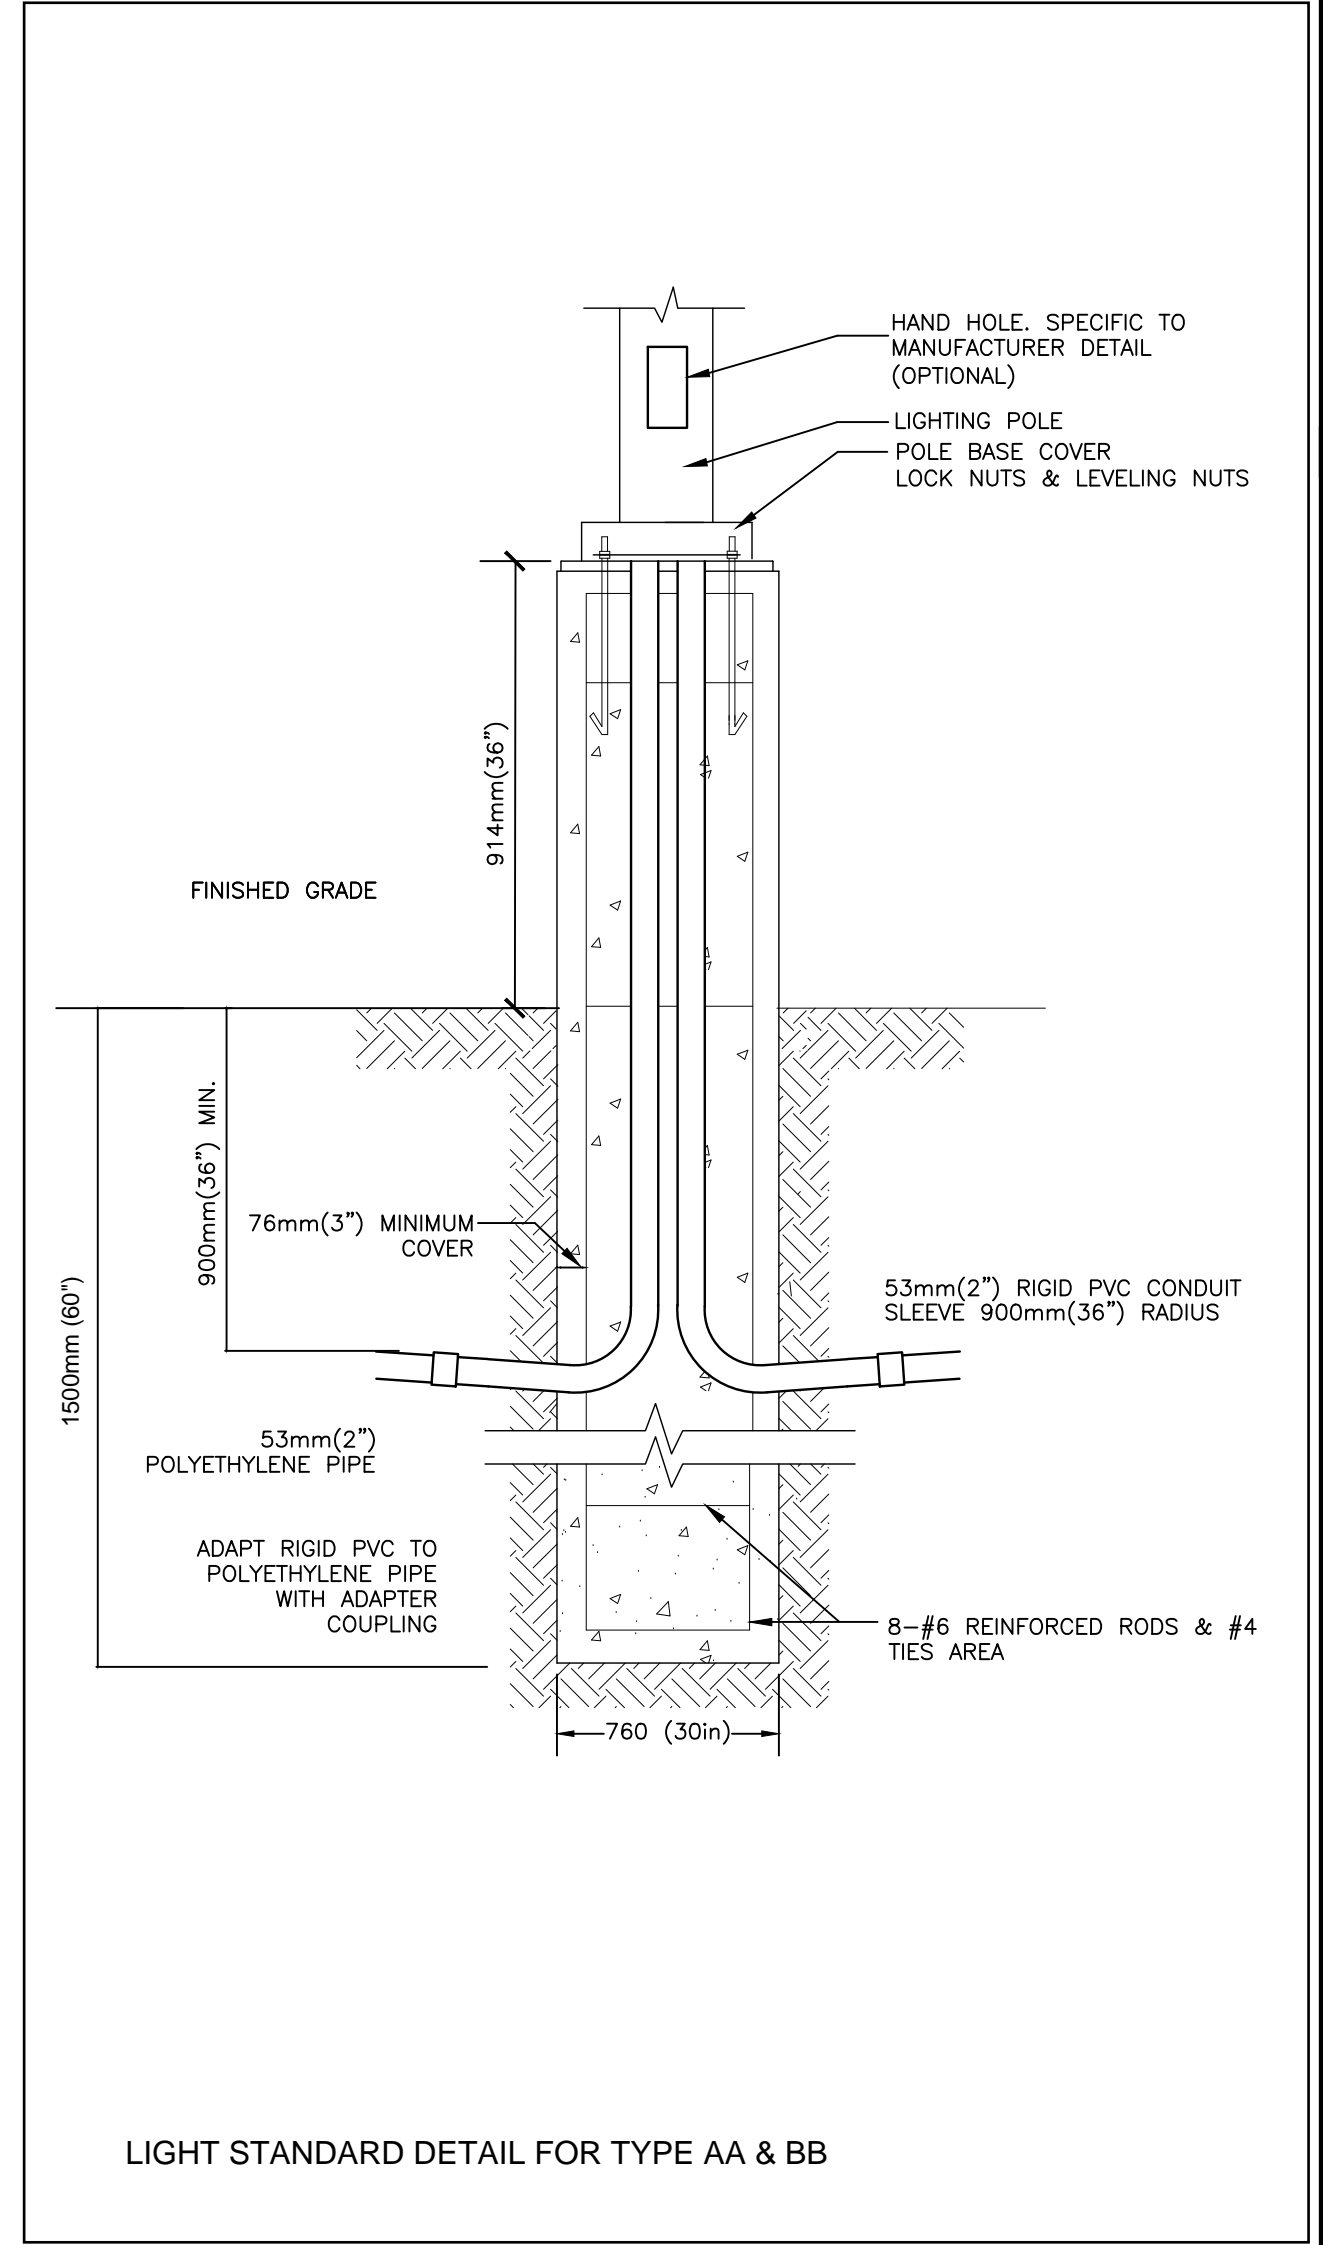


IT IS THE RESPONSIBILITY OF THE APPROPRIATE CONTRACTOR TO CHECK AND VERIFY ALL DIMENSIONS ON SITE AND TO REPORT ALL ERRORS AND/OR OMISSIONS TO THE ARCHITECT.
ALL CONTRACTORS MUST COMPLY WITH ALL PERTINENT CODES AND BY-LAWS.
THIS DRAWING MAY NOT BE USED FOR CONSTRUCTION UNITS, SIGNED BY THE ARCHITECT.
DO NOT SCALE DRAWINGS.
COPYRIGHT RESERVED.

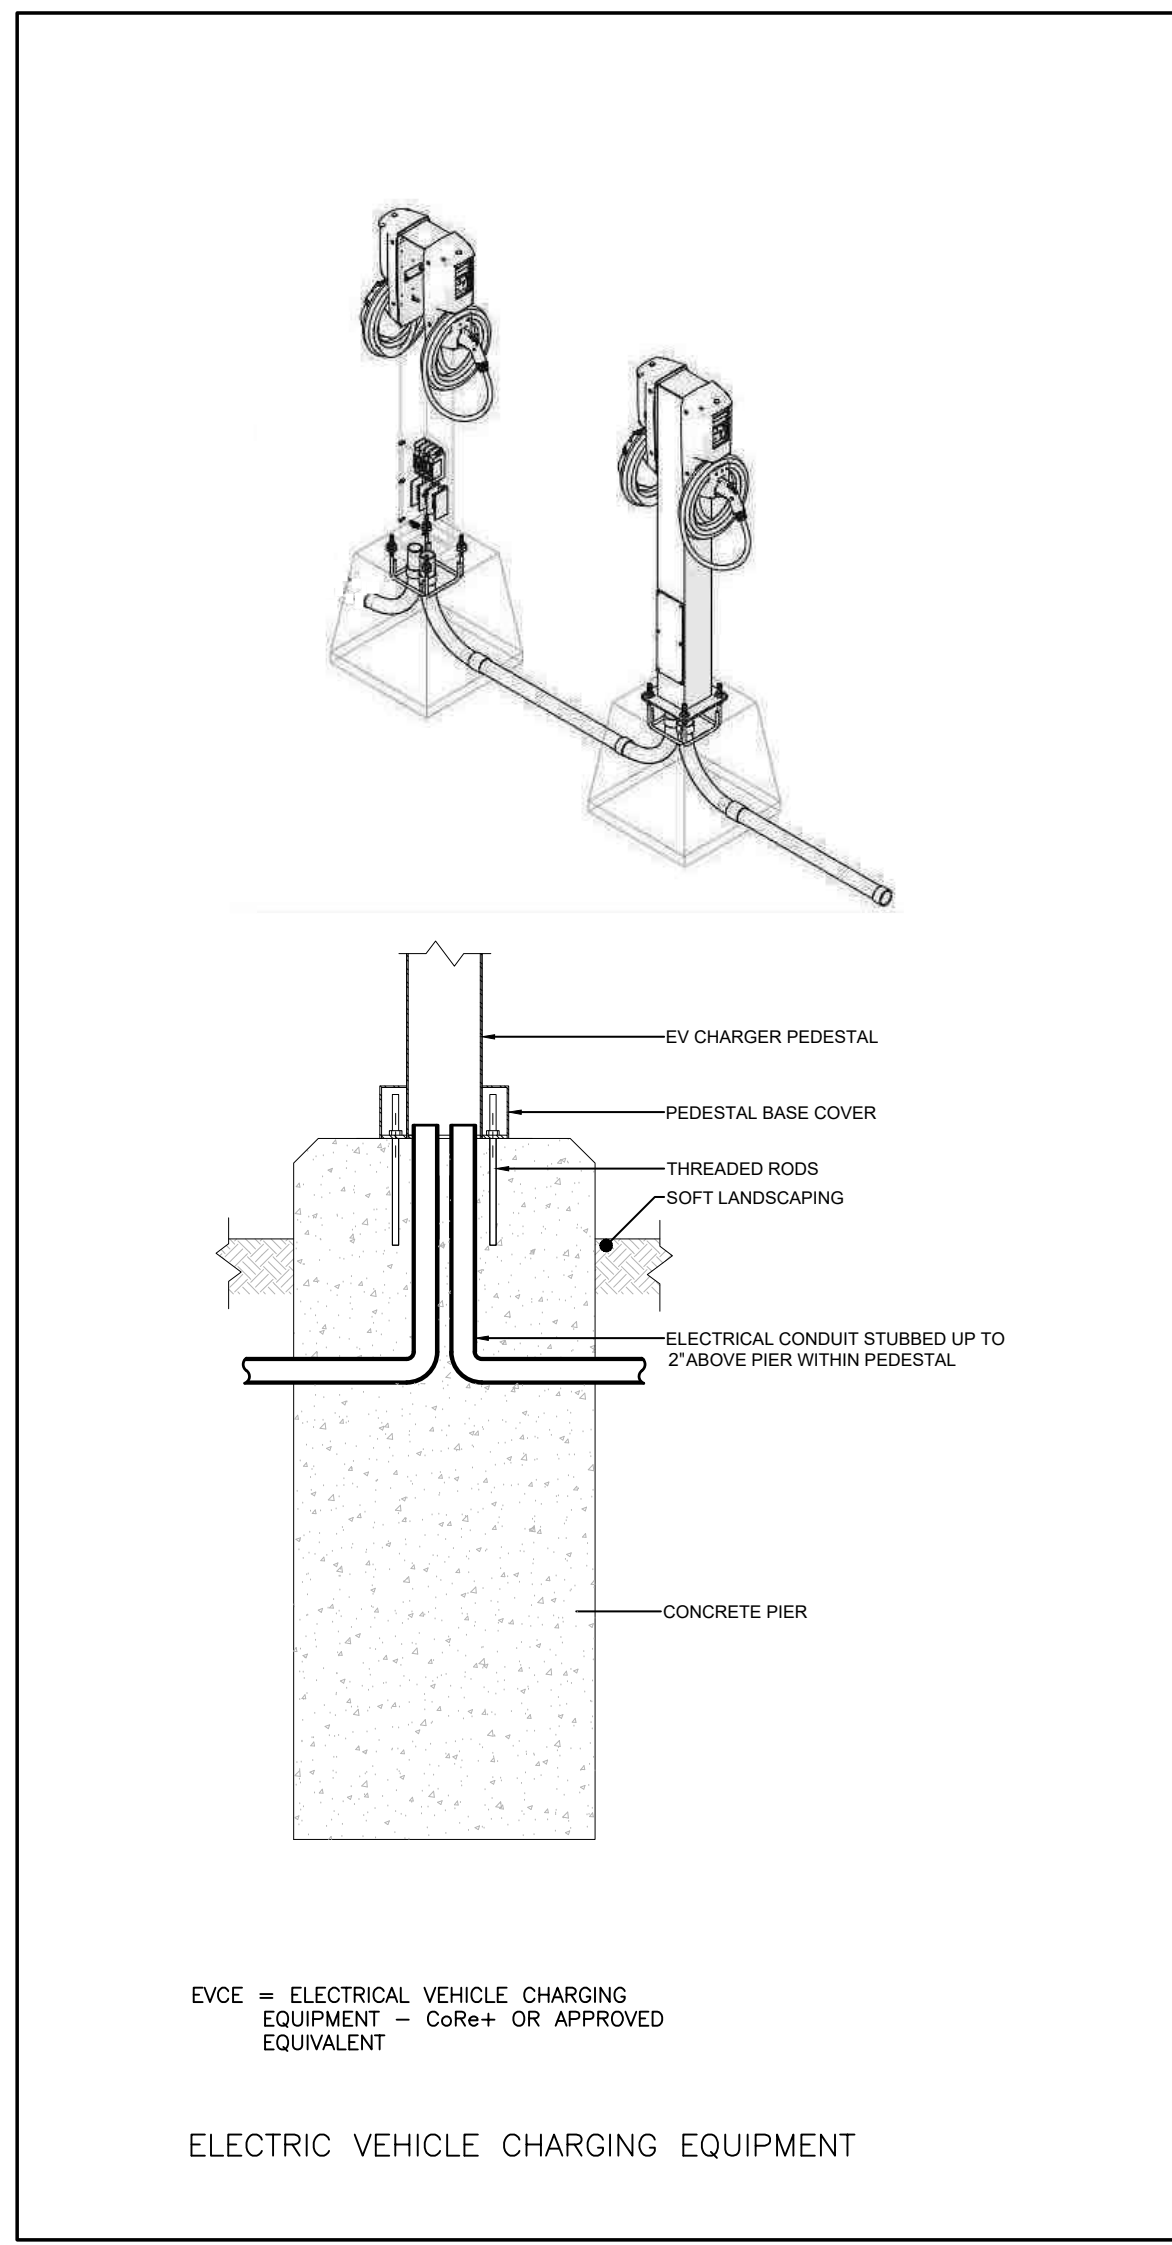


- DRAWING NOTES:**
- ① DUAL ELECTRIC VEHICLE CHARGING STATIONS
 - ② PROVIDE 2-2" CONDUITS FOR FUTURE ELECTRIC VEHICLE CHARGING STATIONS. CONDUITS STUB UP IN LANDSCAPE AREA BACK TO MAIN ELECTRICAL ROOM.
 - ③ HYDRO PAD MOUNTED TRANSFORMER

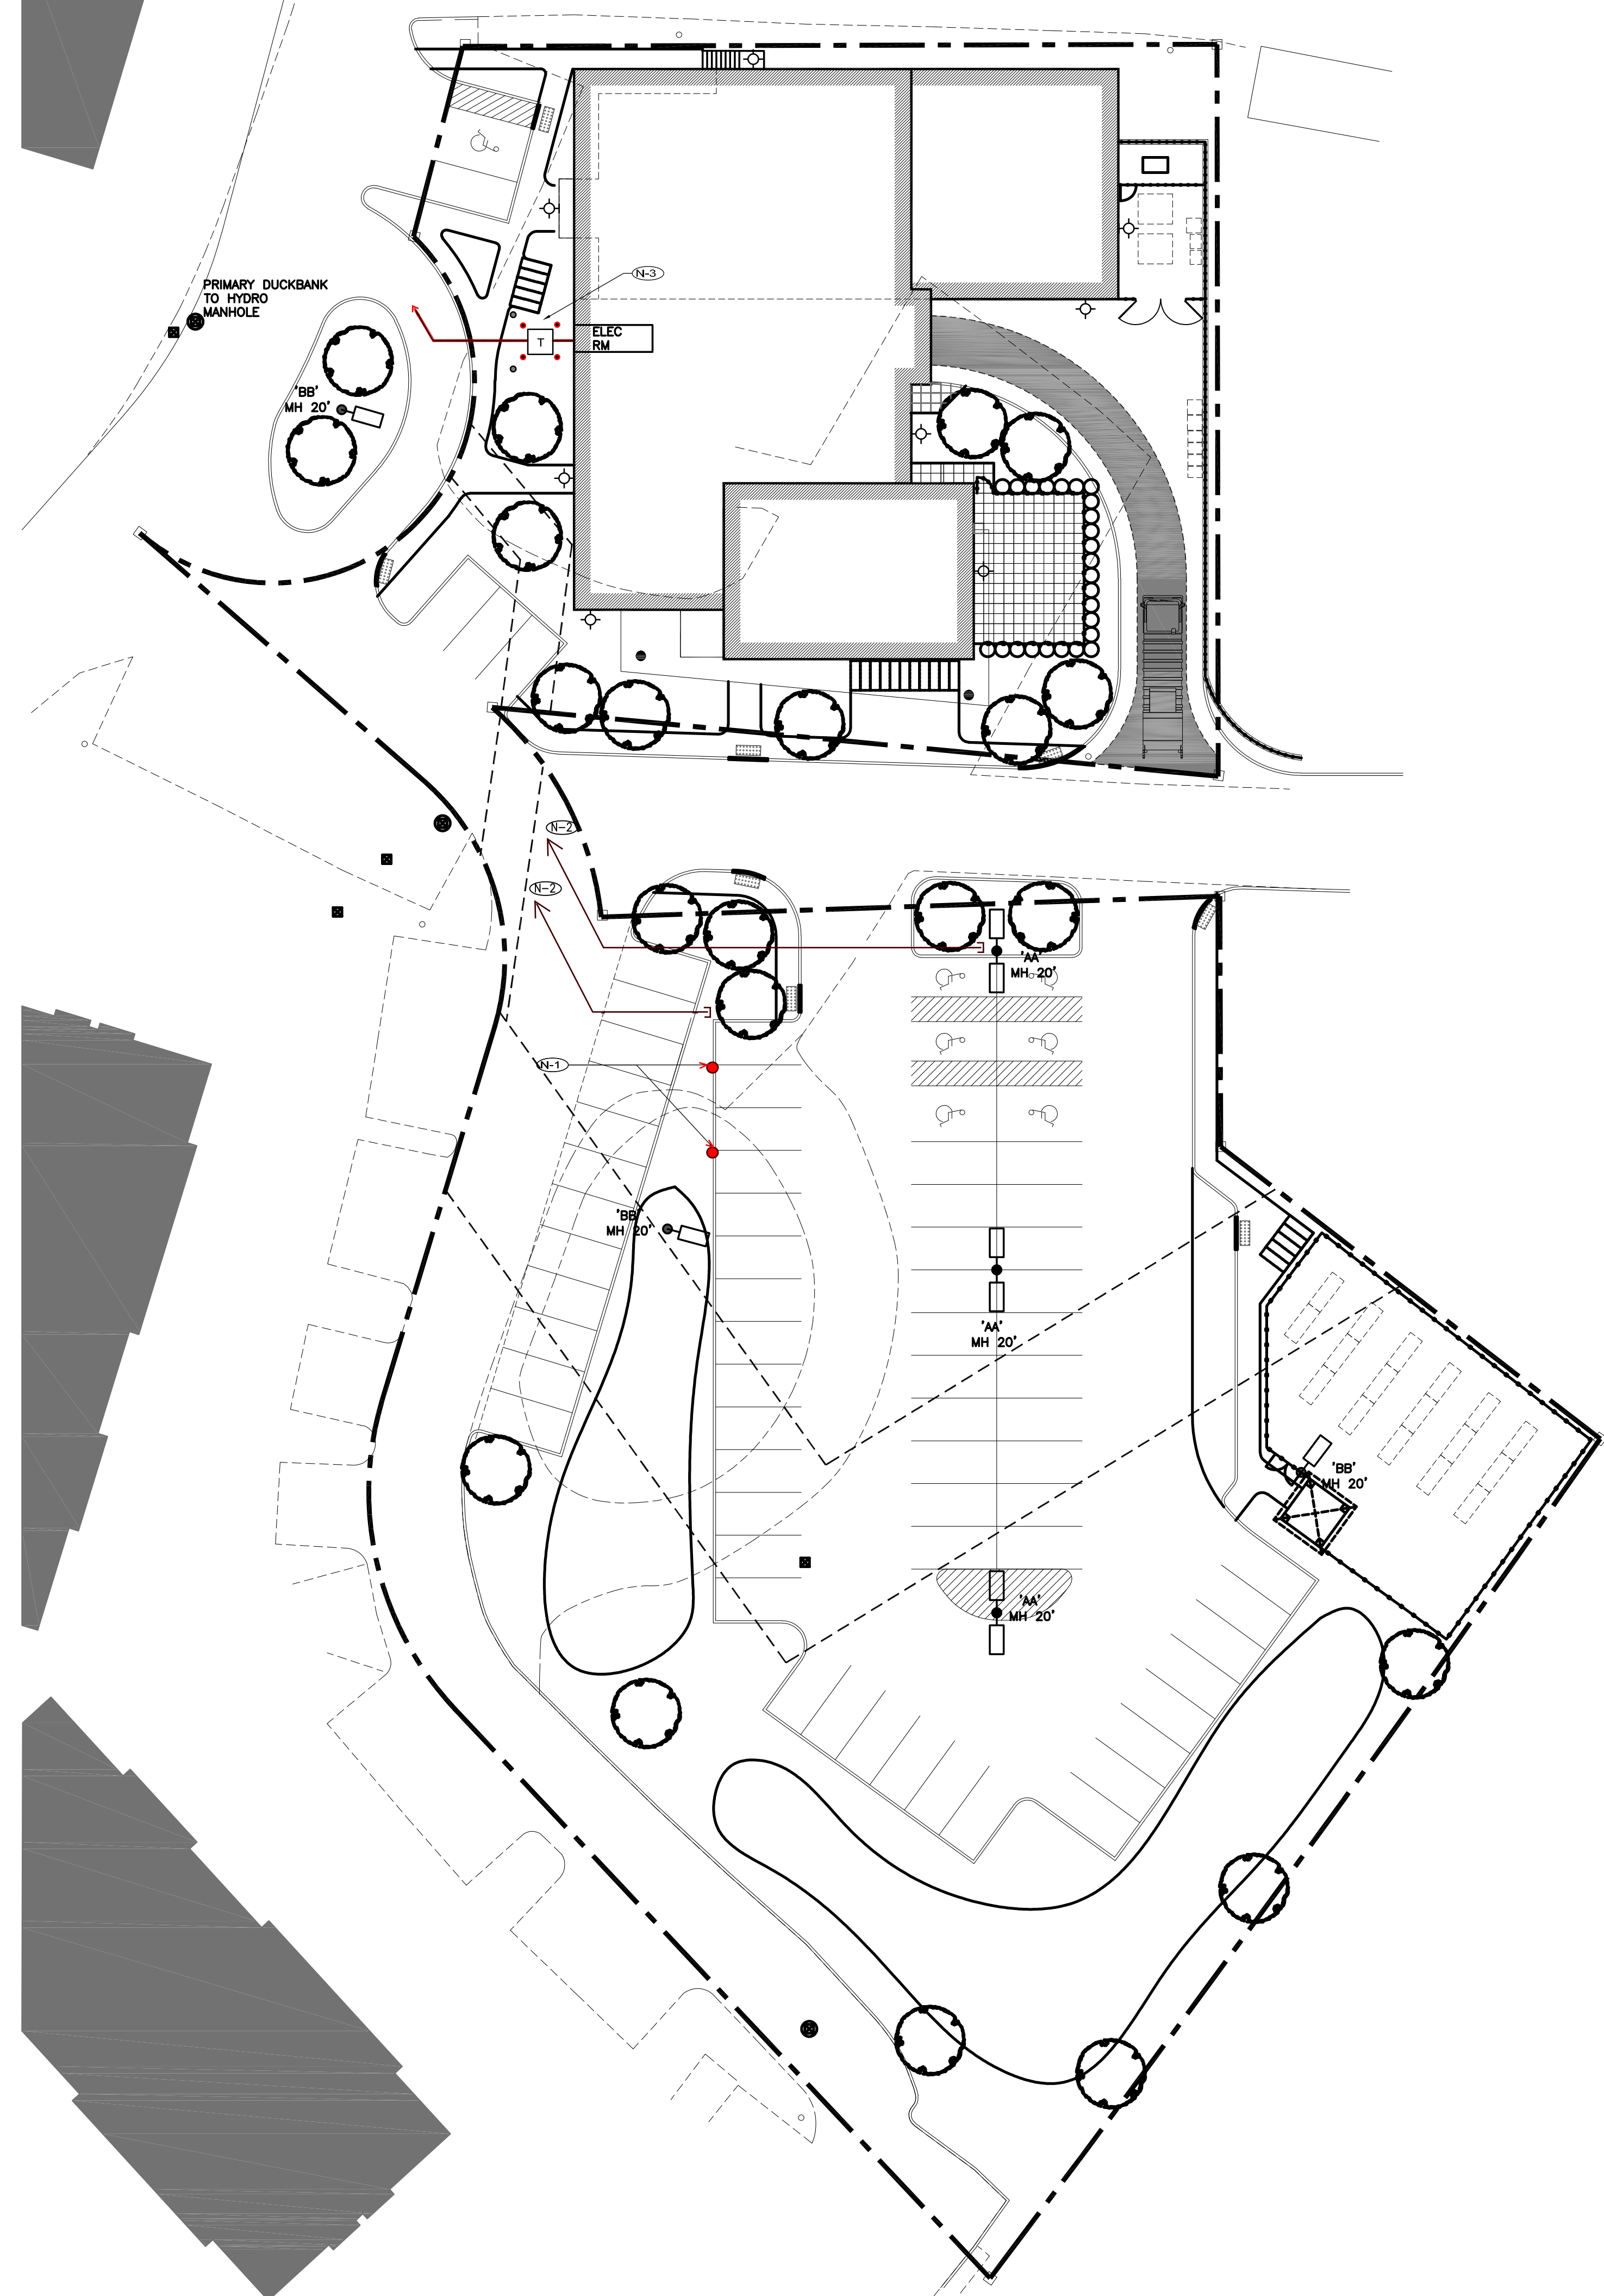

No.	DESCRIPTION	DATE
-----	-------------	------

REVISIONS:

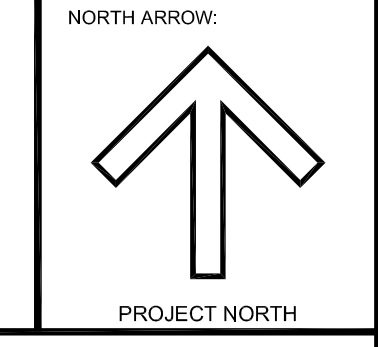

CLIENT:

WIGWAMEN

ARCHITECT:



PROJECT TITLE:

WIGWAMEN

2040 ARROWSMITH DRIVE, OTTAWA, ON, K1J8V9

OTTAWA ONTARIO

SHEET TITLE:

ELECTRICAL SITE PLAN

DRAWN: BZ CHECKED: ML

SCALE: 1:250 SHEET No. E100

PROJECT No. 22734.000