




KEY MAP  
SCALE: N.T.S.

LEGEND



STORM DRAINAGE AREA

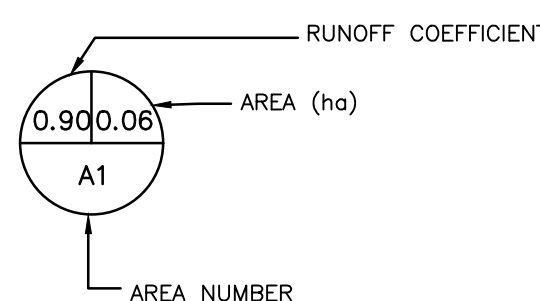


RUNOFF COEFFICIENT

AREA (ha)

AREA NUMBER

# SOMERSET STREET

SITE BENCHMARK  
FIRE HYDRANT  
(TOP OF SPINDLE)  
ELEVATION=73.19

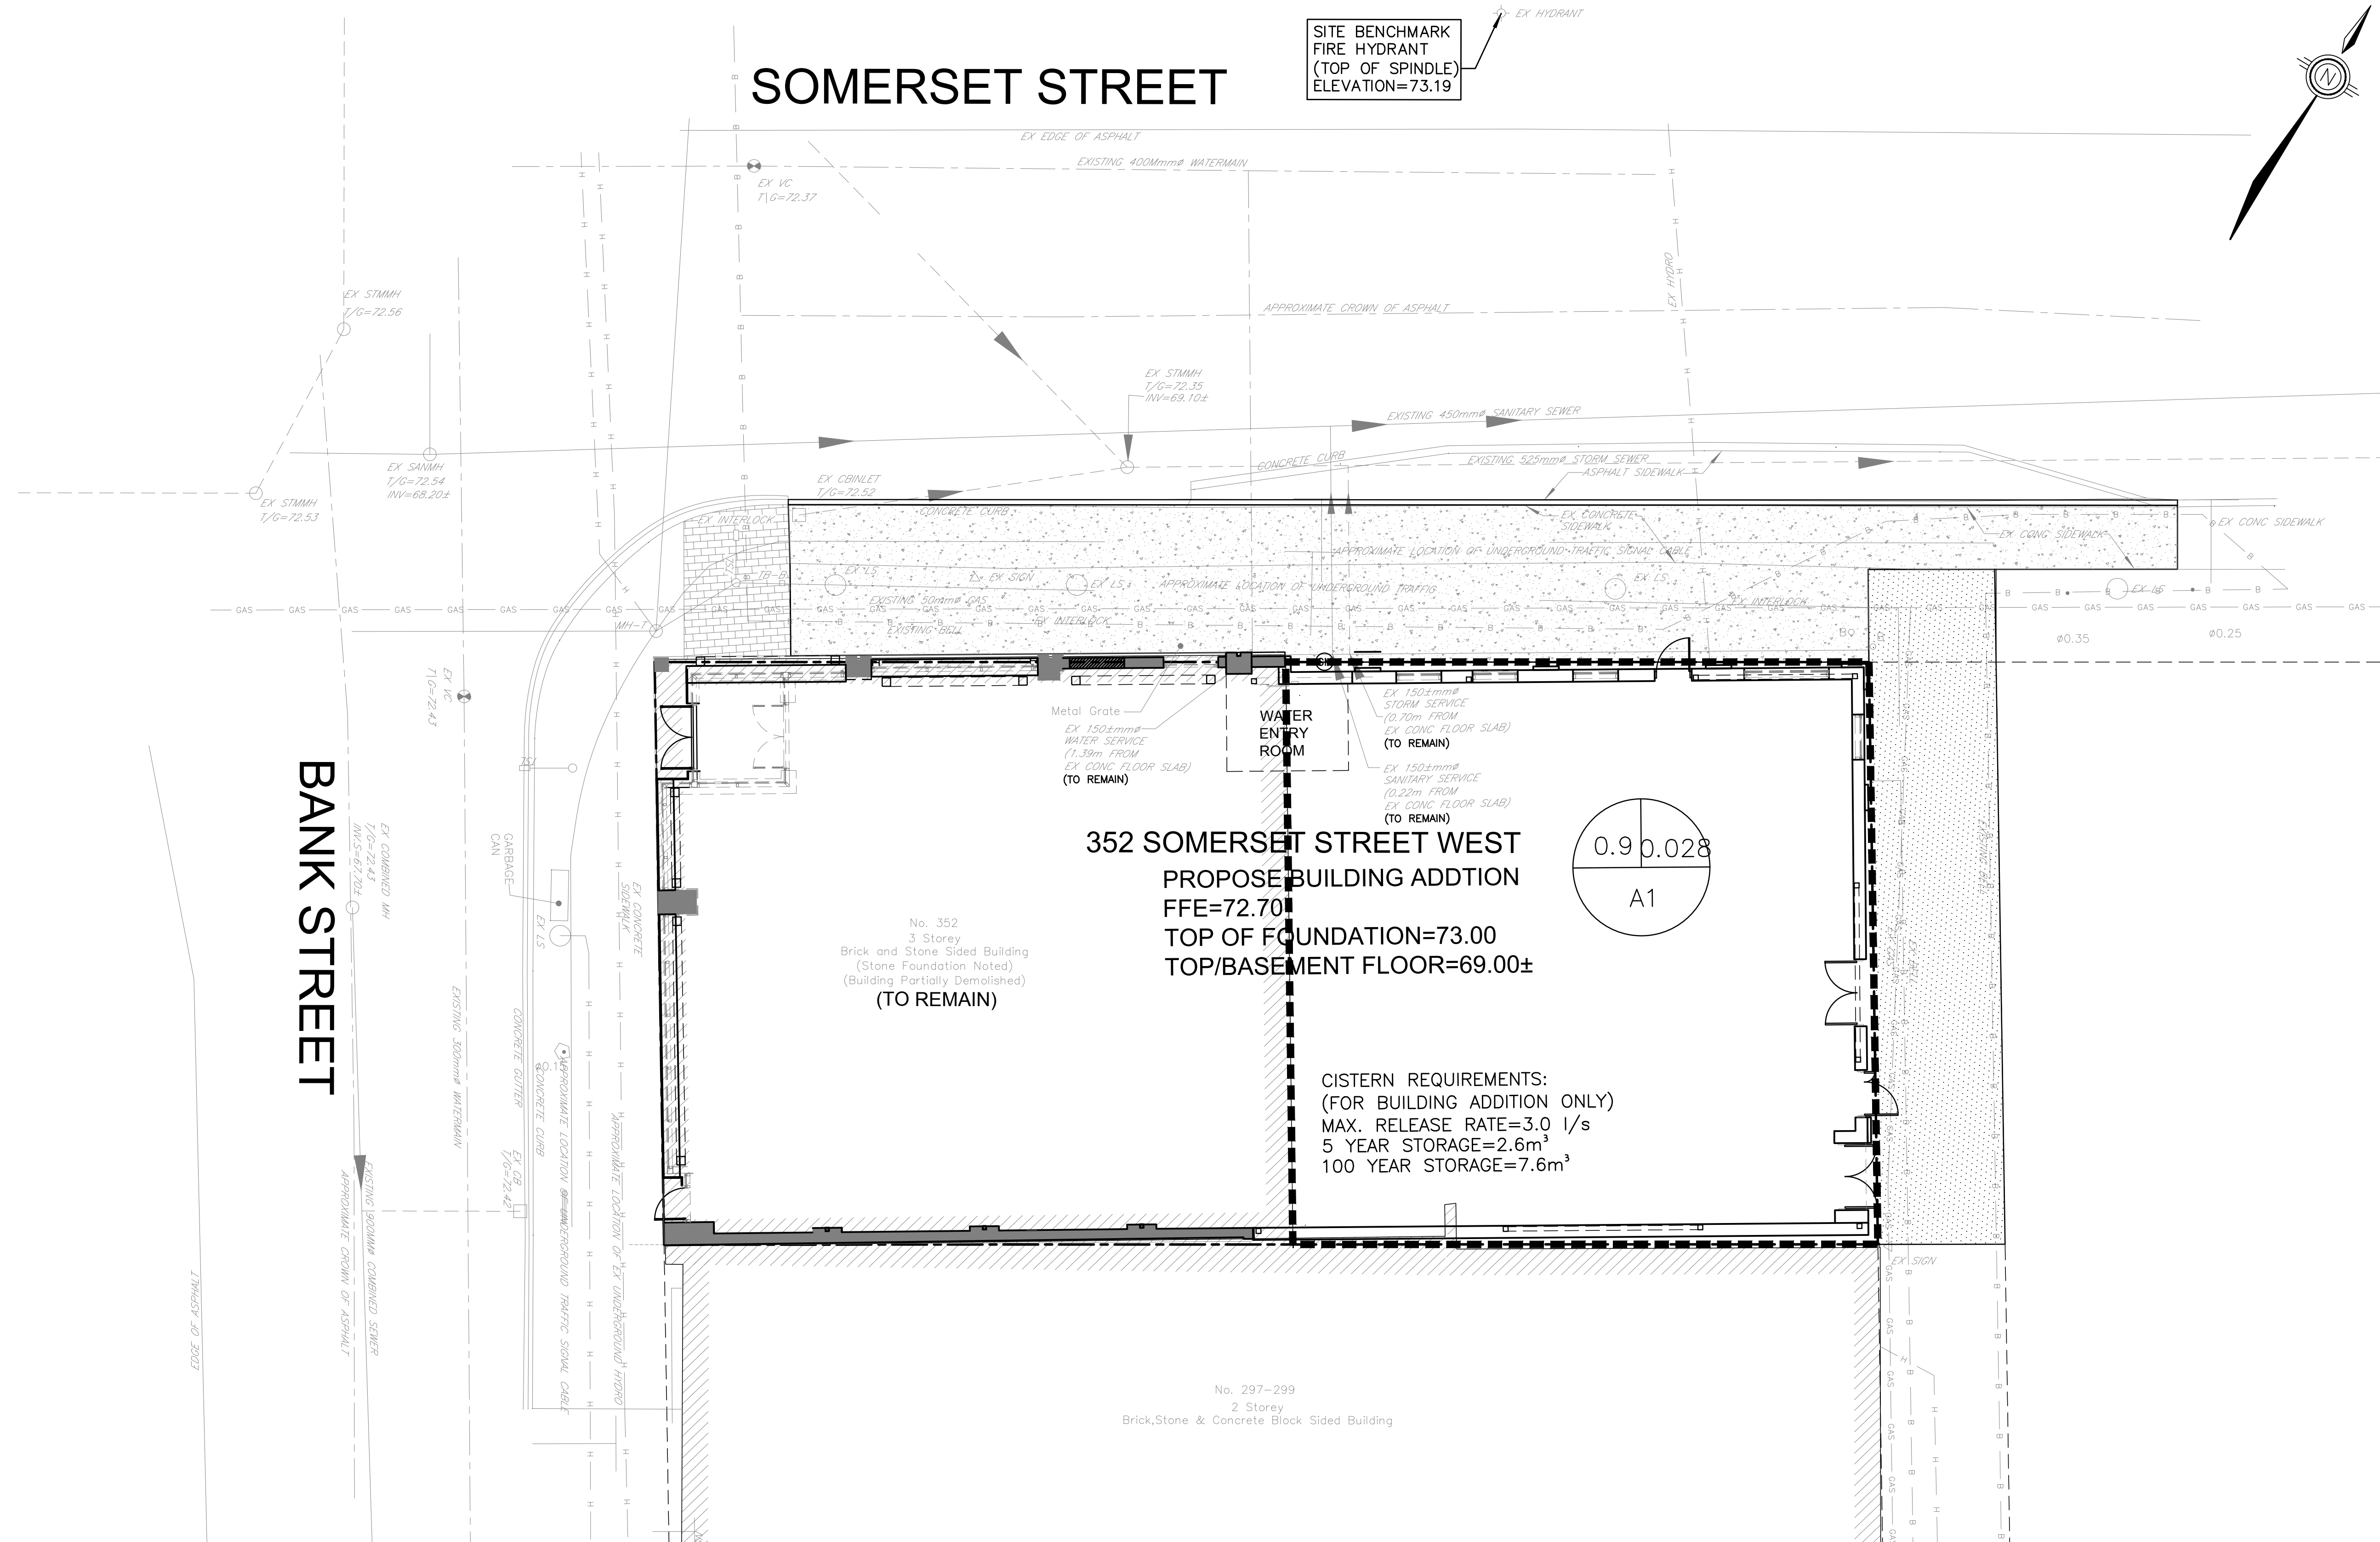

**CONTRACT DRAWINGS:**  
Contractor must verify all dimensions and be responsible for same. Any discrepancies must be reported to the Engineer before commencing work. Drawings are not to be copied, distributed or used by others without the express written consent of Ainley Graham & Associates Limited. Use of these drawings for any purpose other than that stipulated in the contract agreement between the owner/client and the Engineer without the express written consent of Ainley Graham & Associates Limited. Use of these drawings for any other purpose is subject to the following caution.

**CAUTION:** The information contained in this drawing is solely for the intended recipient. Any copying, distribution or use by others without the express written consent of Ainley Graham & Associates Limited is prohibited. The recipient is responsible for confirming the accuracy and completeness of the information with the originator. The recipient assumes all risks and liabilities associated with the use of the drawings. The recipient will save and hold harmless Ainley Graham & Associates Limited for any claims whatsoever associated with or related to the use of the drawings. The recipient will not reuse any portion of the drawings for any future project without the express written permission of Ainley Graham & Associates Limited.

NO.	REVISIONS	DATE	INITIAL
1	ISSUED FOR SITE PLAN APPROVAL	MAR 29/23	JX

Not Valid Unless Signed And Dated

**Professional Engineers**  
Ontario  
MARCH 29, 2023

**Limited Licensee**  
Name: J.W.XU  
Number: 100171806  
Category: CIVIL-see limitation  
Limitations:  
This licence is subject to the limitations as detailed on the certificate.  
Association of Professional Engineers of Ontario

SCALE: 1 : 100  
DESIGN: JX  
DRAWN: JX  
CHECKED: GSC/JX  
DATE: AUG 2022

SOMERSET HOUSE  
352 SOMERSET STREET WEST  
CITY OF OTTAWA

STORMWATER MANAGEMENT PLAN

CONSULTING ENGINEERS PLANNERS

CONTRACT No. 21038 003-21038-SWM1