



1815 MONTREAL RD


OTTAWA ON

RLA PROJECT #: 2405


rla / architecture

2025 05 01




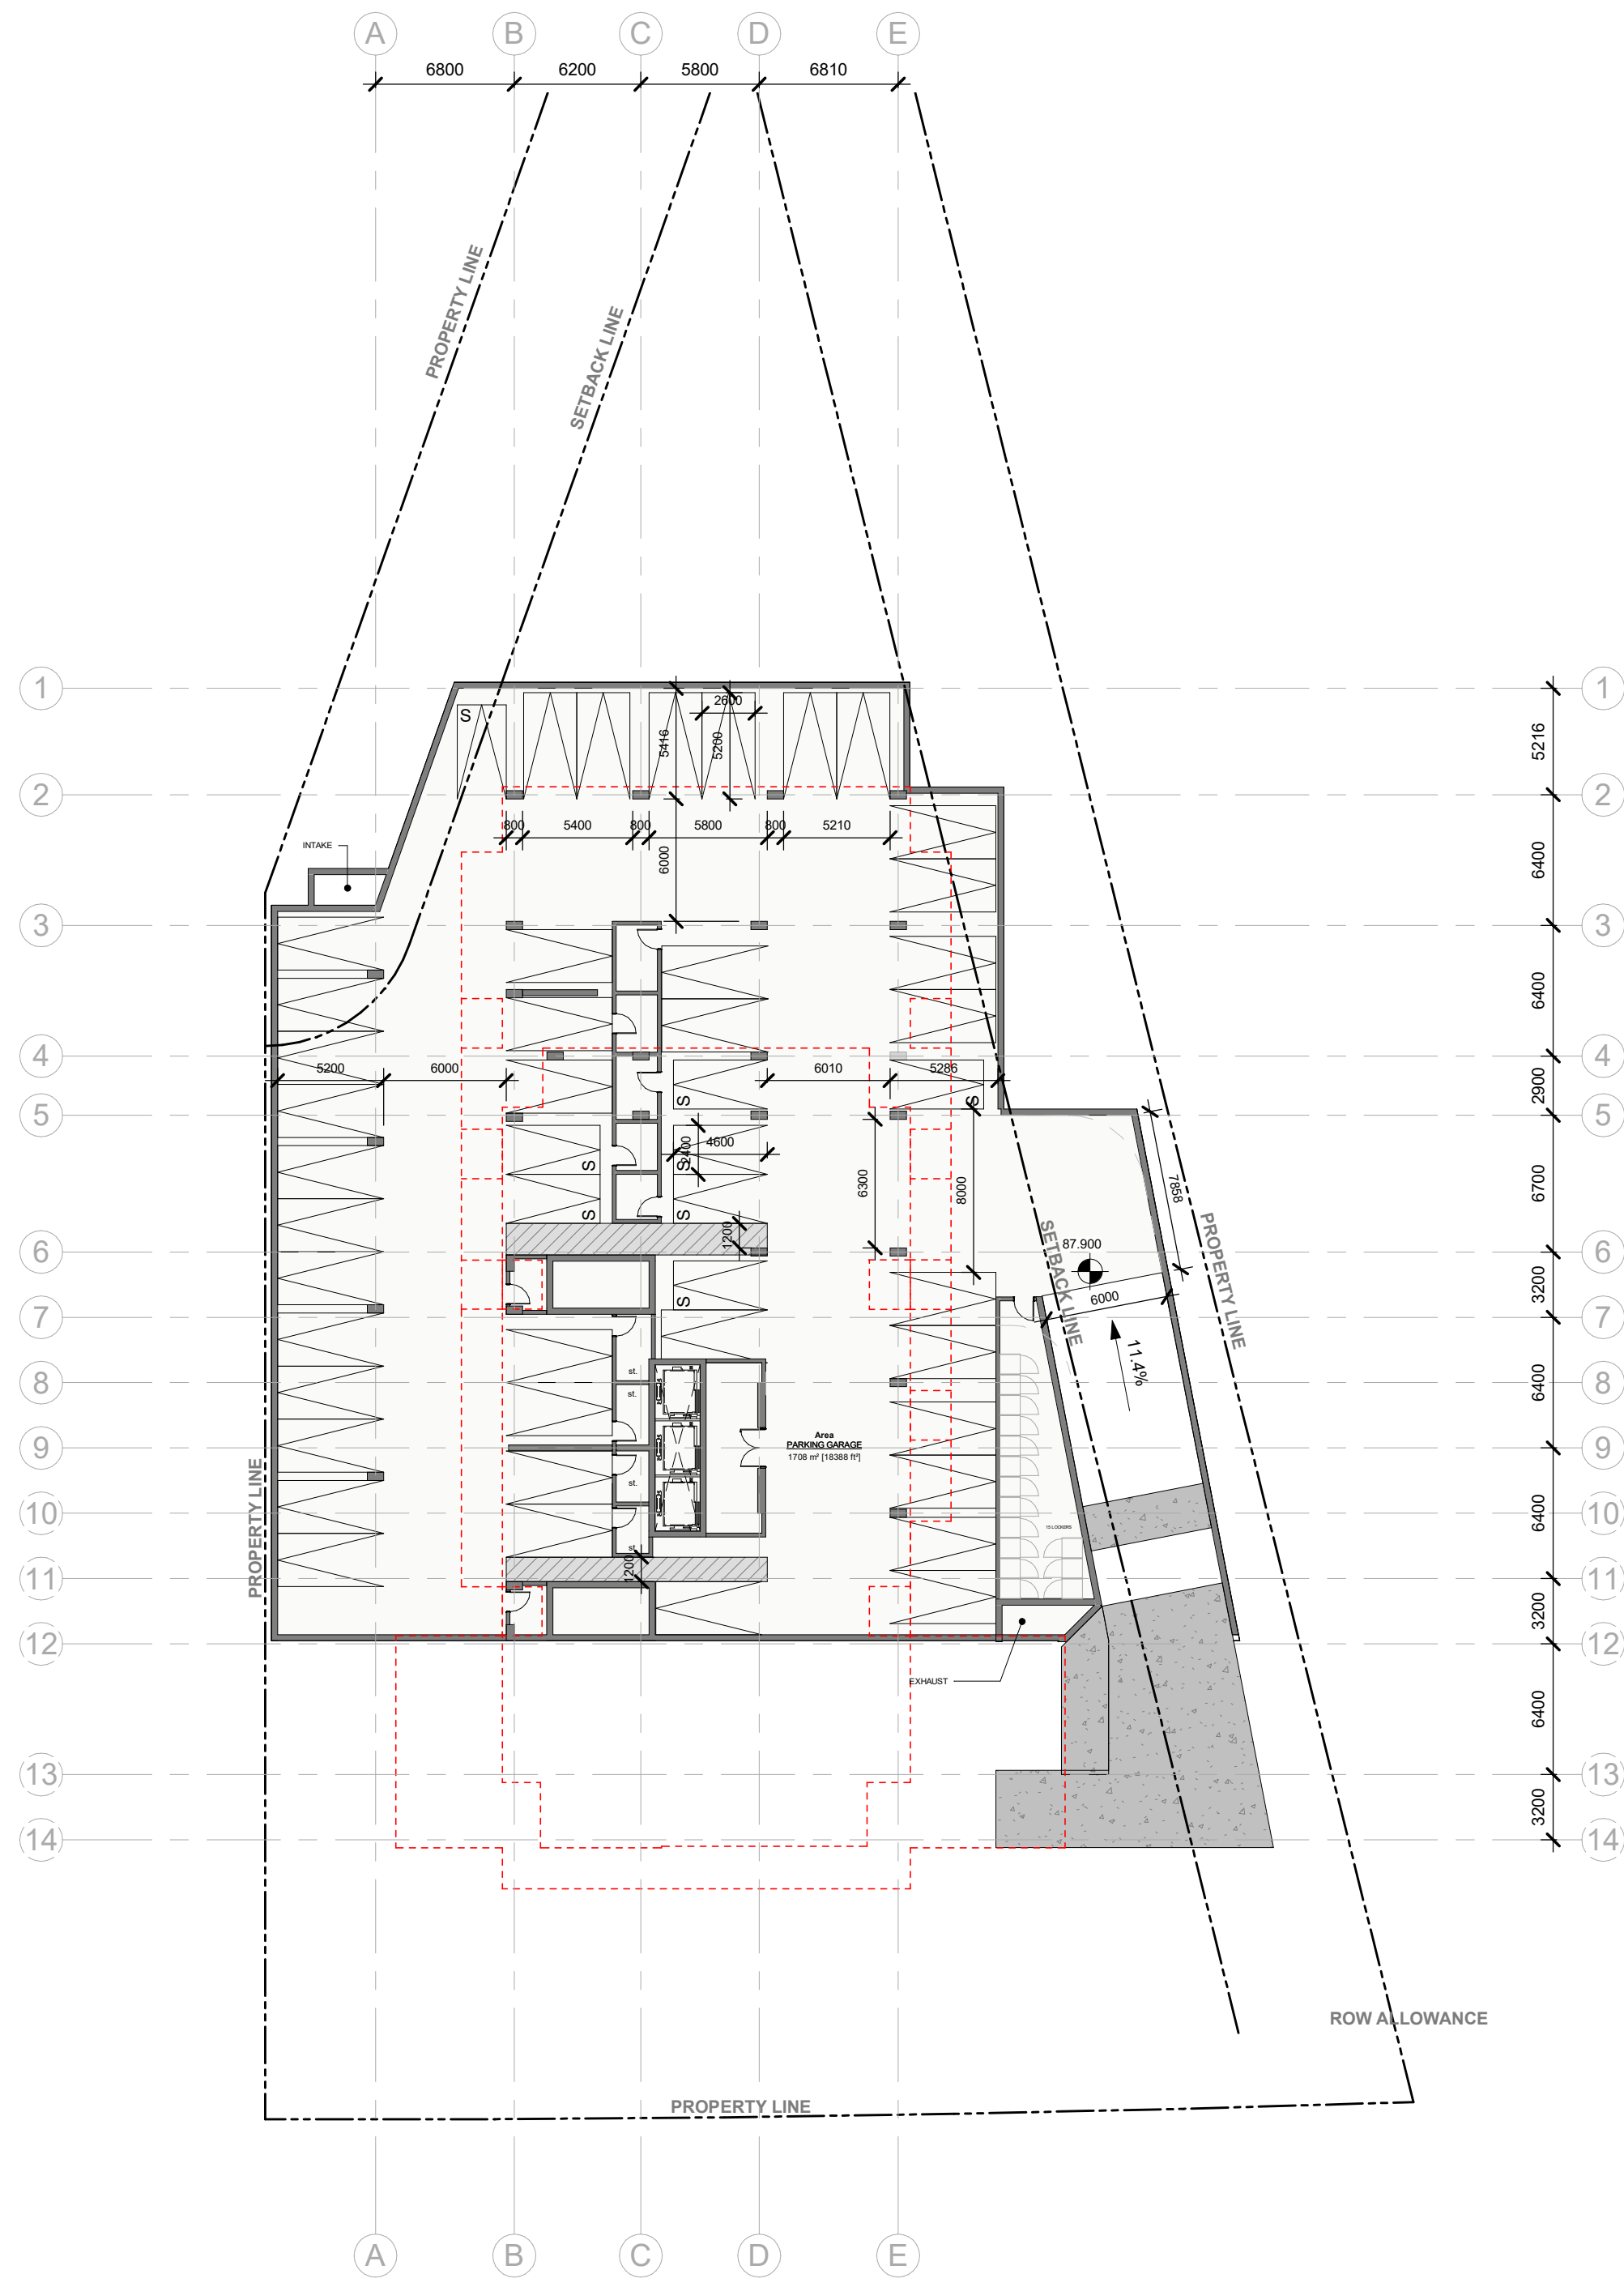

P3 FLOOR PLAN

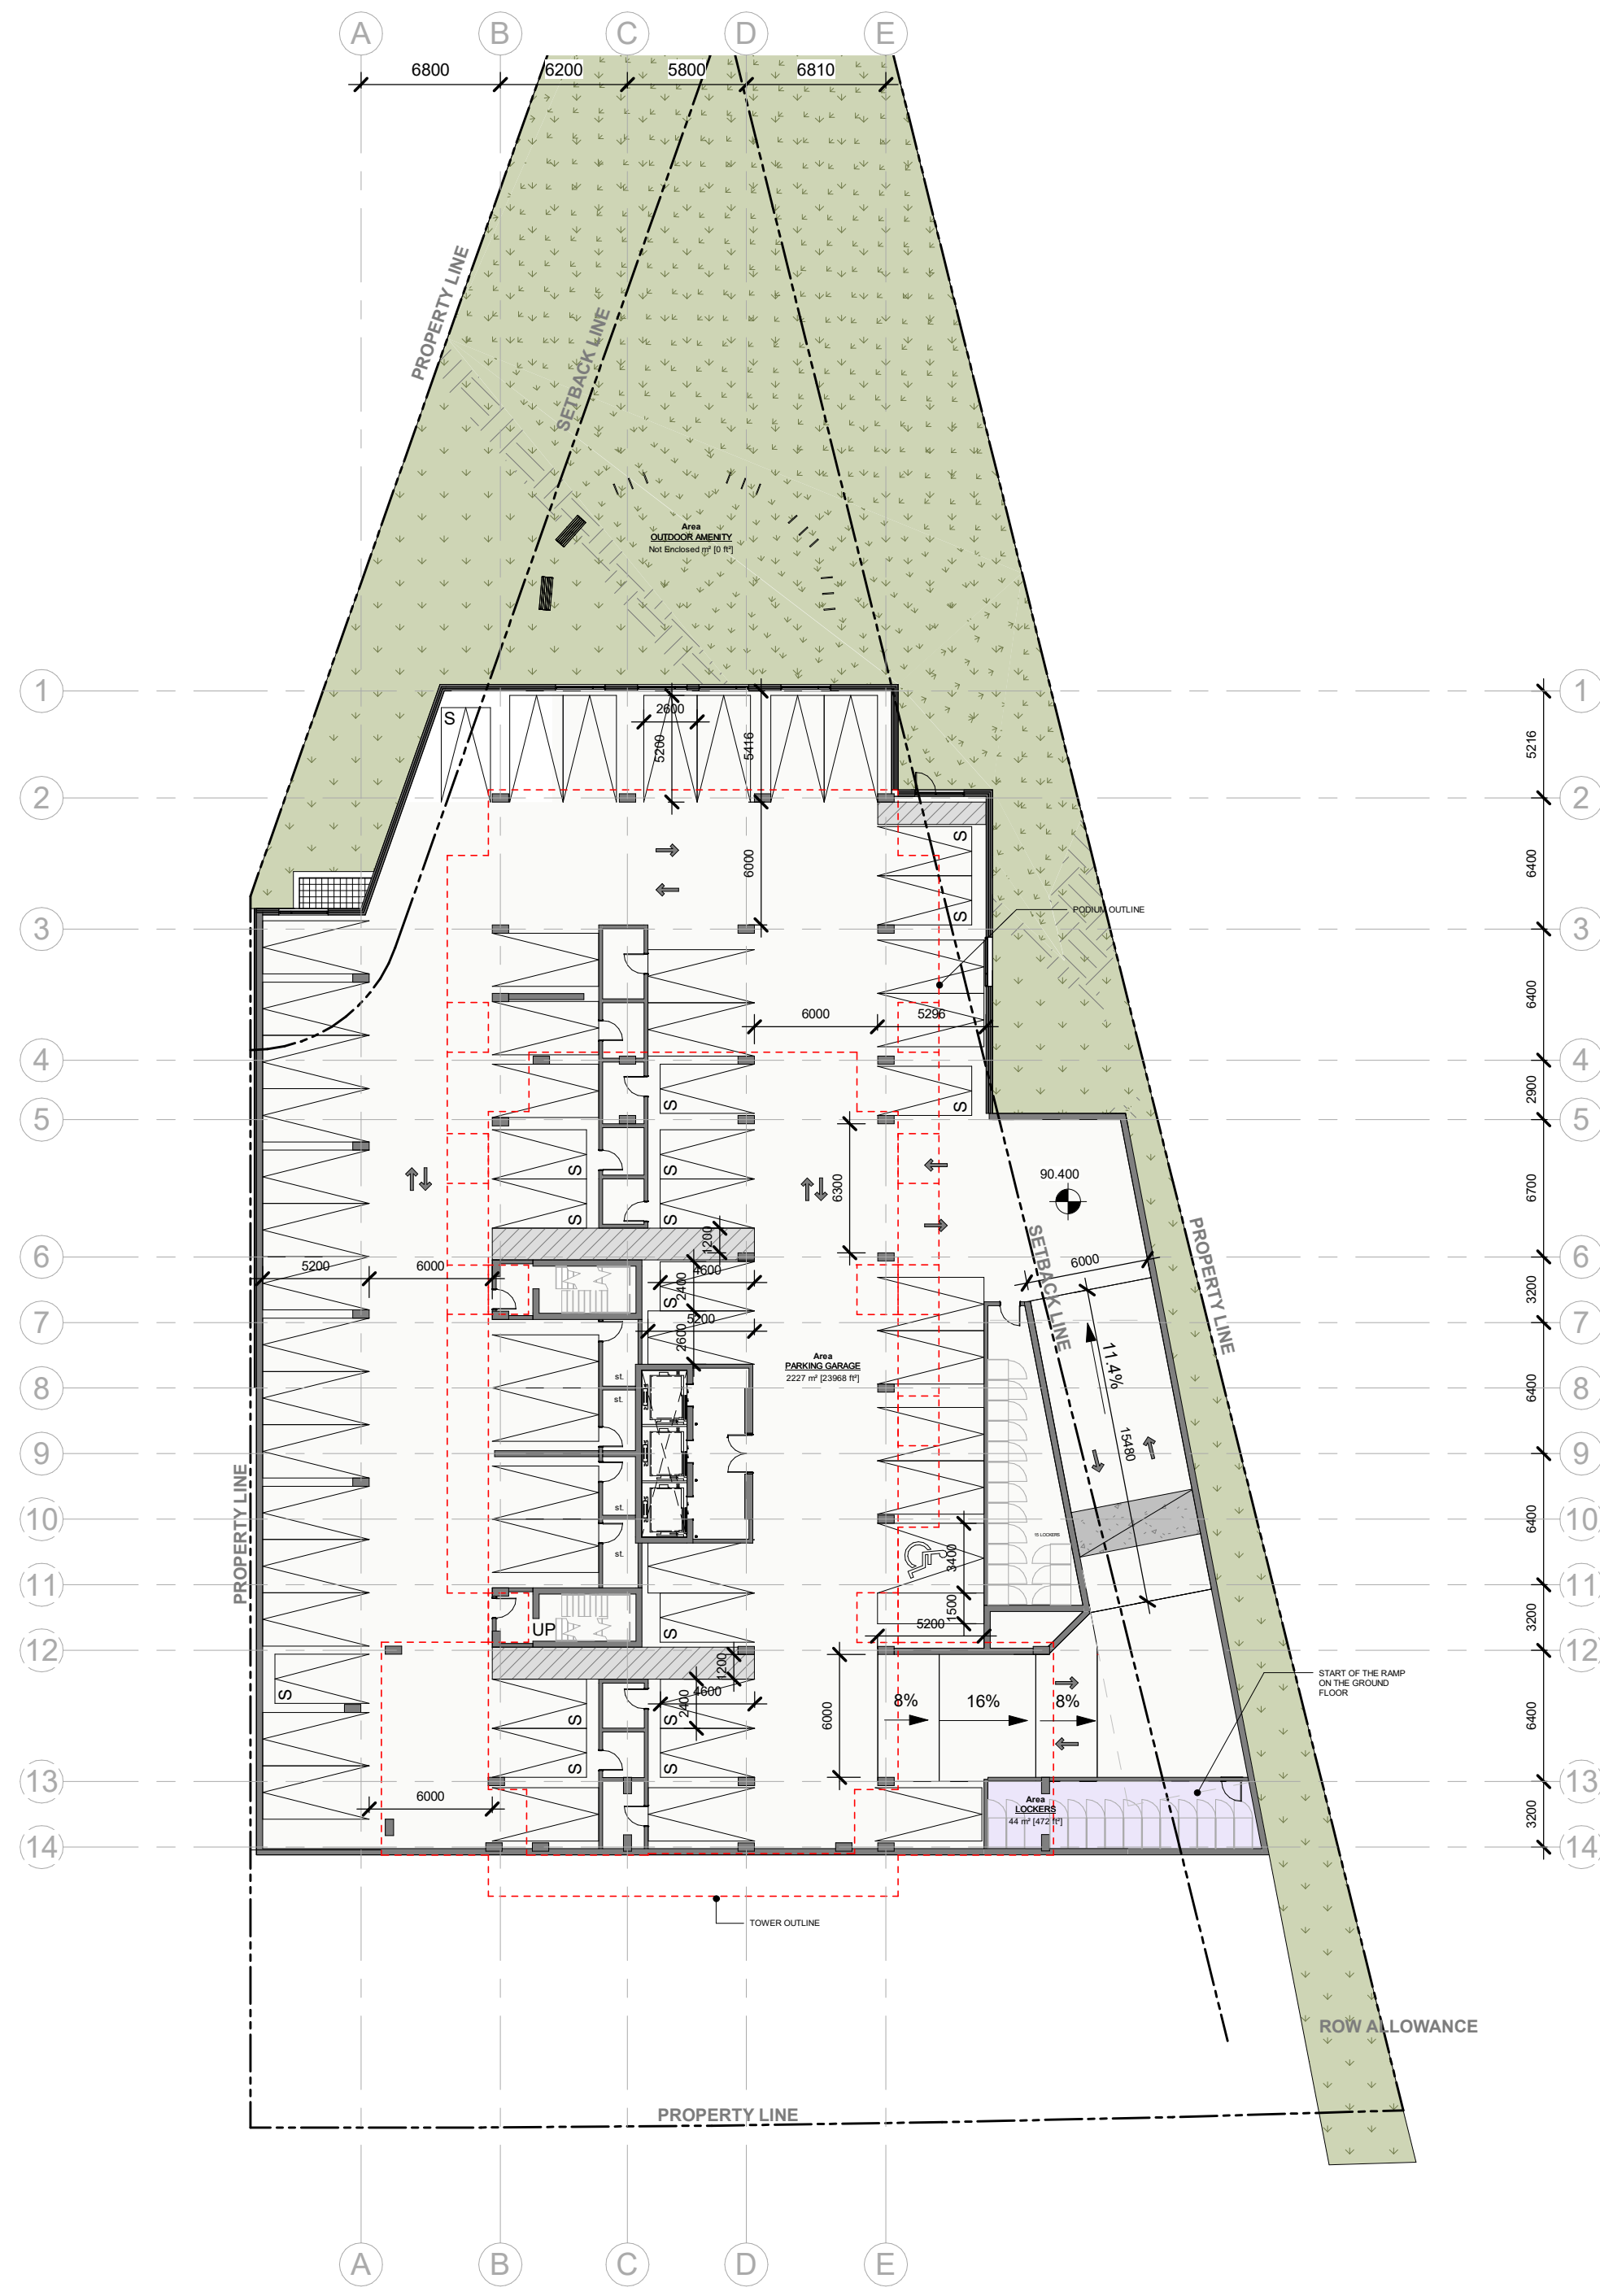

P2 FLOOR PLAN

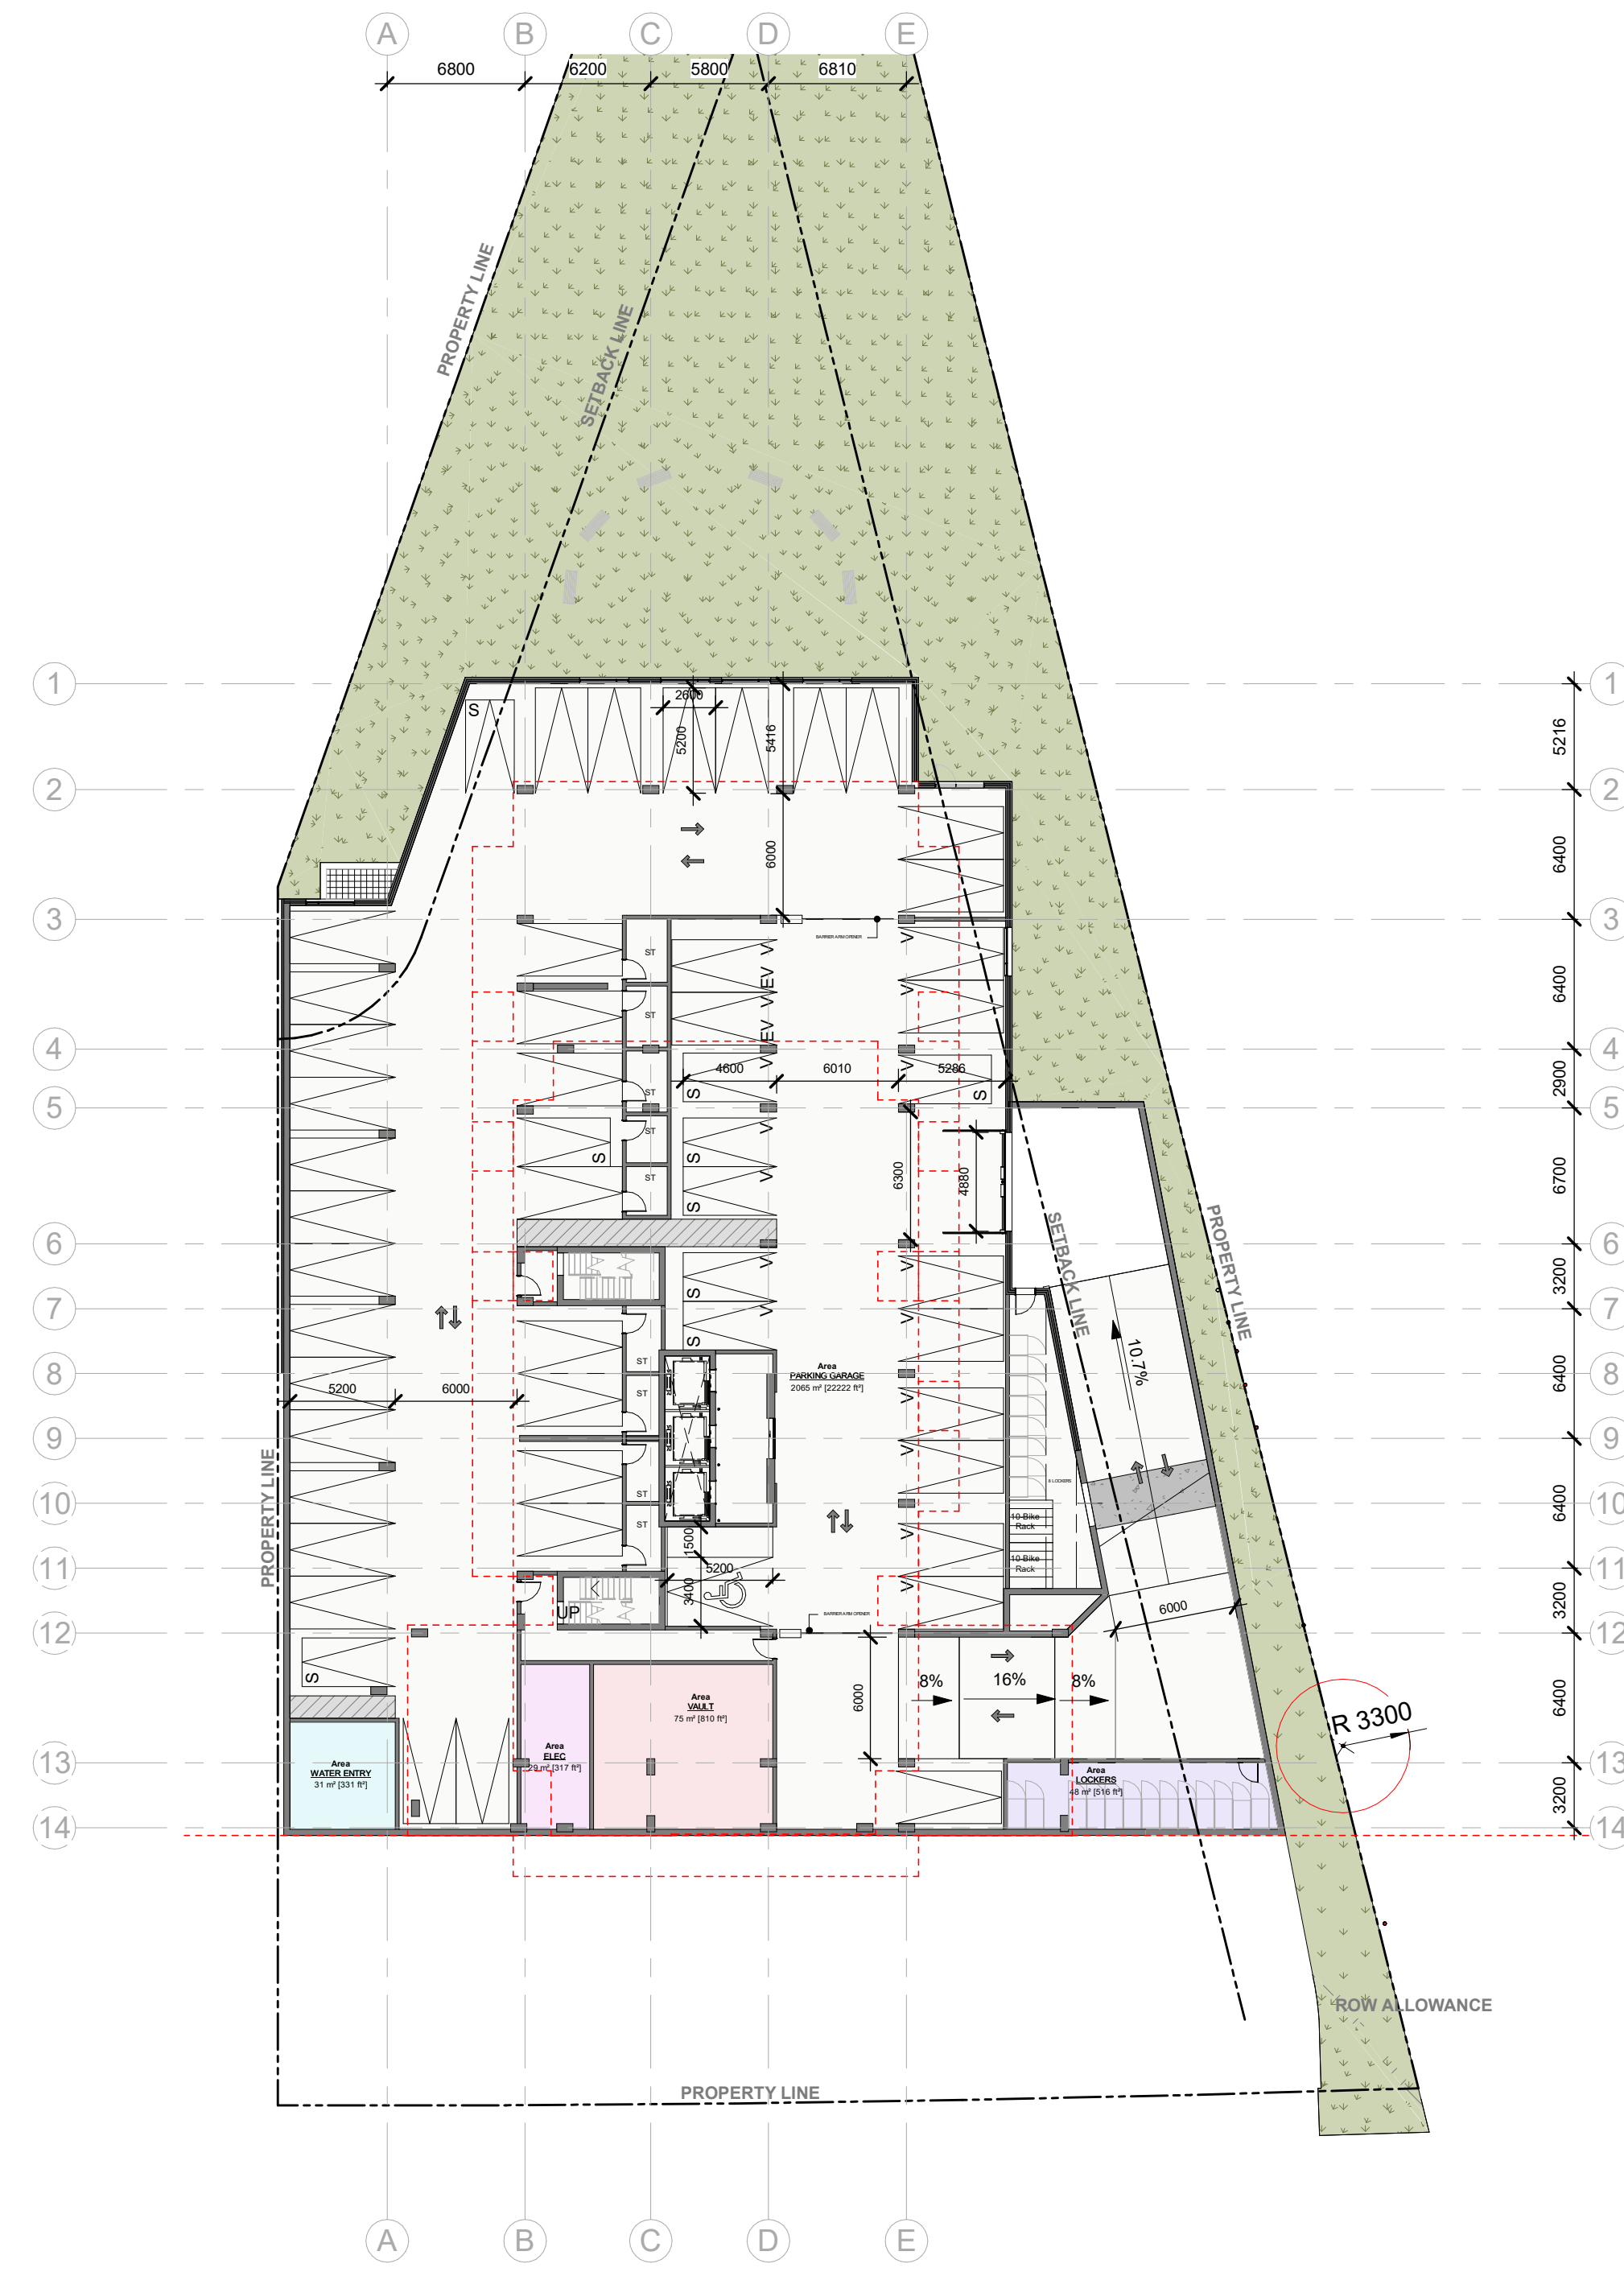

P1 FLOOR PLAN

IT IS THE RESPONSIBILITY OF THE APPROPRIATE CONTRACTOR TO CHECK AND VERIFY ALL DIMENSIONS ON SITE AND TO REPORT ALL ERRORS AND/OR OMISSIONS TO THE ARCHITECT.

ALL CONTRACTORS MUST COMPLY WITH ALL PERTINENT CODES AND BY-LAWS.

THIS DRAWING MAY NOT BE USED FOR CONSTRUCTION UNTIL SIGNED BY THE ARCHITECT.

DO NOT SCALE DRAWINGS.

COPYRIGHT RESERVED.

WITHOUT PREJUDICE

SPC 01 ISSUED FOR ZBLA APPLICATION		2024 12 13
No. DESCRIPTION		YYYY-MM-DD
REVISIONS:		
ARCHITECT SEAL:	NORTH ARROW:	
CLIENT:		
ARCHITECT:		
PROJECT TITLE:		
1815 MONTREAL RD		
OTTAWA ON		
SHEET TITLE:		
FLOOR PLANS		
DRAWN:	CHECKED:	
Author	Checker	
SCALE:	SHEET No:	
1 : 300		
PROJECT No:	A-101	
2405		


PLOT DATE: 2025-05-01 11:23:28 AM



GROUND FLOOR PLAN



LEVEL 2-3 FLOOR PLAN

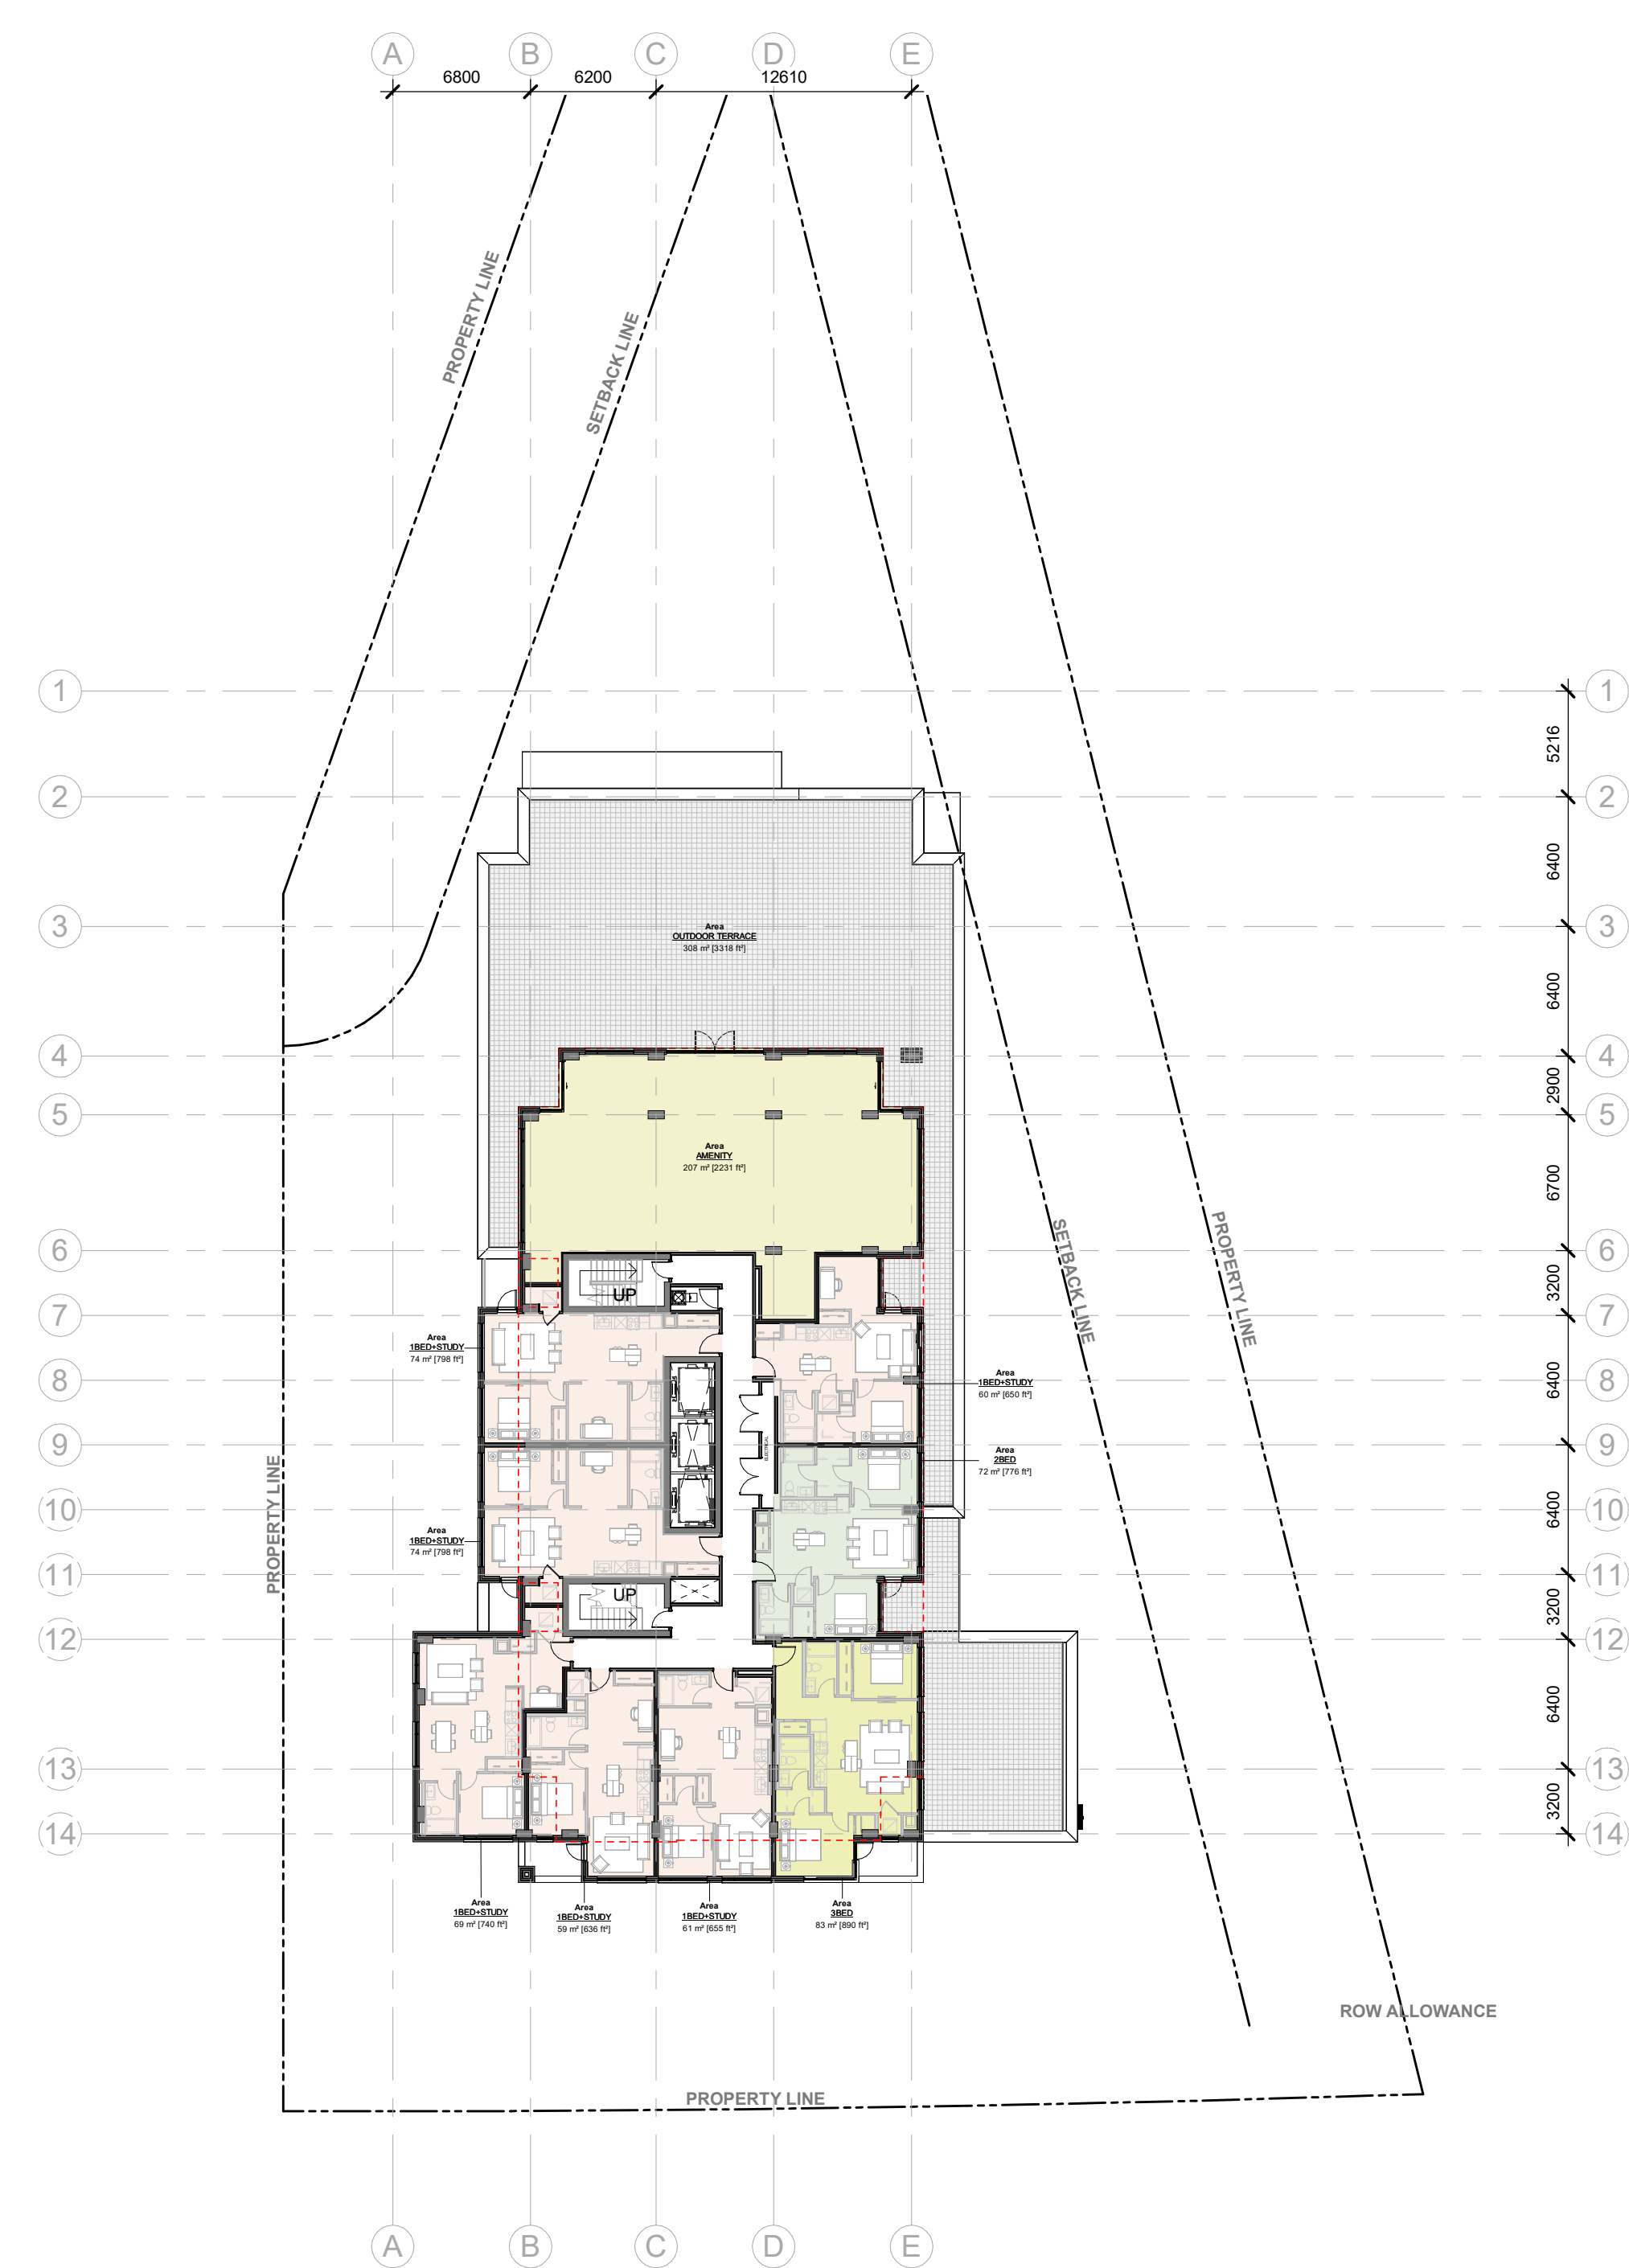

LEVEL 4 FLOOR PLAN

IT IS THE RESPONSIBILITY OF THE APPROPRIATE CONTRACTOR TO CHECK AND VERIFY ALL DIMENSIONS ON SITE AND TO REPORT ALL ERRORS AND/OR OMISSIONS TO THE ARCHITECT.

ALL CONTRACTORS MUST COMPLY WITH ALL PERTINENT CODES AND BY-LAWS.

THIS DRAWING MAY NOT BE USED FOR CONSTRUCTION UNTIL SIGNED BY THE ARCHITECT.


DO NOT SCALE DRAWINGS.

COPYRIGHT RESERVED.

WITHOUT PREJUDICE

SPC 01 ISSUED FOR ZBLA APPLICATION		2024 12 13
No. DESCRIPTION		YYYY-MM-DD
REVISIONS:		
ARCHITECT SEAL:	NORTH ARROW:	
CLIENT:		
ARCHITECT:		
PROJECT TITLE:		
1815 MONTREAL RD		
OTTAWA ON		
SHEET TITLE:		
FLOOR PLANS		
DRAWN:	CHECKED:	A-102
Author	Checker	
SCALE:	SHEET No:	
1 : 300		
PROJECT No:		
2405		


PLOT DATE: 10/30/2025 3:10:10 PM

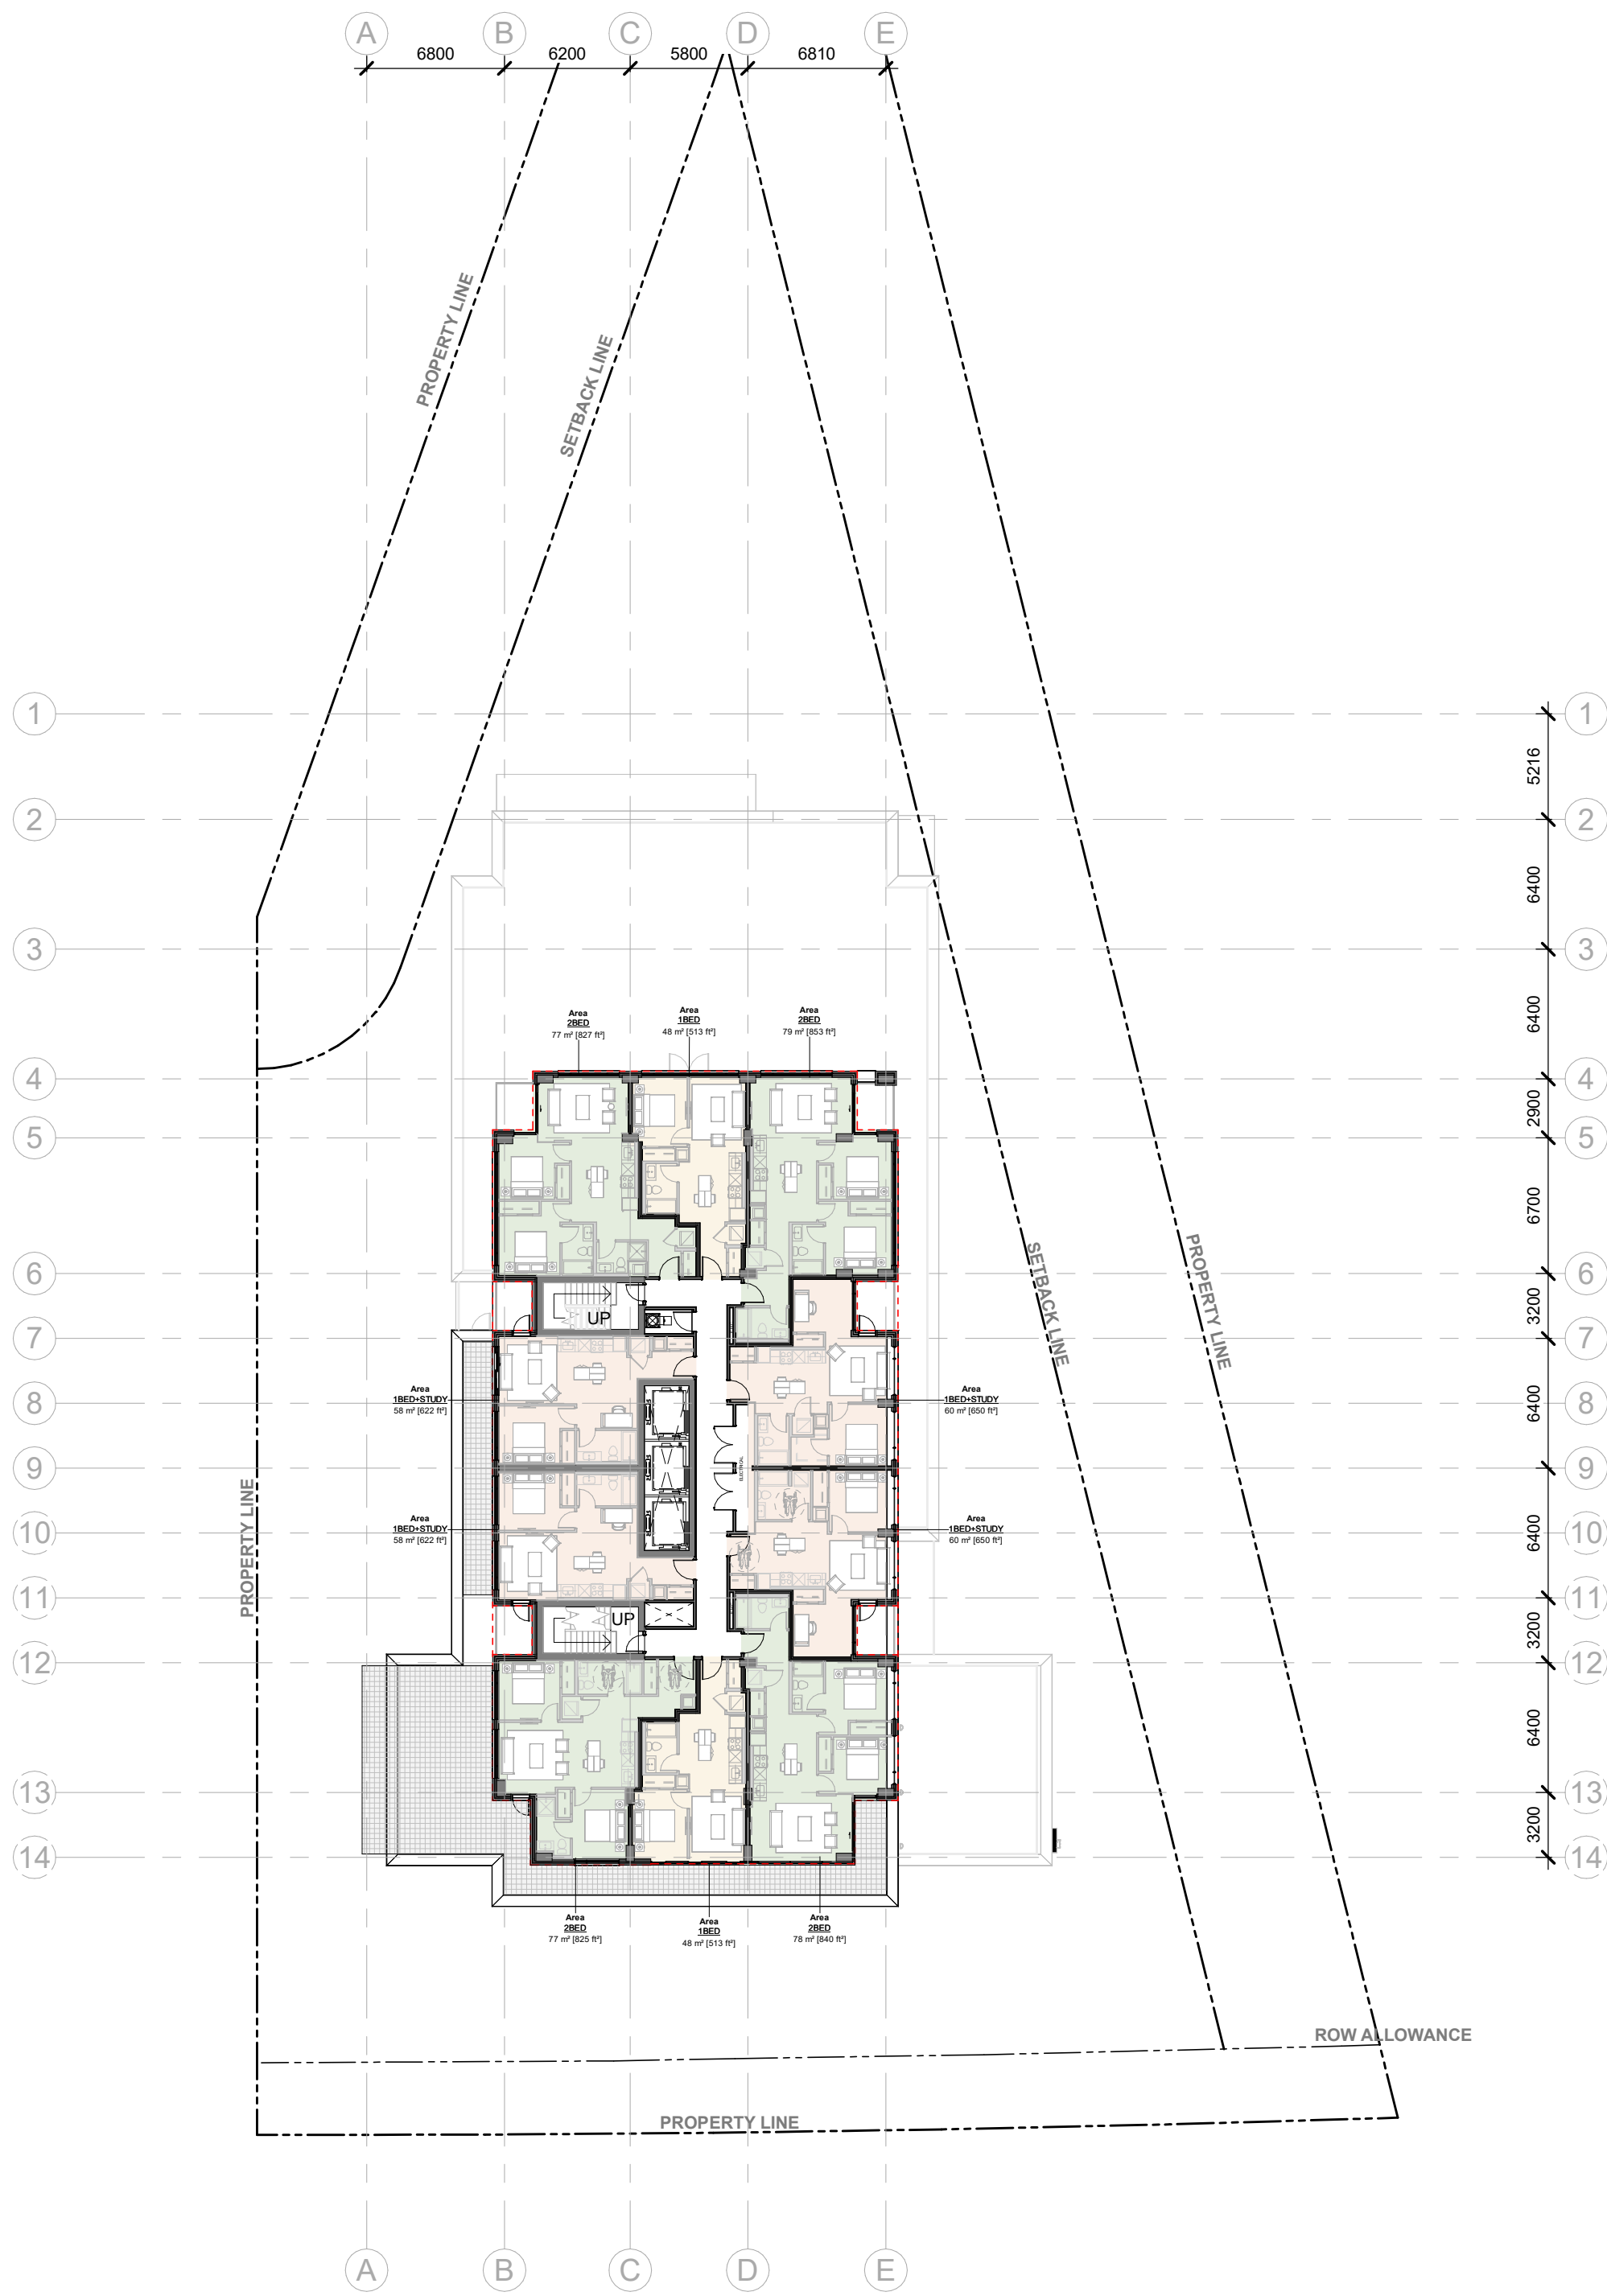

LEVEL 5 FLOOR PLAN



LEVEL 6-16 FLOOR PLAN

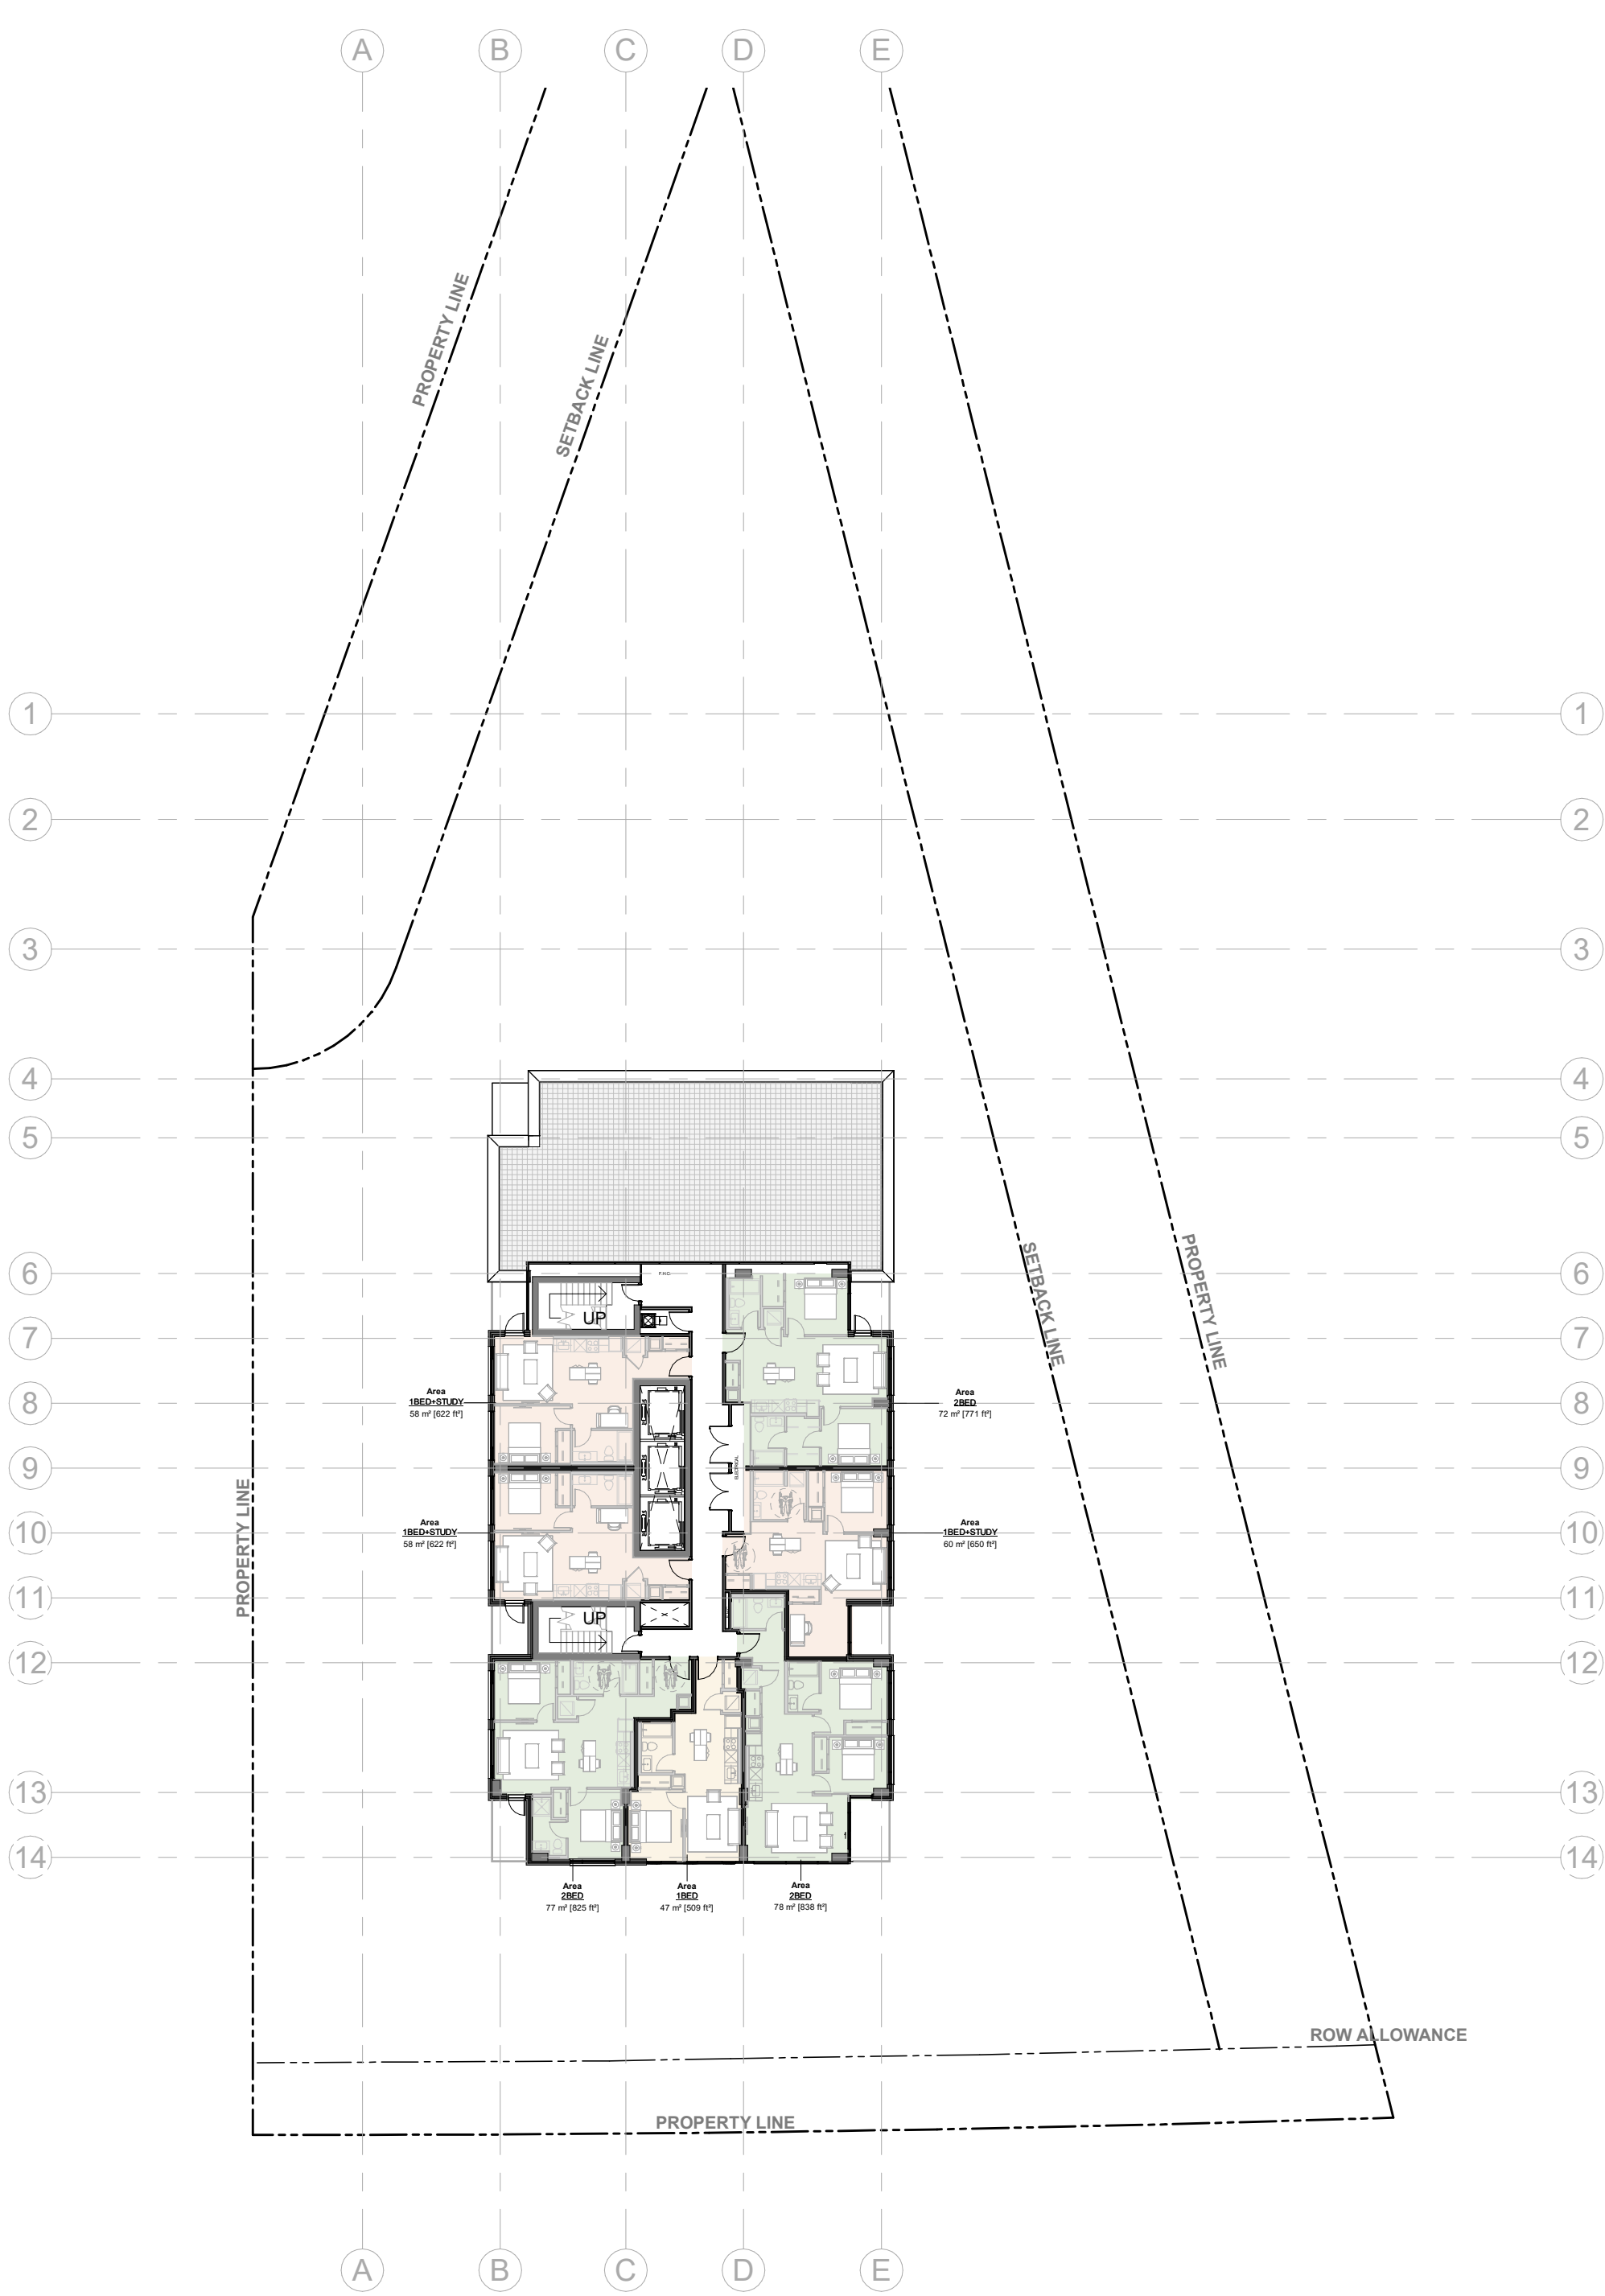

LEVEL 17 FLOOR PLAN

IT IS THE RESPONSIBILITY OF THE APPROPRIATE CONTRACTOR TO CHECK AND VERIFY ALL DIMENSIONS ON SITE AND TO REPORT ALL ERRORS AND/OR OMISSIONS TO THE ARCHITECT.

ALL CONTRACTORS MUST COMPLY WITH ALL PERTINENT CODES AND BY-LAWS.

THIS DRAWING MAY NOT BE USED FOR CONSTRUCTION UNTIL SIGNED BY THE ARCHITECT.


DO NOT SCALE DRAWINGS.

COPYRIGHT RESERVED.

WITHOUT PREJUDICE

SPC 01 ISSUED FOR ZBLA APPLICATION		2024 12 13
No. DESCRIPTION		YYYY-MM-DD
REVISIONS:		
ARCHITECT SEAL:	NORTH ARROW:	
CLIENT:		
ARCHITECT:		
PROJECT TITLE:		
1815 MONTREAL RD		
OTTAWA ON		
SHEET TITLE:		
FLOOR PLANS		
DRAWN:	CHECKED:	A-103
Author	Checker	
SCALE:	SHEET No:	
1 : 300		
PROJECT No:		
2405		


PLOT DATE: 2025-05-01 11:23:58 AM

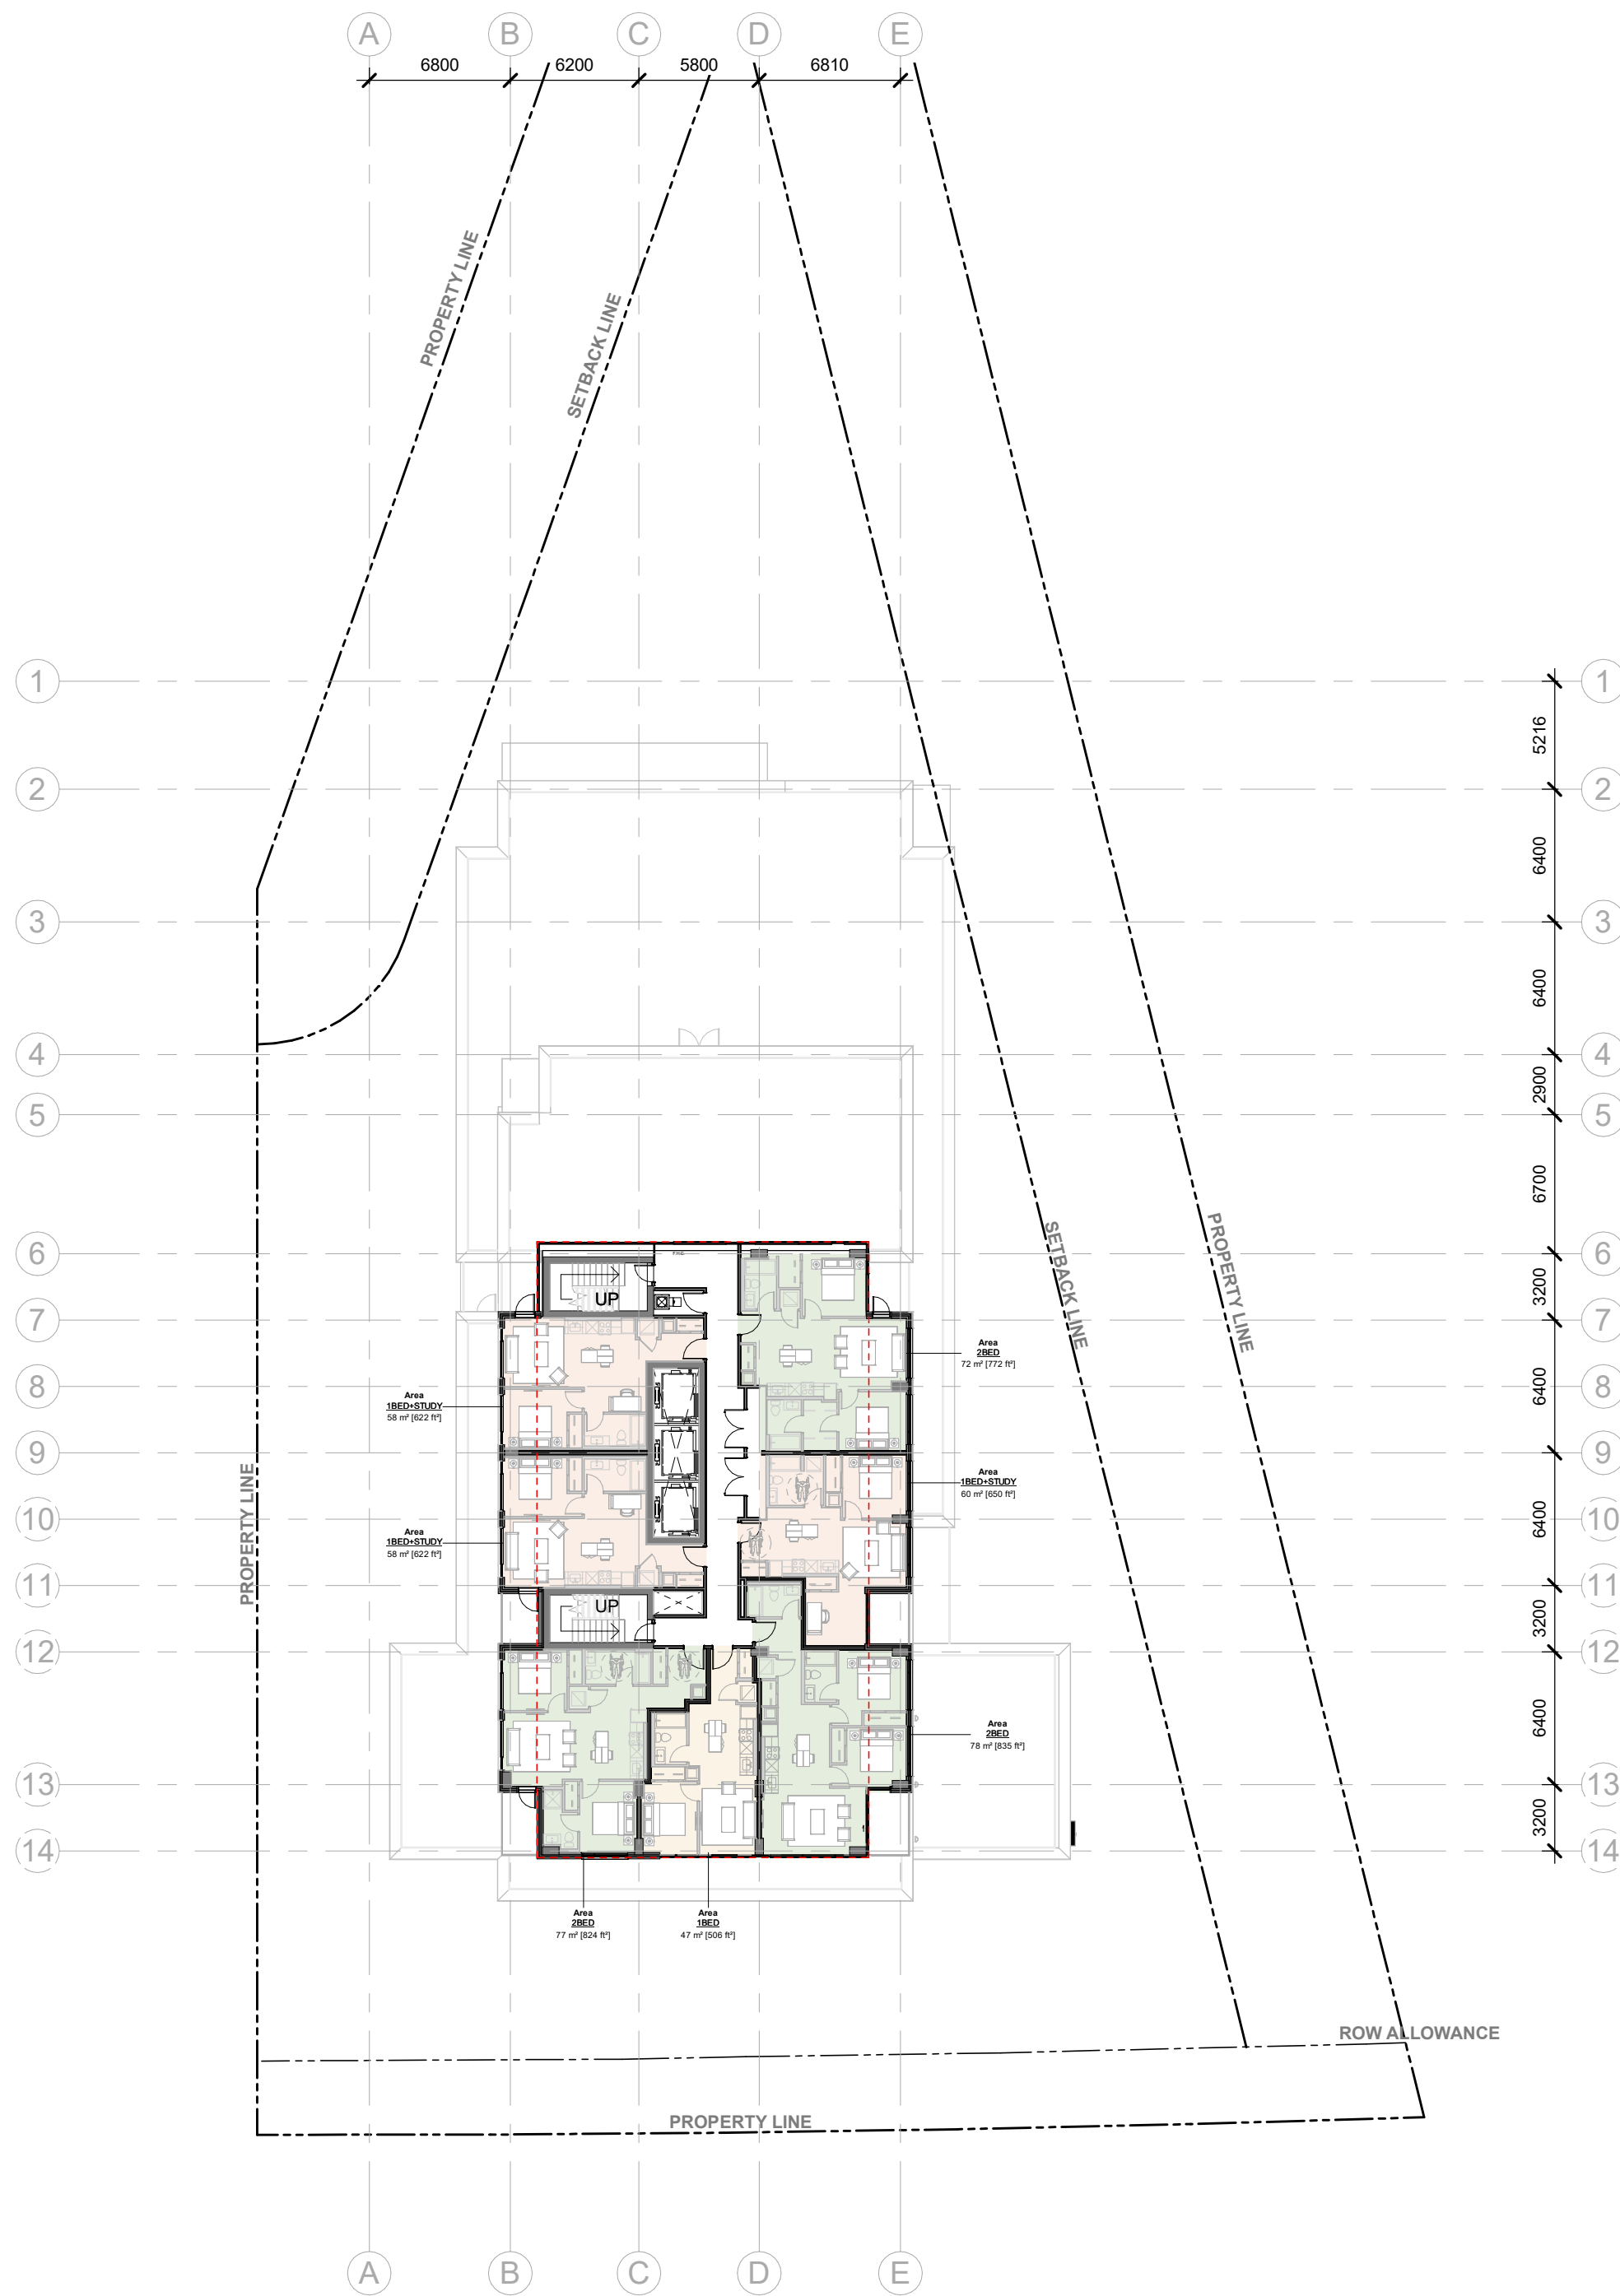

LEVEL 18 FLOOR PLAN



LEVEL 19 FLOOR PLAN

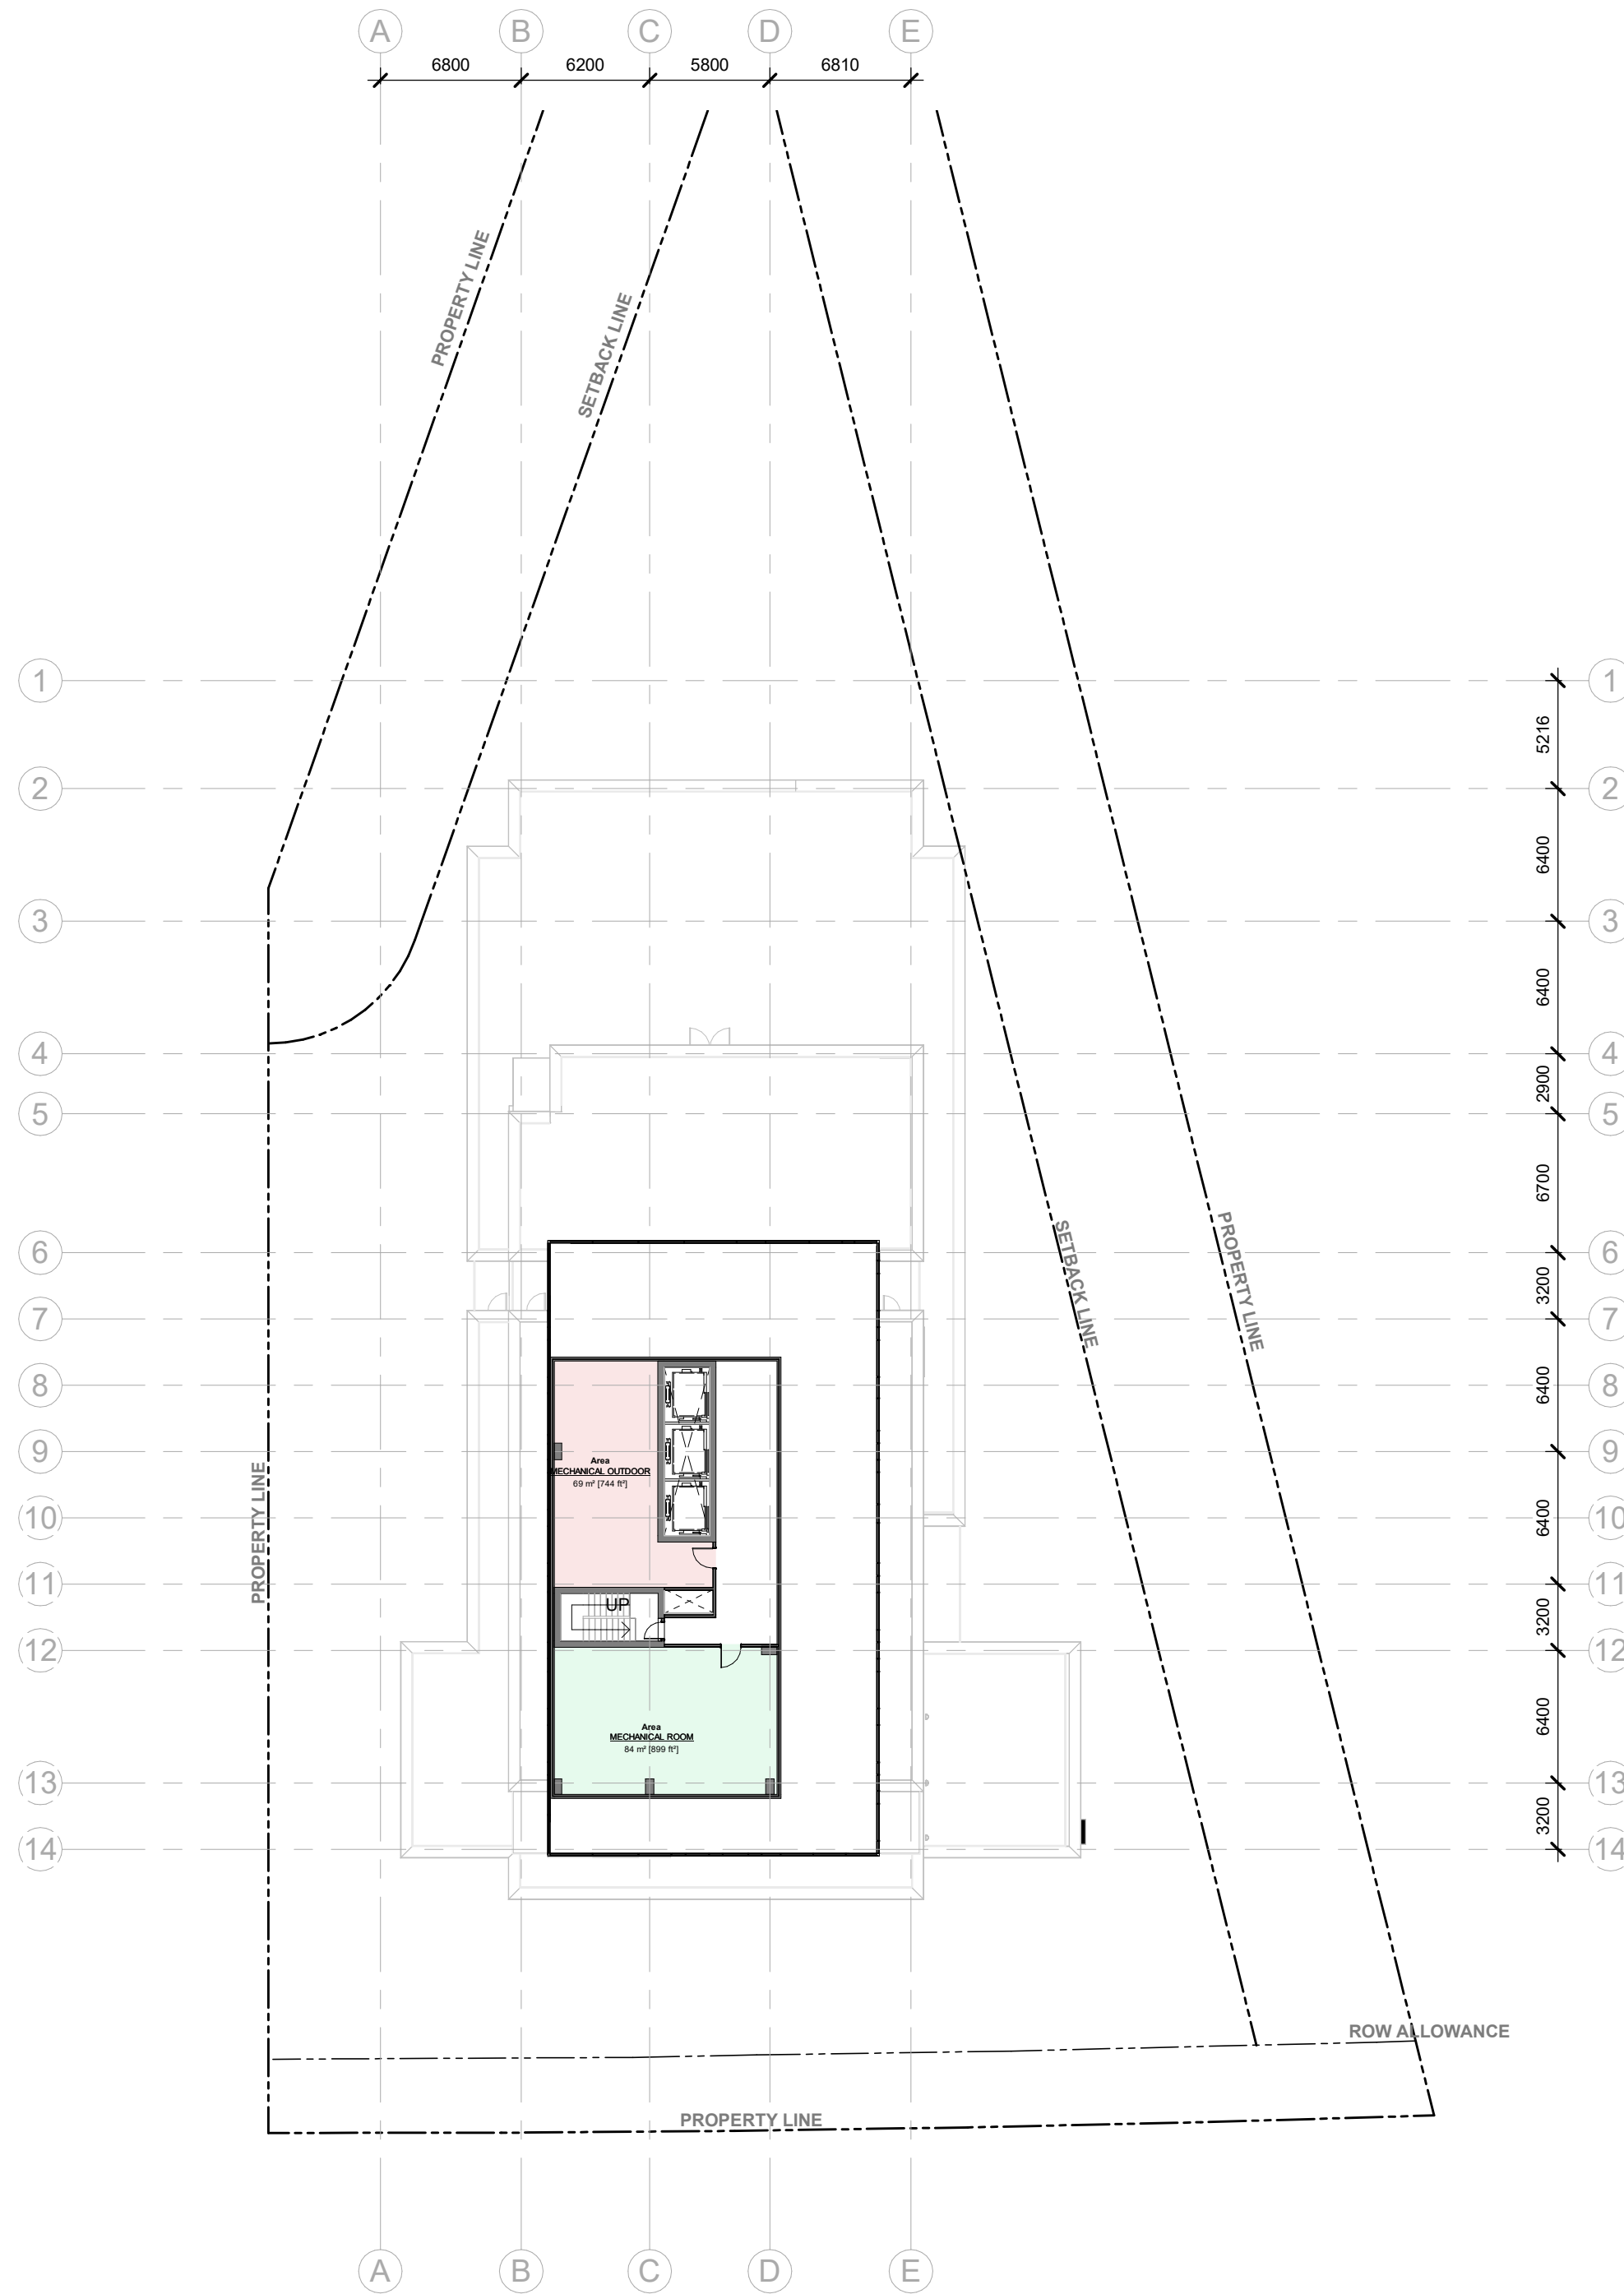

AMENITY / MECHANICAL FLOOR PLAN

IT IS THE RESPONSIBILITY OF THE APPROPRIATE CONTRACTOR TO CHECK AND VERIFY ALL DIMENSIONS ON SITE AND TO REPORT ALL ERRORS AND/OR OMISSIONS TO THE ARCHITECT.

ALL CONTRACTORS MUST COMPLY WITH ALL PERTINENT CODES AND BY-LAWS.

THIS DRAWING MAY NOT BE USED FOR CONSTRUCTION UNTIL SIGNED BY THE ARCHITECT.

DO NOT SCALE DRAWINGS.

COPYRIGHT RESERVED.

WITHOUT PREJUDICE













SPC 01 ISSUED FOR ZBLA APPLICATION		2024 12 13
No. DESCRIPTION		YYYY-MM-DD
REVISIONS:		
ARCHITECT SEAL:	NORTH ARROW:	
CLIENT:		
ARCHITECT:		
PROJECT TITLE:		
1815 MONTREAL RD		
OTTAWA ON		
SHEET TITLE:		
FLOOR PLANS		
DRAWN:	CHECKED:	
Author	Checker	
SCALE:	SHEET No:	
1 : 300		
PROJECT No:	A-104	
2405		

PAPER SIZE: ISO Full Based B1 (707.00 x 1000.00mm)
PLOT DATE: 2025-05-01 11:24:48 AM

WITHOUT PREJUDICE



PLOT DATE: 2025-05-01 11:25:32 AM

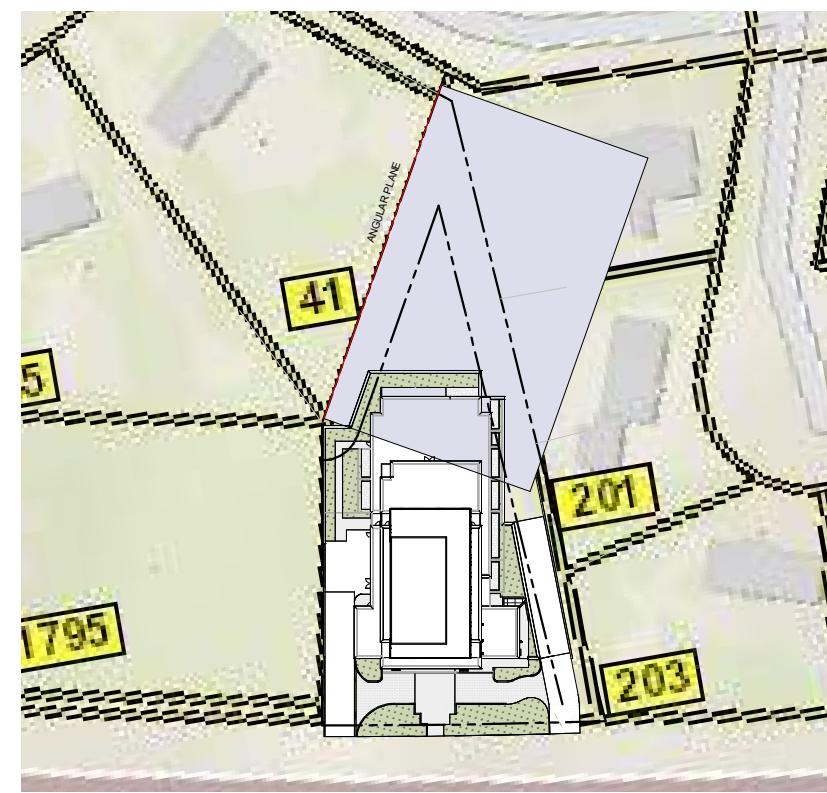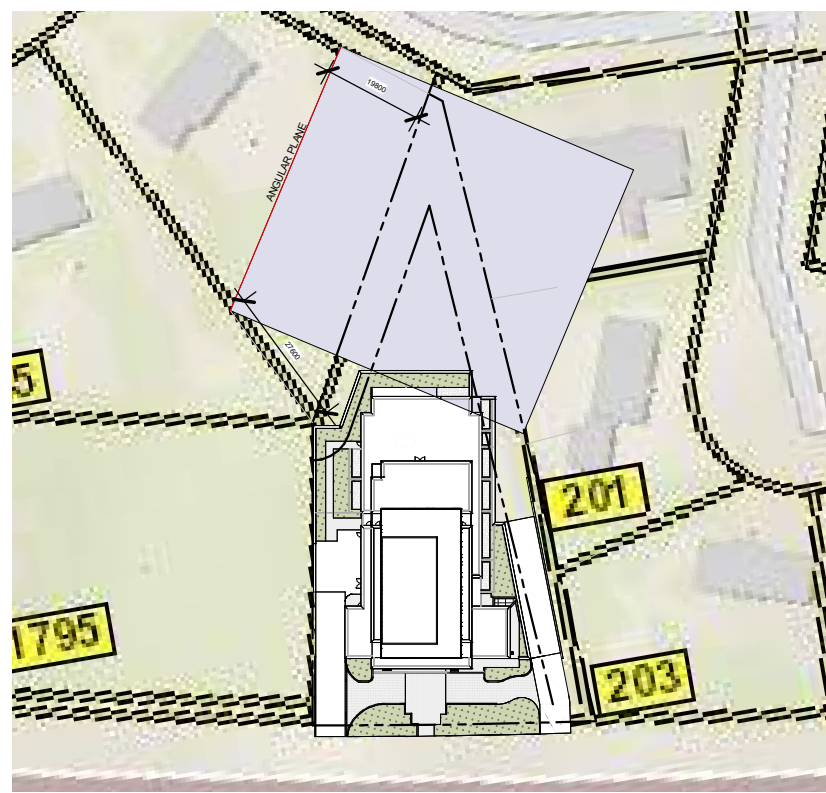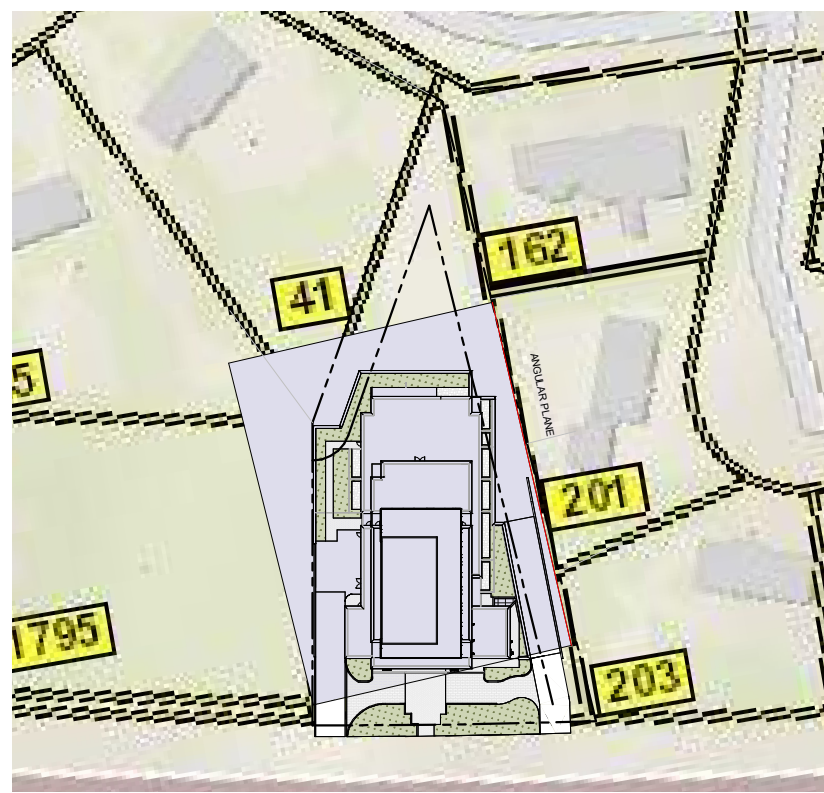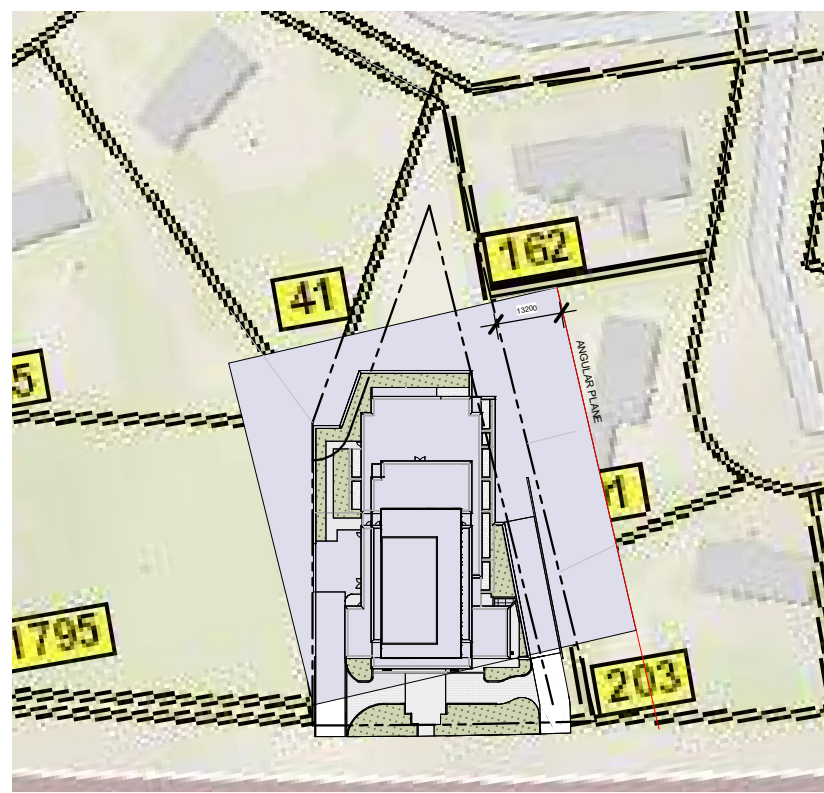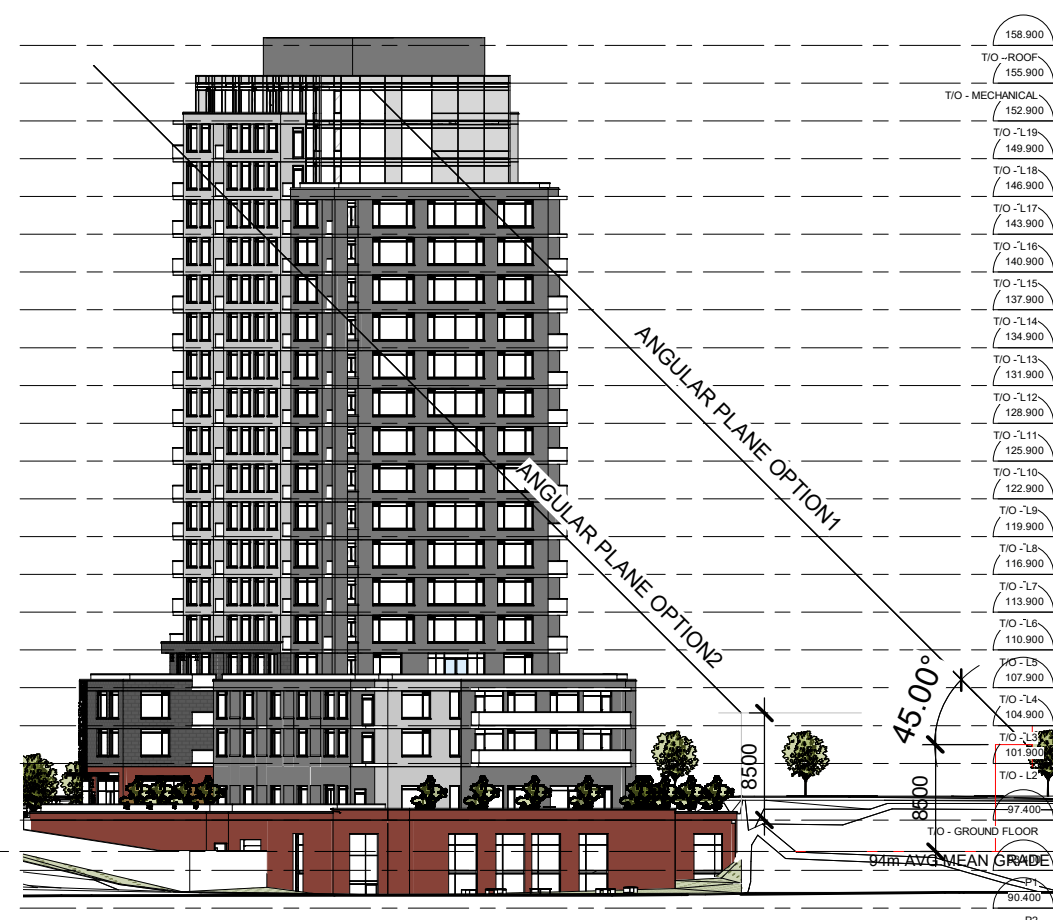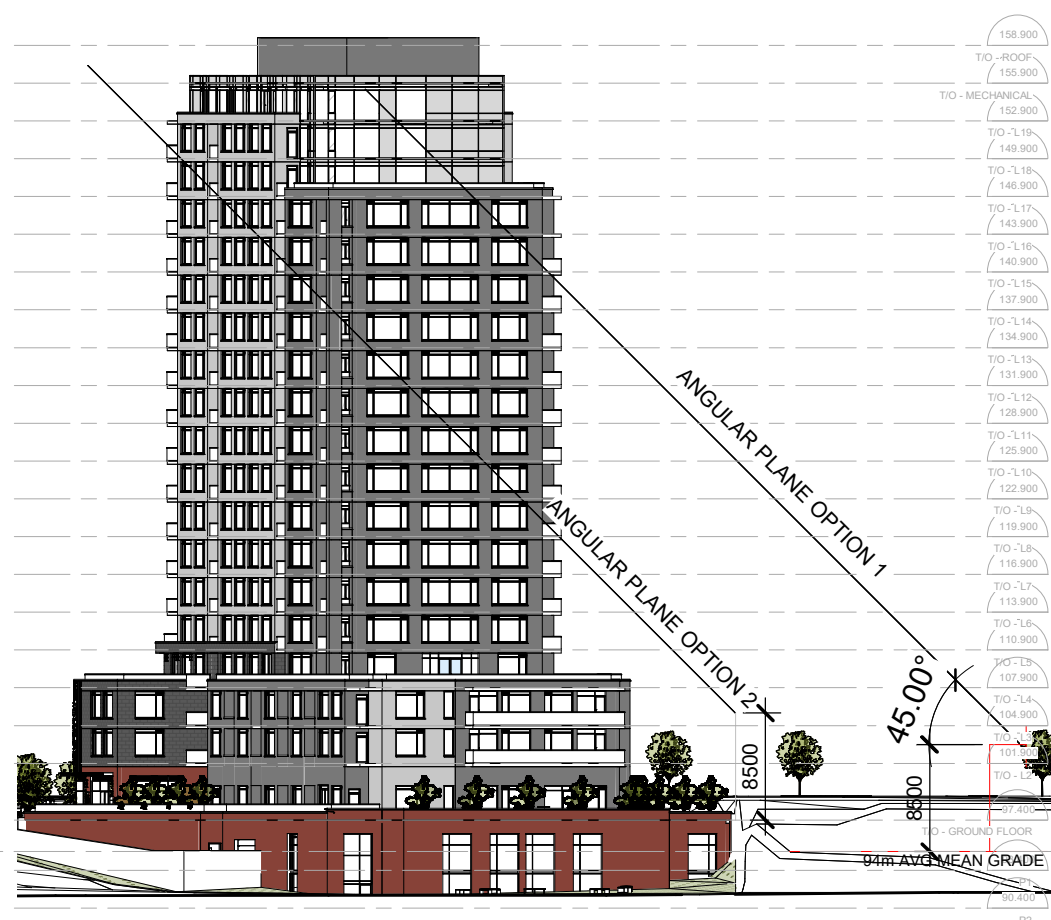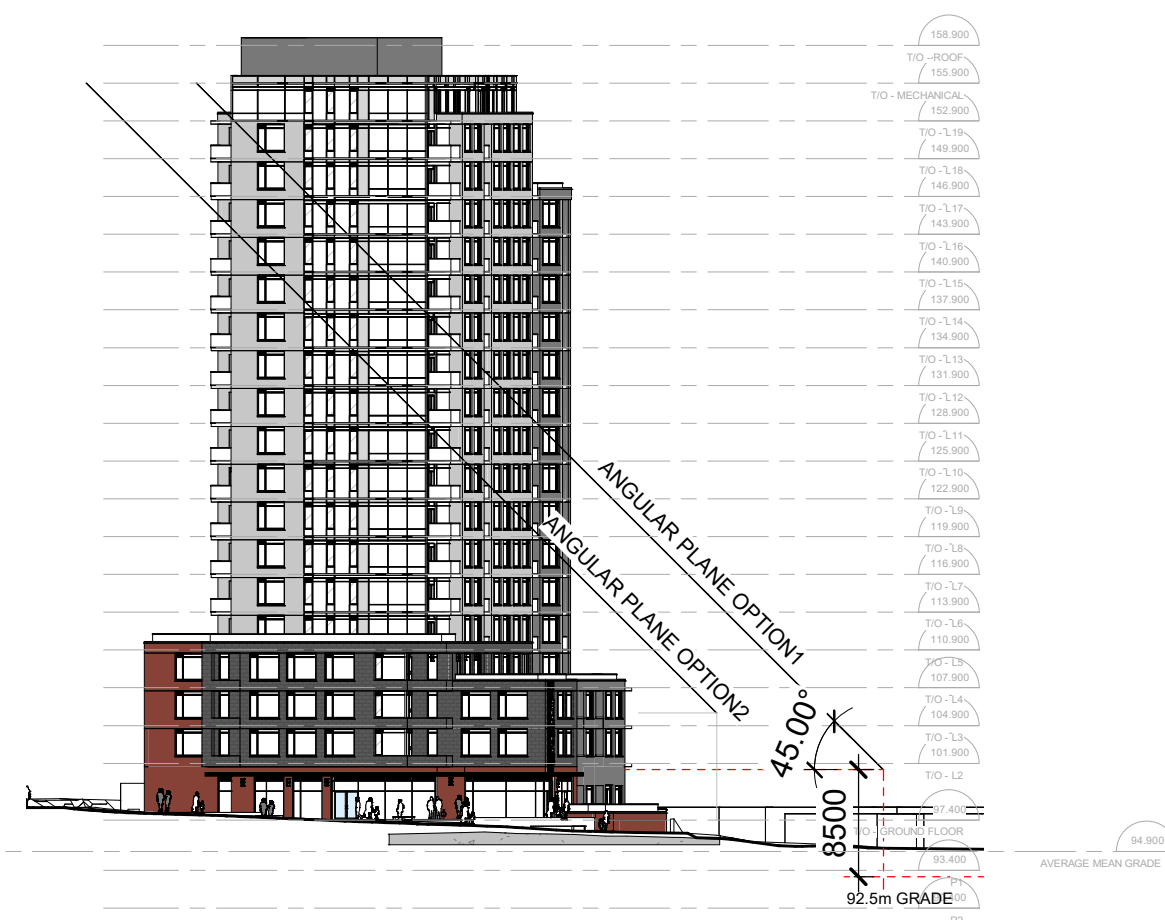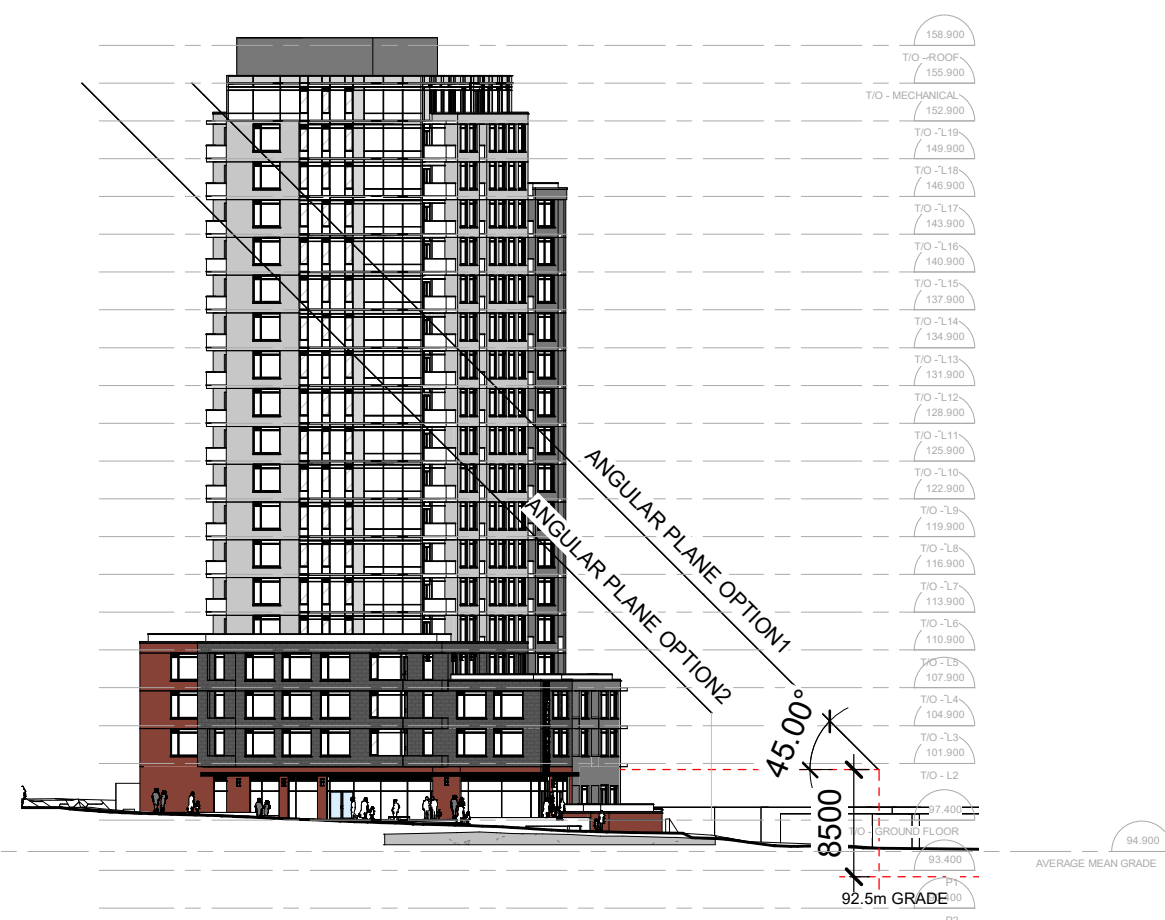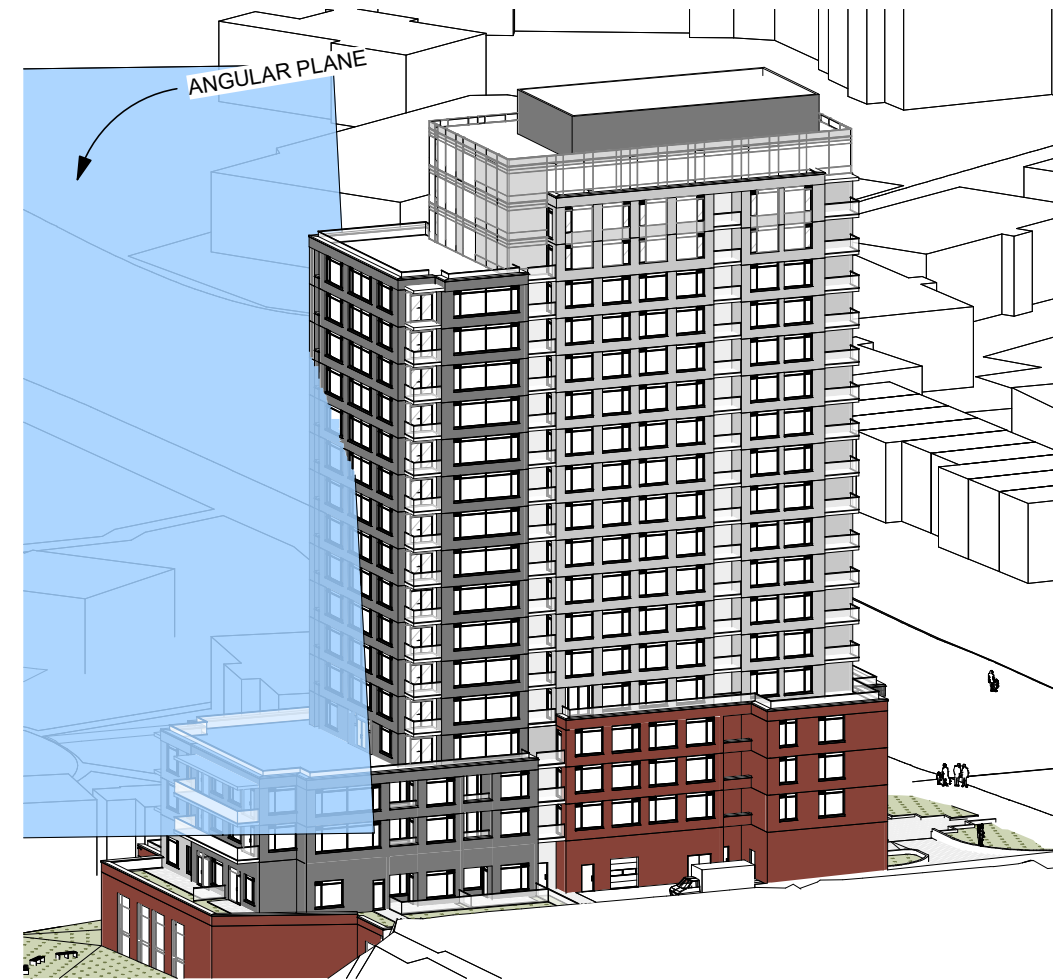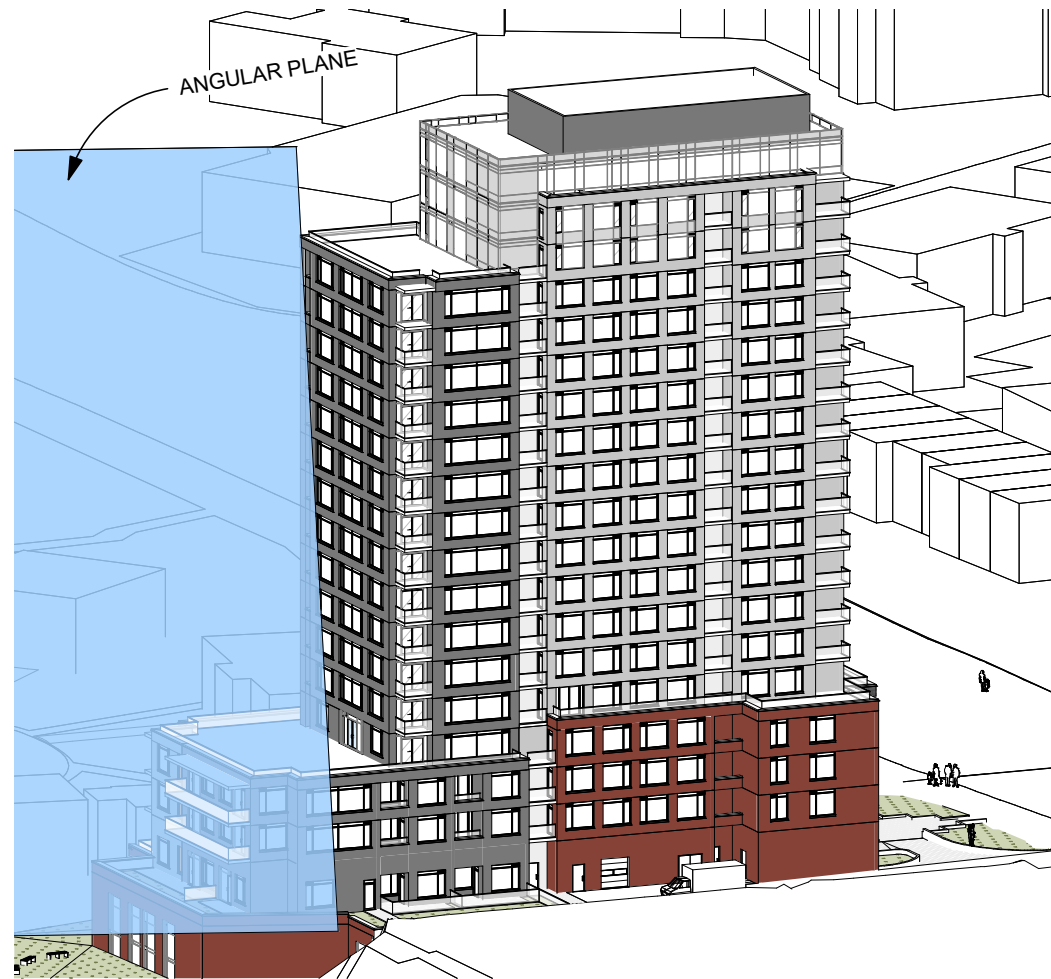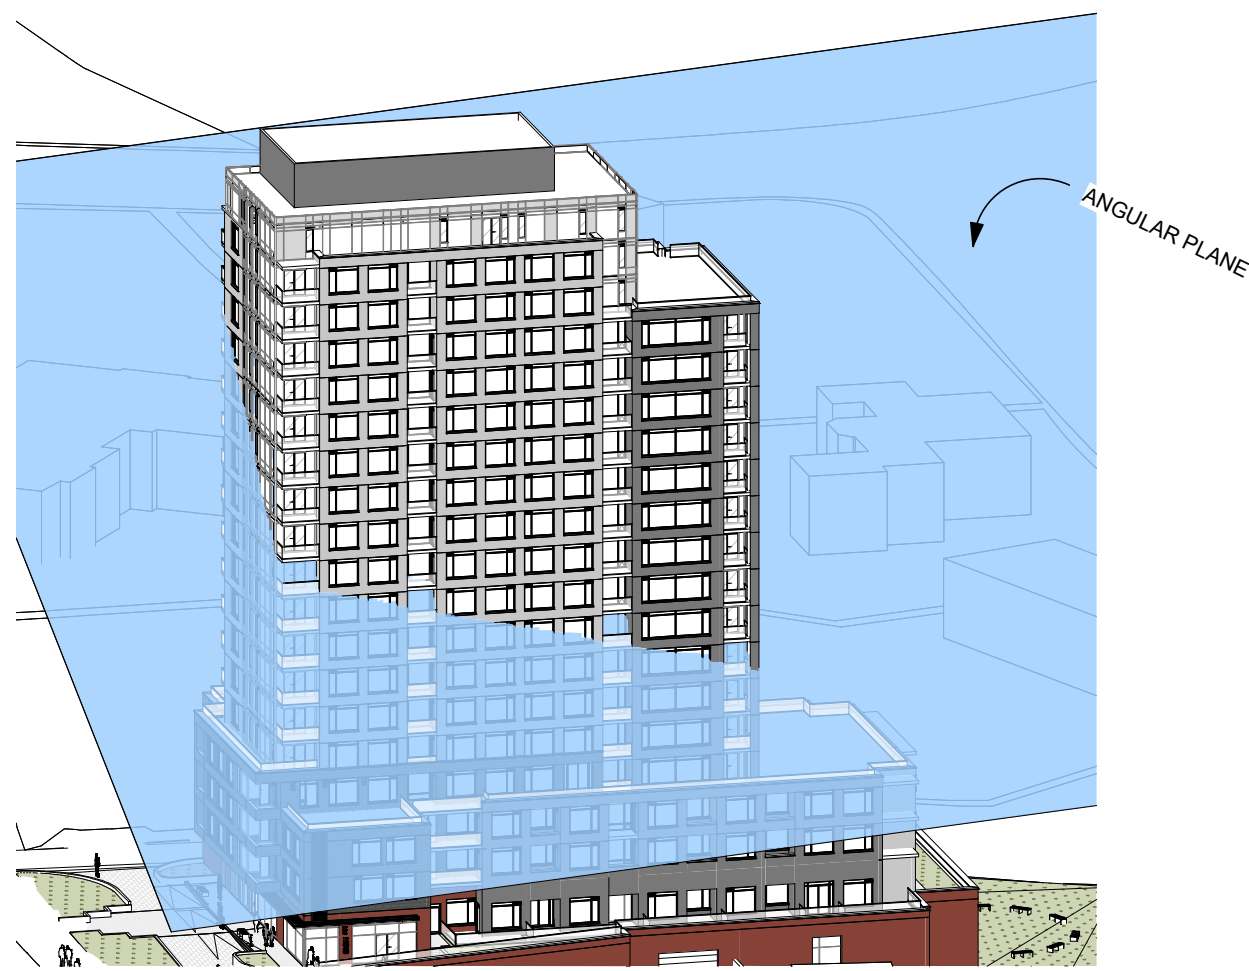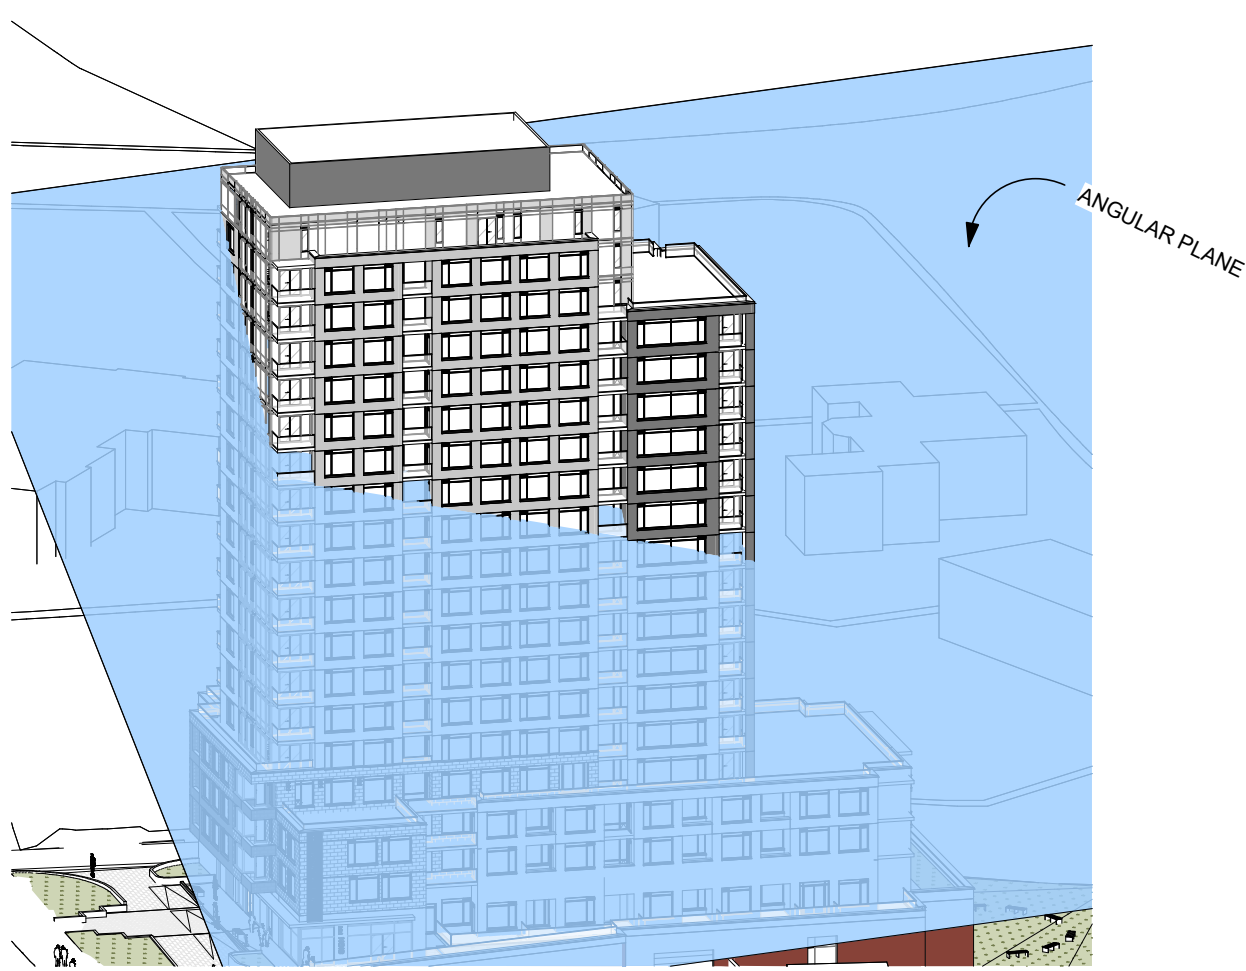

EAST SIDE ANGULAR PLAN
OPTION 1

EAST SIDE ANGULAR PLAN
OPTION 2

WEST SIDE ANGULAR PLAN
OPTION 1

WEST SIDE ANGULAR PLAN
OPTION 2

IT IS THE RESPONSIBILITY OF THE APPROPRIATE CONTRACTOR TO CHECK AND VERIFY ALL DIMENSIONS ON SITE AND TO REPORT ALL ERRORS AND/OR OMISSIONS TO THE ARCHITECT.

ALL CONTRACTORS MUST COMPLY WITH ALL PERTINENT CODES AND BY-LAWS.

THIS DRAWING MAY NOT BE USED FOR CONSTRUCTION UNTIL SIGNED BY THE ARCHITECT.

DO NOT SCALE DRAWINGS.

COPYRIGHT RESERVED.

WITHOUT PREJUDICE

No.	DESCRIPTION	YYYY-MM-DD
REVISIONS:		

ARCHITECT SEAL:

NORTH ARROW:

TRUE NORTH

CLIENT:

ARCHITECT:

56 Beech Street, Ottawa, Ontario K1S 3J6
t.613.724.9932 f.613.724.1209 www.rodericklahey.ca

PROJECT TITLE:

1815 MONTREAL RD

OTTAWA ON




SHEET TITLE:

ANGULAR PLANES

DRAWN: Author	CHECKED: Checker
SCALE: As indicated	SHEET No:
PROJECT No: 2405	A-201

PLOT DATE: 2025-05-01 11:26:22 AM

WITHOUT PREJUDICE

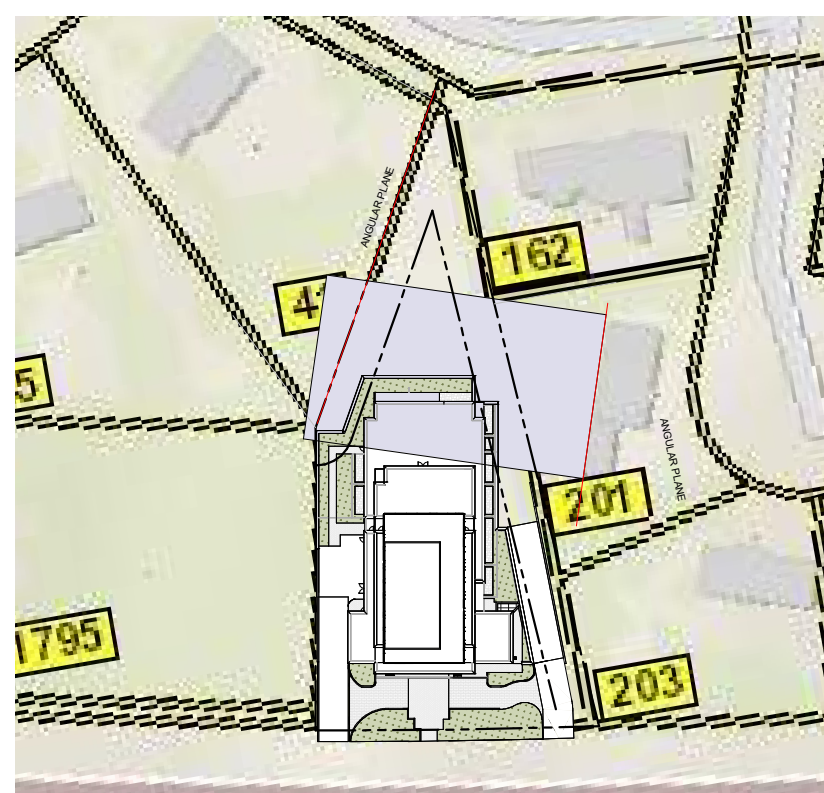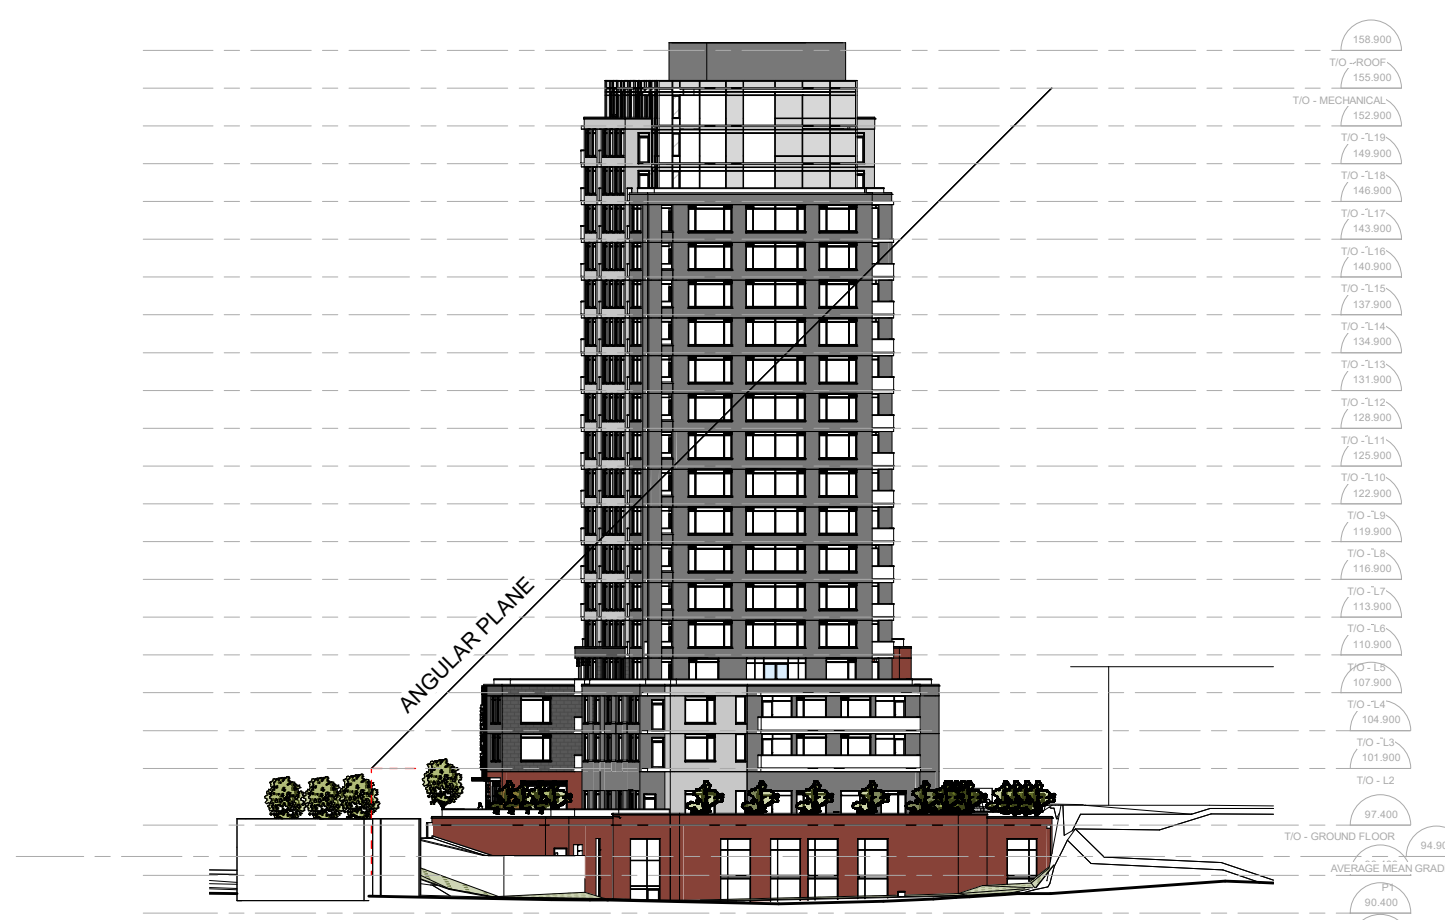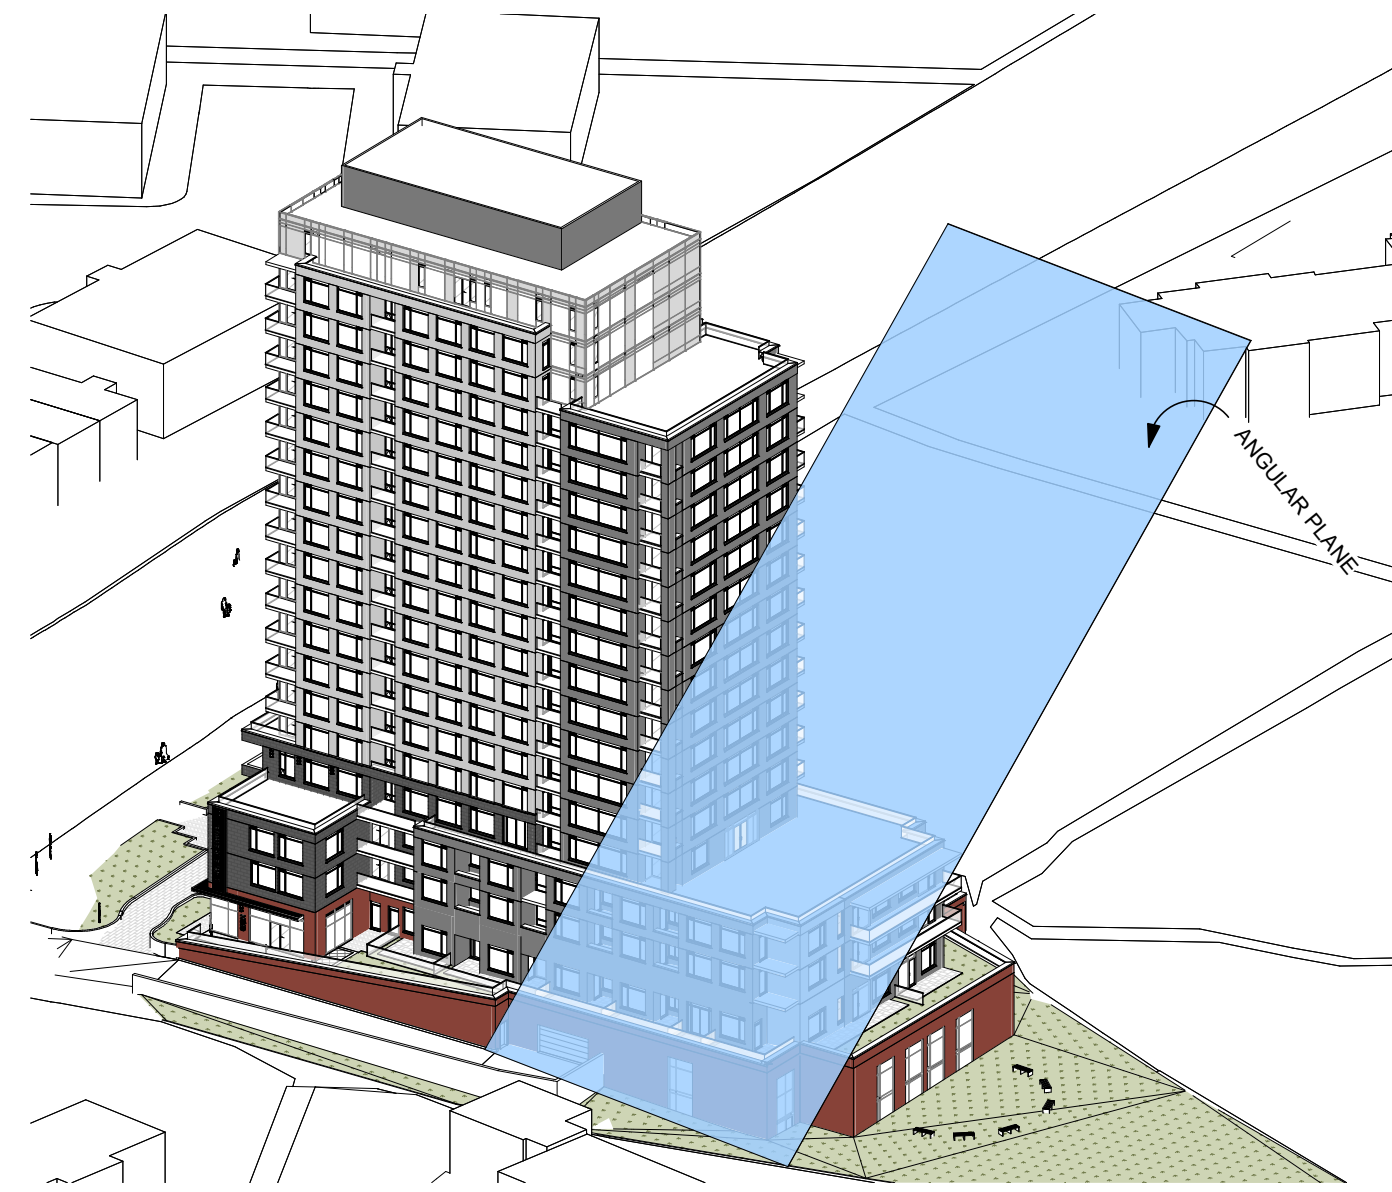

ANGULAR PLANE FROM NEIGHBOURING HOUSE 2

DRAWN: Author	CHECKED: Checker
SCALE: As indicated	SHEET No: A-202
PROJECT No: 2405	

PLOT DATE: 2025-05-01 11:28:46 AM

21 DEC 2025

IT IS THE RESPONSIBILITY OF THE APPROPRIATE
CONTRACTOR TO CHECK AND VERIFY ALL DIMENSIONS
ON SITE AND TO REPORT ALL ERRORS AND/OR
OMISSIONS TO THE ARCHITECT.


ALL CONTRACTORS MUST COMPLY WITH ALL
PERTINENT CODES AND BY-LAWS.

THIS DRAWING MAY NOT BE USED FOR CONSTRUCTION
UNTIL SIGNED BY THE ARCHITECT.

DO NOT SCALE DRAWINGS.

COPYRIGHT RESERVED.

WITHOUT PREJUDICE

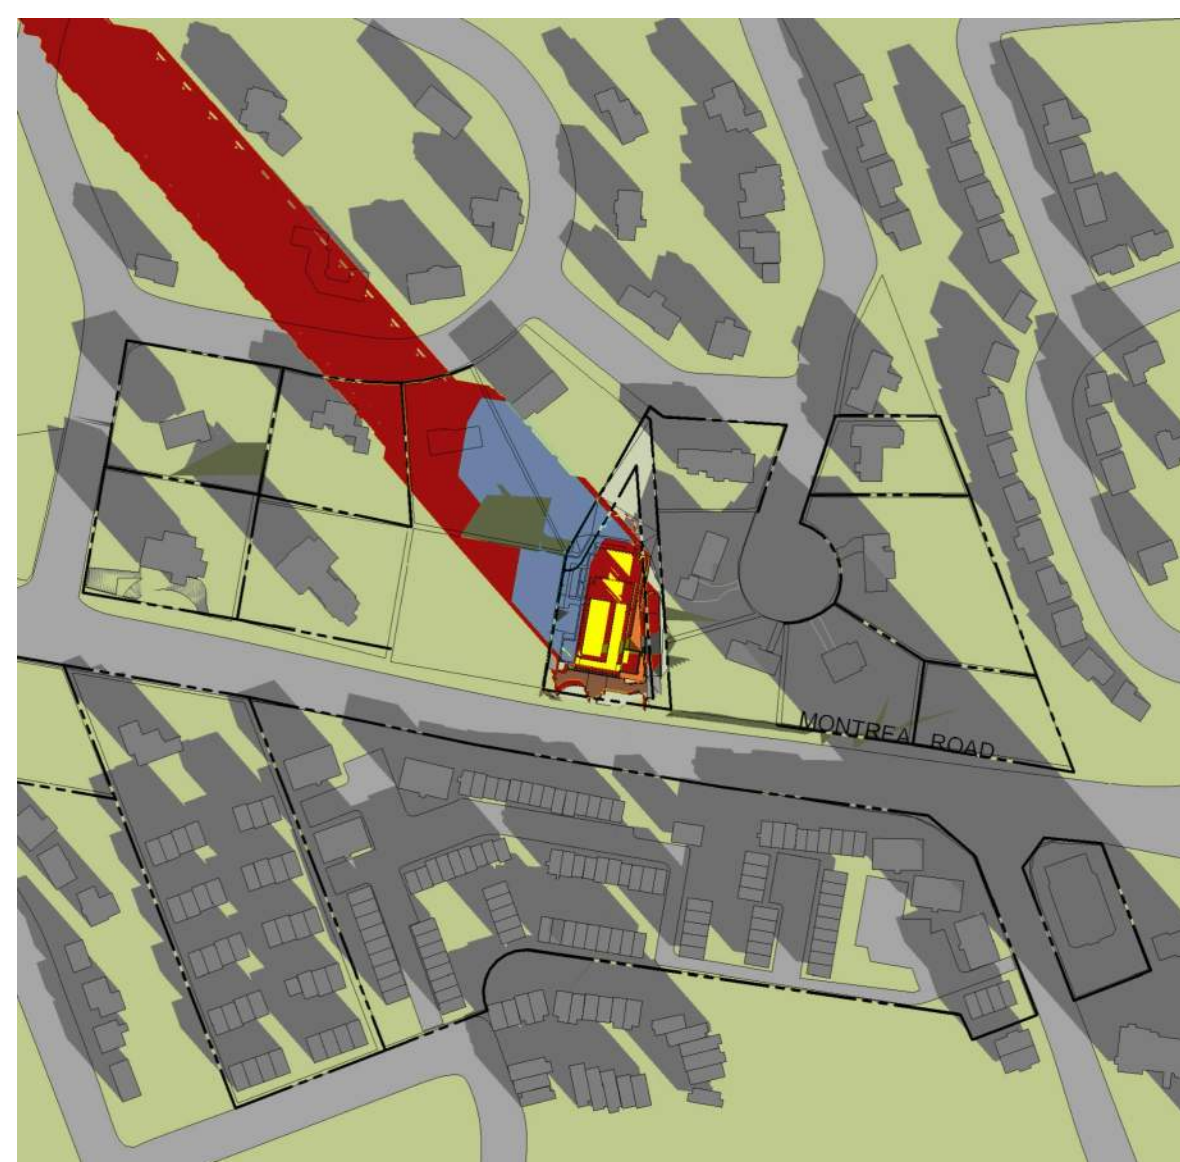

10:00 - DEC 21



11:00 - DEC 21



12:00 - DEC 21



13:00 - DEC 21



 
14:00 - DEC 21



15:00 - DEC 21




16:00 - DEC 21



 PROPOSED SHADOW OUTLINE
 AS OF RIGHT SHADOW OUTLINE
 PROPOSED DEVELOPMENT
 NEW NET SHADOW

[illegible]

SPC 01	ISSUED FOR ZBLA APPLICATION	2024 12 13
No.	DESCRIPTION	YYYY-MM-DD

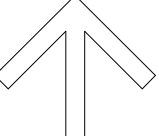REVISIONS:	
ARCHITECT SEAL:	NORTH ARROW: 

CLIENT:

The logo for Creative Dev Ventures is centered on a dark green rectangular background. It features a circular emblem composed of several concentric, slightly offset rings, creating a sense of depth and movement. Overlaid on this emblem is the text "CREATIVE DEV VENTURES" in a clean, white, sans-serif font. Below the company name, the tagline "Development with Purpose" is written in a smaller, lighter font. At the bottom of the green rectangle, the word "Owner" is displayed in a white, serif font.

CREATIVE DEV
VENTURES
Development with Purpose

Owner

ARCHITECT:

rla / architecture

56 Beech Street, Ottawa, Ontario K1S 3J6
t.613.724.9932 f.613.724.1209 www.rodericklahey.ca

PROJECT TITLE:

1815 MONTREAL RD

OTTAWA ON

SHEET TITLE:	
UNSHADE STUDY	
DRAWN: Author	CHECKED: Checker
SCALE: 1 : 1	SHEET No:
PROJECT No: 2405	A-303

PLOT DATE: 2025-05-01 11:28:48 AM

WITHOUT PREJUDICE



SPC 01	ISSUED FOR ZBLA APPLICATION	2024 12 13
No.	DESCRIPTION	YYYY-MM-DD
REVISIONS:		

CLIENT:

The logo for Creative Dev Ventures is centered on a dark green rectangular background. It features a large, stylized 'C' composed of concentric, slightly offset circles. Overlaid on this 'C' is the text 'CREATIVE DEV' in a small, white, sans-serif font, followed by 'VENTURES' in a larger, bold, white, sans-serif font. Below this, the tagline 'Development with Purpose' is written in a smaller, white, sans-serif font. At the bottom of the logo, the word 'Owner' is written in a white, serif font.

PROJECT TITLE:

1815 MONTREAL RD

OTTAWA ON

PLOT DATE: 2025-05-01 11:27:02 AM

WITHOUT PREJUDICE



SPC 01	ISSUED FOR ZBLA APPLICATION	2024 12 13
No.	DESCRIPTION	YYYY-MM-DD
REVISIONS:		

CLIENT:

The logo for Creative Dev Ventures is centered on a dark green rectangular background. It features a large, stylized 'C' composed of concentric, slightly offset circles. Overlaid on this 'C' is the text 'CREATIVE DEV' in a small, white, sans-serif font, followed by 'VENTURES' in a larger, bold, white, sans-serif font. Below 'VENTURES' is the tagline 'Development with Purpose' in a smaller, white, sans-serif font. At the bottom of the logo, the word 'Owner' is written in a white, serif font.

PROJECT TITLE:

1815 MONTREAL RD

OTTAWA ON

PLOT DATE: 2025-05-01 11:27:22 AM



3D VIEW LOOKING TOWARDS ENTRANCE



3D VIEW LOOKING TOWARDS ENTRANCE

IT IS THE RESPONSIBILITY OF THE APPROPRIATE CONTRACTOR TO CHECK AND VERIFY ALL DIMENSIONS ON SITE AND TO REPORT ALL ERRORS AND/OR OMISSIONS TO THE ARCHITECT.

ALL CONTRACTORS MUST COMPLY WITH ALL
PERTINENT CODES AND BY-LAWS.

THIS DRAWING MAY NOT BE USED FOR CONSTRUCTION
UNTIL SIGNED BY THE ARCHITECT.

DO NOT SCALE DRAWINGS.

COPYRIGHT RESERVED.

WITHOUT PREJUDICE

[illegible]

PC 01	ISSUED FOR ZBLA APPLICATION	2024 12 13
No.	DESCRIPTION	YYYY-MM-DD

REVISIONS:

ARCHITECT SEAL:	NORTH ARROW:

CLIENT:



Owner

ARCHITECT:

rla / architecture

6 Beech Street, Ottawa, Ontario K1S 3J6
613.724.9932 f.613.724.1209 www.rodericklahey.ca

PROJECT TITLE:

1815 MONTREAL RD

OTTAWA ON

ENLARGED 3D VIEWS

DRAWN:	CHECKED:
Author	Checker

SCALE:	SHEET No:
--------	-----------

PROJECT No:	A-403
2405	

PLOT DATE: 2025-05-01 11:27:54 AM
PAPER SIZE: ISO Full Bleed B1 (707.00 x 1000.00mm)