




UNDERGROUND FIRE STORAGE TANK OPTION 1

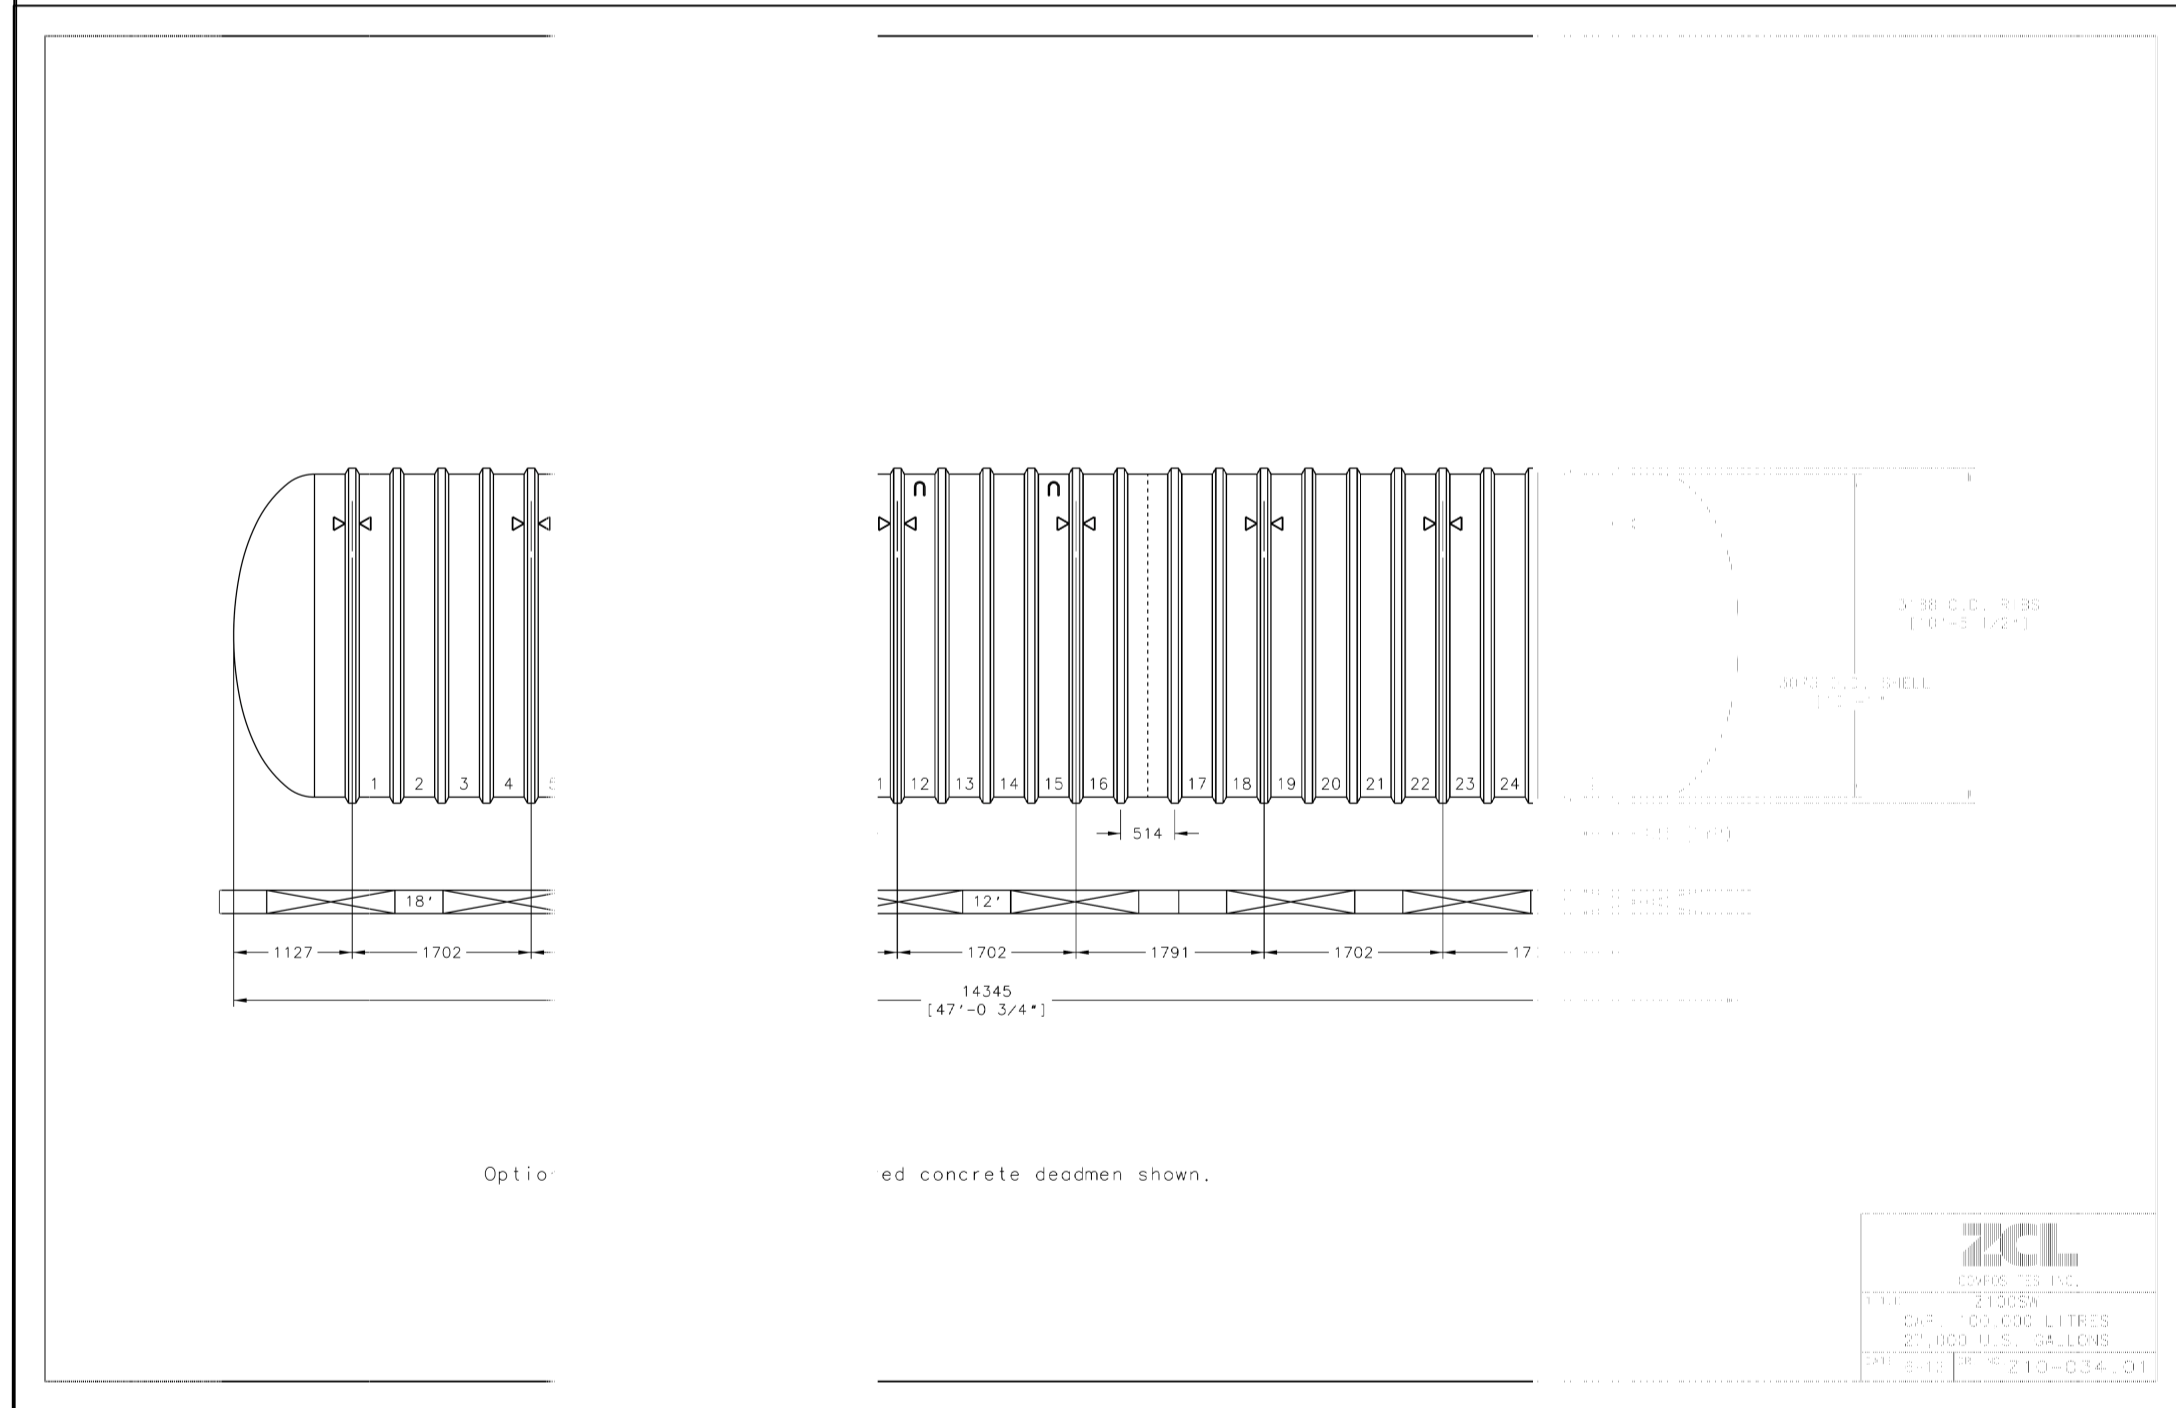

Option 2

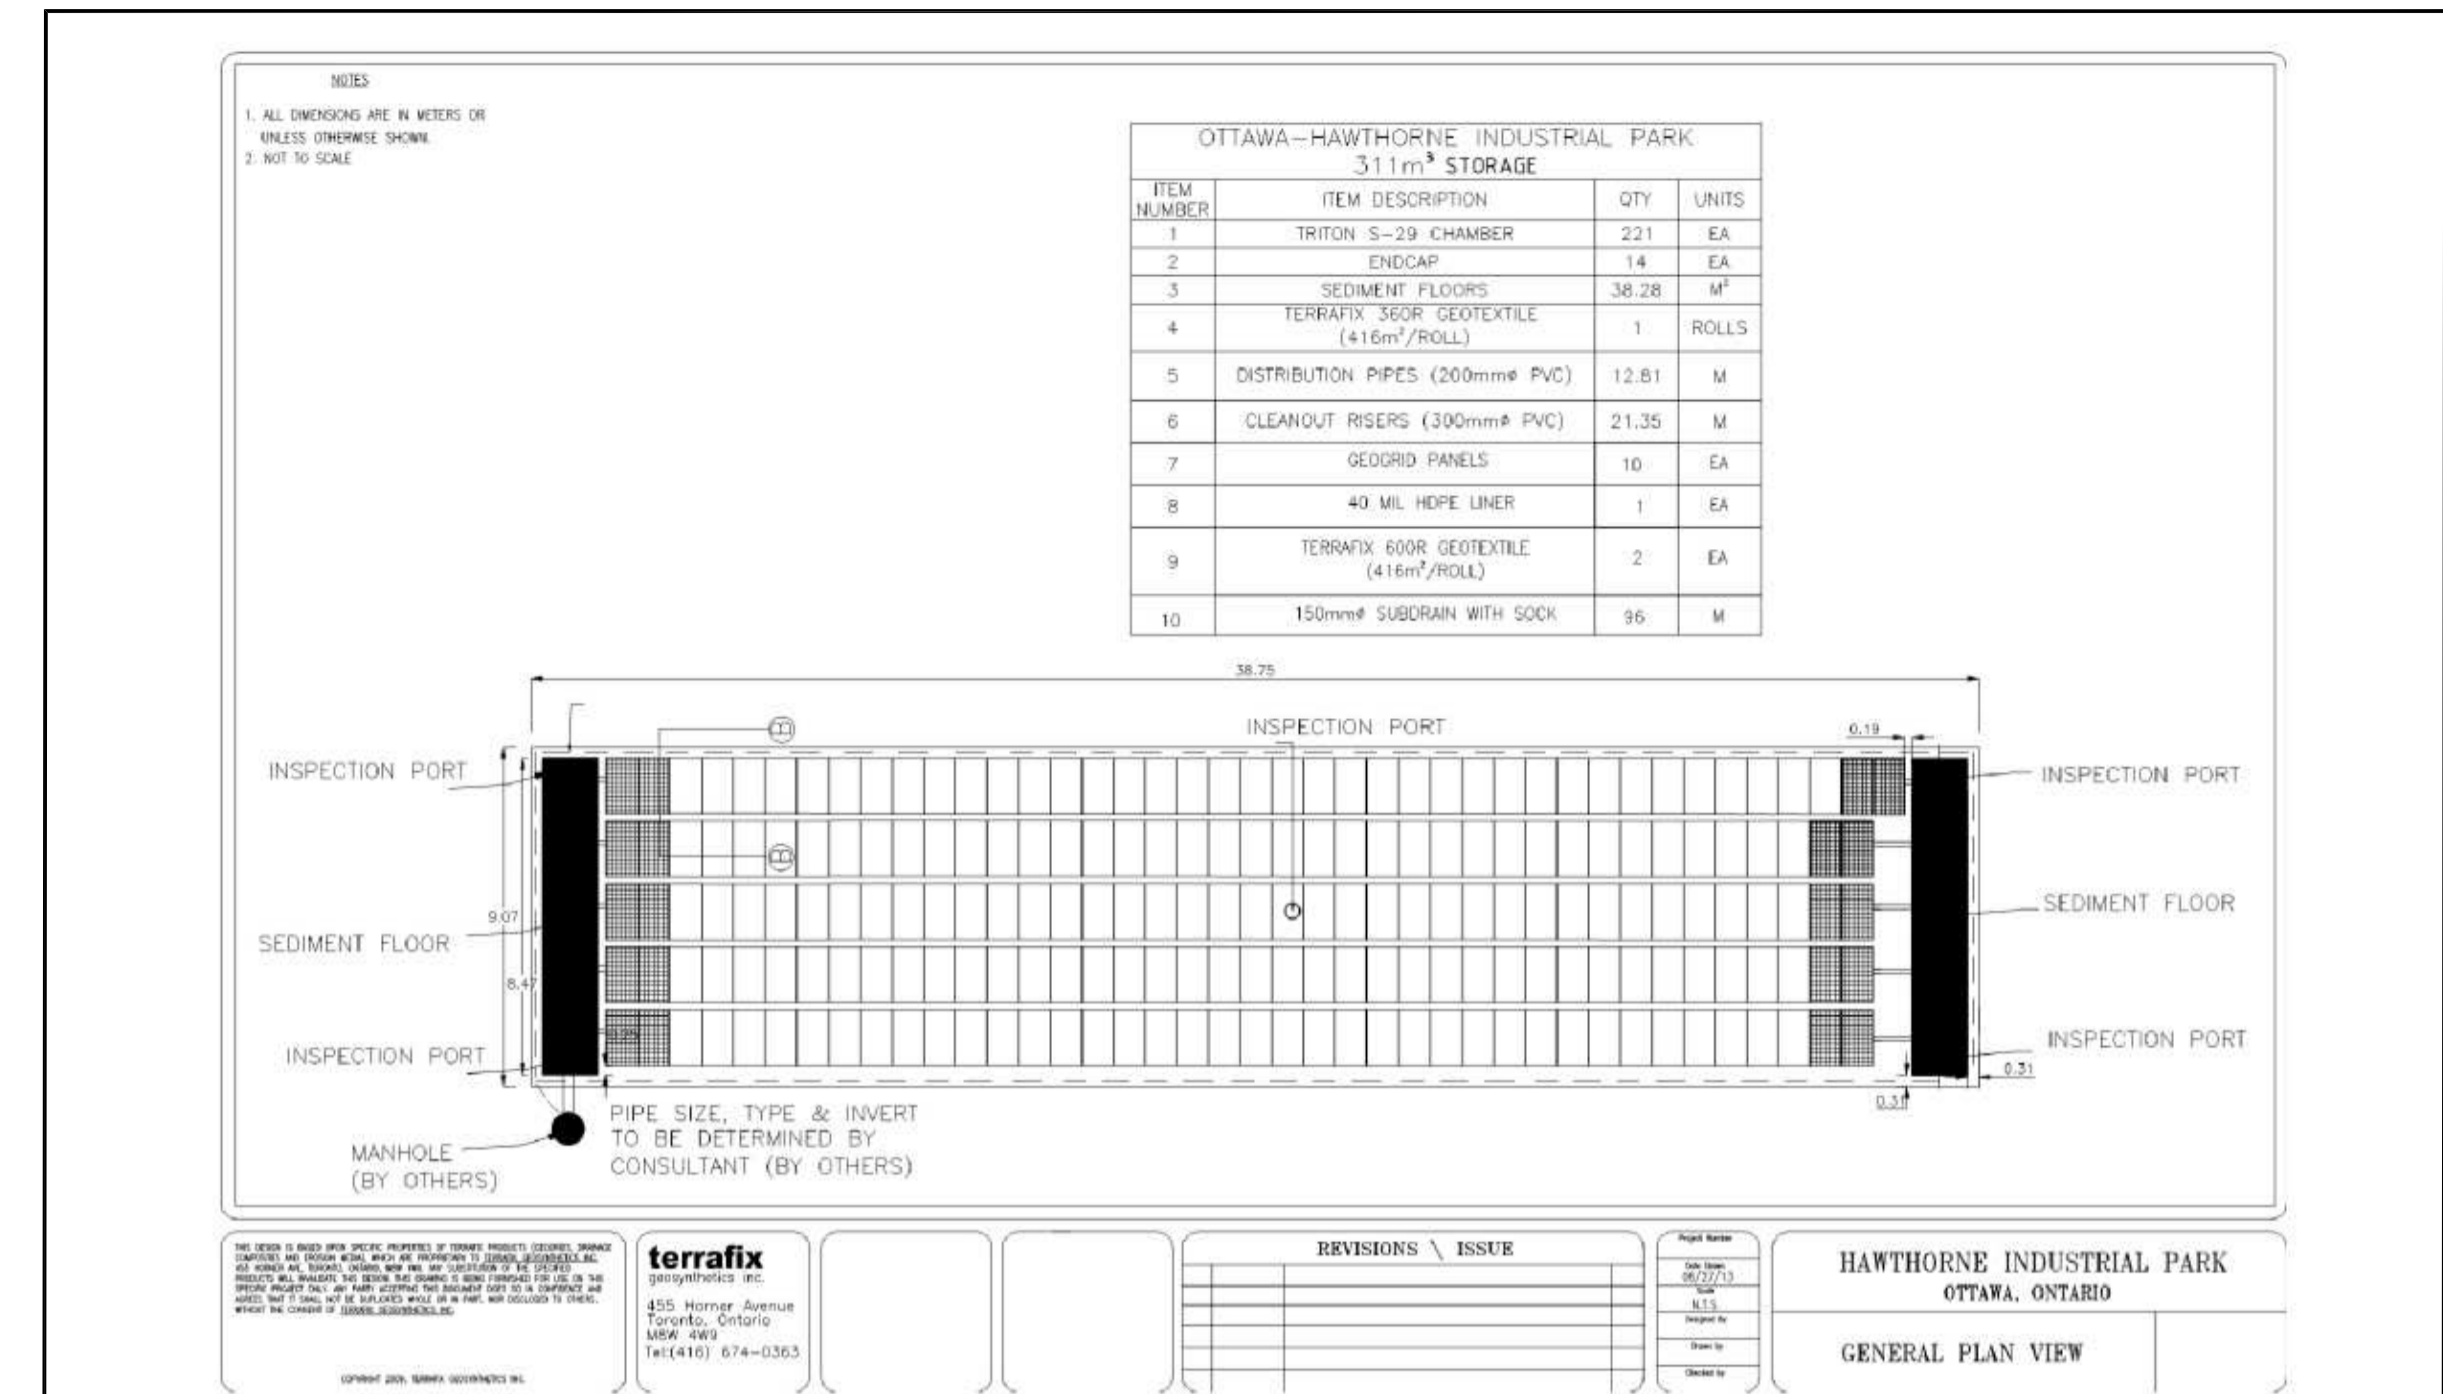

UNDERGROUND FIRE STORAGE TANK OPTION 2

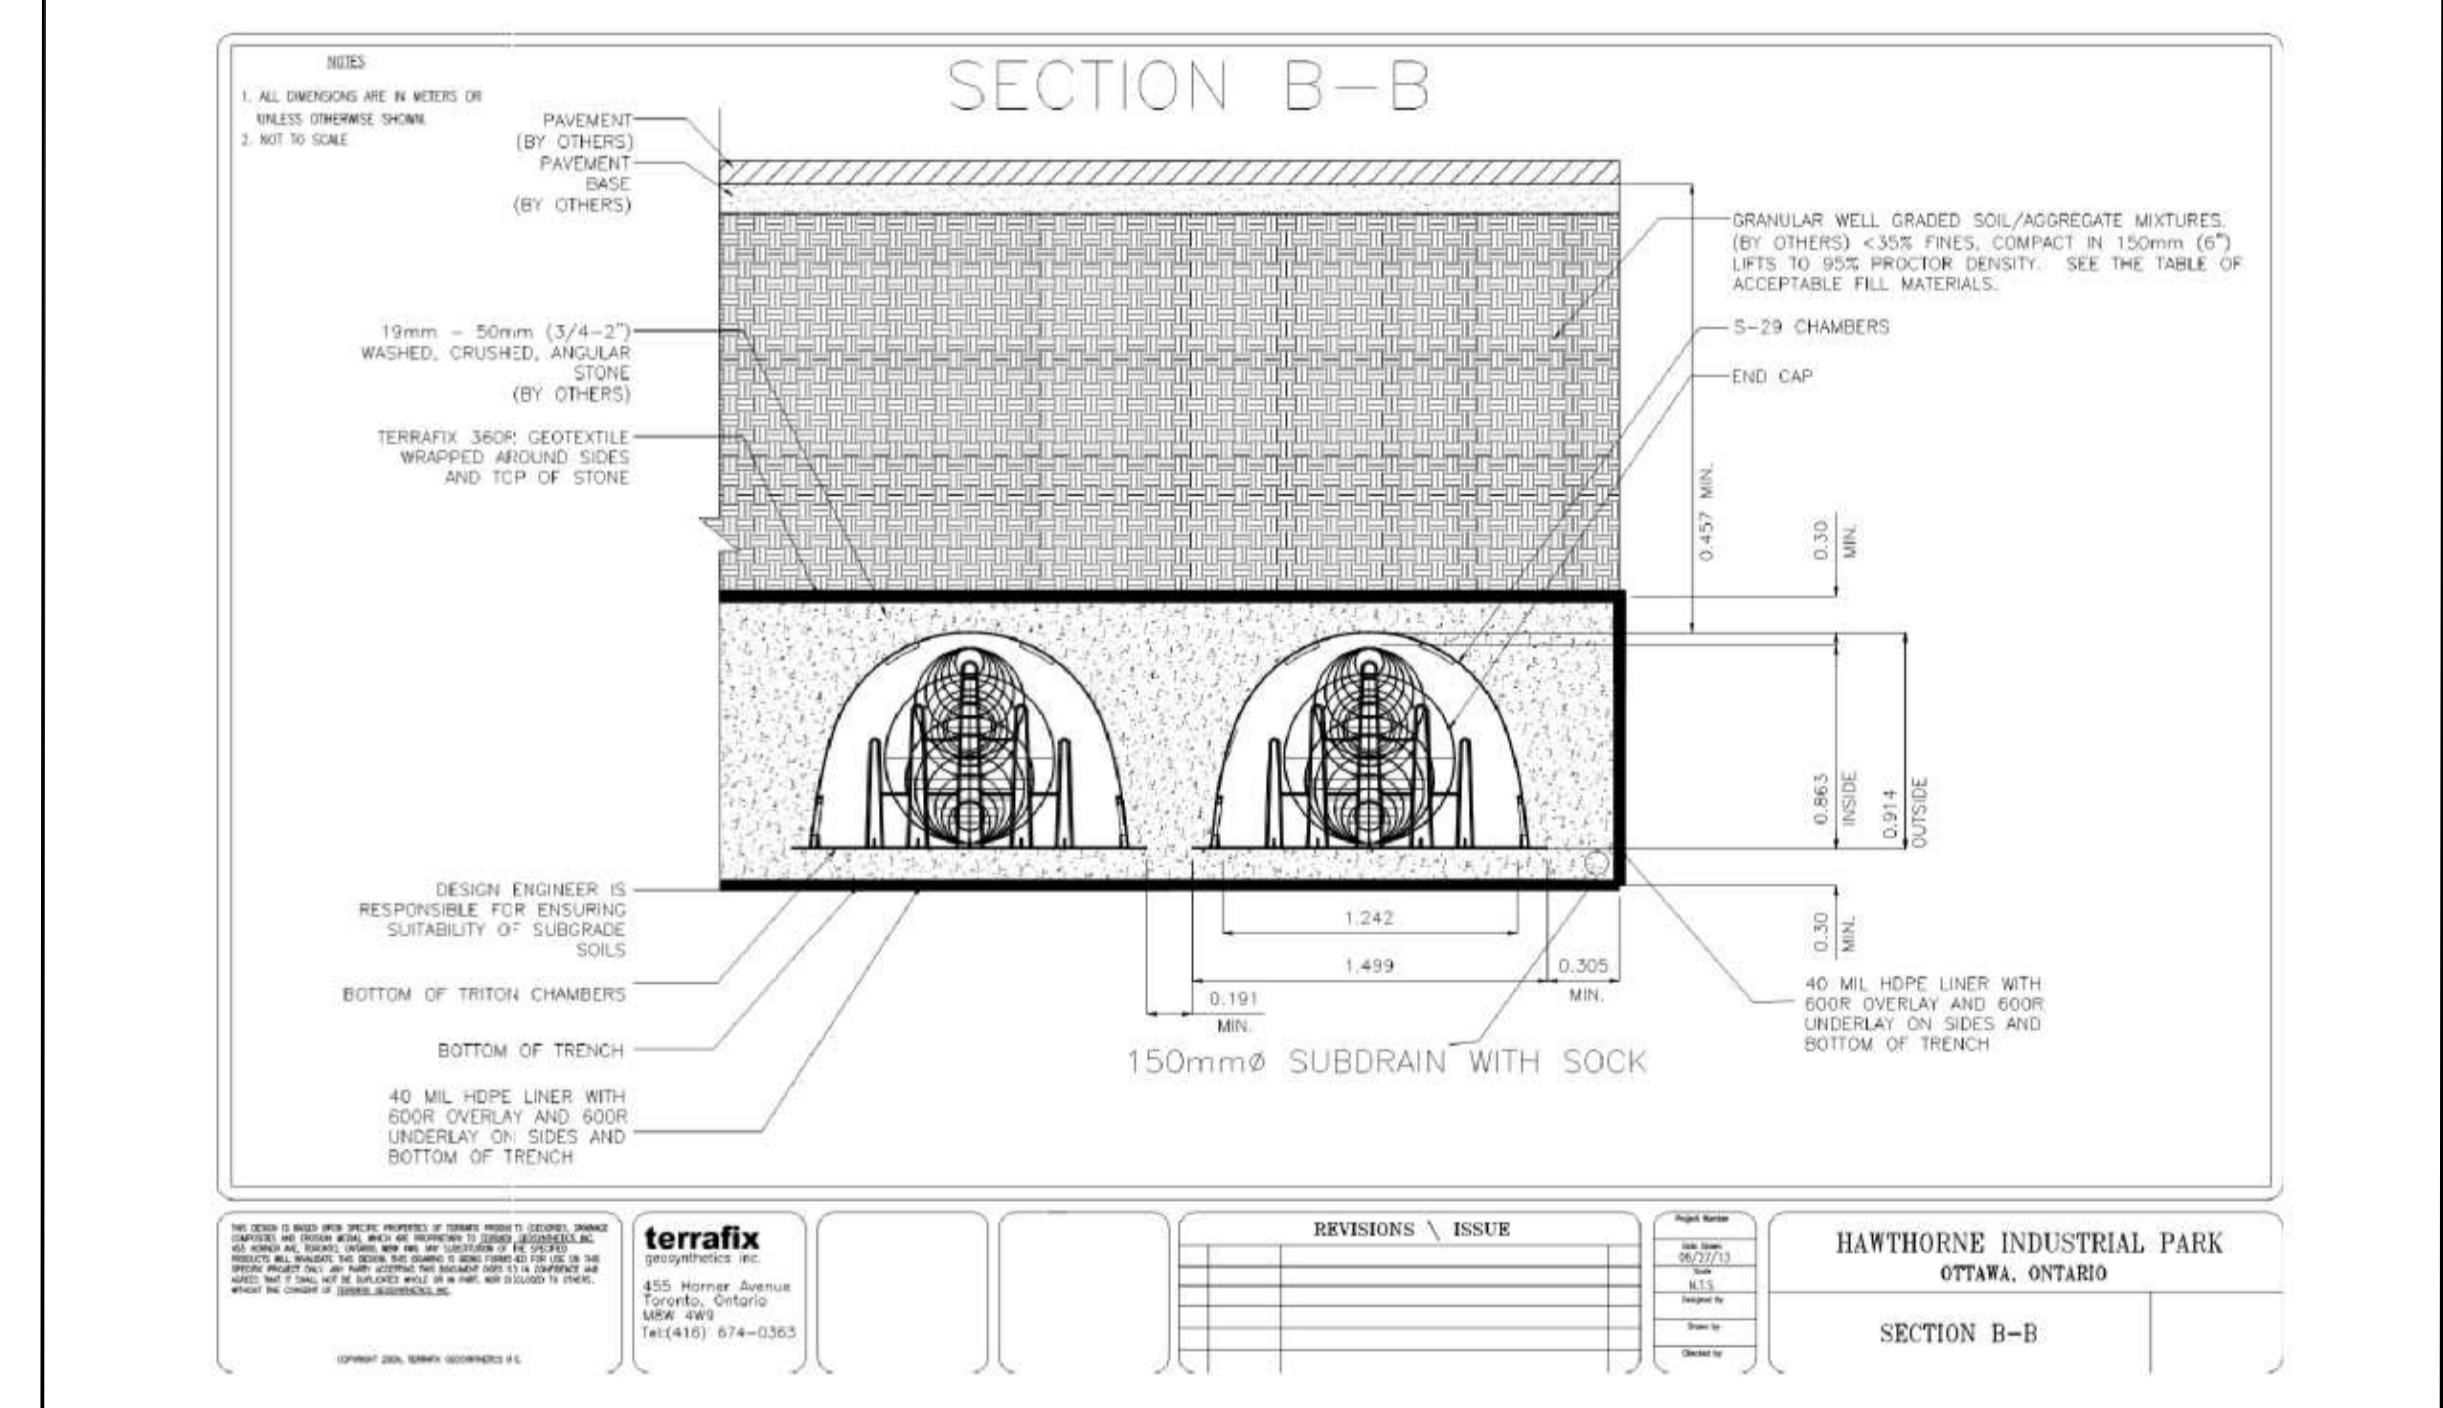

NOTE:
THE POSITION OF ALL POLE LINES, CONDUITS, WATERMANS, SEWERS AND OTHER UNDERGROUND AND OVERGROUND UTILITIES AND STRUCTURES IS NOT NECESSARILY SHOWN ON THE CONTRACT DRAWINGS, AND WHERE SHOWN, THE ACCURACY OF THE POSITION OF SUCH UTILITIES AND STRUCTURES IS NOT GUARANTEED. BEFORE STARTING WORK, DETERMINE THE EXACT LOCATION OF ALL SUCH UTILITIES AND STRUCTURES AND ASSUME ALL LIABILITY FOR DAMAGE TO THEM.

No.	REVISION	DATE	BY
1.	ISSUED FOR SITE PLAN APPROVAL	FEB 10/14	LAB

SCALE	DESIGN
AS SHOWN	CHECKED
	DRAWN
	CHECKED
	APPROVED

FOR REVIEW ONLY	

CITY OF OTTAWA
35 SAPPERS RIDGE - APEX SOUTH BUSINESS CENTRE

NOVATECH
ENGINEERING
CONSULTANTS LTD.
ENGINEERS & PLANNERS
Suite 200, 240 Michael Cowpland Drive
Ottawa, Ontario, Canada
K2M 1P6
Telephone: (613) 254-9643
Facsimile: (613) 254-5967
Email: novainto@novatech-eng.com

PROJECT NO.: 112034B-1
REV: REV #1
DRAWING NO.: 112034-D2

DETAIL PLAN

M:\2011\12034\CAD\Design\112034-D.dwg, D2, Feb 10, 2014, 2:37pm, mmckeeough