

THE EXISTING JOB BENCHMARK IS ON A UTILITY POLE THAT WILL BE RELOCATED. THE SURVEYOR SHALL ESTABLISH AN ALTERNATIVE JOB BENCHMARK PRIOR TO THE COMMENCEMENT OF CONSTRUCTION.

AN EXISTING TRANSFORMER AND STREET LIGHT ARE CONNECTED TO POLE TO BE REMOVED AND SHALL BE CONNECTED TO NEW POLE.

THIS COMPOSITE UTILITY PLAN HAS BEEN PREPARED FOR THE PURPOSES OF COORDINATING THE LOCATION OF THE WATER WORKS, SEWER WORKS AND UTILITIES (INCLUDING GAS, ELECTRICAL, TELEPHONE AND CABLE TV) SERVING THE SUBJECT SITE. REFER TO THE APPROPRIATE PLANS AND DOCUMENTS FOR EXACT LOCATIONS AND DETAILS. LOCATE ALL SERVICES AND UTILITIES PRIOR TO CONSTRUCTION.

DRAWING LEGEND

CB	CATCH BASIN
MH	MANHOLE
CB/MH	CATCH BASIN/MANHOLE
MH	SANITARY MANHOLE
SPL	SPRINGLINE OF PIPE
INV	INVERT OF PIPE
SAN	SANITARY SEWER
ST	STORM SEWER
WS/WM	WATER SERVICE/WATERMAIN
CS	CURB STOP & STANDPOST
VB	VALVE & VALVE BOX
FH	FIRE HYDRANT
W	WATER METER
RM	REMOTE WATER METER READOUT
EGE	EXISTING GRADE ELEVATION
PL	PROPERTY LINE
FEL	FIRST FLOOR ELEVATION
TOP	TOP OF FOUNDATION
BFL	BASEMENT FLOOR ELEVATION
USF	UNDERSIDE OF FOOTING
H	HYDRO
SEC	HYDRO (SECONDARY)
B	BELL TELEPHONE
CAB	ROGERS CABLE
G	GAS

KEY PLAN



No.	DATE	REVISION
4	MAY 20-21	TREE LOCATIONS REVISED
3	MAR 15-21	ISSUED FOR CIRCULATION
2	MAY 25-20	PRELIMINARY CONCEPT SENT TO WSP FOR COORDINATION
1	JUN 14-18	PRELIMINARY



D. B. GRAY ENGINEERING INC.
 Surveyor/Manager - Civil/Drainage, Storm & Sanitary Sewers - Professional
 700 Long Point Circle
 Ottawa, Ontario K1G 4G4
 613-425-8044
 dgray@dbgrayengineering.com

PROPOSED RESIDENTIAL DEVELOPMENT
 1164-1166 HIGHCROFT DR.
 MANOTICK, ONTARIO

COMPOSITE UTILITY PLAN

Drawn	D.B.G.
Hor. Scale	1:200
Vert. Scale	1:20
Date	JUN 14-18
Job No.	18035

Drawing No. **CUP-1**
of 1

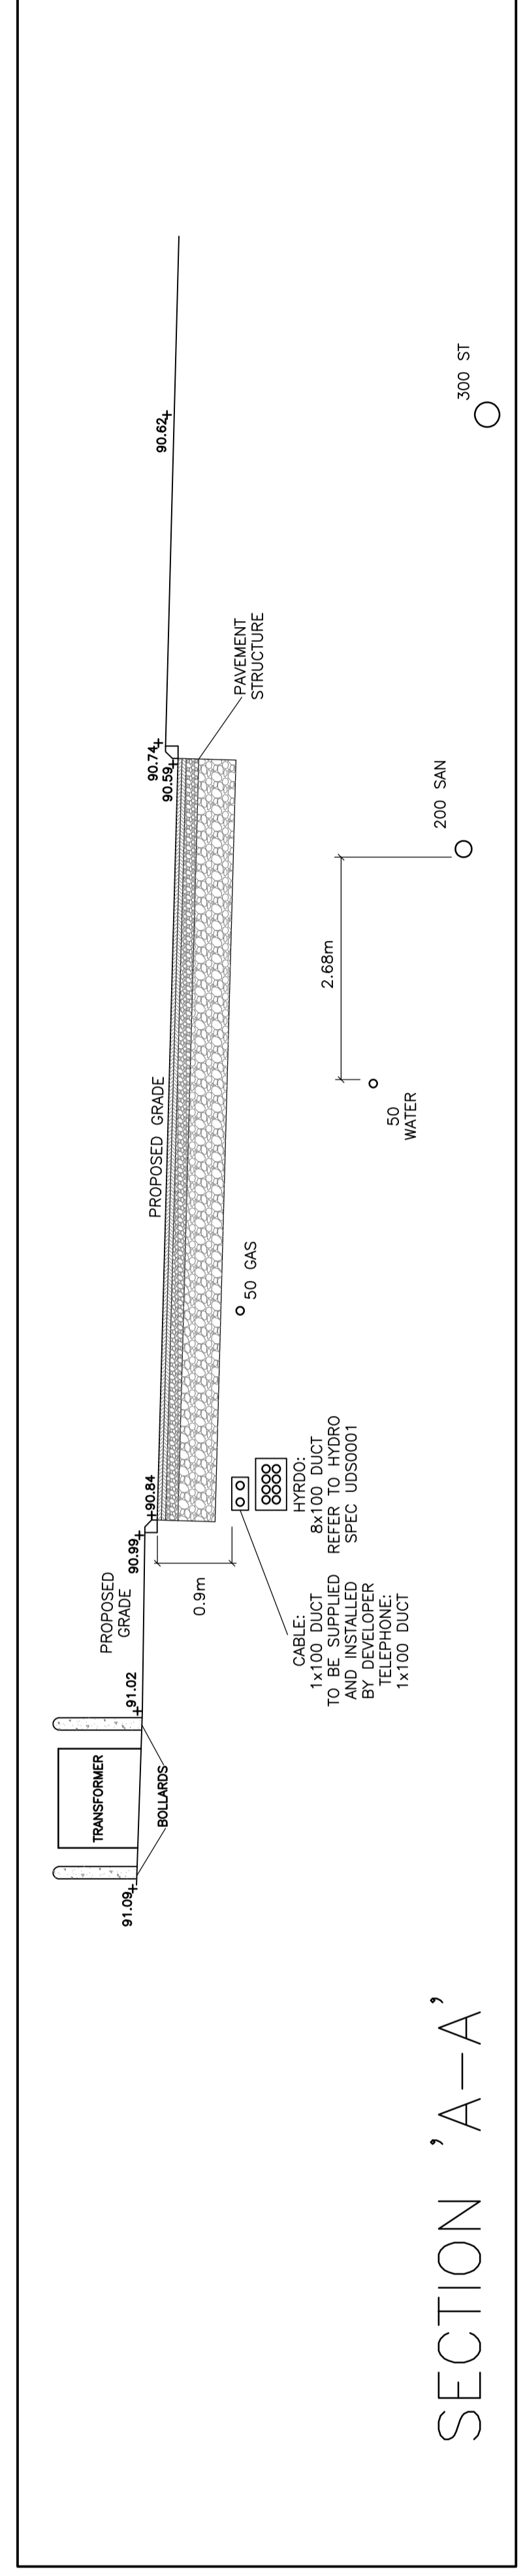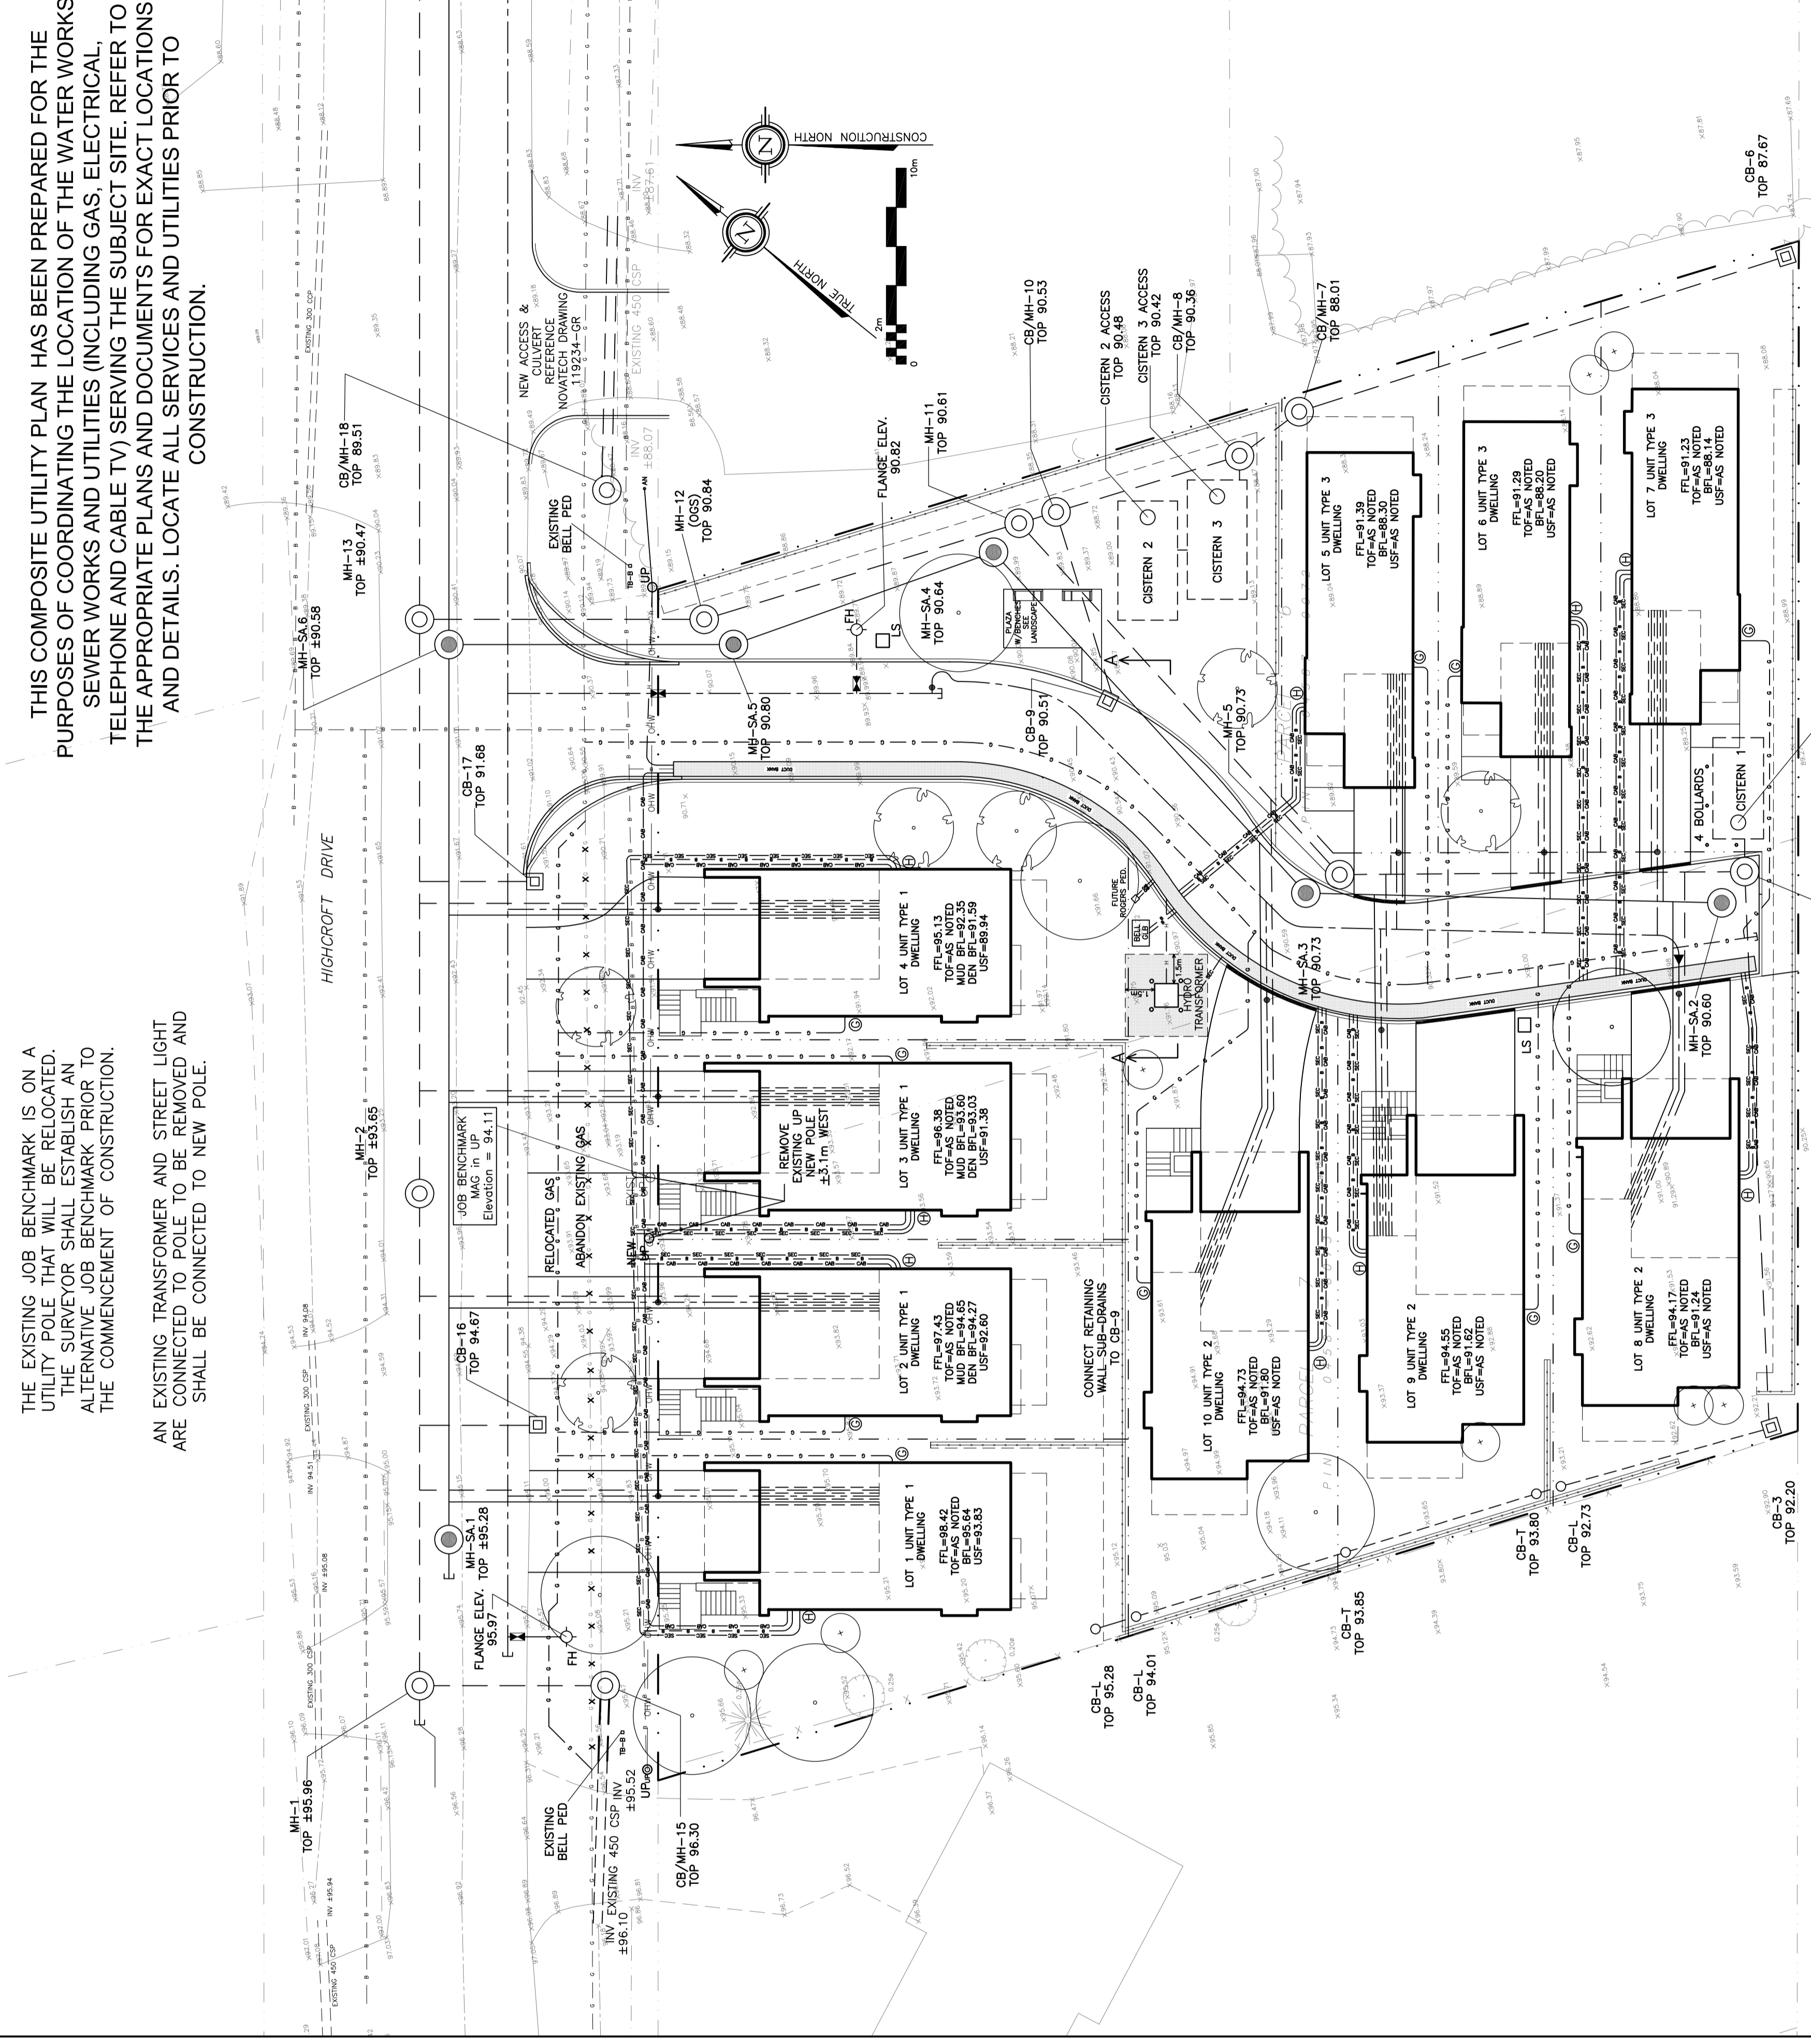

SECTION 'A-A'