


LEGEND

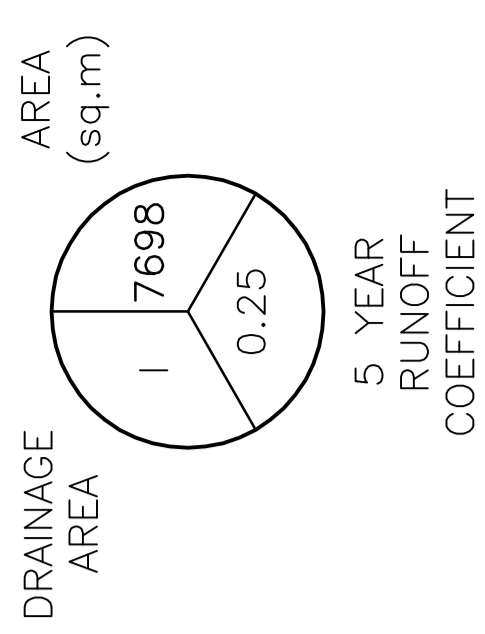

KEY PLAN



No.	DATE	REVISION
3	SEP 27-19	RE-ISSUED FOR APPROVAL
2	AUG 9-19	ISSUED FOR APPROVAL
1	JUN 14-19	PRELIMINARY

D. B. GRAY ENGINEERING INC.
 Professional Engineers - Consulting Engineers - Surveyors & Estimators - Planners
 700 Long Point Circle
 Ottawa, Ontario
 413-425-8044
 dgray@dbgrayengineering.com

Project
PROPOSED RESIDENTIAL DEVELOPMENT
1164-1166 HIGHCROFT DR.
 MANOTICK, ONTARIO

Drawing Title
DRAINAGE PLAN

Engineer's Seal

 Drawn: D.B.G.
 Hor. Scale: 1:200
 Vert. Scale:
 Date: JUN 14-19
 Job No.: 180335
 Drawing No.:
C-6
 of **8**
 NOT VALID UNLESS SIGNED & DATED

