


Copyright Reserved

The Contractor shall verify and be responsible for all dimensions. DO NOT scale the drawing - any errors or omissions shall be reported to Stantec without delay.
The Copyrights to all designs and drawings are the property of Stantec. Reproduction or use for any purpose other than that authorized by Stantec is forbidden.

Legend

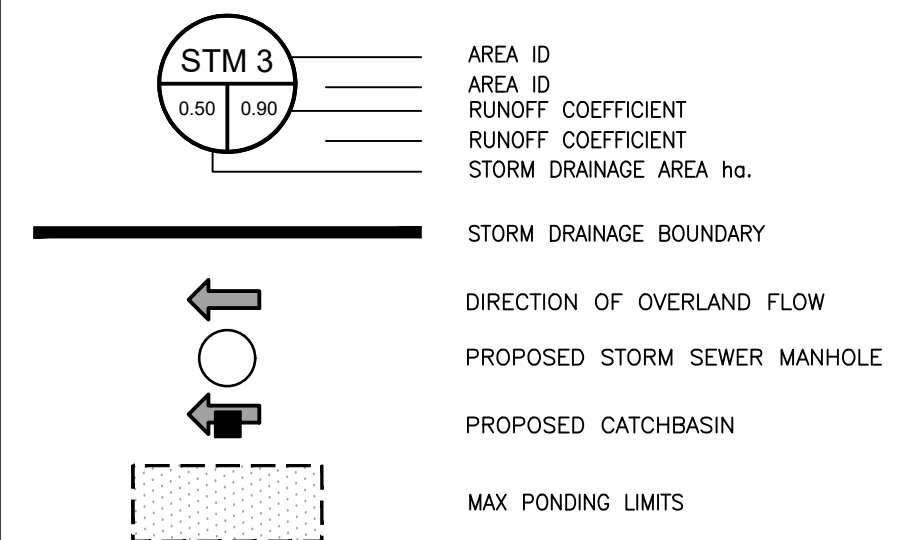

SCHEDULE OF ROOF RELEASE RATES				
BUILDING	HEAD (m)	# OF DRAINS	ICD TYPE	100YR RELEASE RATE (L/s)
BACK-TO-BACK TOWNS	0.15	2	WATS ACCURFLOW (25% OPEN)	1.9

Notes

SCHEDULE OF INLET CONTROL DEVICES					
STRUCTURE ID	DRAINAGE AREA ID	ICD TYPE	ICD INVERT (m)	100 YEAR HEAD (m)	100 YEAR FLOW (L/s)
CB 1	STM-1	PEX TEMPEST LMF 65	91.82	1.68	4.7
CB 2	STM-2	PEX TRIFLEX (25mm CHIMNEY)	91.78	1.60	14.2
CB 3	STM-3	PEX TEMPEST LMF 60	91.80	1.68	4.2

4	REVISED AS PER CITY COMMENTS	DC	DT	20.10.16
3	REVISED AS PER CITY COMMENTS	DC	DT	20.09.14
2	REVISED AS PER CITY COMMENTS	AJ	DT	20.06.30
1	ISSUED FOR SPA	AJ	DT	19.09.12

Revision				
By	Appd.	YY.MM.DD		
			MJS	SG
			Dwn.	Chkd.
			Dgn.	YY.MM.DD


File Name: 160401500 BLK 15 DE.DWG

Permit-Seal

Client/Project
LONGFIELDS BLOCK 14
CAMPANALE GROUP
200-1187 BANK STREET
K1S 3X7
OTTAWA, ON, CANADA

Title
STORM DRAINAGE PLAN

Project No. 160401500
Drawing No. SD-1
Scale 1:300
Sheet 5 of 6
Revision 4
15m
D07-12-19-0174

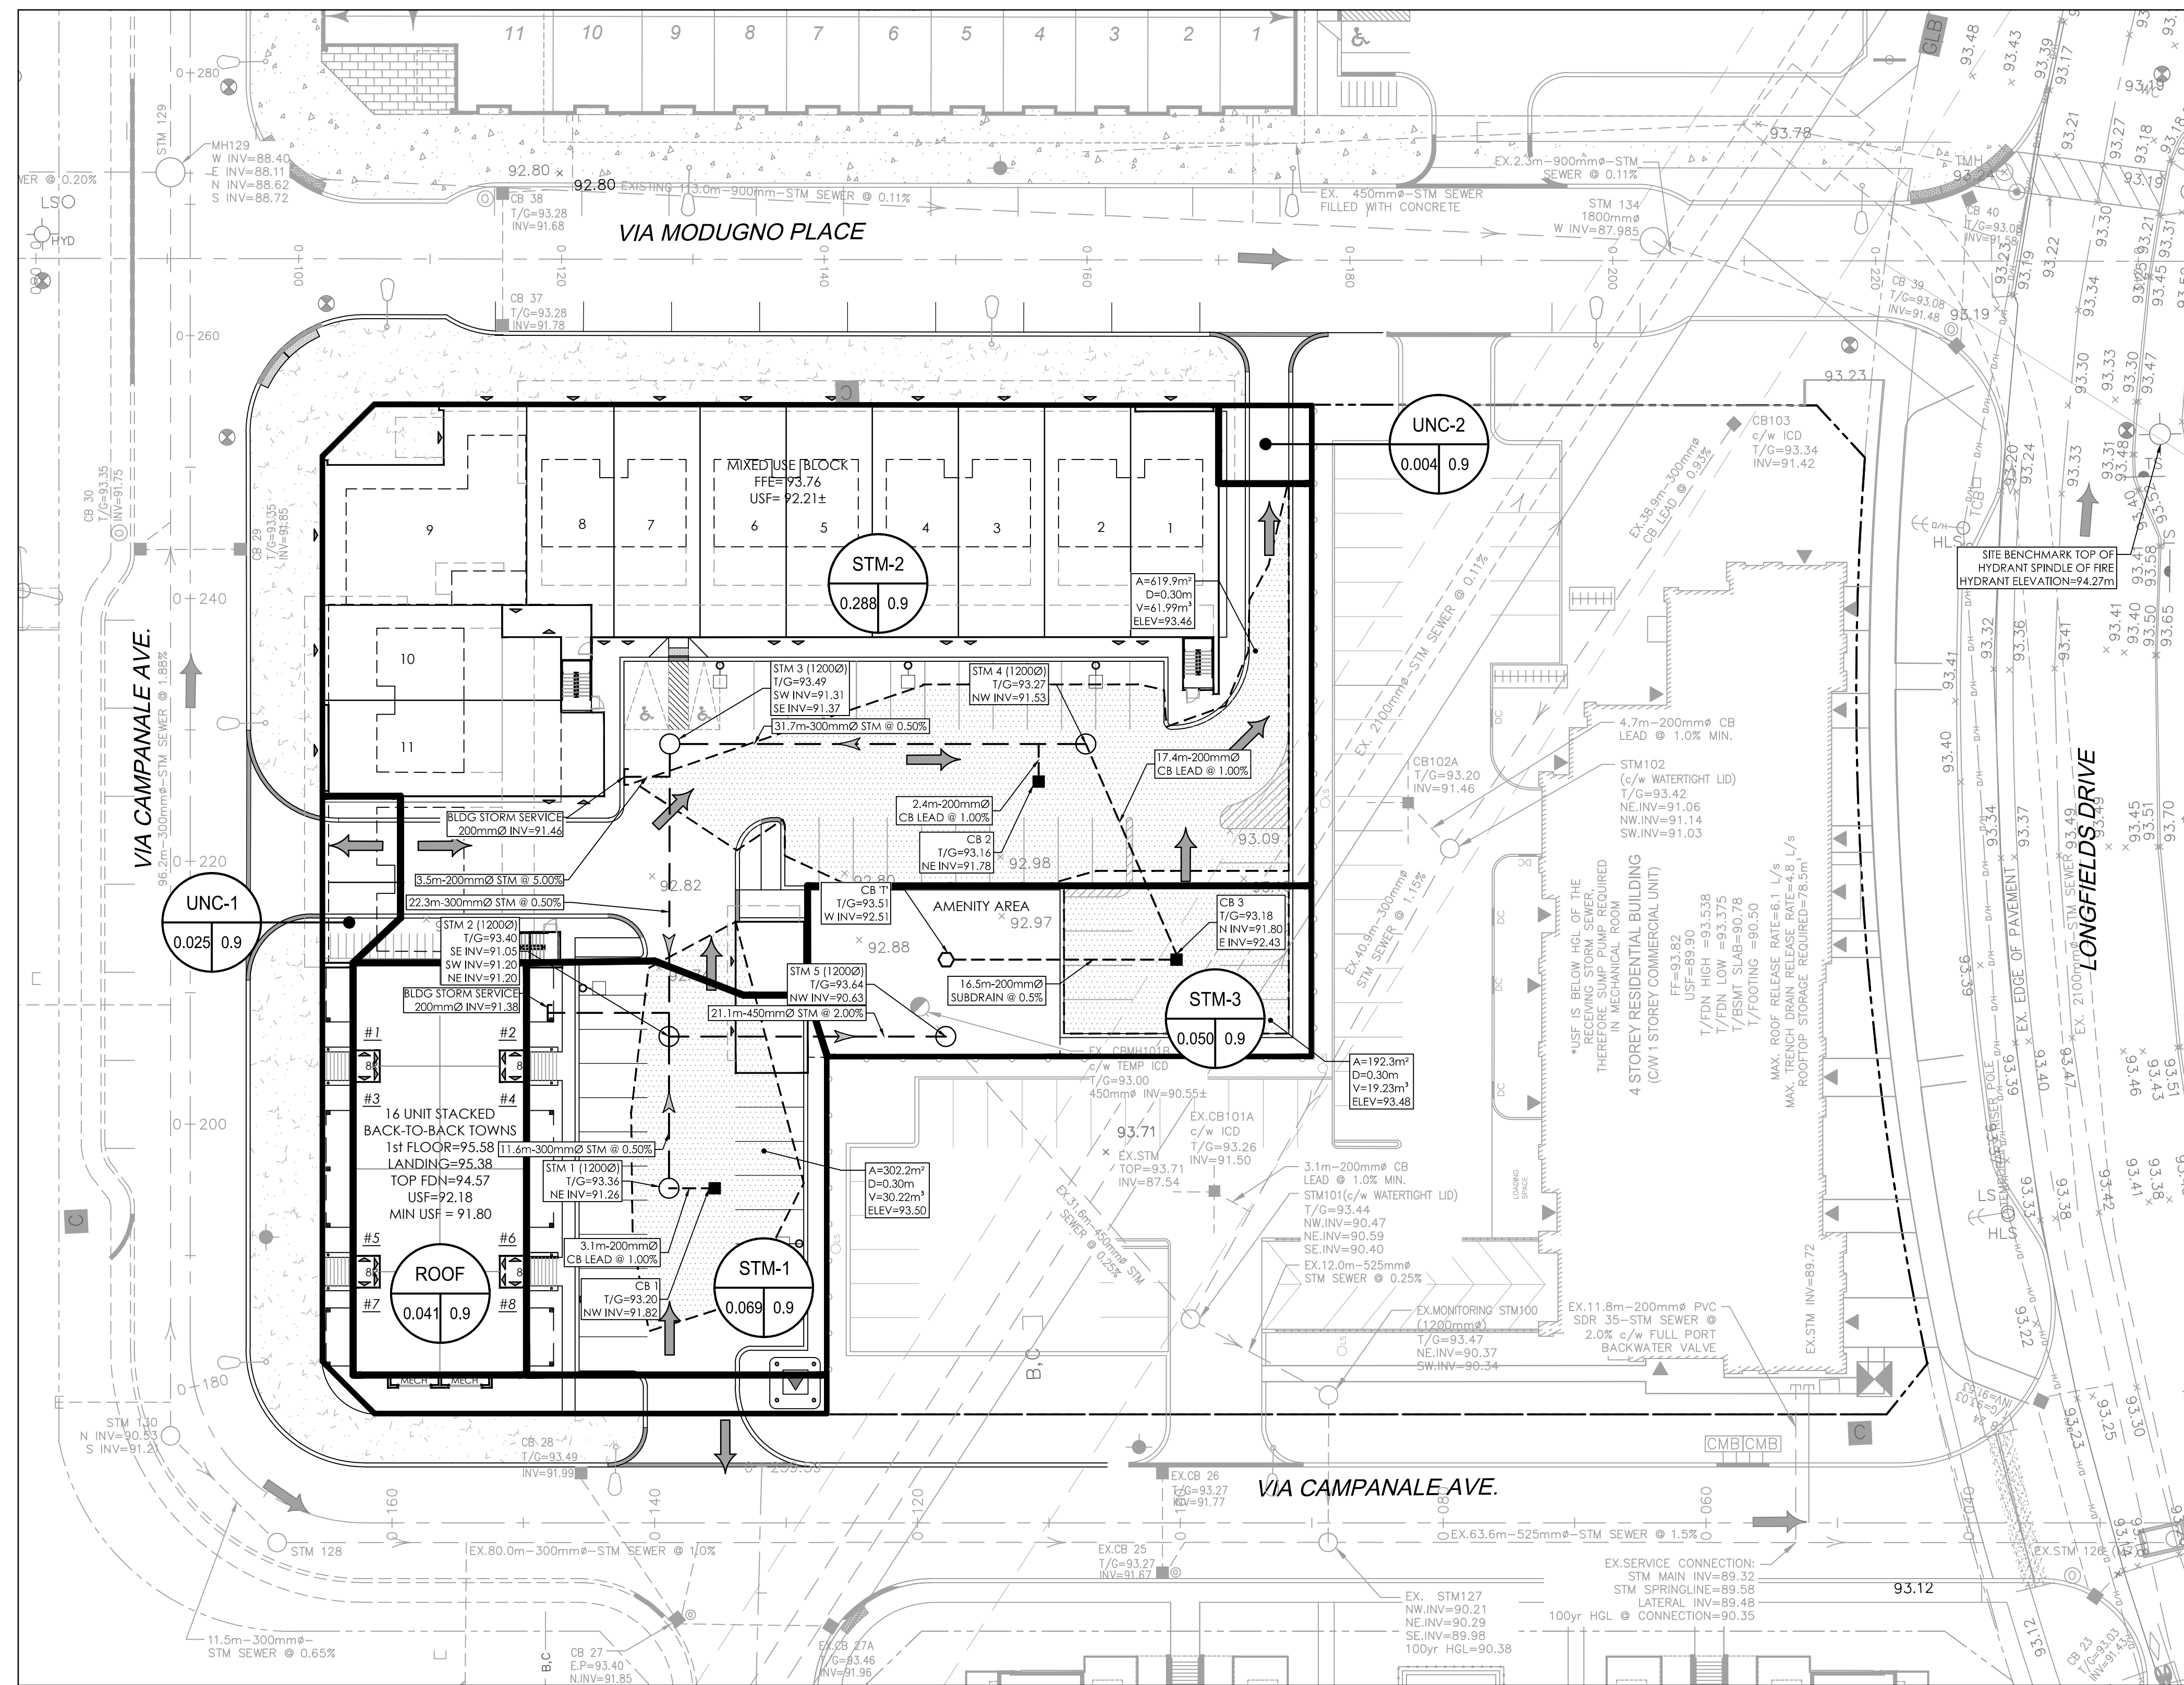

APPROVED
By Lily Xu at 2:32 pm, Nov 26, 2020

LILY XU, MCIP, RPP
MANAGER, DEVELOPMENT REVIEW SOUTH
PLANNING, INFRASTRUCTURE & ECONOMIC
DEVELOPMENT DEPARTMENT, CITY OF OTTAWA