


BANK AND ALYMER- MIXED USE LOW RISE BUILDING

1050 AND 1060 BANK STREET , OTTAWA, ON.

SITE LIGHTING PLAN - ELECTRICAL

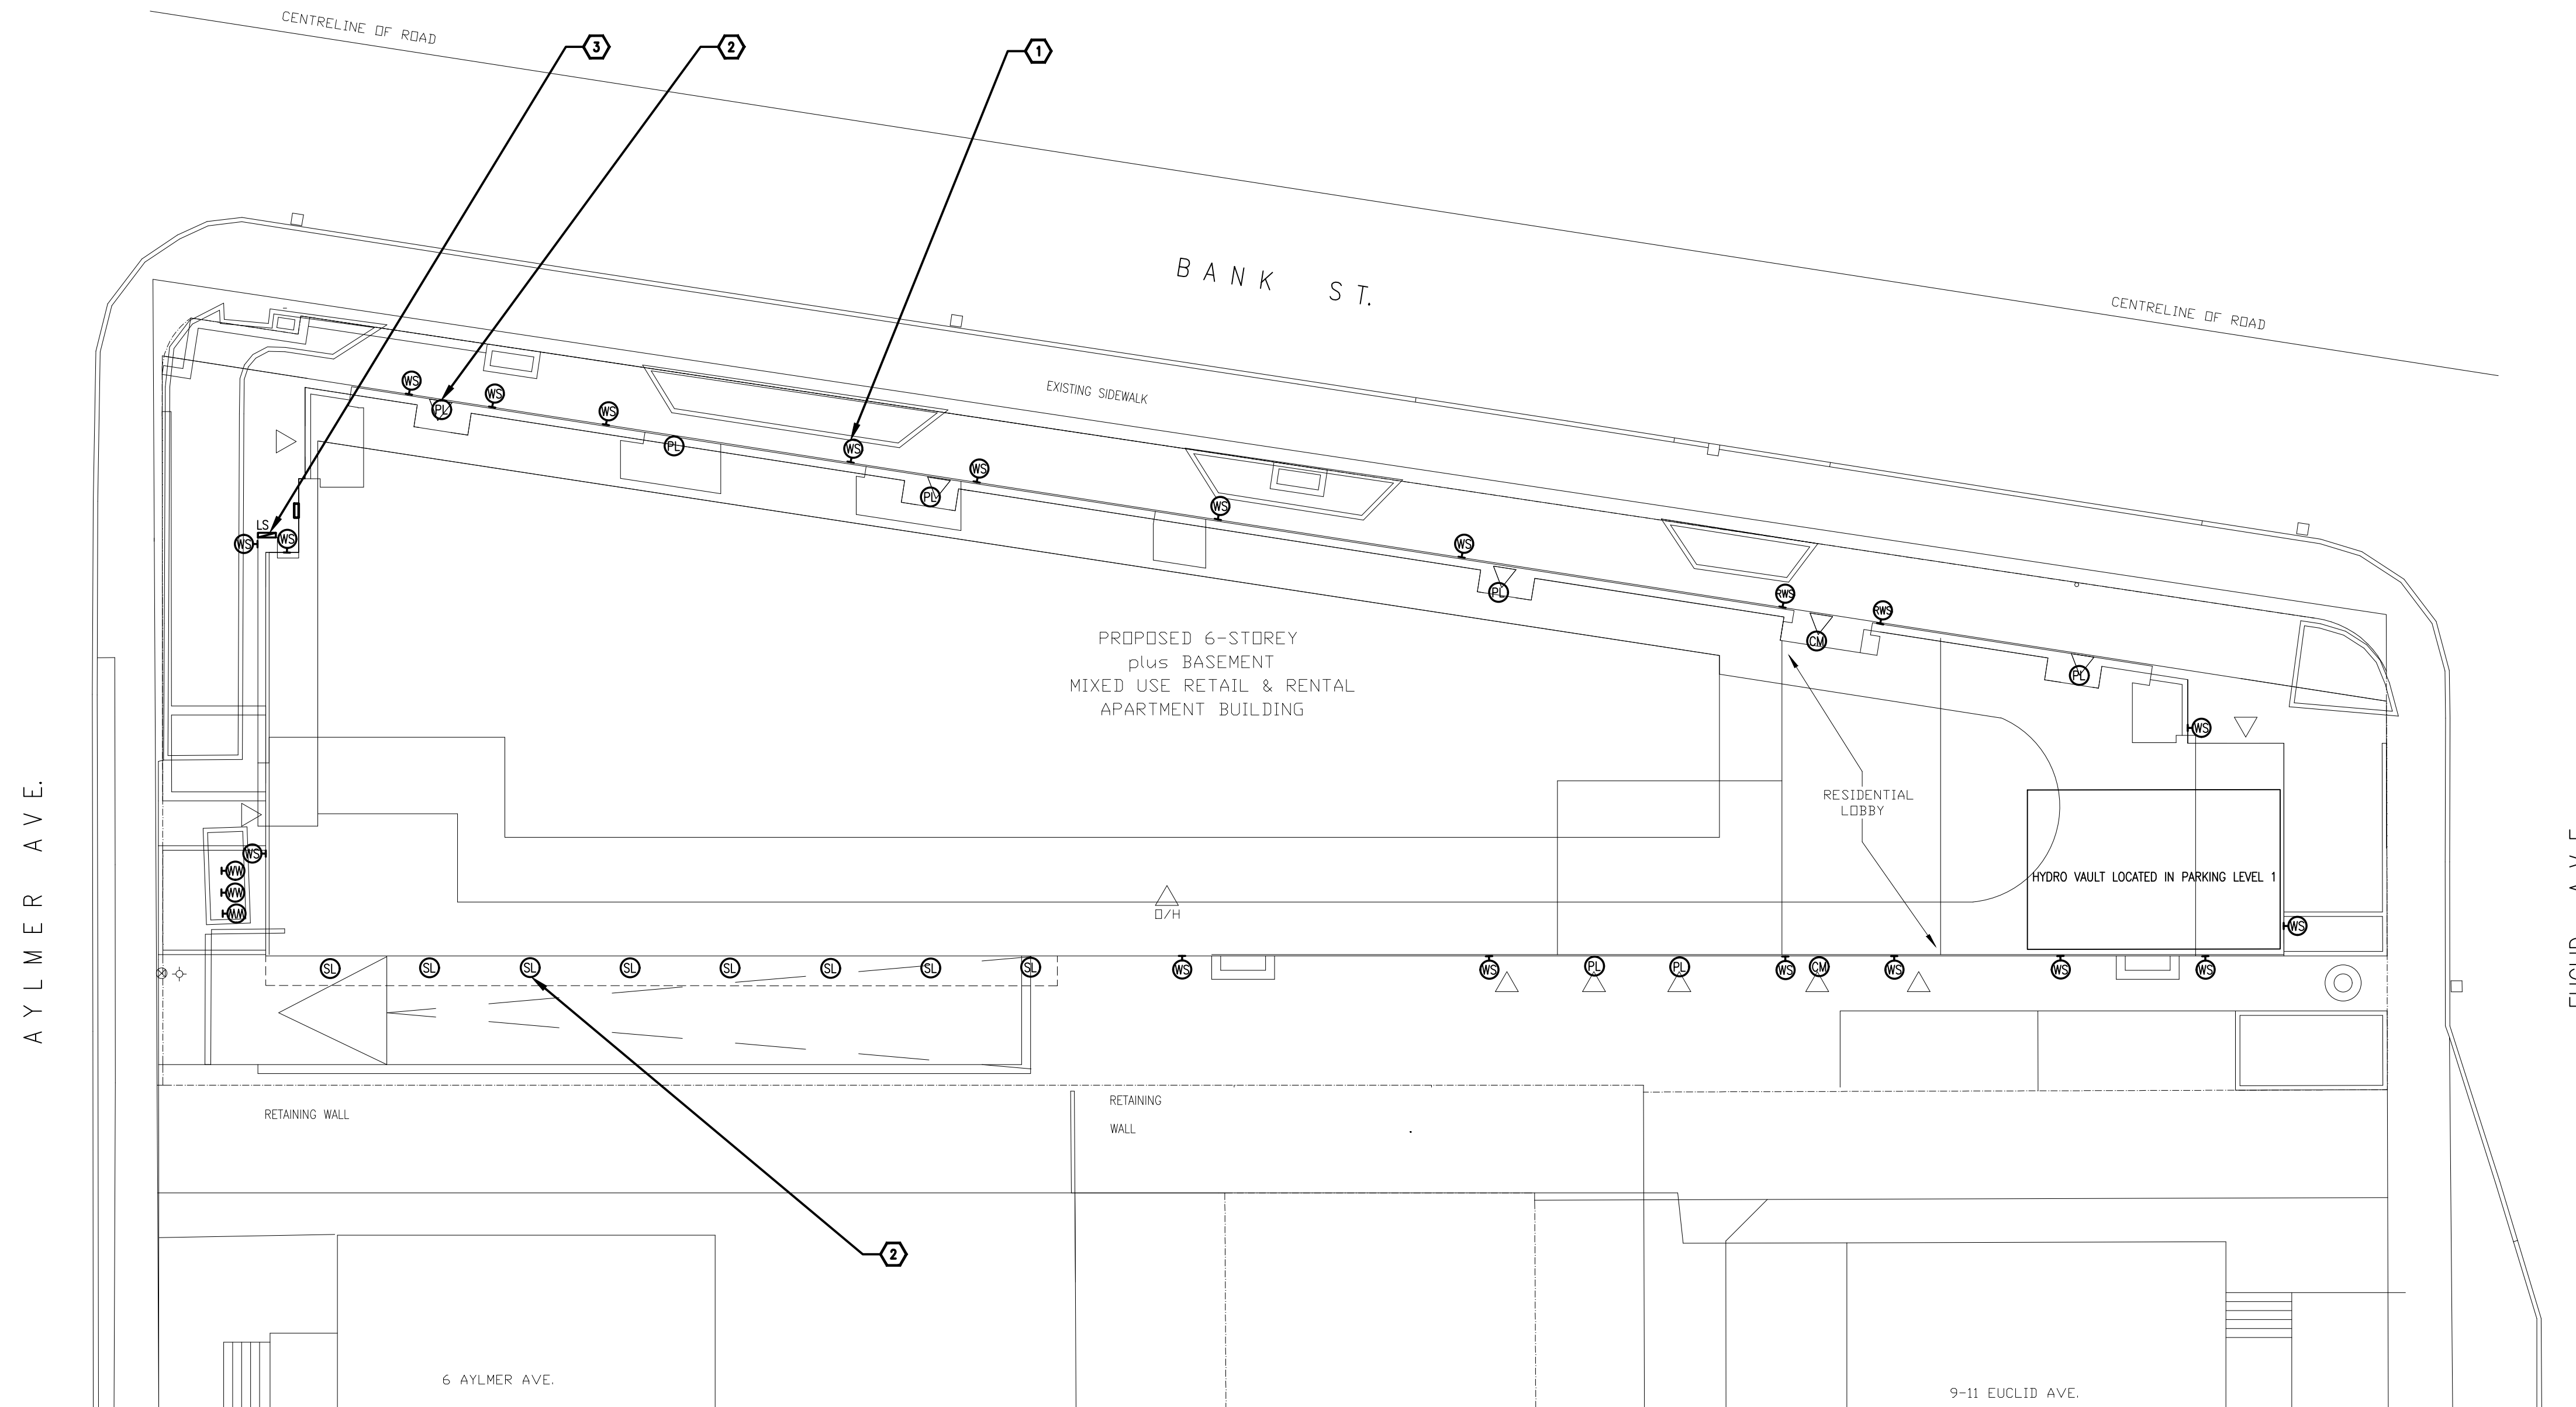

1
E1
1:150
ELECTRICAL SITE PLAN

DRAWING NOTES	
①	LIGHT FIXTURE MOUNTED ON THE WALL.
②	LIGHT FIXTURE RECESSED IN THE CANOPY.
③	LINEAR LED (SURFACE)

DRAWING LIST	
DWG	DESCRIPTION
E1	ELECTRICAL SITE PLAN, LIGHTING FIXTURE SCHEDULE, DRAWING LEGEND AND LIST

DRAWING LEGEND	
SYMBOL	DESCRIPTION
Ⓣ	DOWN LIGHT - TYPE AS SHOWN
Ⓜ	WALL SCONCE - TYPE AS SHOWN
Ⓢ	CEILING MOUNTED - TYPE AS SHOWN
Ⓡ	RECESSED WALL LIGHT - TYPE AS SHOWN
Ⓞ	GROUND LIGHT - TYPE AS SHOWN
Ⓦ	OUTDOOR WALL SCONCE
Ⓛ	LINEAR WALL LIGHT
Ⓛ	LINEAR SURFACE MOUNT LED

LIGHTING FIXTURE SCHEDULE							
TYPE	DESCRIPTION	CATALOG NUMBER	LAMPS PER FIXTURE		VOLT	MOUNTING	REMARKS
			TYPE	WATTS			
WS	TEGEL 18 WALL SCONCE	TECH LIGHTING# 7000WTEG-840-W-C-B-DO-UNV	LED	29.9/ 15.6	4000K	WALL	C/W ACCESSORIES
CM	CEILING SURFACE MOUNTED	DELTA LIGHT# BOXY XL S 93037	LED	16.8	3000K	CEILING	C/W ACCESSORIES
LS	LINEAR LED LIGHT	INTERTECK# HD15-W8-35-2010-S-A-BS-IP67	LED	4.6/FT	3500K	SURFACE	C/W ACCESSORIES
SL	RECESSED WALL LUMINAIRE	WE-EF# QR354 LED	LED	6	3000K	WALL	C/W ACCESSORIES
PL	SQUARE DOWNLIGHT	CONTRASTE# UR4J	LED	15	3500K	RECESSED	C/W ACCESSORIES
HW	EXTERIOR LED LIGHT	ECOSENSE# F80 SINGLE	LED	11.5	3500K	GROUND	C/W ACCESSORIES
RWS	OUTDOOR WALL SCONCE	TECH LIGHTING# 7000WASP-930-36-D-H-UNV-S	LED	48	3500K	WALL	C/W ACCESSORIES
LW	LINEAR WALL LIGHT	INTERTECK# VSPLASYW-TMC-HLO-LED-80-35-FT-120	LED	10	3500K	WALL	C/W ACCESSORIES

- NOTES:
- PROVIDE ALL LIGHT FIXTURE C/W ALL REQUIRED ACCESSORIES FOR FINAL INSTALLATION.
 - LIGHT FIXTURE EQUAL IN PERFORMANCE AND AESTHETICS ARE ACCEPTED.

Client

DATE	REVISION	REF
2019-12-04	ISSUED FOR SITE PLAN	-

THE ENGINEER WAIVES ANY AND ALL RESPONSIBILITY AND LIABILITY FOR PROBLEMS WHICH ARISE FROM FAILURE TO FOLLOW THESE PLANS, SPECIFICATIONS AND THE DESIGN INTENT THEY CONVEY, OR FOR PROBLEMS WHICH ARISE FROM OTHER FAILURE TO OBTAIN AND / OR FOLLOW THE ENGINEER'S GUIDANCE WITH RESPECT TO ANY ERRORS, OMISSIONS, INCONSISTENCIES, AMBIGUITIES OR CONFLICTS WHICH ARE ALLEGED.

THIS DRAWING IS THE PROPERTY OF GOODKEY WEEDMARK & ASSOCIATES LIMITED AND ALL COPYRIGHTS ARE RESERVED. NO USE OF THIS DRAWING MAY BE MADE WITHOUT EXPRESS WRITTEN CONSENT.

DO NOT SCALE DRAWINGS

L'INGÉNIEUR DÉCLINE TOUTE RESPONSABILITÉ DÉCOULANT DE PROBLÈMES FAISANT SUITE AU NON RESPECT DES PLANS, DES SPÉCIFICATIONS ET DE L'INTENTION DU CONCEPT OÙ ILS INDIQUENT OU DE TOUTES LES PROBLÈMES POUVANT RÉSULTER DU DÉFAUT D'OBTENIR ET / OU DE SUIVRE LES CONSEILS DE L'INGÉNIEUR EN CE QUI CONCERNE LES ERREURS, OMISSIONS, INCONSISTENCES, AMBIGUITÉS OU CONFLITS ALLÉGUÉS.

CE Dessin EST LA PROPRIÉTÉ LITTÉRAIRE DE GOODKEY WEEDMARK & ASSOCIATES LIMITED ET TOUTS LES DROITS SONT RÉSERVÉS. L'UTILISATION EST INTERDITE SANS LE CONSENTEMENT ÉCRIT DE L'AUTEUR.

NE PAS MESURER LES DESSINS À L'ÉCHELLE

Goodkey Weedmark
Consulting Engineers

GOODKEY WEEDMARK & ASSOCIATES LIMITED
1688 Woodward Dr. Ottawa Ontario Canada K2C 3R8
613 727-5111 Voice
613 727-5115 Fax
www.gweal.com Web

Project north
Nord du projet

Seal/Sciau

Project/Projet
BANK AND ALYMER - MIXED USE LOW RISE BUILDING
1050 & 1060 BANK STREET

Drawing title/Titre du dessin
ELECTRICAL SITE PLAN

Scale Échelle	AS NOTED	Project no./No. du projet 2019-552
Design by Conçu par	D.VYAS	Drawing/Dessein
Drawn by Dessiné par	L.ALI	E1
Reviewed by Examiné par	D.VYAS	
Date Date	DECEMBER 2019	Revision no: Acad file/Fichier:

OF 1