

Copyright Reserved

The Contractor shall verify and be responsible for all dimensions. DO NOT scale the drawing - any errors or omissions shall be reported to Stantec without delay.  
The Copyrights to all designs and drawings are the property of Stantec. Reproduction or use for any purpose other than that authorized by Stantec is forbidden.

Legend

- PROPOSED WATERMAIN
- PROPOSED VALVE AND VALVE BOX
- PROPOSED REDUCER
- PROPOSED FIRE HYDRANT
- PROPOSED WATER METER
- PROPOSED REMOTE WATER METER
- PROPOSED PRESSURE REDUCING VALVE
- PROPOSED SANITARY SEWER
- PROPOSED STORM SEWER
- PROPOSED CATCHBASIN MANHOLE
- PROPOSED CATCHBASIN
- PROPOSED SUB DRAIN AND SUBDRAIN CATCH BASIN AS PER CITY OF OTTAWA STANDARD DRAWINGS S29. PIPE TO BE HDPE PREFORMED SMOOTH INNER WALL C/W FILTER SOCK
- PROPOSED FRENCH DRAIN COLLECTION SYSTEM TO BE CONNECTED TO INTERNAL PLUMBING OUTLETING INTO CISTERN. (REFER TO MECHANICAL PLAN FOR DETAILS)
- PROPOSED AREA DRAINS TO BE CONNECTED TO INTERNAL PLUMBING OUTLETING INTO CISTERN. (REFER TO ARCHITECTURAL AND MECHANICAL PLAN FOR DETAILS)
- PROPOSED DEPRESSED CURB LOCATIONS
- THERMAL INSULATION ON STORM SEWER WHERE COVER IS LESS THAN 1.5m. THERMAL INSULATION ON WATERMAIN WHERE COVER IS LESS THAN 2.4m AS PER W22.
- PROPERTY LINE

Notes

SCHEDULE OF INLET CONTROL DEVICES

AREA ID	STRUCTURE ID	TYPE	100%R HEAD (m)	100%R RELEASE RATE (L/S)
F101	STM110	108mm VERTICAL SLIDING ORIFICE	2.05	32.8
*104	STM104	230mm VERTICAL SLIDING ORIFICE	3.28	232.9
F100	TANK	150mm VERTICAL SLIDING ORIFICE	2.51	74.5
*101A	STM101	380mm VERTICAL SLIDING ORIFICE	3.55	534.6

\* ICDS THAT REQUIRE REPLACEMENT

1. PROPOSED AREA DRAINS TO BE CONNECTED TO INTERNAL PLUMBING OUTLETING INTO CISTERN. (REFER TO ARCHITECTURAL AND MECHANICAL PLAN FOR DETAILS)

Revision	By	Appd.	YY.MM.DD	
2	REVISED AS PER CITY COMMENTS	MJS	DT	20.10.07
1	REVISED AS PER CITY COMMENTS	MJS	DT	20.05.15
0	ISSUED TO CITY FOR SPA	MJS	DT	20.01.09


File Name:	MJS	KS	MJS	19.09.23
160401510-D8	Dwn.	Chkd.	Dgn.	YY.MM.DD

Permit-Seal

Client/Project  
SELECTION GROUP INTERNATIONAL INC.  
2400 BOUL. DANIEL JOHNSON  
LAVAL, QUEBEC  
H7T 3A4  
1357 BASELINE ROAD  
OTTAWA, ON, CANADA

Title  
SITE SERVICING PLAN

Project No.	Scale	Sheet	Revision
160401510	0 2.5 7.5 12.5m 1:250		
Drawing No.			

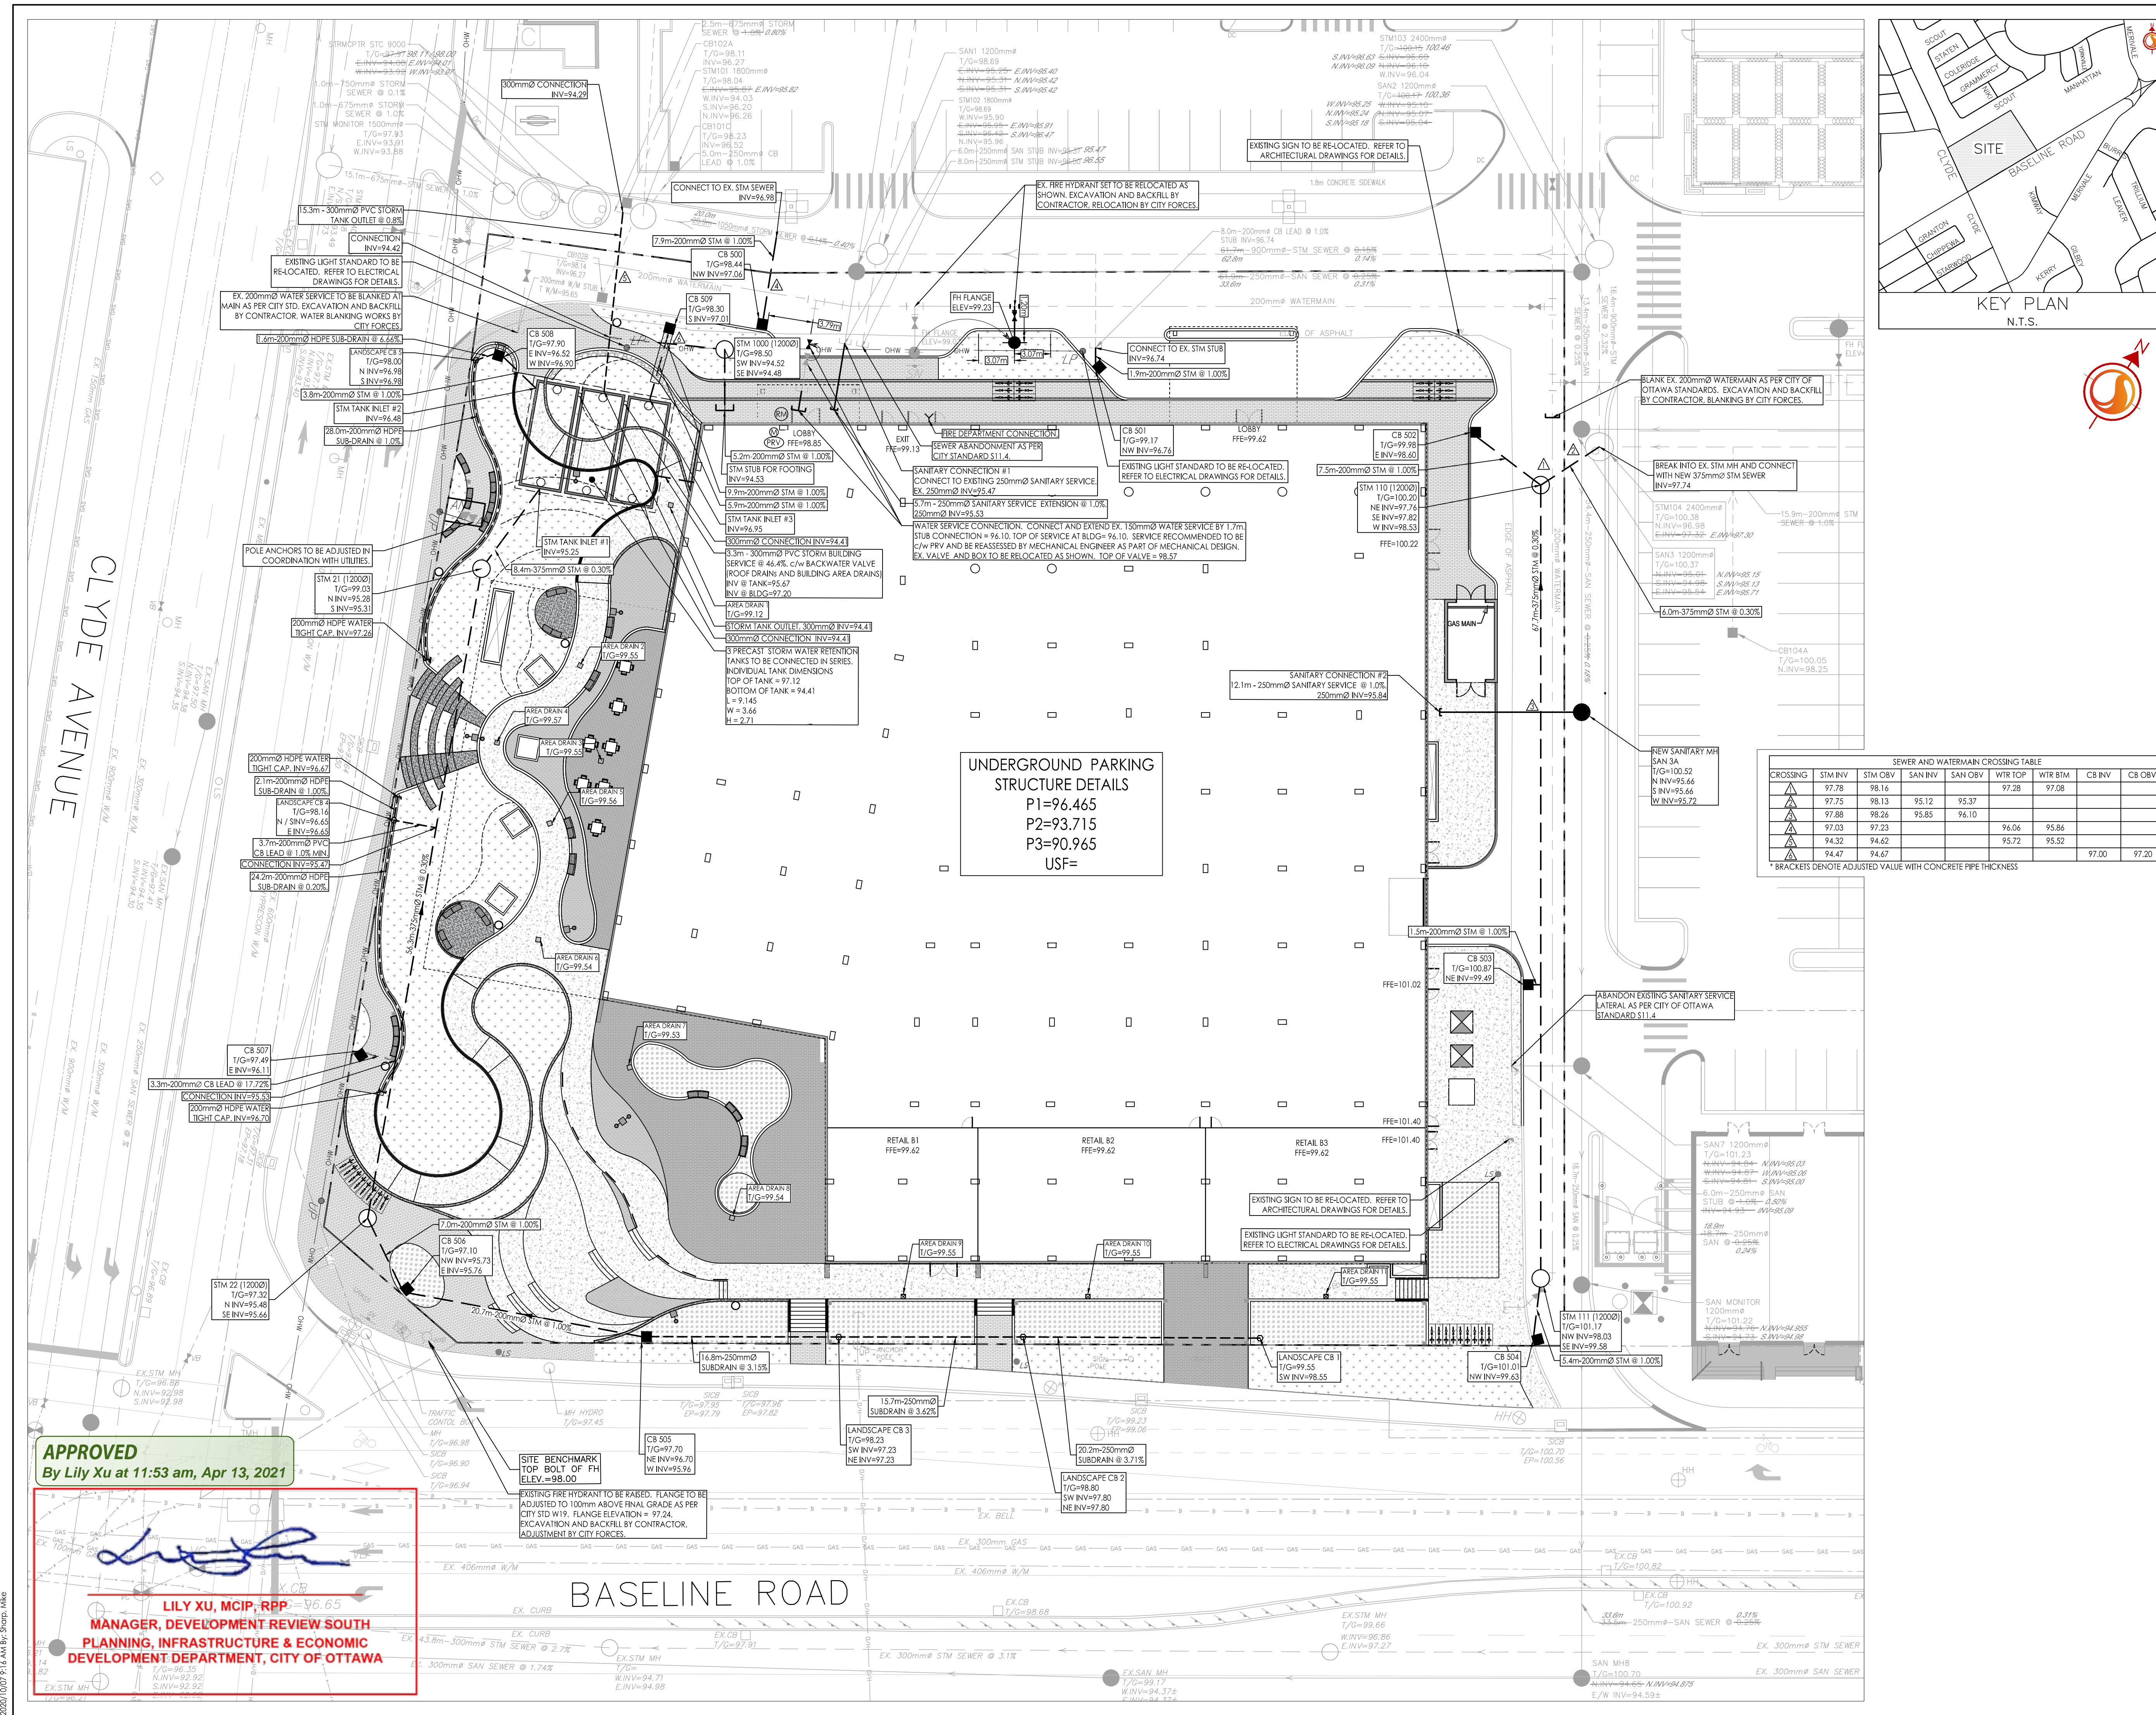

**APPROVED**  
By Lily Xu at 11:53 am, Apr 13, 2021

**LILY XU, MCIP, RPP = 96.65**  
MANAGER, DEVELOPMENT REVIEW SOUTH  
PLANNING, INFRASTRUCTURE & ECONOMIC  
DEVELOPMENT DEPARTMENT, CITY OF OTTAWA

2020/10/05 09:14 AM S:\Design\Drawings\160401510\SSP-D8.dwg  
 ORIGINAL SHEET ARCH-D