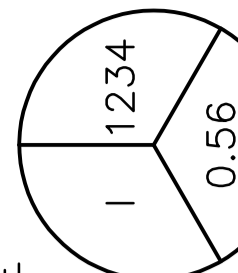



EXISTING DRAINAGE PATTERN LEGEND

← EXISTING DRAINAGE

DRAINAGE PLAN LEGEND

DRAINAGE AREA
 AREA (sq.m)
 5 YEAR RUNOFF COEFFICIENT

KEY PLAN

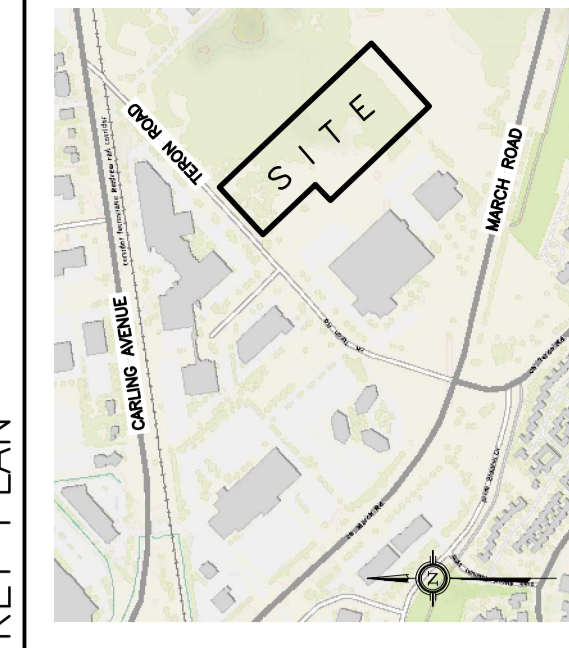


No.	DATE	REVISION
4	JUL 13-20	RE-ISSUED FOR APPROVAL
3	MAY 11-20	RE-ISSUED FOR APPROVAL
2	FEB 13-20	ISSUED FOR APPROVAL
1	FEB 11-20	ISSUED FOR COORDINATION

D. B. GRAY ENGINEERING INC.
 Stormwater Management - Grading & Drainage - Sewer & Sanitary Sewers - Erosion
 700 Long Point Circle
 Ottawa, Ontario
 613-425-8044
 dgray@dbgrayengineering.com

**PROPOSED
 1 STOREY
 INDUSTRIAL WAREHOUSE
 1243 TERON ROAD
 OTTAWA, ONTARIO**

**EXISTING
 DRAINAGE PATTERN AND
 DRAINAGE PLAN**

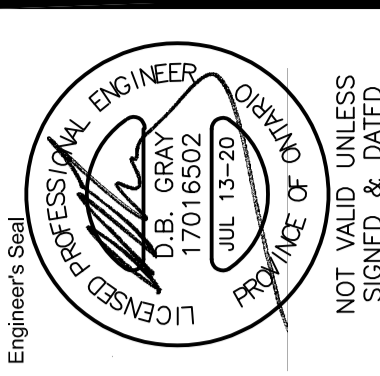Engineer's Seal

 Drawn: D.B.G.
 Hor. Scale: 1:400
 Vert. Scale:
 Date: OCT 18-19
 Job No.: 19057
 Drawing No.: **C-6**
 of **6**
 NOT VALID UNLESS SIGNED & DATED

