

GENERAL NOTES

1. CONTRACTOR MUST VERIFY ALL JOB DIMENSIONS, DIMENSIONS, OWNERS AND APPROVED DIMENSIONS. DIMENSIONS SHALL BE OBTAINED BEFORE PROCEEDING WITH WORK.
2. ALL DRAWINGS & SPECIFICATIONS ARE INSTRUMENTS OF PROFESSIONAL SERVICE. THEY ARE NOT TO BE REPRODUCED OR COPIED IN ANY MANNER WITHOUT THE WRITTEN PERMISSION OF THE ARCHITECT.

No.	Revision/Issue	Date
6	ISSUED FOR SITE PLAN	FEB 21

PROJECT MANAGER
HARSH GUPTA
 B. ARCH
 1066 PLANTÉ DRIVE
 OTTAWA, ON K1V 9T6
 T: 613-737-5939
 F: 613-812-1726
 C: 613-866-2984
 E: jessica@dpbplanco.com

PLANNER
jd planning
 + project management
 41 Rideau Ferry Road,
 Lombardy, ON K0G 1L0
 T: 613 812 1726
 E: jessica@dpbplanco.com

CLIENT
**ANNIS, OSULLIVAN,
 VOLLEBECK LTD.**
 14 Concourse Gate,
 Suite 500, K2E 7S6
 Montreal, ON K4M 1A7
 Tel: (613) 692-8662
 Fax: (613) 727-1079
 Email: haper@annid.com

TRANSPORTATION ENGINEER
**D. J. Halpeny &
 Associates Ltd.**
 P. O. Box 774,
 Montreal, QC H3T 1K2
 Tel: (514) 393-8888
 Fax: (514) 393-1945
 Email: dhalpeny@dpbplanco.com

STRUCTURAL CONSULTANT
DESIGN & SYSTEMS ASSOCIATES INC.
 3332 Conroy Ave S48
 Ottawa, ON K2H 5A8
 Phone: (613) 722-5168
 Fax: 613 729 9500
 Email: havel@designsystems.ca

MENSTRUATION CONSULTANT
**Janice B. Lemox &
 Associates Inc.**
 3332 Conroy Ave S48
 Ottawa, ON K2H 5A8
 Phone: (613) 722-5168
 Email: jle@jbl.ca

MECHANICAL & ELECTRICAL CONSULTANT
LRJ ENGINEERING INC.
 548 Woodbine Avenue
 Unit 100
 Markham, ON L3R 1X7
 Tel: (905) 477-0119
 Fax: (905) 477-0119
 Email: info@lrj.ca

MICROCLIMATE & ELECTRICAL CONSULTANT
CHIARELLI KORBEL ENGINEERING LTD.
 1000 Kennedy Road
 Markham, ON L3R 9X7
 Tel: (905) 477-0119
 Fax: (905) 477-0119
 Email: info@ckel.com

ARCHITECT
VECTOR DESIGN ARCHITECTS
 14 STRATHBURY STREET,
 OTTAWA, ONTARIO K2G 5N8
 TELEPHONE: (613) 421-9806
 EMAIL: vecorcd@gmail.com

PROJECT AND LOCATION
**HERITAGE CENTRE -
 HINDU TEMPLE - PHASE 2,**
 4835 BANK ST., OTTAWA, ON
 P1N 0A3 26-0011

TITLE OF DRAWING
**FLOOR PLAN -
 LEVEL 1 & 2**


JOB NUMBER
 17033

DATE
 2019 05

SCALE
 AS SHOWN

DWG NUMBER
 A101

DESIGNED BY
 SJK

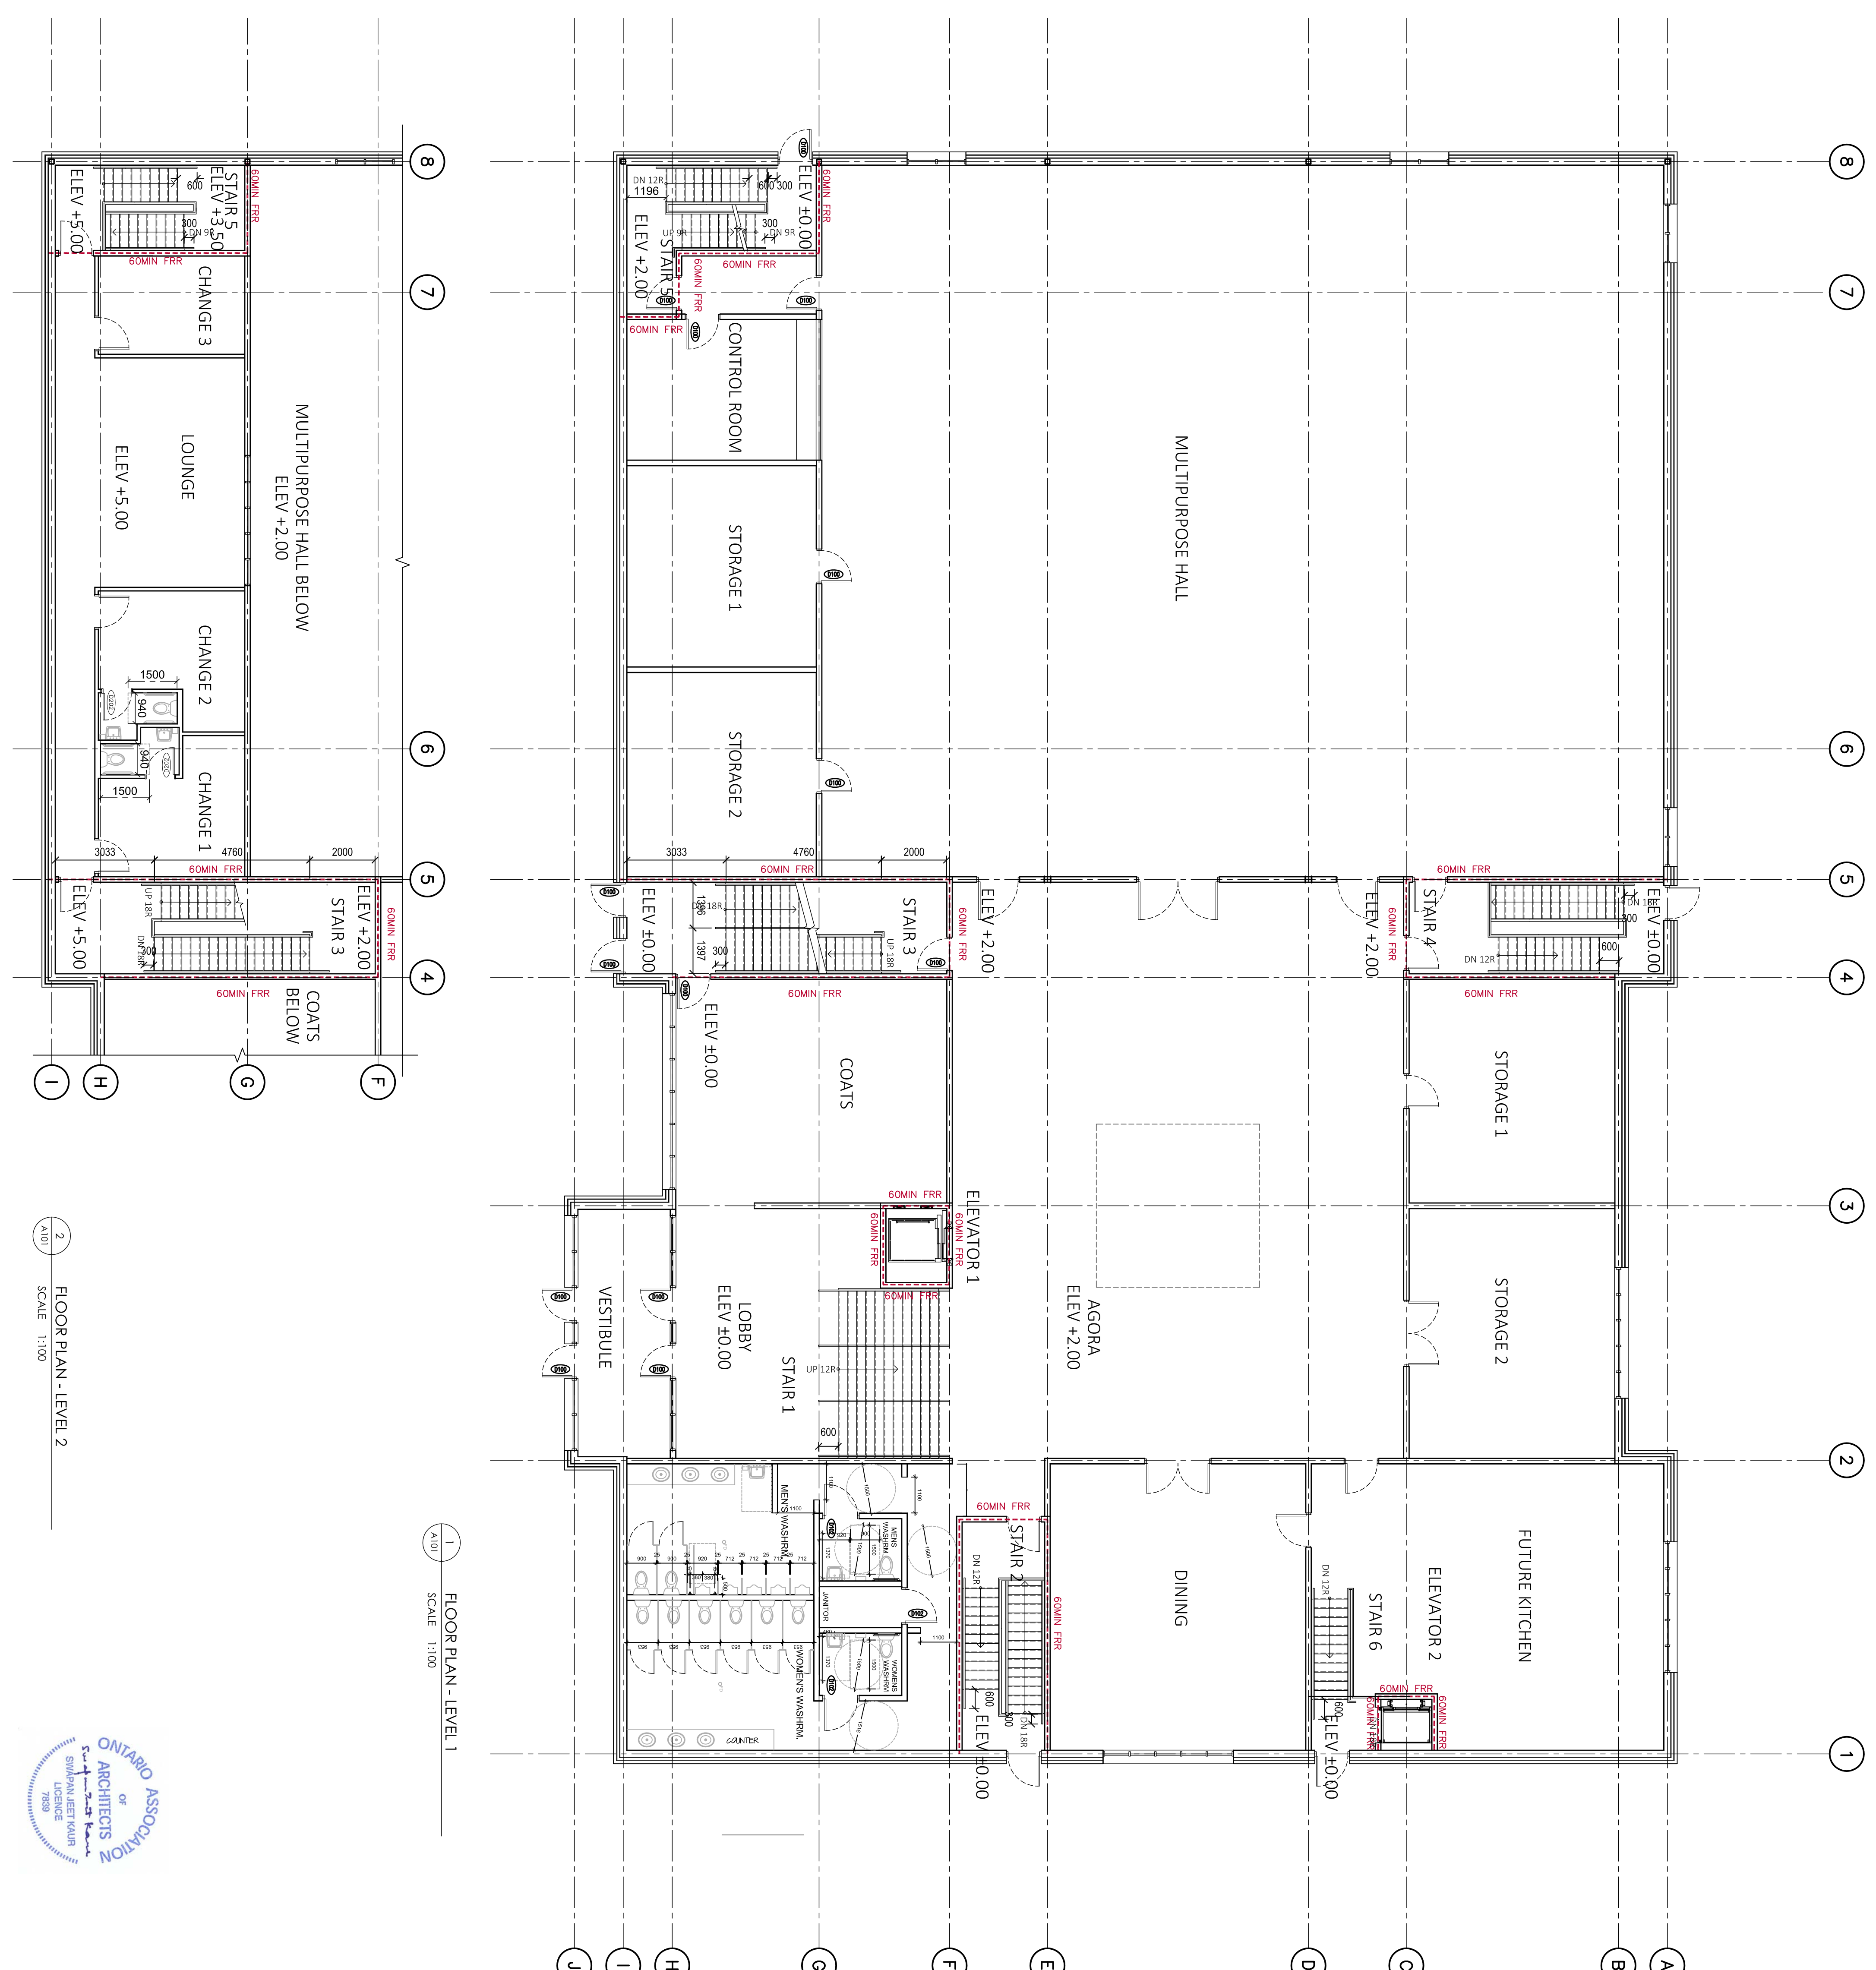

1 FLOOR PLAN - LEVEL 1
 SCALE: 1:100

2 FLOOR PLAN - LEVEL 2
 SCALE: 1:100

