

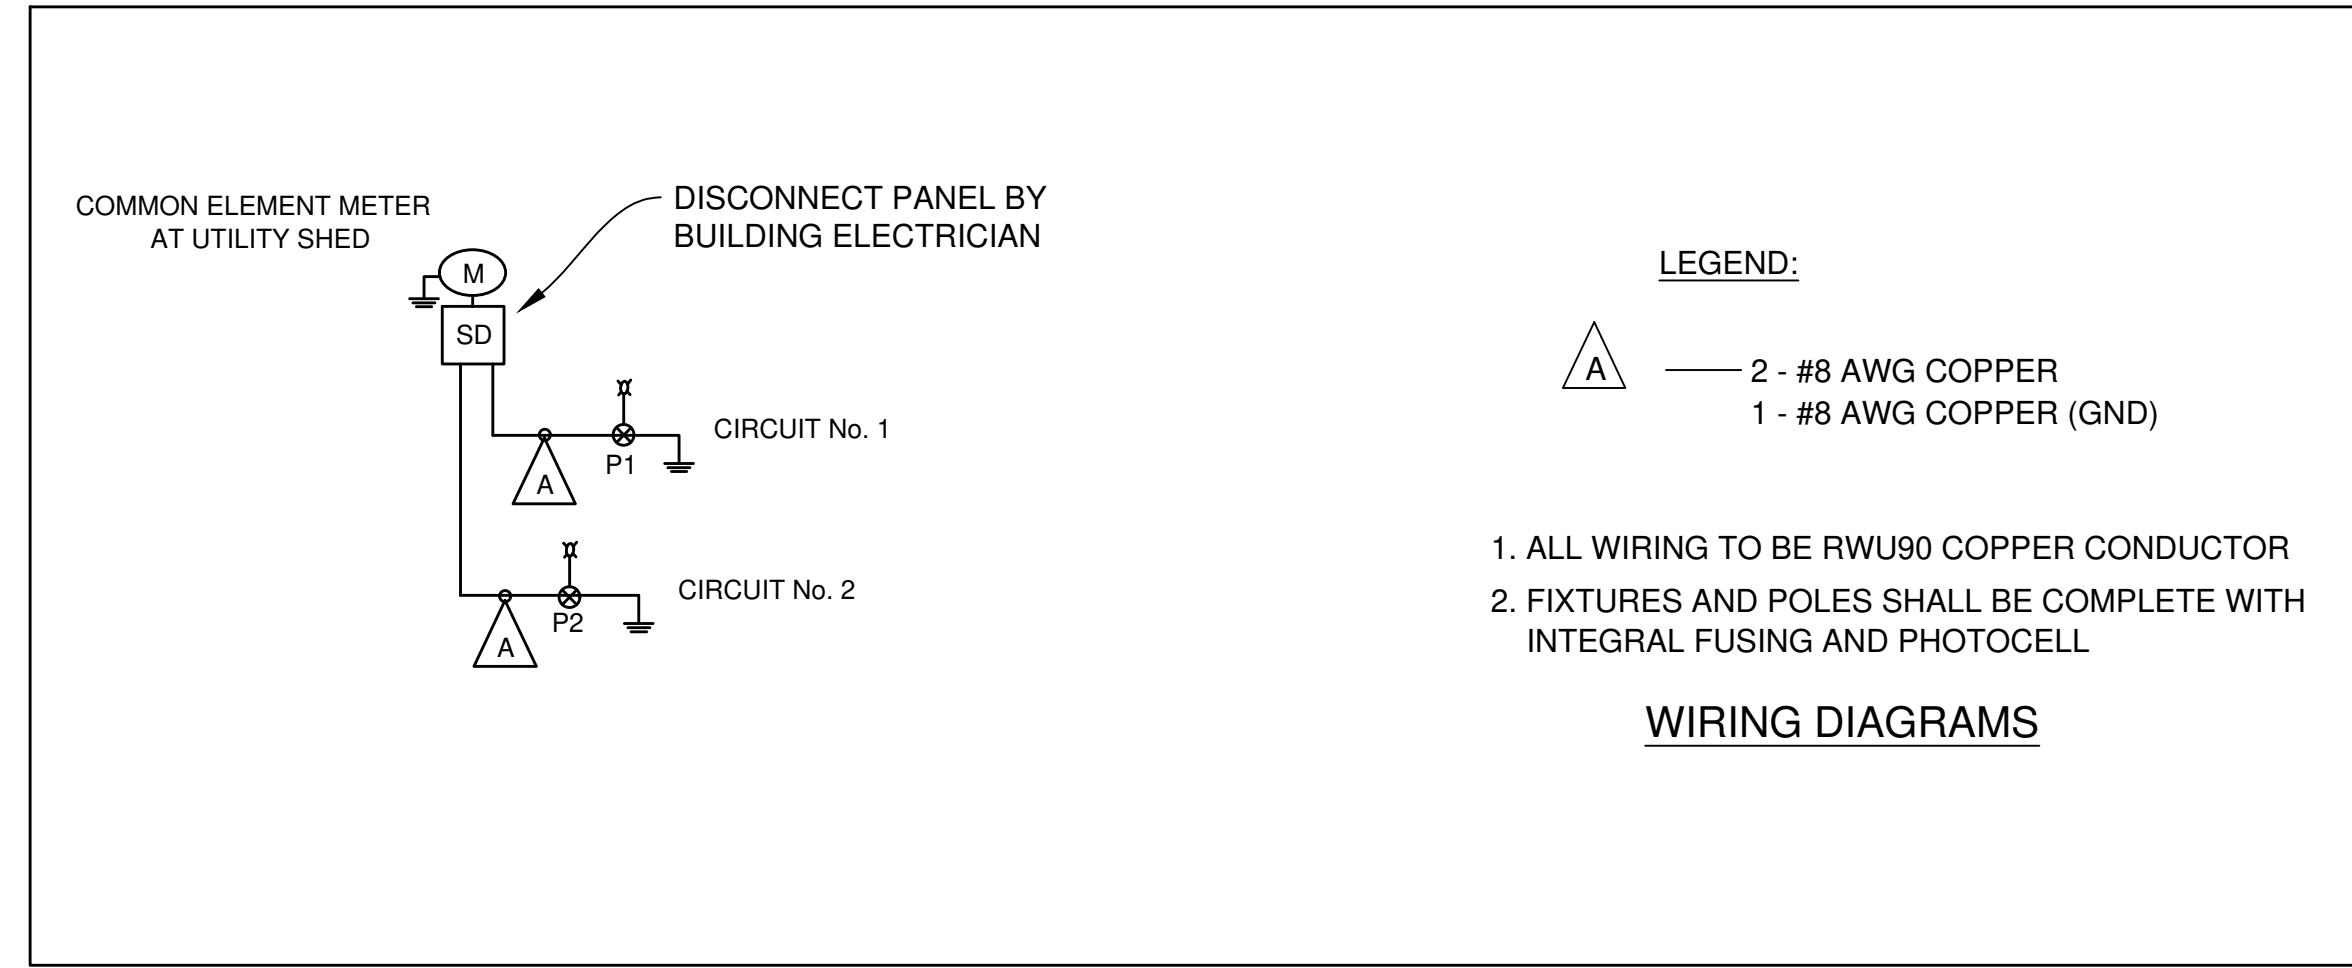


*Andrew McCreight*  
**ANDREW MCCREIGHT**  
 MANAGER (A), DEVELOPMENT REVIEW CENTRAL  
 PLANNING, REAL ESTATE & ECONOMIC DEVELOPMENT  
 DEPARTMENT, CITY OF OTTAWA

**APPROVED**  
 By Andrew McCreight at 8:27 am, Aug 10, 2023

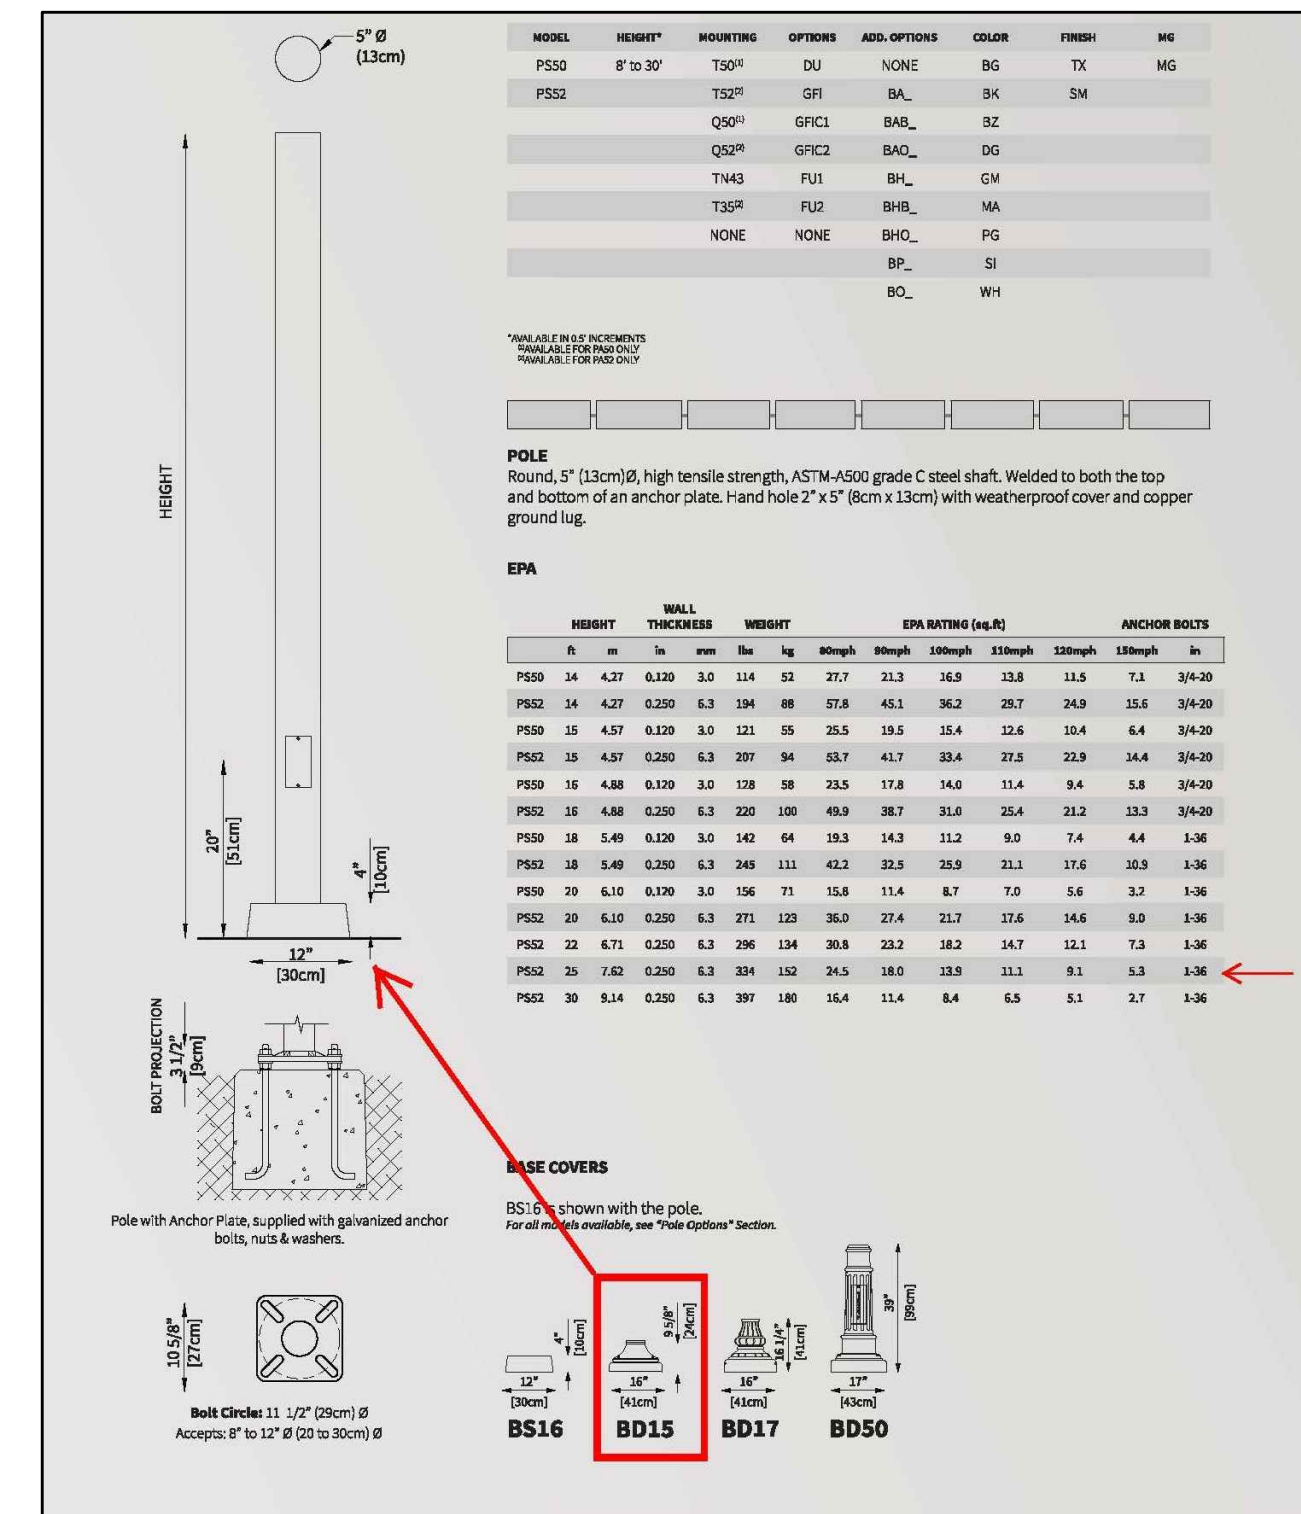

BILL OF MATERIALS	
CATALOG No.	DESCRIPTION
CM019T4C-FGC-2HS-60-3K-120-PT-BK-TX	60 WATT LED, TYPE II DISTRIBUTION, COACH STYLE LUMINAIRE (BLACK), c/w HOUSE SHIELD AS MANU. BY CYCLONE. COLOR TEMP. 3000K. LIGHT P1
CM019T4C-FGC-4HS-60-3K-120-PT-BK-TX	60 WATT LED, TYPE IV DISTRIBUTION, COACH STYLE LUMINAIRE (BLACK), c/w HOUSE SHIELD AS MANU. BY CYCLONE. COLOR TEMP. 3000K. LIGHT P2
PS52	7.6m (25') ROUND STEEL POLE, 5" DIA., BLACK IN COLOR c/w BASE COVER BD15 AS MANUFACTURED BY CYCLONE.

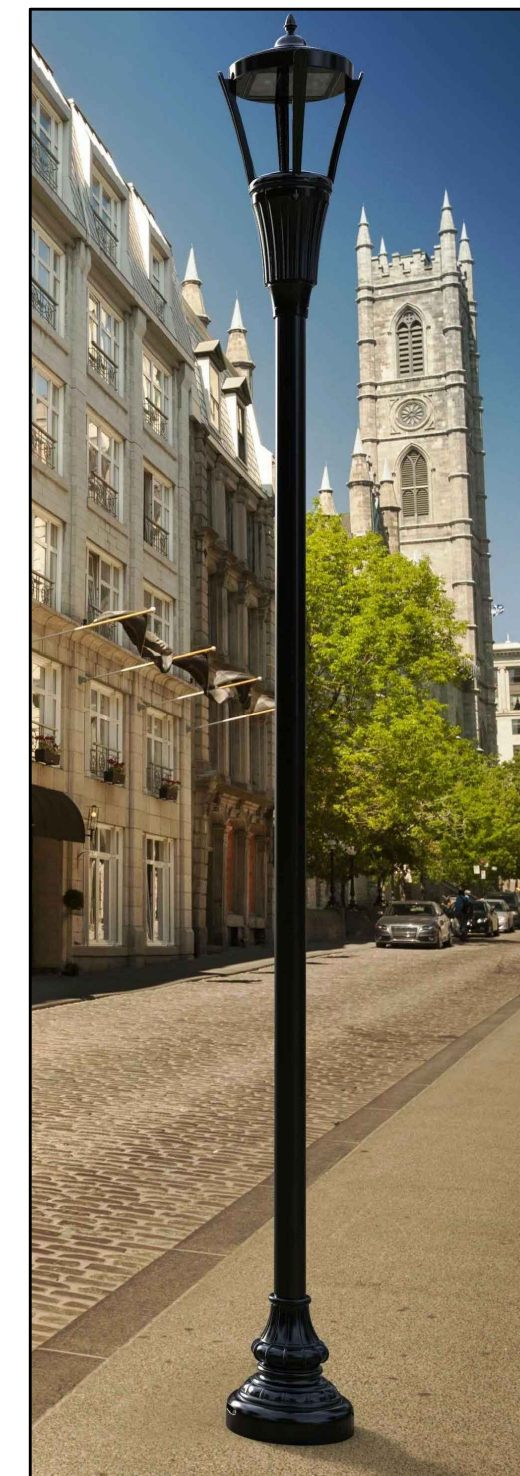

- LEGEND:**
- ☒ PROPOSED HYDRO TRANSFORMER
  - ▨ PROPOSED CONCRETE ENCASED DUCT BANK
  - PROPOSED STREET LIGHT
  - PROPOSED STREET LIGHT CABLE
  - SD PROPOSED DISCONNECT PANEL
  - PROPOSED GROUNDING
  - M PROPOSED STREET LIGHT METER
  - PROPOSED FIRE HYDRANT

- GENERAL NOTES:**
- THIS PLAN SHALL BE READ IN CONJUNCTION WITH THE COMPOSITE UTILITY PLAN AND THE CITY OF OTTAWA STANDARDS SHALL GOVERN OVER THIS DRAWING.
  - ALL WORK SHALL BE CARRIED OUT IN COMPLIANCE WITH THE ONTARIO OCCUPATIONAL HEALTH AND SAFETY ACT AND REGULATIONS FOR CONSTRUCTION PROJECTS.
  - ALL WORK AND MATERIALS TO CONFORM WITH CURRENT MINISTRY OF THE ENVIRONMENT & ENERGY OF ONTARIO, CITY OF OTTAWA AND ONTARIO PROVINCIAL STANDARDS AND SPECIFICATIONS. LOCAL UTILITY STANDARDS AND MINISTRY OF TRANSPORTATION STANDARDS WILL APPLY WHERE REQUIRED.
  - THE CONTRACTOR IS ADVISED THAT WORKS BY OTHERS MAY BE ONGOING DURING THE PERIOD OF THIS CONTRACT. THE CONTRACTOR SHALL COORDINATE CONSTRUCTION ACTIVITIES AND COORDINATION WITH ALL OTHER CONTRACTORS AND PREVENT CONSTRUCTION CONFLICTS.
  - THE INFORMATION SHOWN FOR EXISTING UTILITIES WAS PROVIDED BY OTHERS. THE CONTRACTOR IS RESPONSIBLE FOR LOCATING AND PROTECTING ALL UTILITIES DURING CONSTRUCTION.
- STREET LIGHTING NOTES**
- FOR TRENCH CROSS SECTION SEE KOLLAARD ASSOCIATES PROJECT No. 190867.
  - STREET LIGHT CABLE (IN 76mm DUCT) TO BE INSTALLED IN JOINT-USE TRENCH, WHERE APPLICABLE.
  - STREET LIGHTS SHALL BE 0.5m FROM ASPHALT WALKWAYS.

NO.	DESCRIPTION	DATE	BY
3	REVISED SITE PLAN AS PER CITY COMMENTS	4/21/2022	DAP
2	REVISED SITE PLAN AS PER CITY COMMENTS	5/7/2021	DAP
1	SUBMITTED FOR APPROVAL	6/19/2020	DAP

**REVISIONS**

**UB UTILITY BOX DESIGNS**  
 Residential + Commercial Development  
 251 Foxton Road, Toronto, Ont M6G 3R1  
 416 666 7500 dpoirier@utilitybox.ca

**CLIENT**  
**TEAK DEVELOPMENTS**  
 31 WOODVIEW CRESCENT  
 OTTAWA, ONTARIO

**PROJECT NAME**  
 6173 RENAUD ROAD  
 OTTAWA, ONTARIO

**DRAWING NAME**  
 STREET LIGHT DESIGN

	DATE:	JUNE 2020
	SCALE:	1:250
	PROJ. No:	UBD-0436
	DWG. No:	SL-1