


STORM OUTLET VIA 127 CARILLION

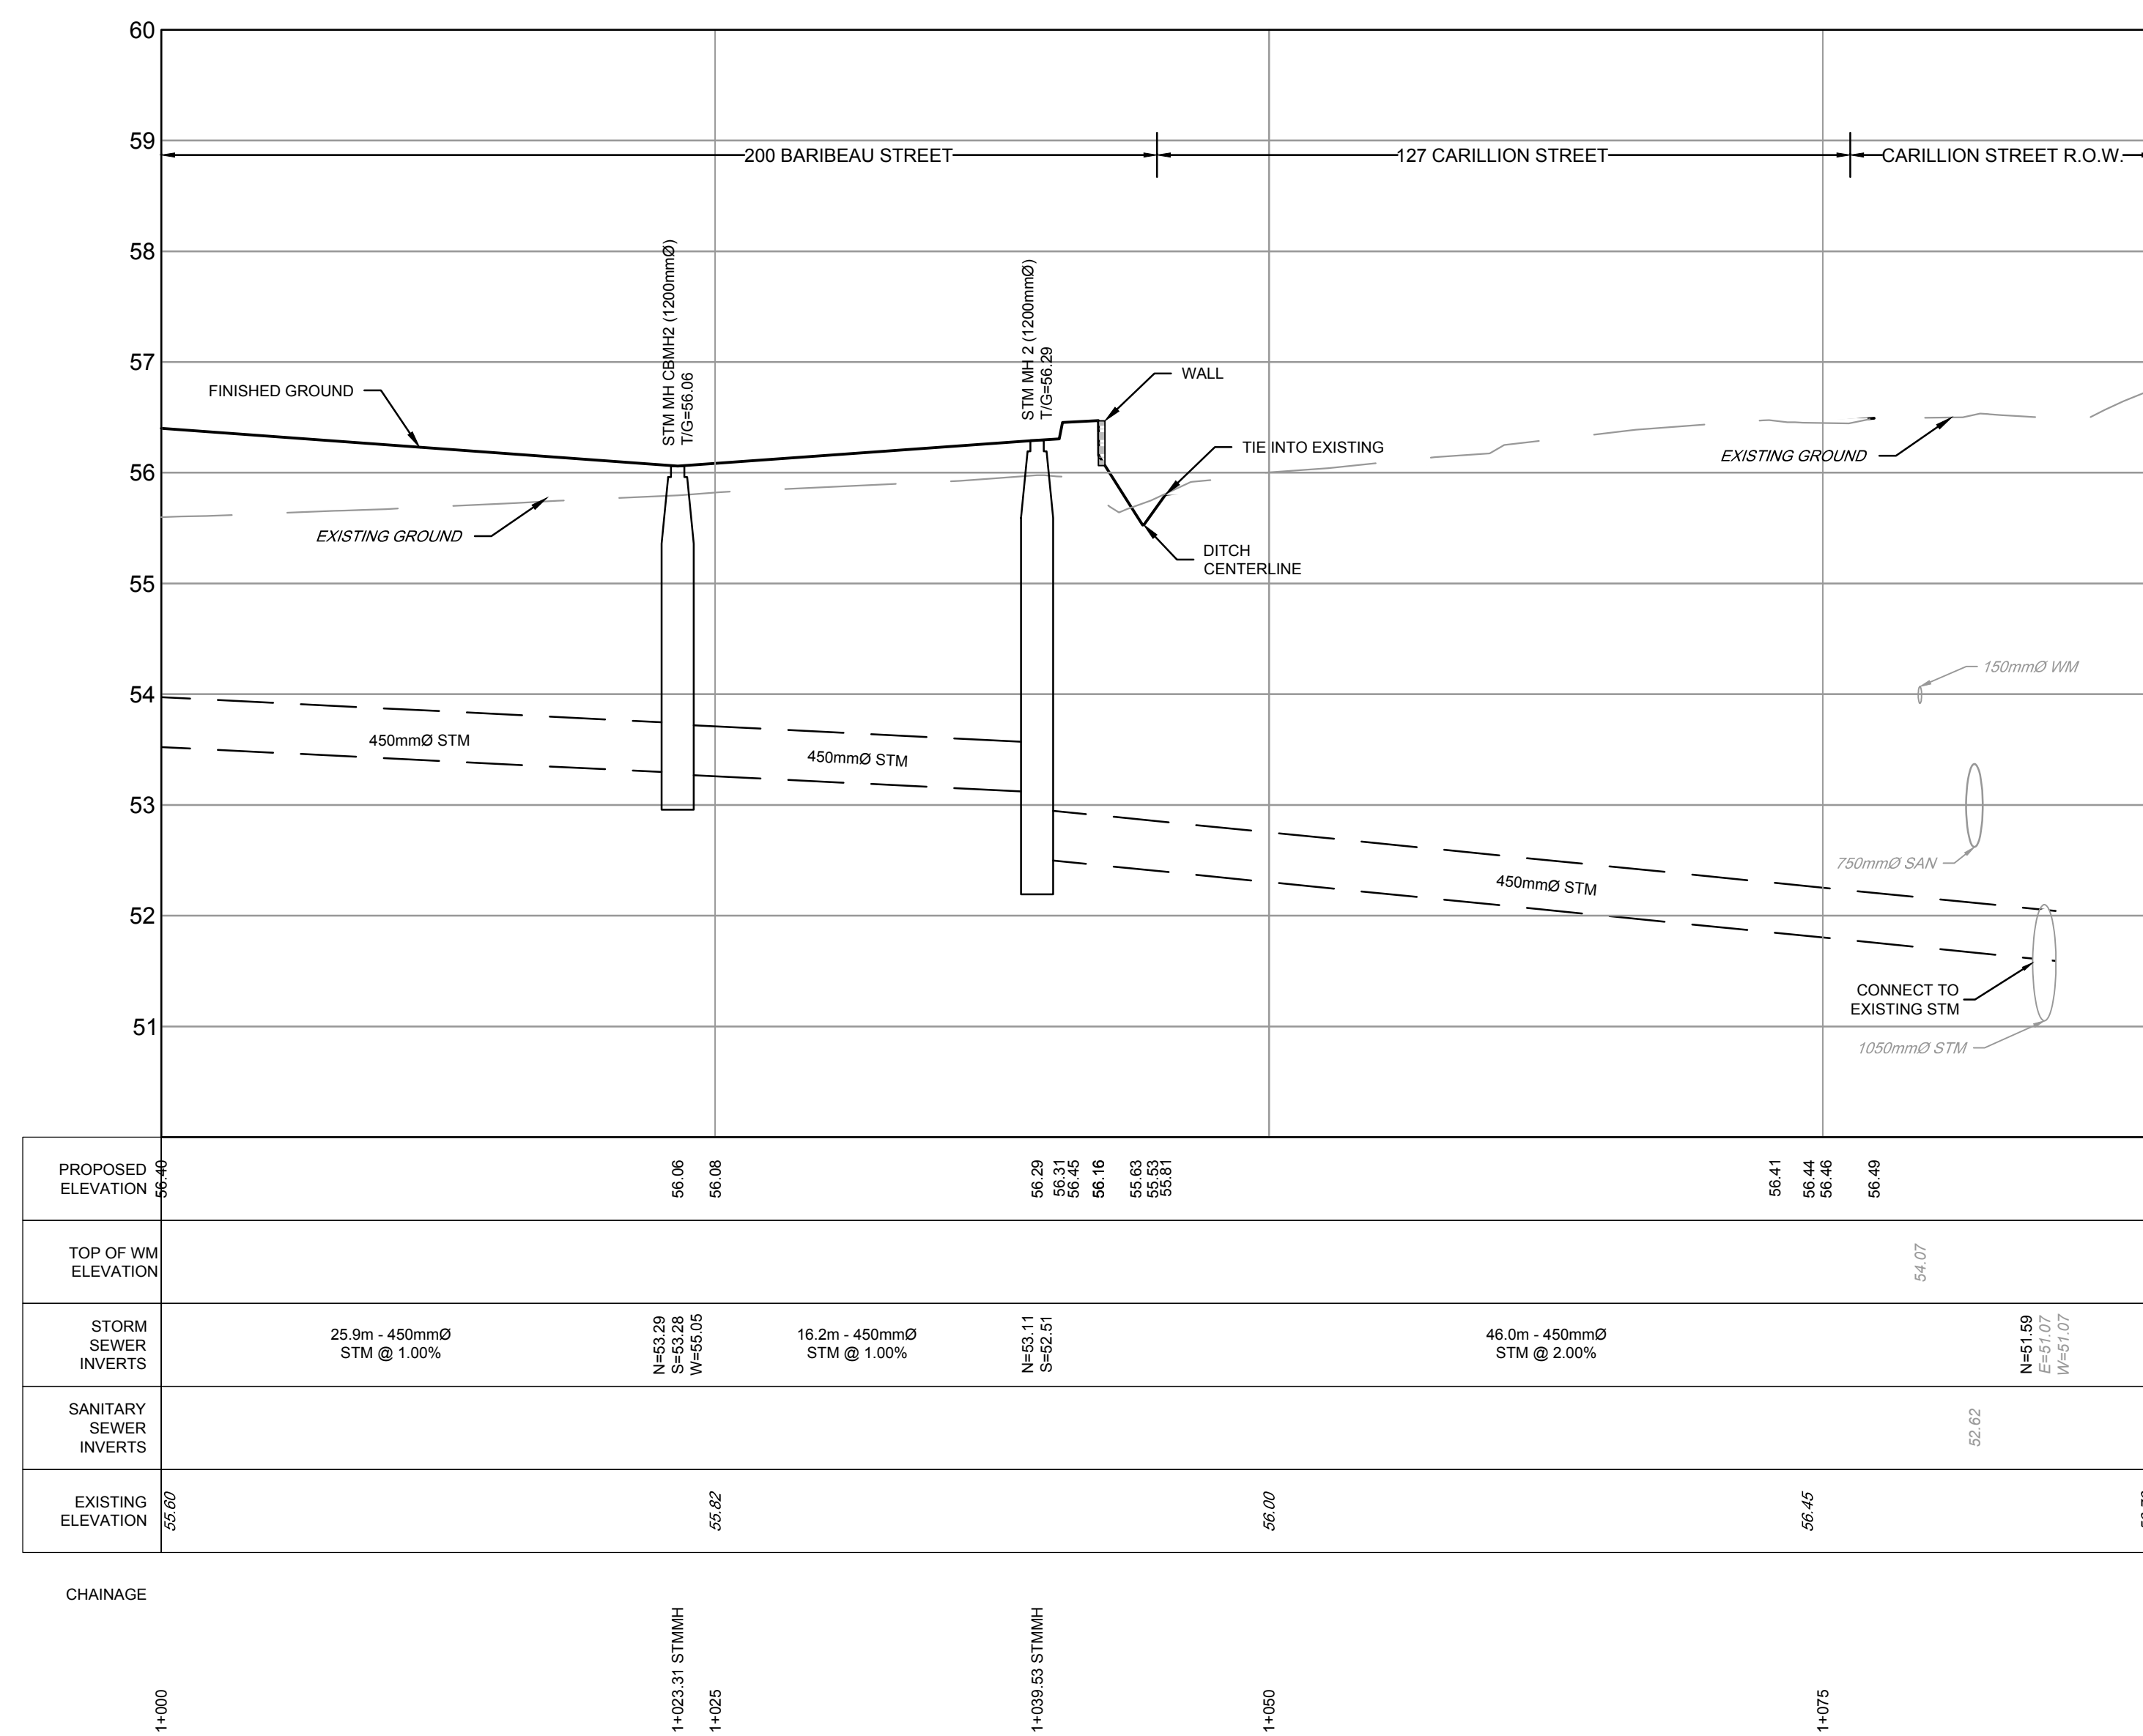

C:\Users\11068\OneDrive\Documents\119068\PR1\21_Oct 09_2024_11_26am.dwg

NOTE:
THE POSITION OF ALL POLE LINES, CONDUITS, WATERMANS, SEWERS AND OTHER UNDERGROUND AND OVERGROUND UTILITIES AND STRUCTURES IS NOT NECESSARILY SHOWN ON THE CONTRACT DRAWINGS, AND WHERE SHOWN, THE ACCURACY OF THE POSITION OF SUCH UTILITIES AND STRUCTURES IS NOT GUARANTEED. BEFORE STARTING WORK, DETERMINE THE EXACT LOCATION OF ALL SUCH UTILITIES AND STRUCTURES AND ASSUME ALL LIABILITY FOR DAMAGE TO THEM.



No.	REVISION	DATE	BY	No.	REVISION	DATE	BY
8.	UNDER DESIGN			XXX	MAB		
7.	SITE PLAN UPDATE			JUL 15/22	MAB		
6.	ISSUED FOR ECA			MAR 24/22	MAB		
5.	CITY SUBMISSION			OCT 21/21	MAB		
4.	CITY SUBMISSION			AUG 3/21	MAB		
3.	CITY SUBMISSION			JUN 8/21	MAB		
2.	CITY SUBMISSION			FEB 5/21	MAB		
1.	STORM OUTLET VIA 127 CARILLION			OCT 29/20	MAB		

SCALE	1:250	1:50
HORIZONTAL	0 2 4 6 8 10	0 0.5 1.0 1.5 2.0
VERTICAL		

DESIGN	DTD
CHECKED	LRW
DRAWN	DTD
CHECKED	LRW
APPROVED	MAB

FOR REVIEW ONLY

PROVINCE OF ONTARIO
LICENSED PROFESSIONAL ENGINEER
L.R. WILSON
100180055

PROVINCE OF ONTARIO
LICENSED PROFESSIONAL ENGINEER
M.A. BISSETT
2024.10.09

NOVATECH
Engineers, Planners & Landscape Architects
Suite 200, 240 Michael Cowpland Drive
Ottawa, Ontario, Canada K2M 1P6
Telephone (613) 254-9643
Facsimile (613) 254-5867
Website www.novatech-eng.com

CITY OF OTTAWA
DOMINION VILLAGE - 200 BARIBEAU STREET

PLAN AND PROFILE
STM OUTLET VIA 127 CARILLION
1+000 to 1+090

PROJECT No.	119068
REV	REV #9
DRAWING No.	119068-PR1