


LEGEND

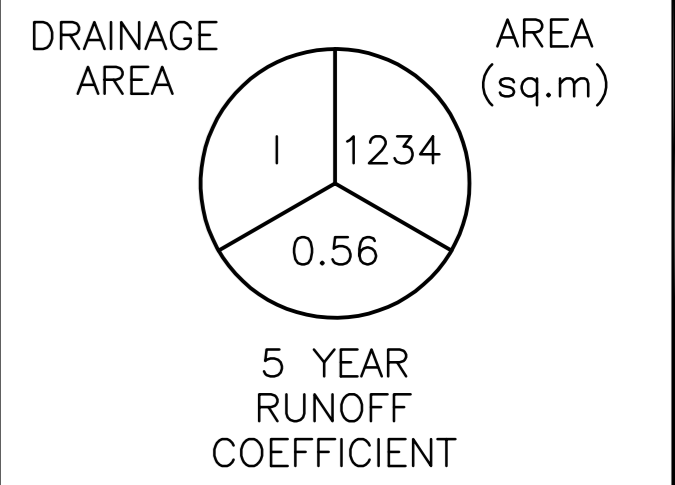

KEY PLAN




No.	DATE	REVISION
4	MAR 12-21	RE-ISSUED FOR APPROVAL
3	OCT 13-20	ISSUED FOR APPROVAL
2	APR 3-20	50% COMPLETE ISSUED FOR REVIEW & COORDINATION
1	JAN 21-20	PRELIMINARY

D. B. GRAY ENGINEERING INC.
Stormwater Management - Grading & Drainage - Storm & Sanitary Sewers - Watermain
 700 Long Point Circle 613-425-8044
 Ottawa, Ontario d.gray@dbgrayengineering.com

Project
PROPOSED THREE STOREY APARTMENT BUILDING
DUNBAR COURT
 OTTAWA, ONTARIO

Drawing Title
DRAINAGE PLAN

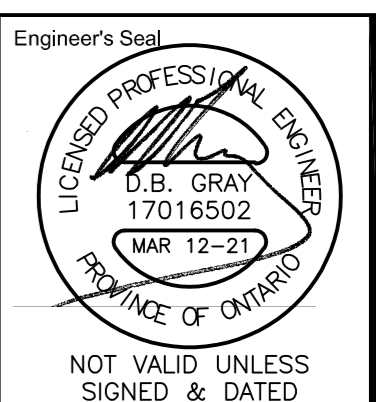

Drawn D.B.G.
 Hor. Scale 1:100
 Vert. Scale
 Date JAN 21-20
 Job No. 19062

Drawing No.
C-9
 of 9