


CLIENT:

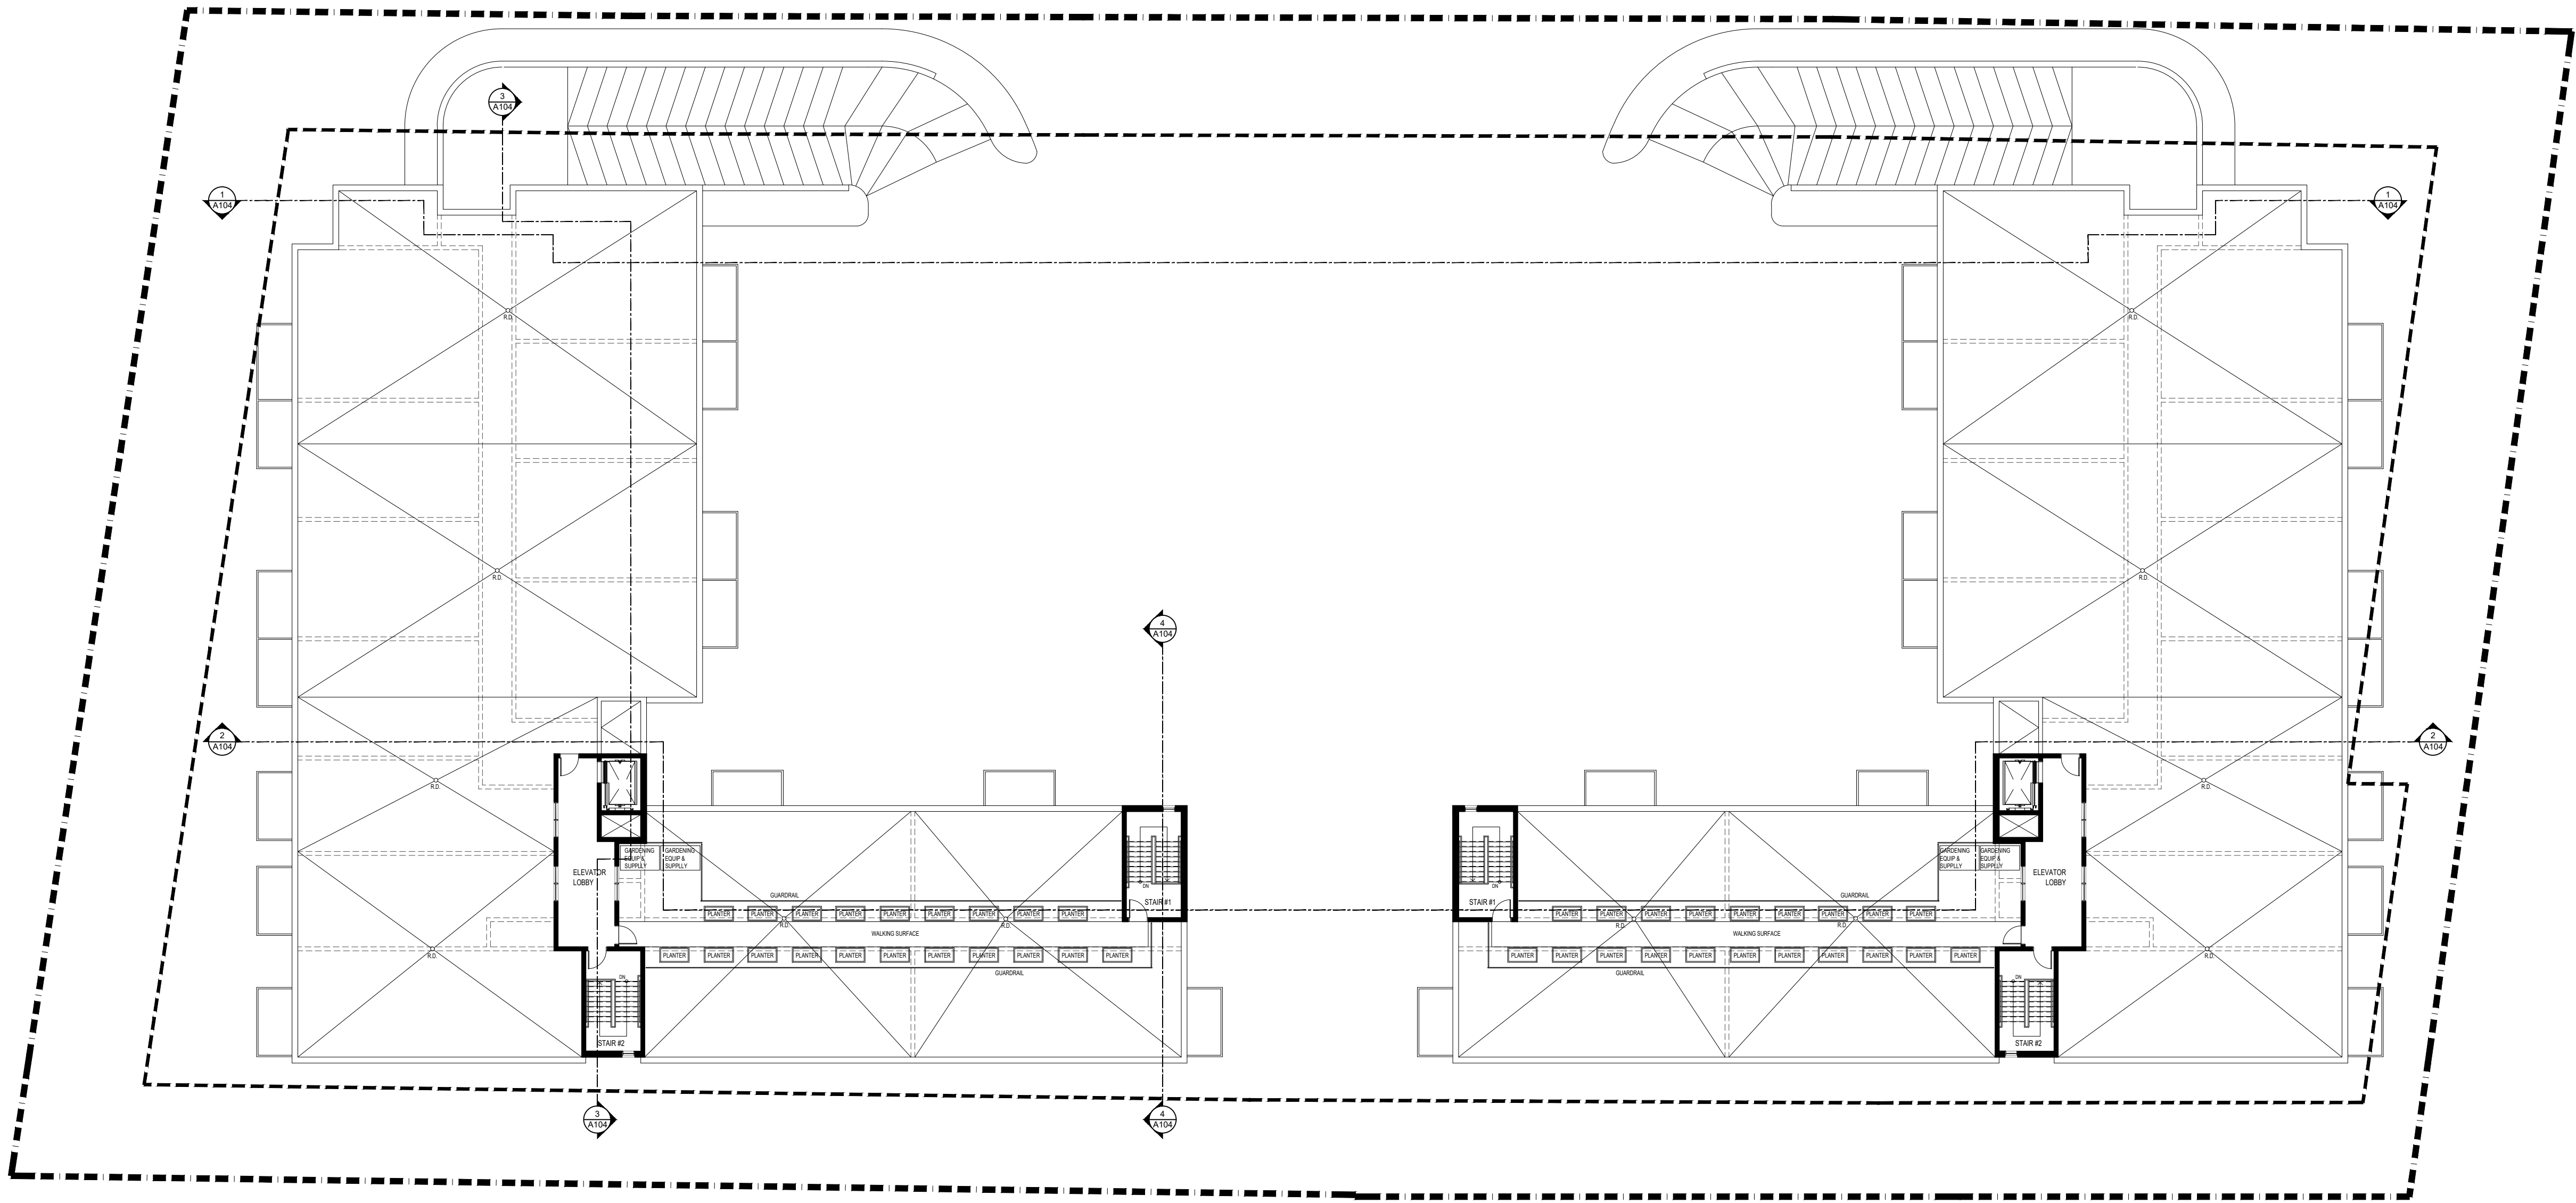

1 ROOF LEVEL PLAN
A102 SCALE = 1 : 200

No.	REVISIONS	BY	DATE
11			
10			
09			
08			
07			
06	FOR REVIEW	PE	APR. 01 2022
05	FOR REVIEW	PE	MAR. 21 2022
04	FOR REVIEW	PE	APR. 09 2021
03	FOR REVIEW	PE	NOV. 10 2020
02	FOR REVIEW	PE	NOV. 02 2020
01	FOR REVIEW	PE	OCT. 29 2020

NOT AUTHENTIC UNLESS SIGNED AND DATED



CONSULTING ENGINEERS

STRUCTURAL

MECHANICAL

ELECTRICAL

DESIGNED BY: P.E. DRAWN BY: P.E. APPROVED BY: P.E.

PROJECT

3817-3843 INNES ROAD
ORLEANS

DRAWING TITLE

ROOF PLAN

PROJECT NO.

0378

DATE
OCT, 29, 2020

A102

FILE # D07-12-20-0164