


1 ELECTRICAL SITE PLAN
SCALE: N.T.S.


Symbol	Qty	Label	Arrangement	Description	LLF	Luminaire Lumens	Luminaire Watts	Total Watts	[MANUFAC]	BUG Rating
□	1	P3	Single	ASL1-80L-25-3K7-3-BC	0.900	2239	25.533	25.533	HUBBELL OUTDOOR	B0-U0-G1
□	5	P2	Single	ASL1-80L-50-3K7-4W-U	0.900	5870	49.7	248.5	HUBBELL OUTDOOR	B1-U0-G2
□	2	P1	Single	ASL1-80L-50-3K7-3-U	0.900	5981	49.7	99.4	HUBBELL OUTDOOR	B1-U0-G2
□	2	W1	Single	TRPT-1ZL30-3K7-2	0.900	2721	28.2	56.4	HUBBELL OUTDOOR LIGHTING	B1-U1-G1
○	4	D1	Single	LTR-4RD-H-SL06L-DM1_LTR-4RD-T-SL35K9WDS	0.900	664	7.8	31.2	PRESCOLITE	B1-U0-G0

Label	CalcType	Units	Avg	Max	Min	Avg/Min	Max/Min
BARRIER FREE PARKING	Illuminance	Fc	3.12	4.0	1.7	1.84	2.35
BLDG ENTRANCES	Illuminance	Fc	5.31	8.7	2.7	1.97	3.22
CANOPY'S	Illuminance	Fc	5.93	9.1	3.2	1.85	2.94
SITE PARKING	Illuminance	Fc	1.54	2.8	0.5	3.08	5.60
SPILL OF LIGHT	Illuminance	Fc	0.00	0.0	0.0	N.A.	N.A.

2 LUMINAIRE SCHEDULE AND CALCULATION SUMMARY
SCALE: N.T.S.

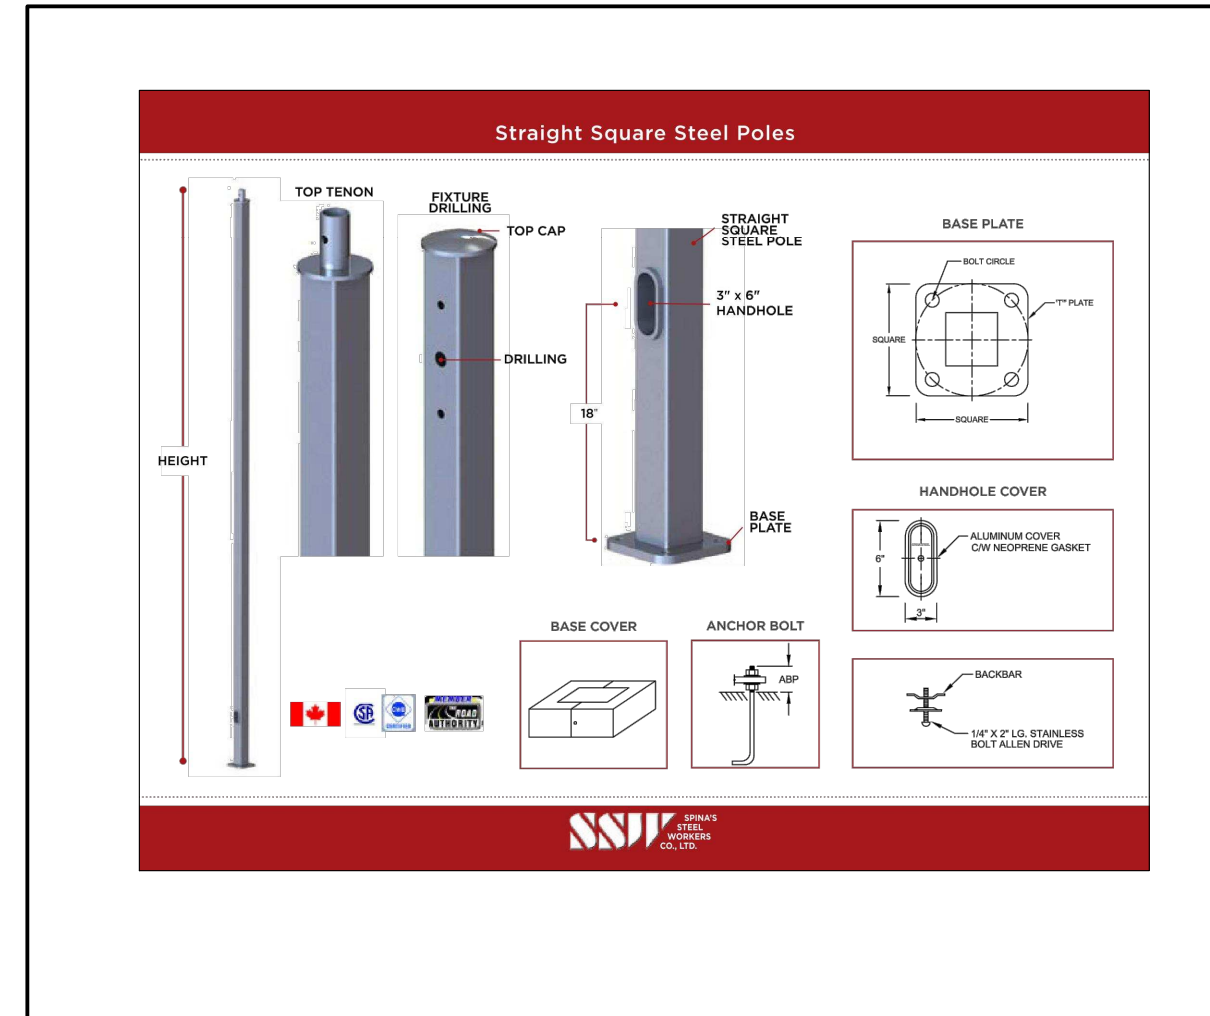

3 SQUARE SEET POLES
SCALE: N.T.S.

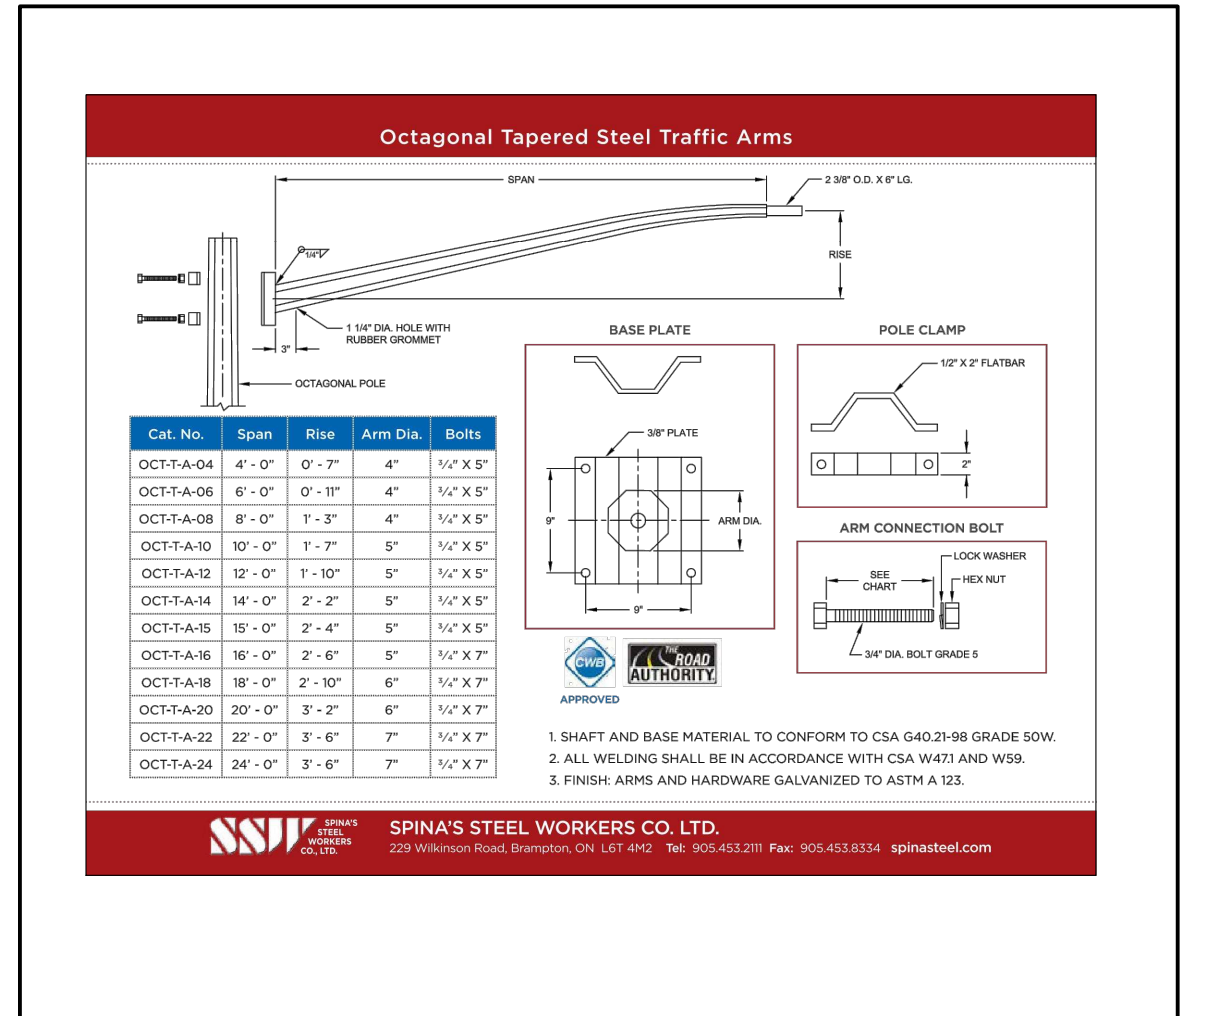

4 TAPERED STEEL STEEL TRAFFIC ARMS
SCALE: N.T.S.

7 LUMINAIRE D1
SCALE: N.T.S.

6 LUMINAIRE W1
SCALE: N.T.S.

5 LUMINAIRE P1 P2 P3
SCALE: N.T.S.

1.	09/06/2022	ISSUED FOR SITE PLAN CONTROL	CH'D
REVISIONS			
THE SPECIFICATIONS ARE TO BE CONSIDERED AS AN INTEGRAL PART OF THESE DRAWINGS AND NEITHER THE DRAWINGS NOR THE SPECIFICATIONS SHALL BE USED ALONE. REFER TO ARCHITECTURAL DRAWINGS FOR DIMENSIONS. DO NOT SCALE.			PROJECT NORTH
 250 ROWNTREE DAIRY RD. WOODBRIDGE, ON TEL: 905-507-0800 WWW.QUASARCG.COM			
FOR QUESTIONS REGARDING THIS PROJECT, PLEASE EMAIL: SINCER-22@QUASARCG.COM			
PROJECT			
3817-3843 INNES ROAD ORLEANS			
TITLE			
ELECTRICAL SITE PLAN			
CHECKED	--	PROJECT No.	SINCER-22-
SCALE	AS SHOWN	DRAWING No.	E-100