


1 ELECTRICAL SITE PLAN
SCALE: 1:250


Symbol	Qty	Label	Arrangement	Description	LLF	Luminaire Lumens	Luminaire Watts	Total Watts	[MANUFAC]	BUG Rating
☐	1	P3	Single	ASL1-80L-25-3K7-3-BC	0.900	2239	25.533	25.533	HUBBELL OUTDOOR	BO-UO-G1
☐	2	P2	Single	ASL1-80L-50-3K7-4W-U	0.900	5870	49.7	248.5	HUBBELL OUTDOOR	B1-UO-G2
☐	2	P1	Single	ASL1-80L-50-3K7-3-U	0.900	5981	49.7	99.4	HUBBELL OUTDOOR	B1-UO-G2
☐	2	W1	Single	GEO1-24L-15-3K7-3	0.900	1805	14.9	29.8	BEACON	BO-UO-G1
○	4	DT	Single	LTR-4RD-H-SL06L-DM1-LTR-4RD-T-SL5SKWDS	0.900	664	7.8	31.2	PRESCOLITE	B1-UO-G0

Label	CalcType	Units	Avg	Max	Min	Avg/Min	Max/Min
BARRIER FREE PARKING	Illuminance	Fc	3.12	4.0	1.7	1.84	2.35
BLDG ENTRANCES	Illuminance	Fc	3.75	4.0	3.6	1.04	1.11
CANOPY'S	Illuminance	Fc	5.93	9.1	3.2	1.85	2.84
SITE PARKING	Illuminance	Fc	1.54	2.8	0.5	3.08	5.60
SPILL OF LIGHT	Illuminance	Fc	0.00	0.0	0.0	N.A.	N.A.

2 LUMINAIRE SCHEDULE AND CALCULATION SUMMARY
SCALE: N.T.S.

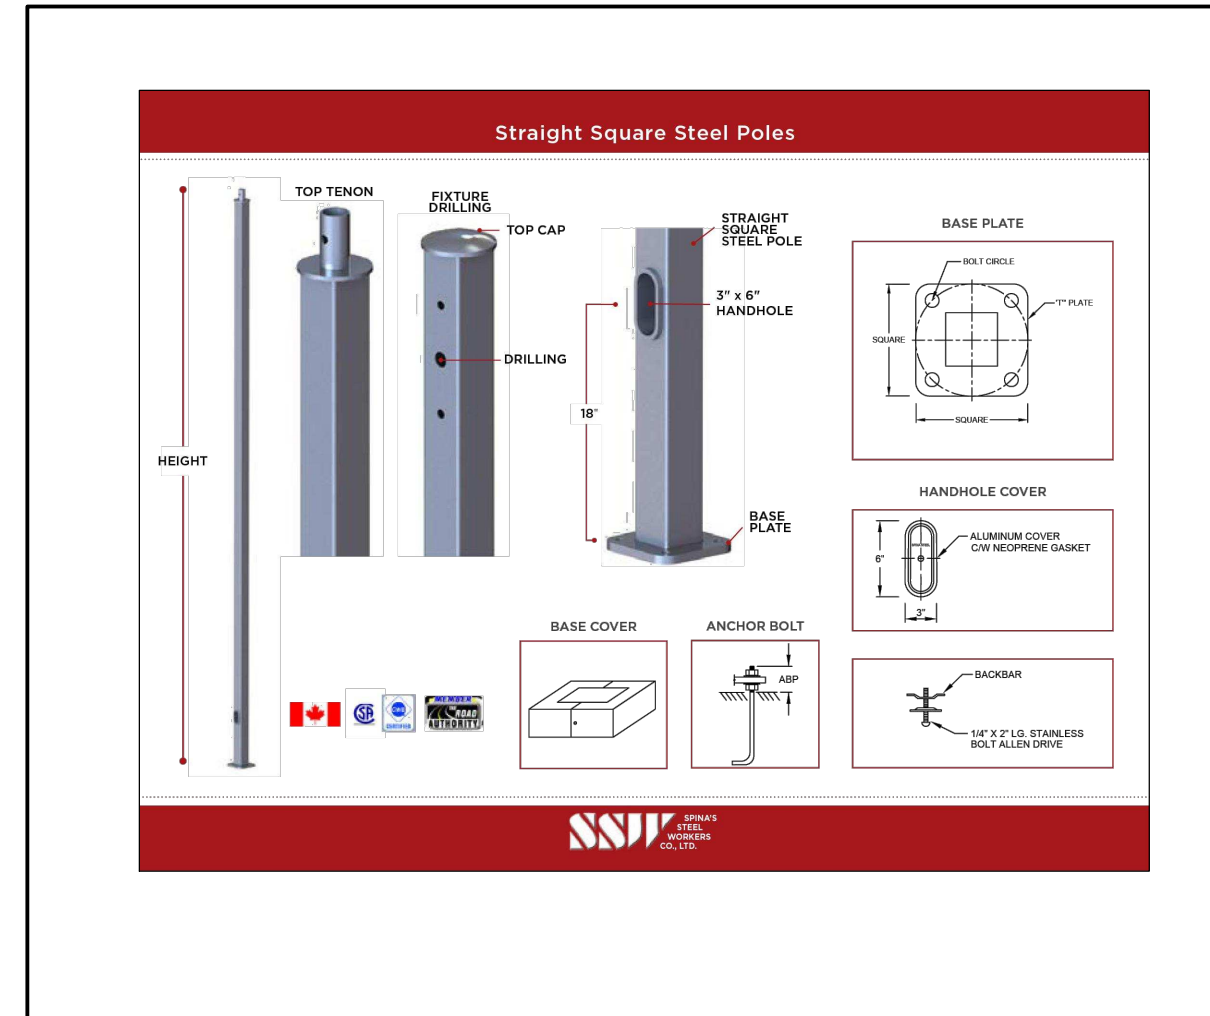

3 SQUARE STREET POLES
SCALE: N.T.S.

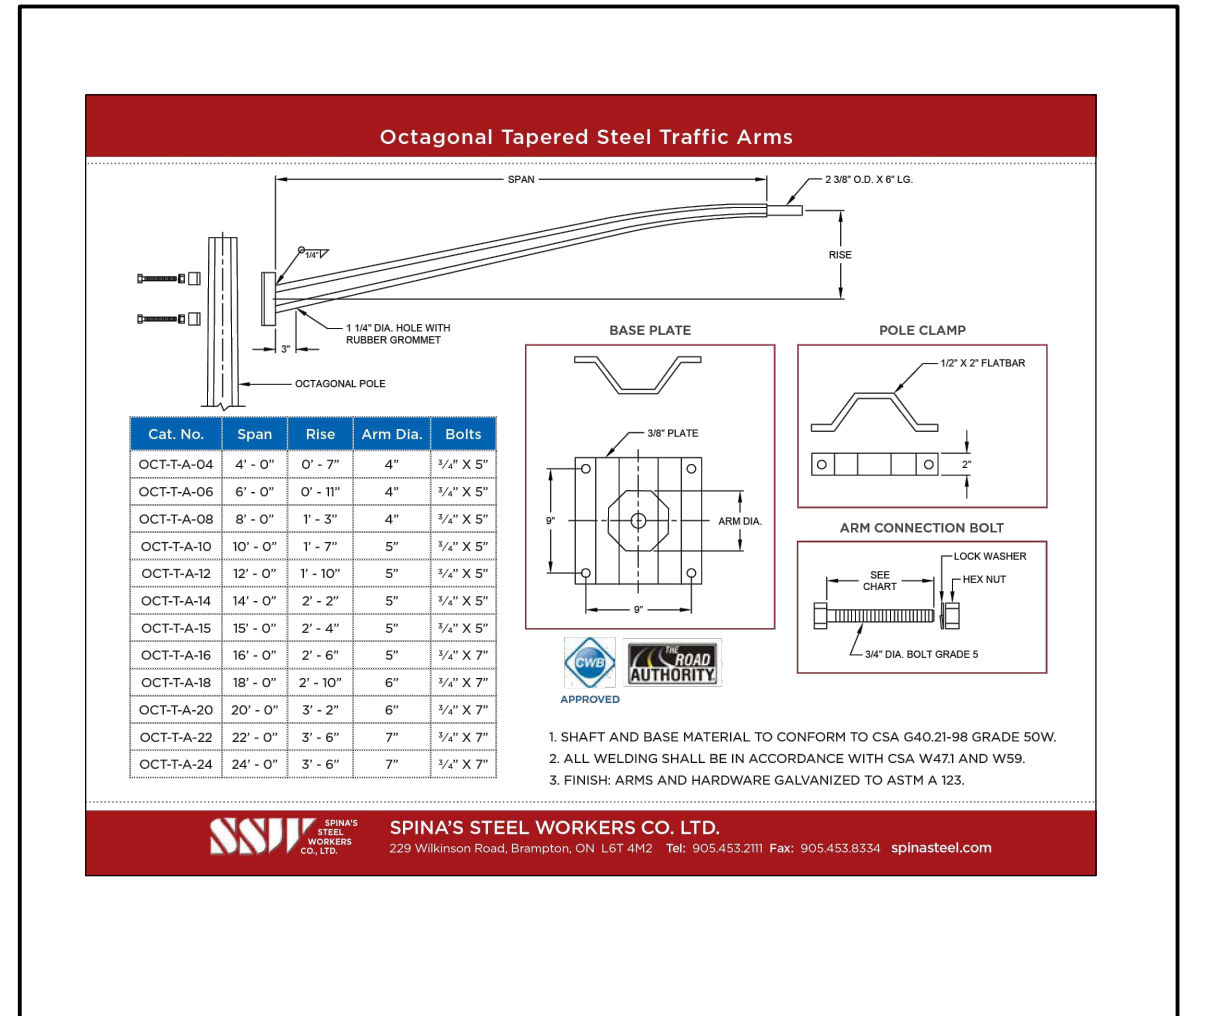

4 TAPERED STEEL TRAFFIC ARMS
SCALE: N.T.S.

7 LUMINAIRE D1
SCALE: N.T.S.

6 LUMINAIRE W1
SCALE: N.T.S.

5 LUMINAIRE P1, P2 & P3
SCALE: N.T.S.

No.	DATE	DESCRIPTION	CH'D
3	29 AUG 2023	RE-ISSUED FOR SITE PLAN CONTROL	TS
2	14 MAR 2023	RE-ISSUED FOR SITE PLAN CONTROL	TS
1	09 JUN 2022	ISSUED FOR SITE PLAN CONTROL	TS

REVISIONS		PROJECT NORTH
THE SPECIFICATIONS ARE TO BE CONSIDERED AS AN INTEGRAL PART OF THESE DRAWINGS AND NEITHER THE DRAWINGS NOR THE SPECIFICATIONS SHALL BE USED ALONE. REFER TO ARCHITECTURAL DRAWINGS FOR DIMENSIONS. DO NOT SCALE.		
 250 ROWNTREE DAIRY RD. WOODBRIDGE, ON TEL: 905-507-0800 WEB: WWW.QUASARGC.COM		
PROJECT		3817-3843 INNES ROAD ORLEANS
TITLE		ELECTRICAL SITE PLAN
CHECKED	TS	PROJECT No. NCR-22-RE-010
SCALE	AS SHOWN	DRAWING No. E-100