


1 ELECTRICAL SITE PLAN  
SCALE: 1:250

Symbol	Qty	Label	Arrangement	Description	LLF	Luminaire Lumens	Luminaire Watts	Total Watts	[MANUFAC]	BUG Rating
□	1	P3	Single	ASL1-80L-25-3K7-3-BC	0.900	2239	25.533	25.533	HUBBELL OUTDOOR	BO-UO-G1
□	5	P2	Single	ASL1-80L-50-3K7-4W-U	0.900	5870	49.7	248.5	HUBBELL OUTDOOR	BI-UO-G2
□	2	P1	Single	ASL1-80L-50-3K7-3-U	0.900	5981	49.7	99.4	HUBBELL OUTDOOR	BI-UO-G2
□	2	W1	Single	GEO1-24L-15-3K7-3	0.900	1805	14.9	29.8	BEACON	BO-UO-G1
○	4	D1	Single	LTR-4RD-H-SL06L-DM1-LTR-4RD-T-SL5SKWDS	0.900	664	7.8	31.2	PRESCOLITE	BI-UO-G0


  

Label	CalcType	Units	Avg	Max	Min	Avg/Min	Max/Min
BARRIER FREE PARKING	Illuminance	Fc	3.12	4.0	1.7	1.84	2.35
BLDG ENTRANCES	Illuminance	Fc	3.75	4.0	3.6	1.04	1.11
CANOPY'S	Illuminance	Fc	5.93	9.1	3.2	1.85	2.84
SITE PARKING	Illuminance	Fc	1.54	2.8	0.5	3.08	5.60
SPILL OF LIGHT	Illuminance	Fc	0.00	0.0	0.0	N.A.	N.A.

2 LUMINAIRE SCHEDULE AND CALCULATION SUMMARY  
SCALE: N.T.S.

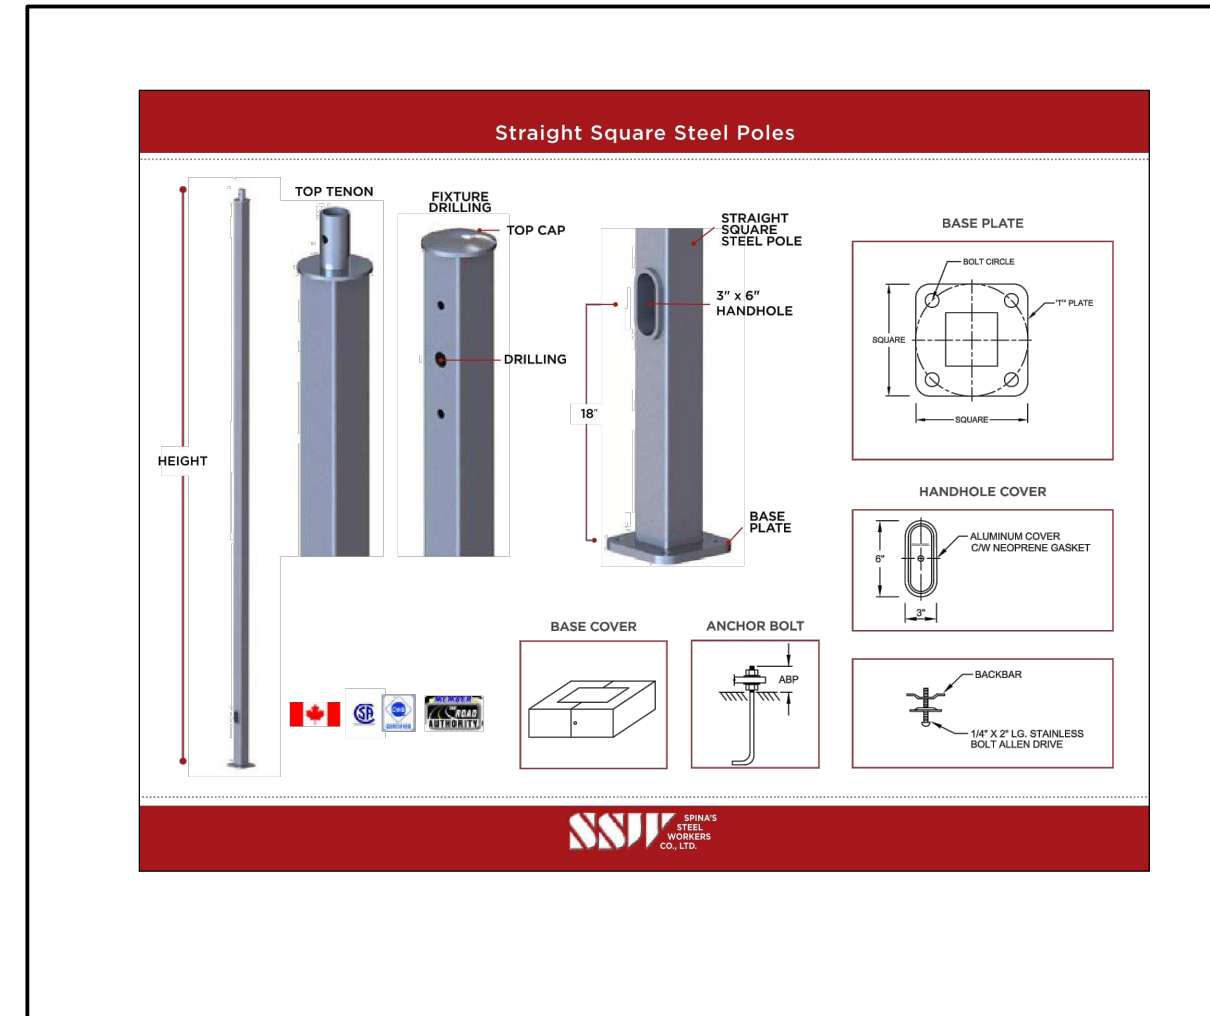

3 SQUARE STREET POLES  
SCALE: N.T.S.

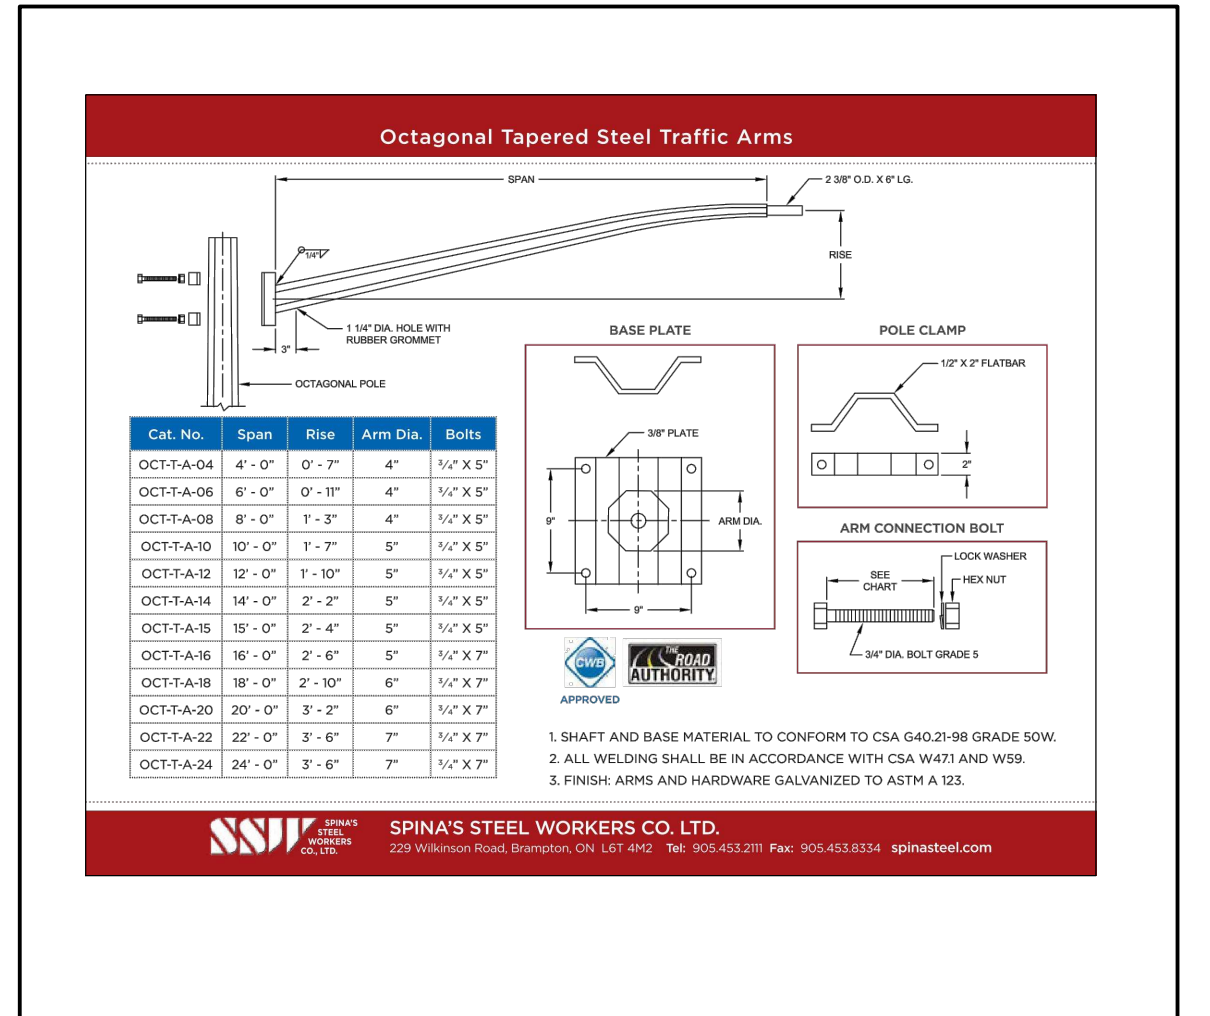

4 TAPERED STEEL TRAFFIC ARMS  
SCALE: N.T.S.

7 LUMINAIRE D1  
SCALE: N.T.S.

6 LUMINAIRE W1  
SCALE: N.T.S.

5 LUMINAIRE P1, P2 & P3  
SCALE: N.T.S.

No.	DATE	DESCRIPTION	CH'D
2	14/03/2023	RE-ISSUED FOR SITE PLAN CONTROL	TS
1	09/06/2022	ISSUED FOR SITE PLAN CONTROL	TS

REVISIONS

THE SPECIFICATIONS ARE TO BE CONSIDERED AS AN INTEGRAL PART OF THESE DRAWINGS AND NEITHER THE DRAWINGS NOR THE SPECIFICATIONS SHALL BE USED ALONE. REFER TO ARCHITECTURAL DRAWINGS FOR DIMENSIONS. DO NOT SCALE.

PROJECT NORTH

250 ROWNTREE DAIRY RD. WOODBRIDGE, ON  
905-507-0800  
WWW.QUASARC.COM

FOR QUESTIONS REGARDING THIS PROJECT, PLEASE EMAIL:  
NCR-22-RE-010@QUASARC.COM

PROJECT  
3817-3843 INNEW ROAD  
ORLEANS

TITLE  
ELECTRICAL SITE PLAN

CHECKED  
--

SCALE  
AS SHOWN

PROJECT No.  
NCR-22-RE-010

DRAWING No.  
E-100

QUASAR CONSULTING GROUP  
T.W. SEDORE  
LICENSED PROFESSIONAL ENGINEER  
14 FEB 2023  
PROVINCE OF ONTARIO