



LEGEND

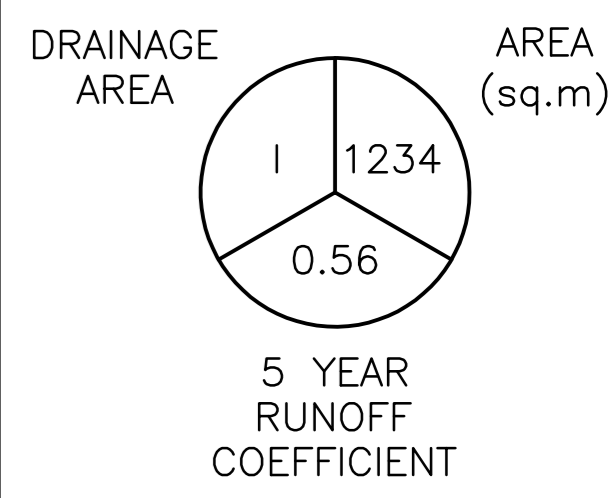

KEY PLAN

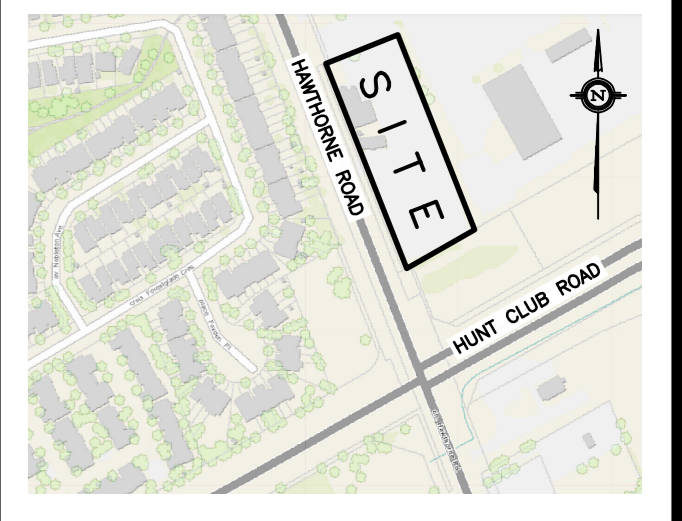

No.	DATE	REVISION
5	MAY 31-22	RE-ISSUED FOR APPROVAL
4	NOV 1-21	ISSUED FOR TENDER
3	OCT 8-21	ISSUED FOR BUILDING PERMIT
2	DEC 11-20	ISSUED FOR APPROVAL
1	DEC 9-20	ISSUED FOR COORDINATION

D. B. GRAY ENGINEERING INC.
 Stormwater Management - Grading & Drainage - Storm & Sanitary Sewers - Watermain
 700 Long Point Circle 613-425-8044
 Ottawa, Ontario d.gray@dbgrayengineering.com

Project
PROPOSED 4-STOREY DYMON STORAGE BUILDING
 3455 HAWTHORNE ROAD
 OTTAWA, ONTARIO

DRAINAGE PLAN

Engineer's Seal

 NOT VALID UNLESS SIGNED & DATED

Drawn: D.B.G.
 Hor. Scale: 1:250
 Vert. Scale:
 Date: NOV 17-20
 Job No.: 19107
 Drawing No.:
C-8
 of 8

D07-12-20-0191