

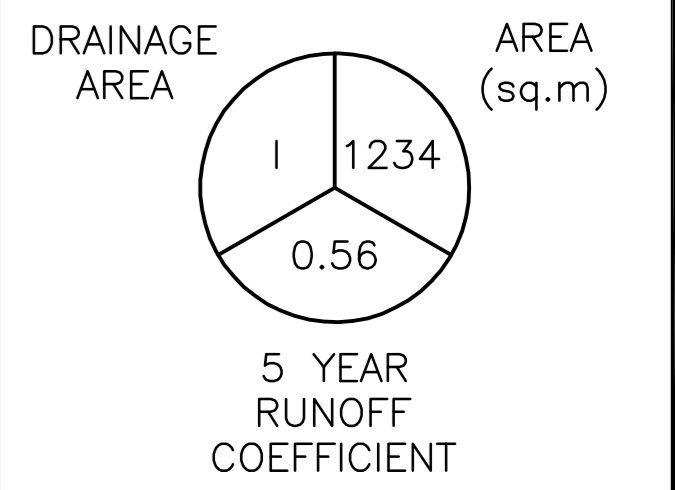


LEGEND

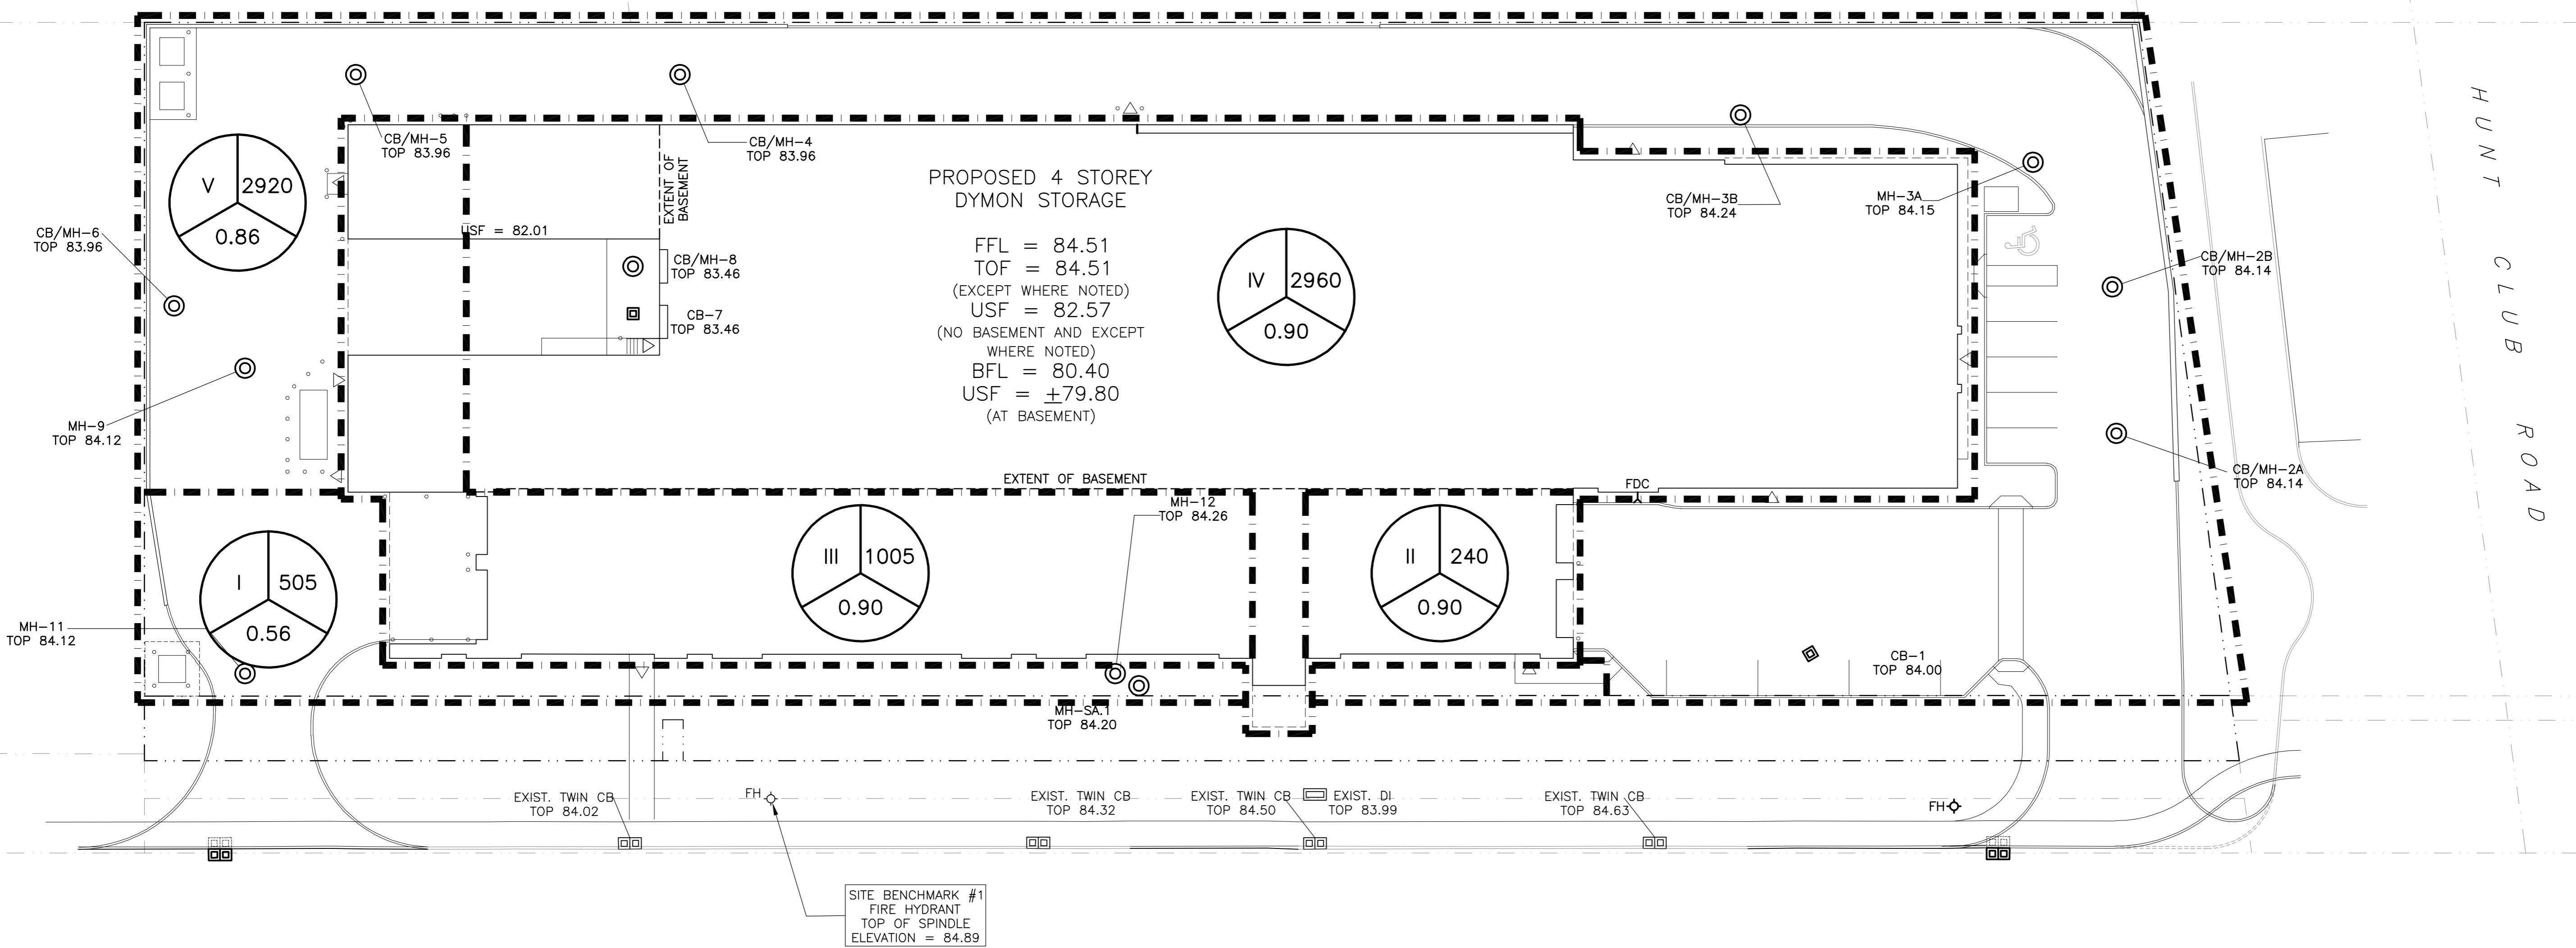

KEY PLAN

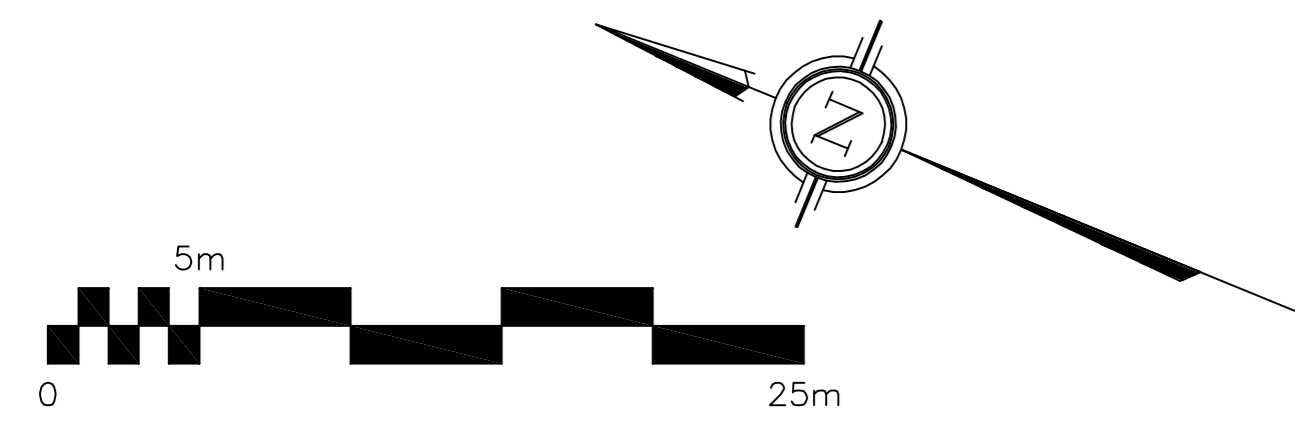


No.	DATE	REVISION
6	AUG 11-22	ISSUED FOR CONSTRUCTION
5	MAY 31-22	RE-ISSUED FOR APPROVAL
4	NOV 1-21	ISSUED FOR TENDER
3	OCT 8-21	ISSUED FOR BUILDING PERMIT
2	DEC 11-20	ISSUED FOR APPROVAL
1	DEC 9-20	ISSUED FOR COORDINATION

D. B. GRAY ENGINEERING INC.
Stormwater Management - Grading & Drainage - Storm & Sanitary Sewers - Mainframes
 700 Long Point Circle 613-425-8044
 Ottawa, Ontario d.gray@dbgrayengineering.com


Project
**PROPOSED 4-STOREY
 DYMON STORAGE BUILDING
 3455 HAWTHORNE ROAD
 OTTAWA, ONTARIO**

DRAINAGE PLAN

APPROVED
 By Lily Xu at 1:58 pm, Sep 09, 2022



LILY XU, MCIP, RPP
 MANAGER, DEVELOPMENT REVIEW SOUTH
 PLANNING, INFRASTRUCTURE & ECONOMIC
 DEVELOPMENT DEPARTMENT, CITY OF OTTAWA

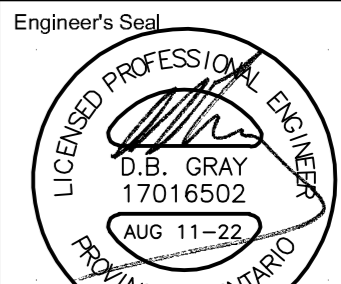Engineer's Seal

 NOT VALID UNLESS
 SIGNED & DATED

Drawn: D.B.G.
 Hor. Scale: 1:250
 Vert. Scale:
 Date: NOV 17-20
 Job No.: 19107
 Drawing No.:
**C-8
 of 8**