






GENERAL NOTES
DO NOT SCALE DRAWINGS.
CONTRACTOR TO VERIFY ALL DIMENSIONS & CONDITIONS
AND REPORT ANY DISCREPANCIES.

PROJECT NORTH

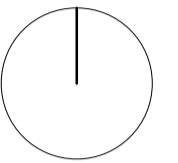

TRUE NORTH

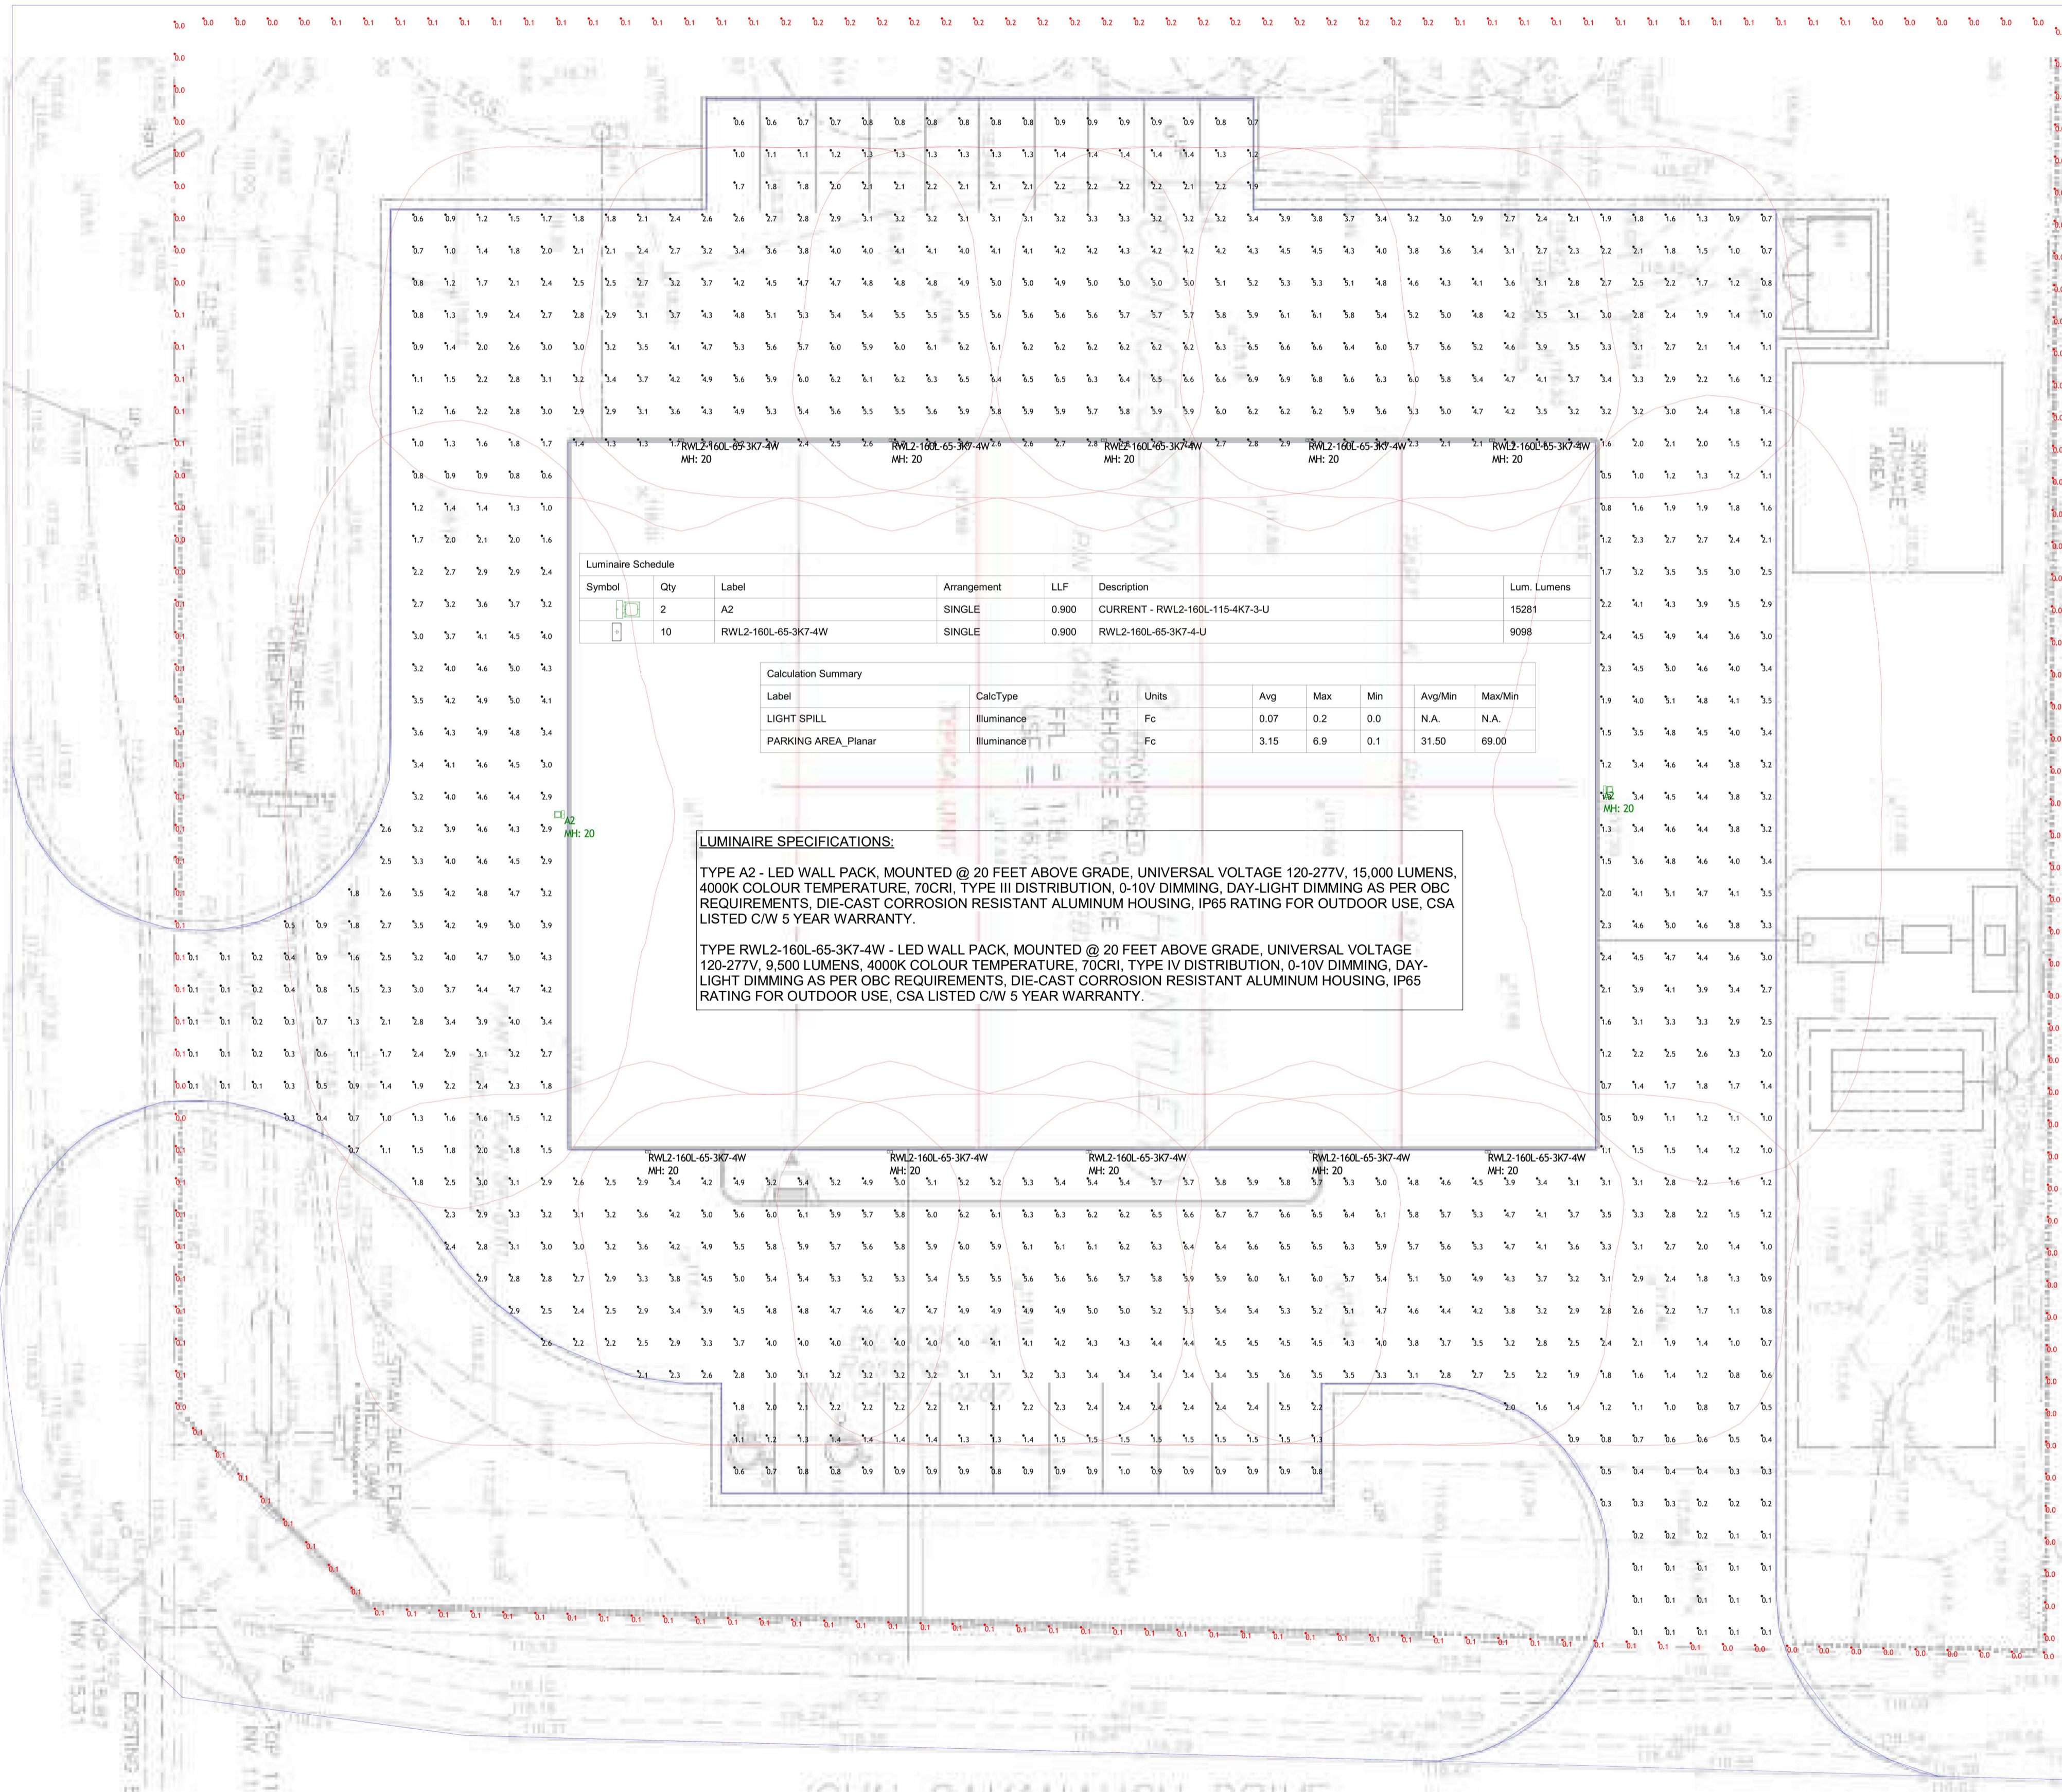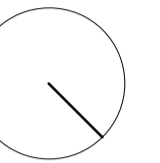




Symbol	Qty	Label	Arrangement	LLF	Description	Lum. Lumens
□	2	A2	SINGLE	0.900	CURRENT - RWL2-160L-115-4K7-3-U	15281
□	10	RWL2-160L-65-3K7-4-W	SINGLE	0.900	RWL2-160L-65-3K7-4-U	9098

Label	CalcType	Units	Avg	Max	Min	Avg/Min	Max/Min
LIGHT SPILL	illuminance	Fc	0.07	0.2	0.0	N.A.	N.A.
PARKING AREA_Planar	illuminance	Fc	3.15	6.9	0.1	31.50	69.00

LUMINAIRE SPECIFICATIONS:

TYPE A2 - LED WALL PACK, MOUNTED @ 20 FEET ABOVE GRADE, UNIVERSAL VOLTAGE 120-277V, 15,000 LUMENS, 4000K COLOUR TEMPERATURE, 70CRI, TYPE III DISTRIBUTION, 0-10V DIMMING, DAY-LIGHT DIMMING AS PER OBC REQUIREMENTS, DIE-CAST CORROSION RESISTANT ALUMINUM HOUSING, IP65 RATING FOR OUTDOOR USE, CSA LISTED C/W 5 YEAR WARRANTY.

TYPE RWL2-160L-65-3K7-4-W - LED WALL PACK, MOUNTED @ 20 FEET ABOVE GRADE, UNIVERSAL VOLTAGE 120-277V, 9,500 LUMENS, 4000K COLOUR TEMPERATURE, 70CRI, TYPE IV DISTRIBUTION, 0-10V DIMMING, DAY-LIGHT DIMMING AS PER OBC REQUIREMENTS, DIE-CAST CORROSION RESISTANT ALUMINUM HOUSING, IP65 RATING FOR OUTDOOR USE, CSA LISTED C/W 5 YEAR WARRANTY.

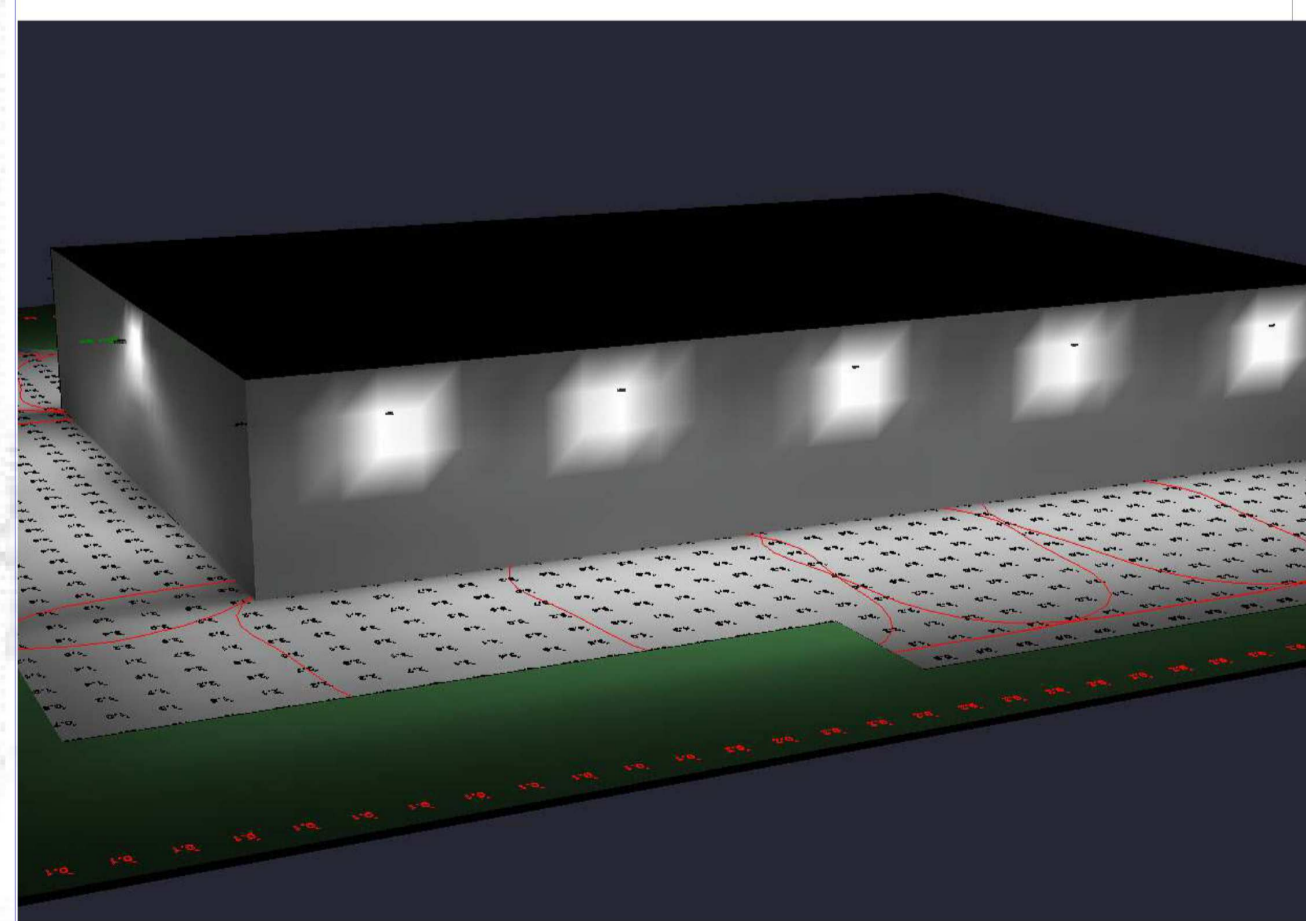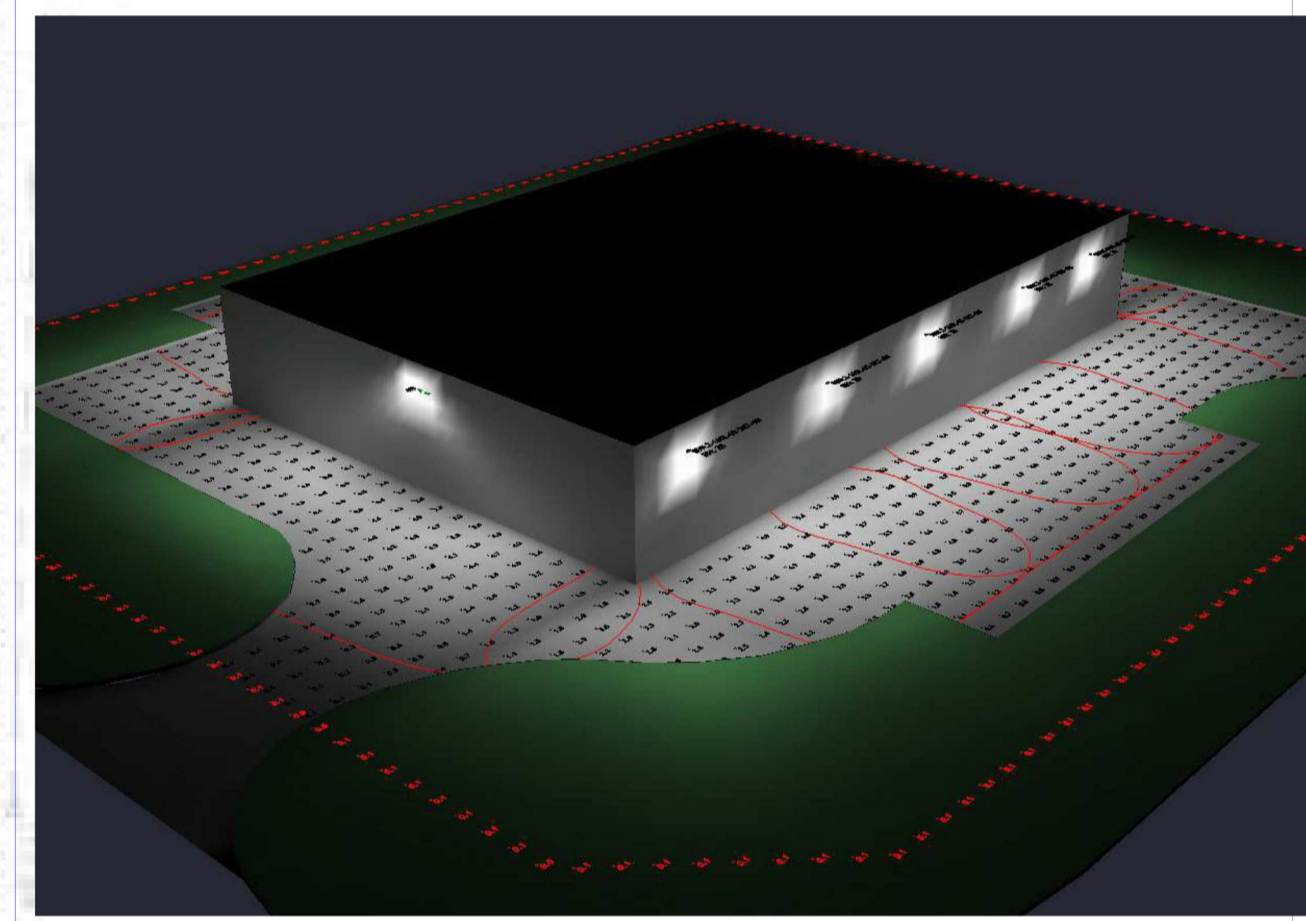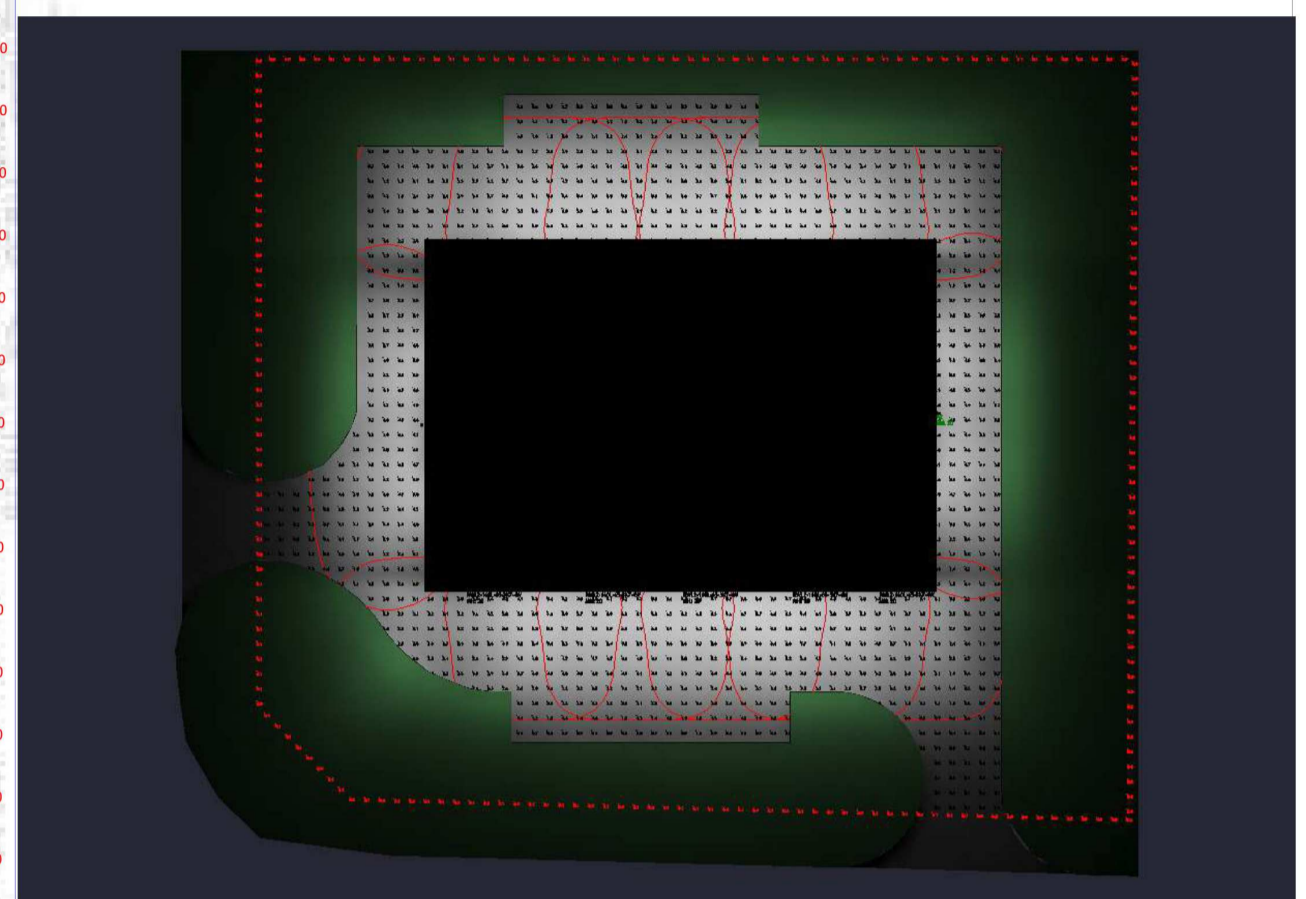

No.	DATE	DESCRIPTION
A	2023-08-10	ISSUED FOR SITE PLAN APPLICATION

REVISIONS

PROJECT

2167 McGee Side Road

2167 McGee Side Road
Carp, Ontario, K0A 1L0

IDEA # 23560 CLIENT #

SHEET NAME

SITE LIGHTING PLAN - FLOOR PLAN

DATE 2023-08-10 SCALE AS NOTED.

CHECKED BY N. FRAYN DRAWN BY LIAM BECK

SHEET No.