
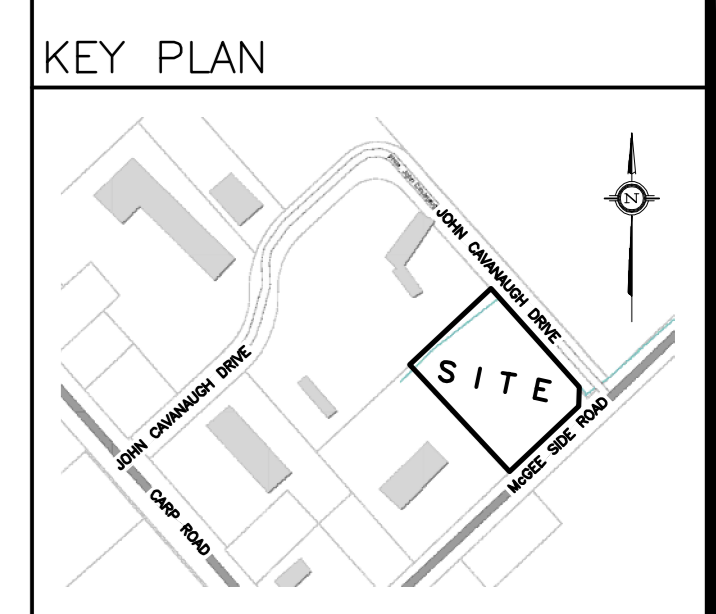


**LEGEND**

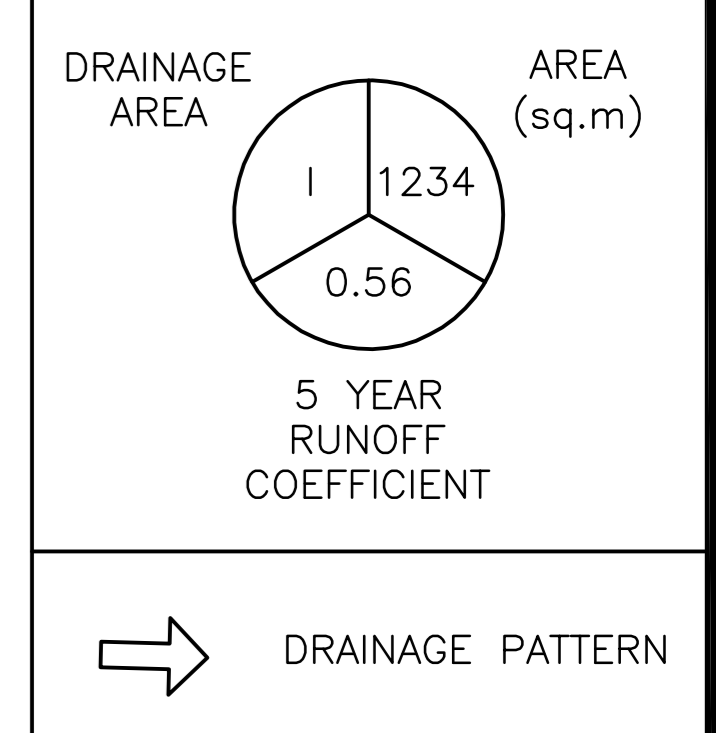

No.	DATE	REVISION
3	JUN 29-23	ISSUED FOR APPROVAL
2	JUN 23-23	ISSUED FOR COORDINATION
1	APR 19-23	ISSUED FOR CLIENT REVIEW

**D. B. GRAY ENGINEERING INC.**  
 Stormwater Management - Grading & Drainage - Storm & Sanitary Sewers - Mainframes  
 700 Long Point Circle 613-425-8044  
 Ottawa, Ontario d.gray@dbgrayengineering.com

Project  
**OFFICE & WAREHOUSE**  
**2167 MCGEE SIDE ROAD**  
 OTTAWA, ONTARIO

Drawing Title  
**PRE-DEVELOPMENT & POST DEVELOPMENT DRAINAGE PLAN**

Engineer's Seal  
  
 NOT VALID UNLESS SIGNED & DATED

Drawn: D.B.G.  
 Hor. Scale: 1:250  
 Vert. Scale:  
 Date: APR 19-23  
 Job No.: 23024  
 Drawing No.:  
**C-7**  
 of 7