

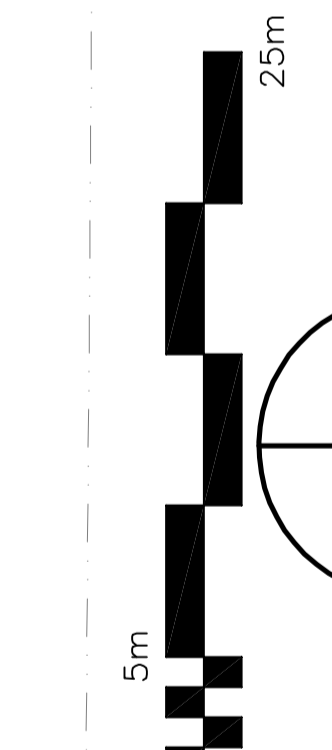


OWNER:
STOKED INDUSTRIES INC
14 KNOLL TERRACE,
NEPEAN ON K2J 2K6

PART 1 PLAN 4R-4727

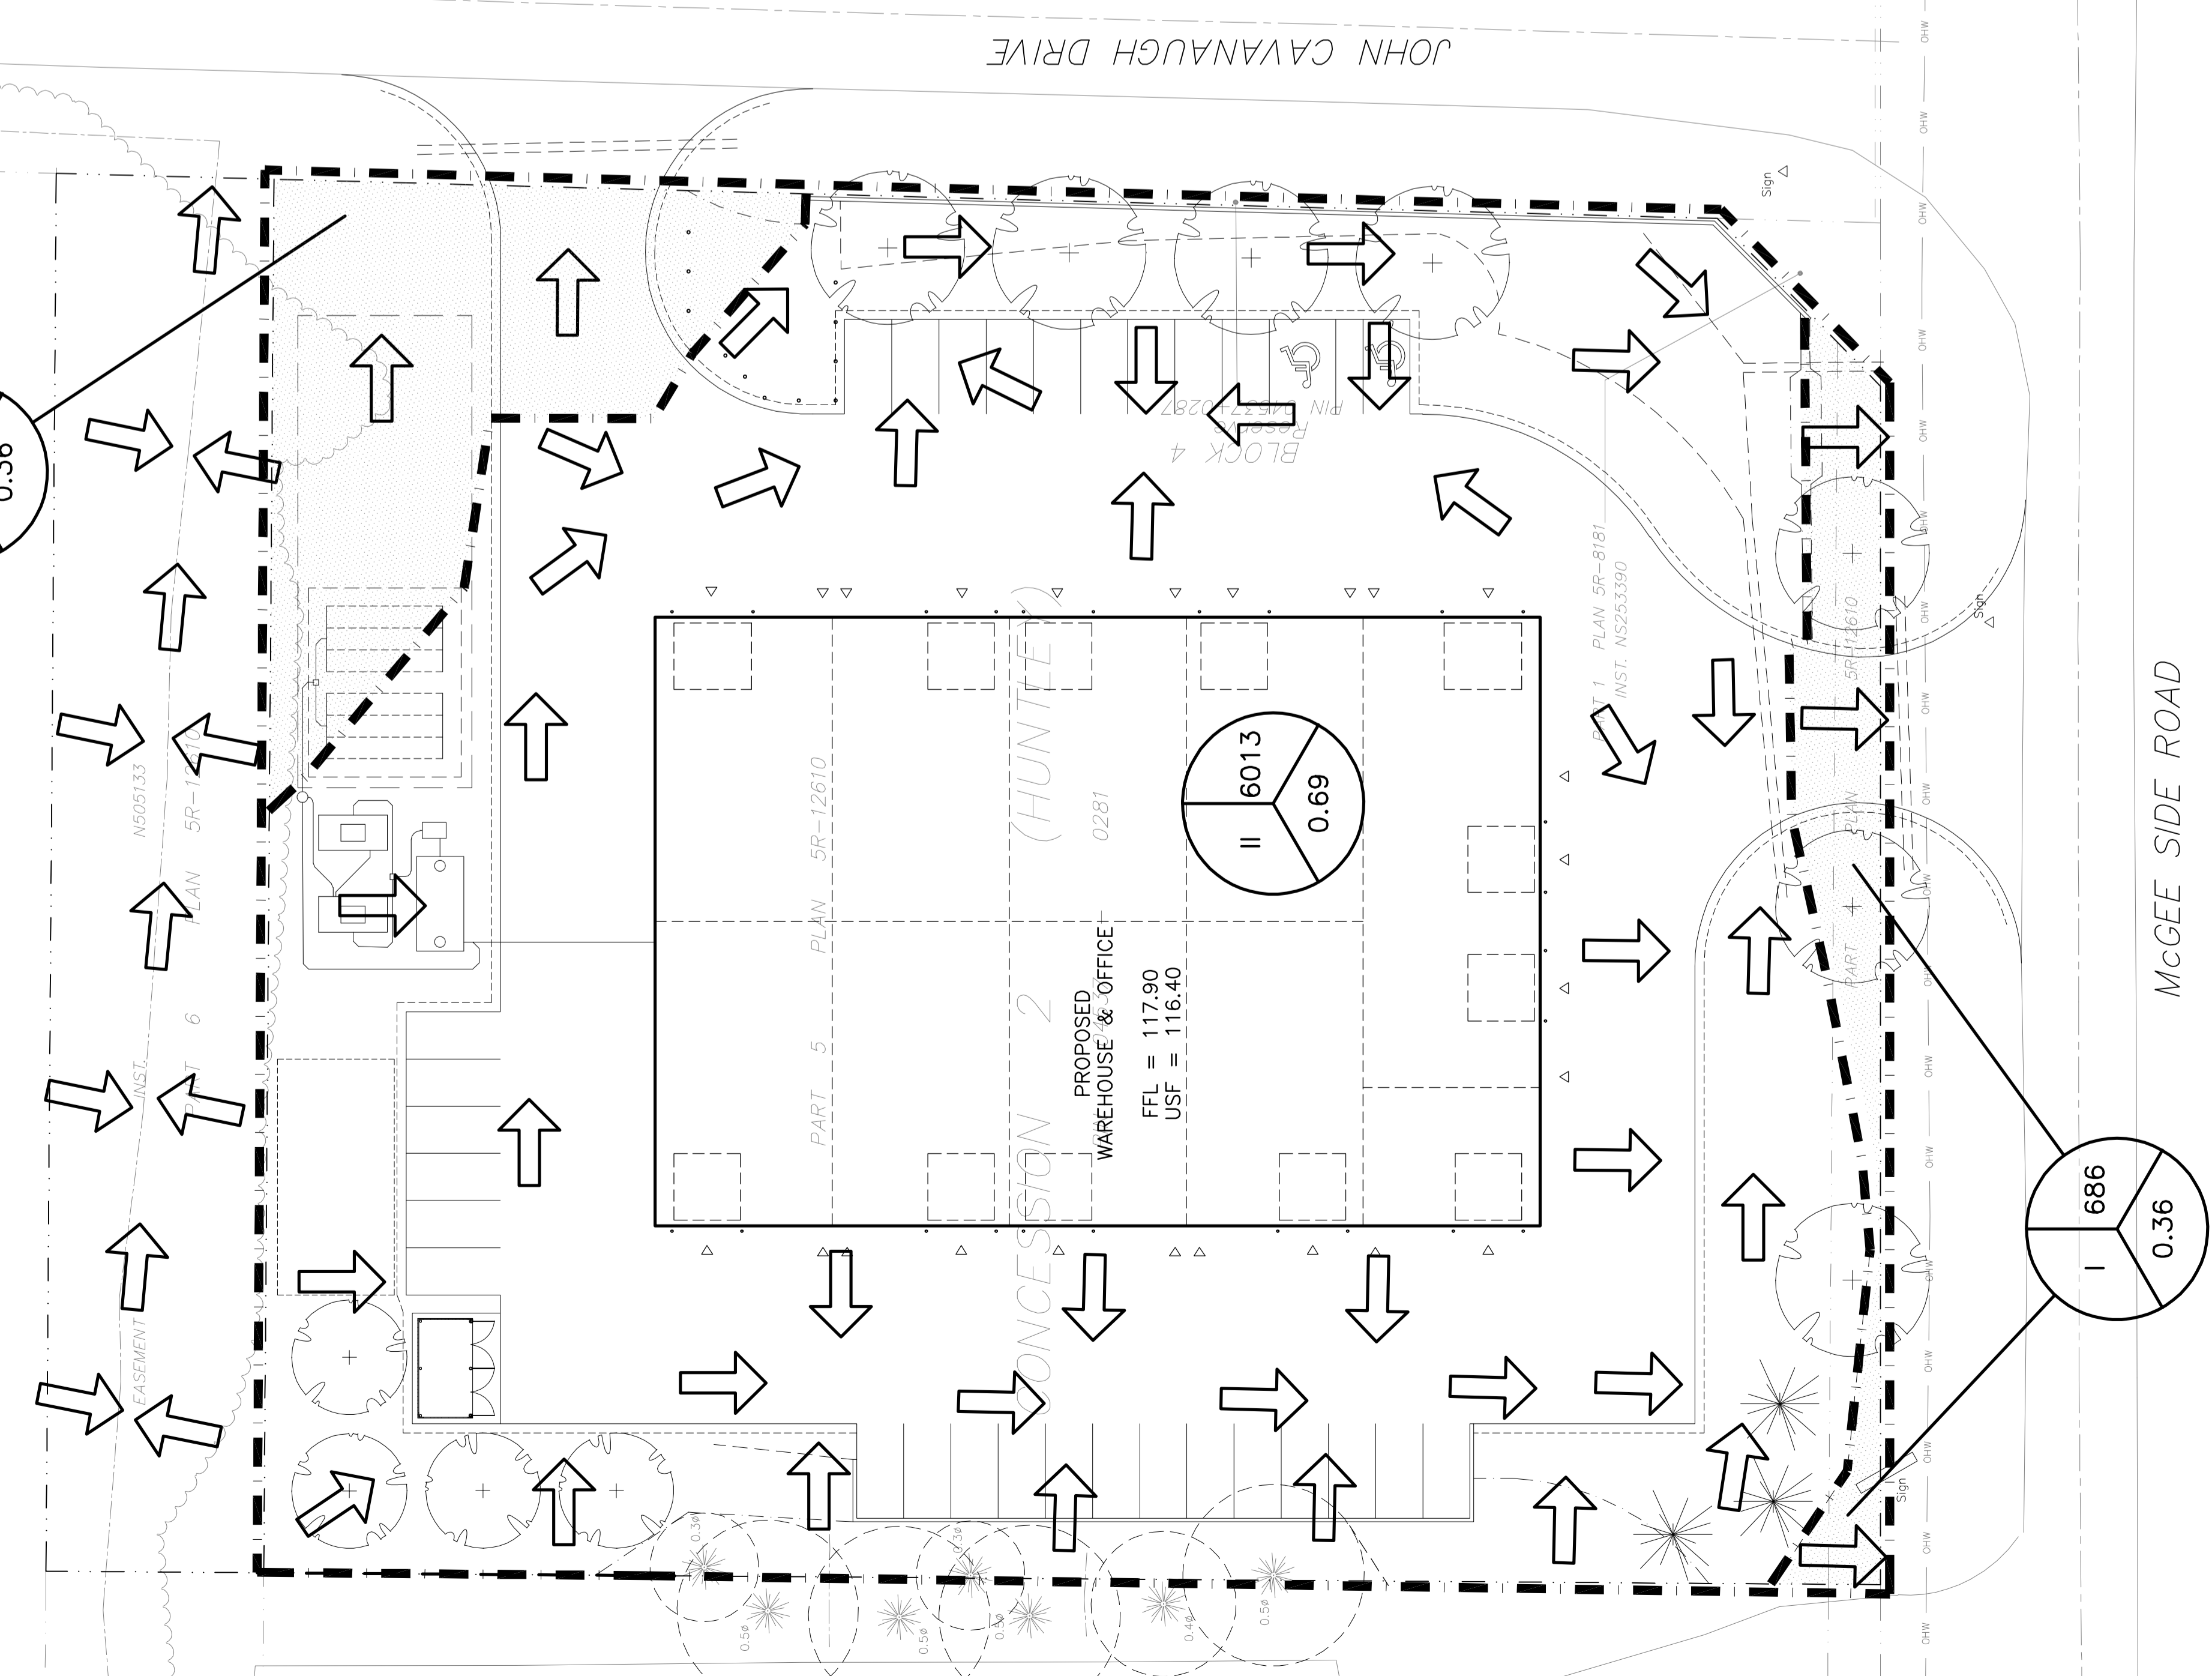


PIN 04537 - 0283

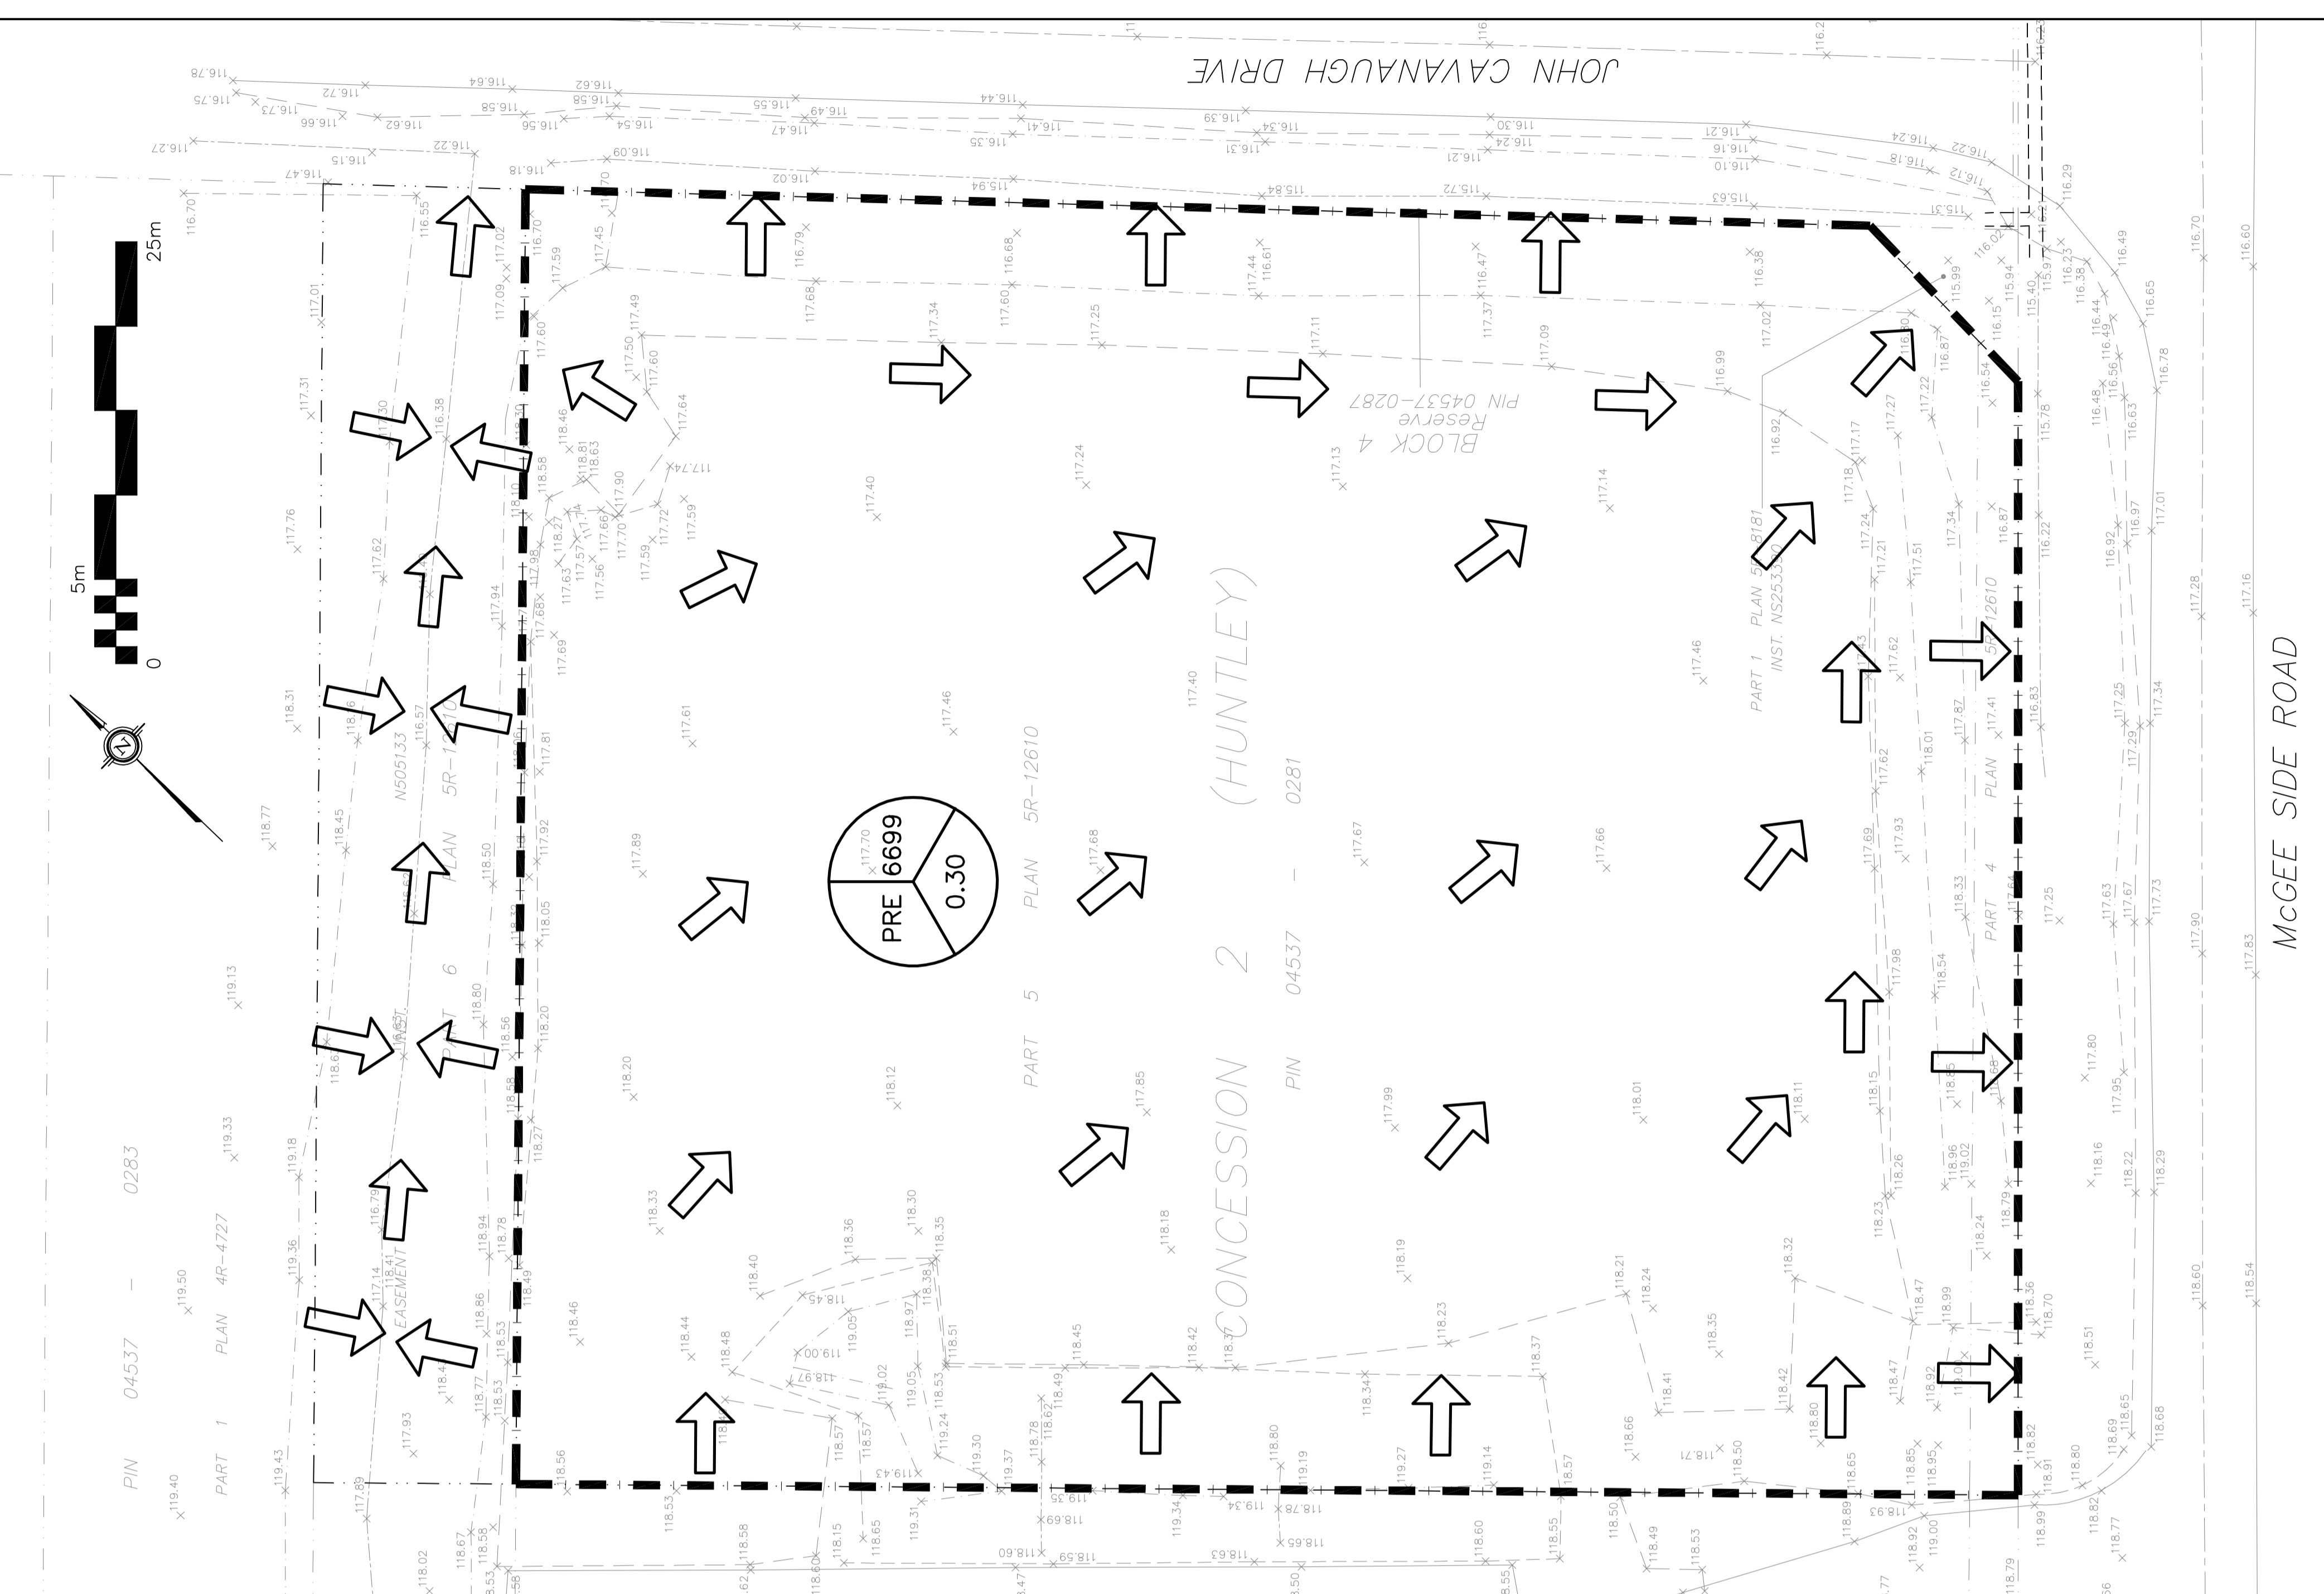

PIN 04537 - 0283

LEGEND

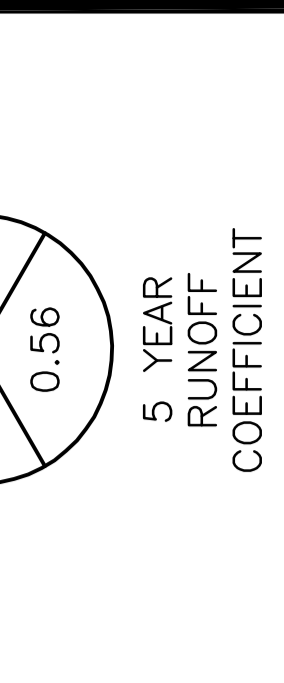


5 YEAR
RUNOFF
COEFFICIENT

DRAINAGE PATTERN



KEY PLAN

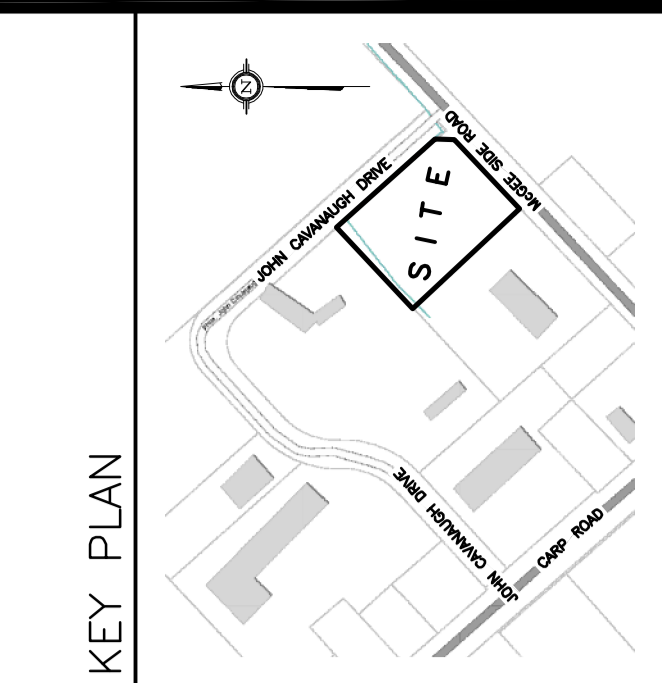

No.	DATE	REVISION
7	DEC 21-23	RE-ISSUED FOR APPROVAL
6	AUG 10-23	RE-ISSUED FOR APPROVAL
5	JUN 29-23	RE-ISSUED FOR APPROVAL
4	JUN 23-23	ISSUED FOR COORDINATION
3	APR 19-23	ISSUED FOR CLIENT REVIEW
2	JUN 14-21	RE-ISSUED FOR APPROVAL
1	MAR 12-21	ISSUED FOR APPROVAL

D. B. GRAY ENGINEERING INC.
700 Long Point Circle
Ottawa, Ontario
613-425-8044
dgray@dbgrayengineering.com

Project
OFFICE & WAREHOUSE
2167 MCGEE SIDE ROAD
OTTAWA, ONTARIO

Drawing Title
PRE-DEVELOPMENT &
POST DEVELOPMENT
DRAINAGE PLAN

Engineer's Seal
D.B. GRAY
17016502
P. 21-23
ENGINEER
NOT VALID UNLESS
SIGNED & DATED

Drawn: D.B.G.
Horz. Scale: 1:250
Vert. Scale: 1:25
Date: APR 19-23
Job No.: 23024

Drawing No.
C-7
of 7