


An exact copy of all working documents including, without limitations, the original of the present document or plan is kept on file by J.R.P. Engineering. Any modification carried out to this document or plan or to accompanying documents without written authorization by the engineer is prohibited.

Authorized modifications must be signed and sealed by an engineer and this engineer will be completely responsible for these modifications. J.R.P. Engineering is not and will not be responsible for the consequences of these modifications or for modifications carried out without its consent.

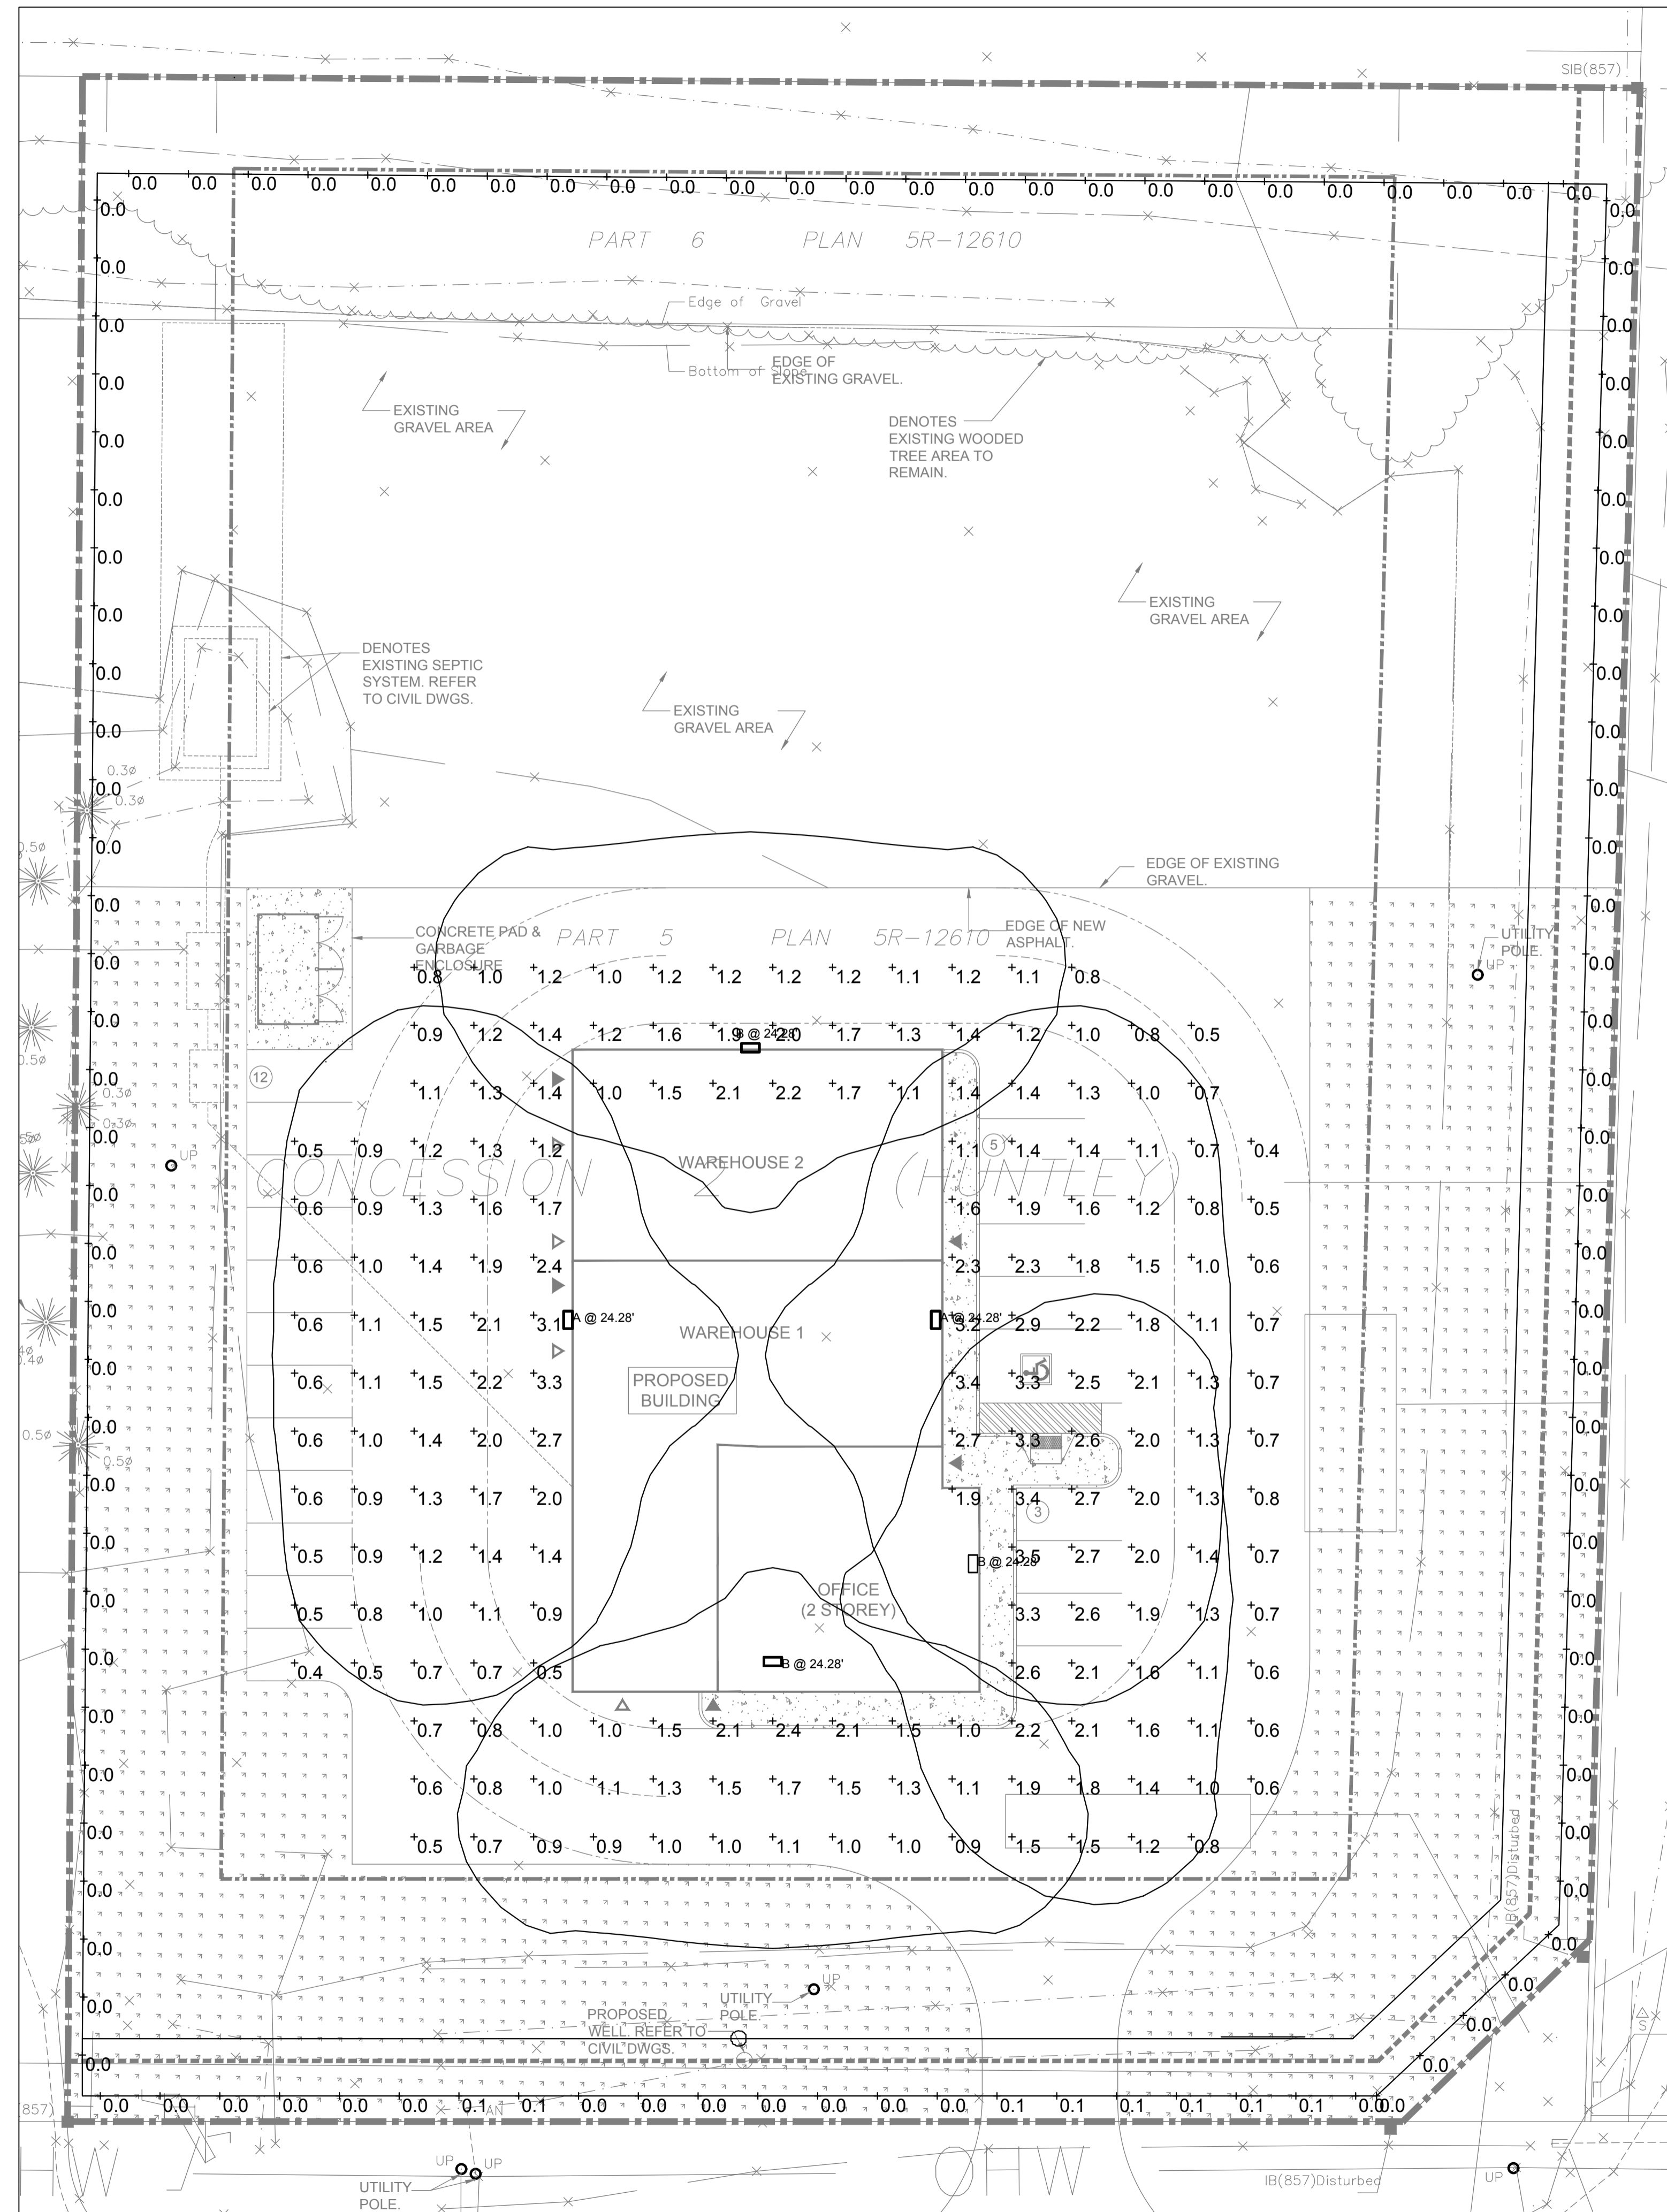


LIGHTING FIXTURE SCHEDULE						
TYPE	MAKE/MODEL	VOLTAGE	MOUNT	LAMPS	TEMPERATURE	NOTES
A	WDGE3 LED P4 70CRI R3 40K	120V	WALL PACK	LED	4000K	
B	WDGE3 LED P2 70CRI R3 40K	120V	WALL PACK	LED	4000K	

1 SITE LIGHTING PLAN
E-1 1:200

No	DESCRIPTION	DATE
0	ISSUED FOR SITE PLAN	FEB 3 2021

REVISIONS

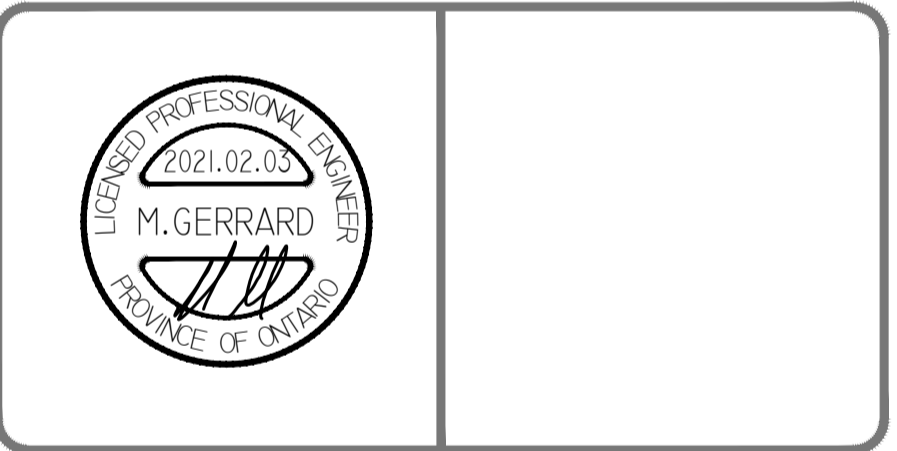

client:

project:
INDUSTRIAL BUILDING
2167 MCGEE SIDE ROAD
OTTAWA, ONTARIO

drawing title:
**ELECTRICAL
SITE LIGHTING PLAN
PHOTOMETRIC**

scale:	AS NOTED	drawn by:	C.M.
designed by:	C.M.	reviewed by:	M.G.
approved by:	M.G.	date:	FEB 2021

project no.:	100-2103	drawing no.:	E-1
revision:	<0>		of 1