


- NOTES:
- SITE LIGHTING HAS BEEN DESIGNED TO MINIMIZE LIGHT SPILLAGE ONTO ADJOINING PROPERTIES (MAXIMUM OF 0.5fc).
 - MOUNTING HEIGHT OF ALL FIXTURES IS 6096mm.

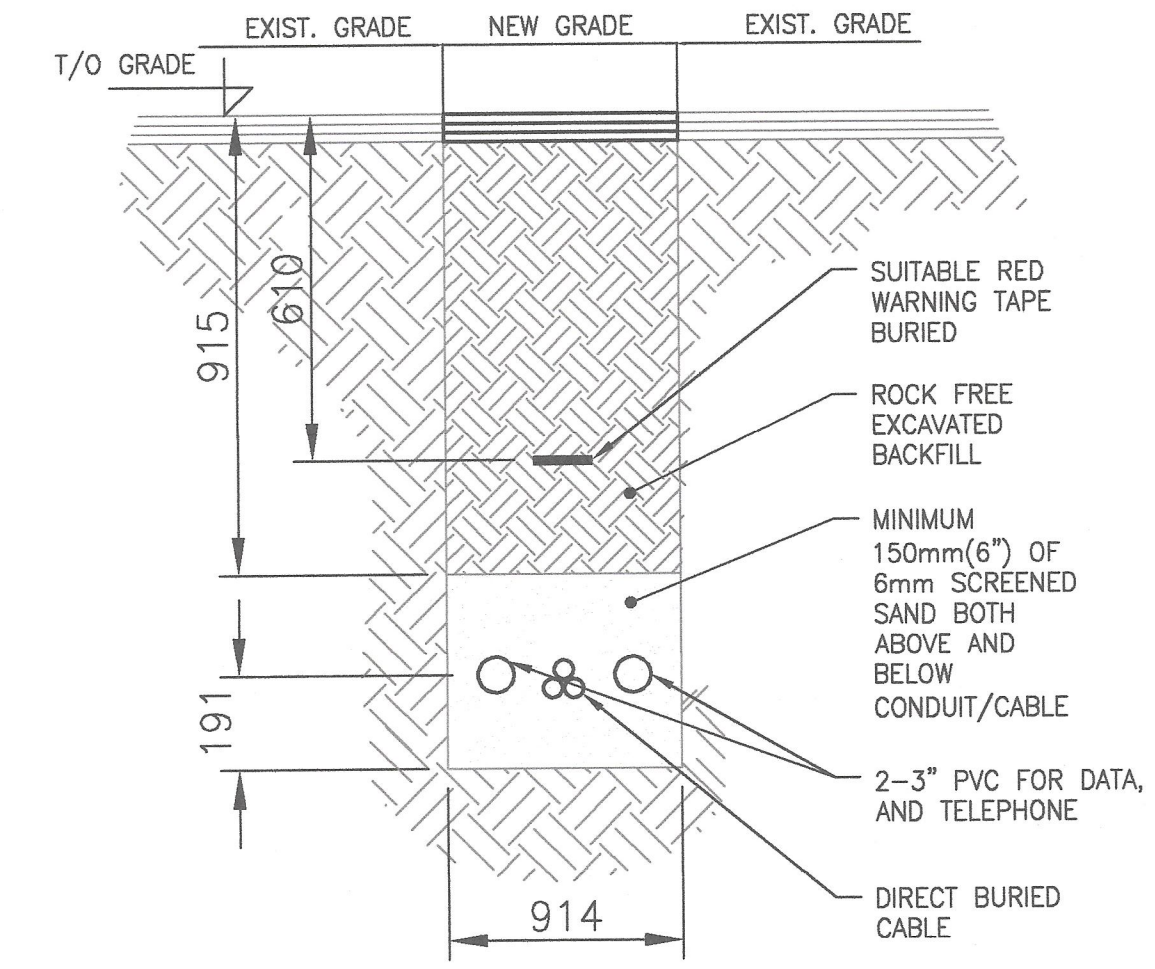

HYDRO SECONDARY TRENCH DETAIL (TYPICAL)
SCALE NTS

USE AND INTERPRETATION OF DRAWINGS:
DRAWINGS ARE NOT TO BE SCALED.
BY USE OF THE DRAWINGS FOR CONSTRUCTION OF THE PROJECT, THE OWNER REPRESENTS THAT HE HAS REVIEWED AND APPROVED THE DRAWINGS. THE CONTRACTOR REPRESENTS THAT HE HAS VISITED THE SITE, FAMILIARIZED HIMSELF WITH THE LOCAL CONDITIONS, VERIFIED FIELD DIMENSIONS AND CORRELATED HIS OBSERVATIONS WITH THE REQUIREMENTS OF THE CONTRACT DOCUMENTS.
THIS DRAWING ILLUSTRATES THE WORK TO BE DONE. THE ENGINEER IS NOT RESPONSIBLE FOR THE MEANS, METHODS, TECHNIQUES, SEQUENCES, AND PROCEDURES USED TO DO THE WORK, OR THE SAFETY ASPECTS OF CONSTRUCTION, AND NOTHING ON THIS DRAWING EXPRESSED OR IMPLIED CHANGES THIS CONDITION. CONTRACTOR SHALL DETERMINE ALL CONDITIONS AT THE SITE AND SHALL BE RESPONSIBLE FOR KNOWING HOW THEY AFFECT THE WORK.
UNAUTHORIZED CHANGES:
IN THE EVENT THE CLIENT, THE CLIENTS CONTRACTORS OR SUBCONTRACTORS, OR ANYONE FOR WHOM THE CLIENT IS LEGALLY LIABLE MAKES OR PERMITS TO BE MADE ANY CHANGES TO ANY REPORTS, PLANS, SPECIFICATIONS OR OTHER CONSTRUCTION DOCUMENTS PREPARED BY EFI WITHOUT OBTAINING EFI'S PRIOR WRITTEN CONSENT, THE CLIENT SHALL ASSUME FULL RESPONSIBILITY FOR THE RESULTS OF SUCH CHANGES. THEREFORE THE CLIENT AGREES TO WAIVE ANY CLAIM AGAINST EFI AND TO RELEASE EFI FROM ANY LIABILITY ARISING DIRECTLY OR INDIRECTLY FROM SUCH CHANGES.
IN ADDITION, THE CLIENT AGREES, TO THE FULLEST EXTENT PERMITTED BY LAW, TO INDEMNIFY AND HOLD HARMLESS EFI FROM ANY DAMAGES, LIABILITIES OR COSTS, INCLUDING REASONABLE ATTORNEY'S FEES AND COST OF DEFENSE, ARISING FROM SUCH CHANGES.
IN ADDITION, THE CLIENT AGREES TO INCLUDE IN ANY CONTRACTS FOR CONSTRUCTION APPROPRIATE LANGUAGE THAT PROHIBITS THE CONTRACTOR OR ANY SUBCONTRACTORS OF ANY TIER FROM MAKING ANY CHANGES OR MODIFICATIONS TO EFI'S CONSTRUCTION DOCUMENTS WITHOUT PRIOR WRITTEN APPROVAL OF EFI AND THAT FURTHER REQUIRES THE CONTRACTOR TO INDEMNIFY BOTH EFI AND THE CLIENT FROM ANY LIABILITY OR COST ARISING FROM SUCH CHANGES MADE WITHOUT SUCH PROPER AUTHORIZATION.

REFERENCES			
NO. REF.	NO. DWG.	TITLE	BY
1			

DATE	REV.	REVISIONS	BY	APP'D
2021/07/14	B	BUILDING 'A' FOOTPRINT CHANGE	AB	GC

DRAWING ISSUED FOR:
DATE: 2021 JULY 14
 CLIENT REVIEW BID/TENDER CONSTRUCTION
 INFORMATION PERMIT OTHER



UNAUTHORIZED USE OF DATA DISCLOSURE OF TECHNICAL INFORMATION CONTAINED HEREIN OR REPRODUCTION OF THIS DOCUMENT IN WHOLE OR IN PART FOR USE BY THIRD PARTIES IS PROHIBITED WITHOUT PRIOR WRITTEN PERMISSION FROM LOWE, GRWELLE & ASSOCIATES INC.

EFI Engineering
34 SOUTH BRANCH ROAD
CORNWALL ON K6K 1T4
T: (613) 936-0148
F: (613) 936-8451
engineer@efiengineering.com
www.efiengineering.com

ARCHITECT:
KWC ARCHITECTS INC.
383 PARKDALE AVE. SUITE 201
OTTAWA, ONTARIO K1Y 4R4

CLIENT:
BBS CONSTRUCTION (Ontario) LTD.

SITE: 103 SCHNEIDER RD
KANATA, ON

TITLE: BBS SCHNEIDER WAREHOUSES
ELECTRICAL SITE PLAN

SCALE: 1:500	DATE: 2021/06/15	DRAWN: AB	CHECKED: GC
--------------	------------------	-----------	-------------

PROJECT NO: 6848	DRAWING NO: E101	REVISION: B
------------------	------------------	-------------

QTY	UNIT	DESCRIPTION	NOM. DIM'N	LAMP	LENS	WATTS	MEAN LUMENS	VOLTAGE	ACCEPTABLE PRODUCT	NOTES
13	A	WALL LIGHT	-	LED		109	11279	347	LITHONIA DSXW2 LED 30C 1000 40K T3M MVOLT	OR APPROVED ALTERNATE
3	B	OUTDOOR AREA LIGHT		LED		102	11672	347	LITHONIA DSX1 LED P3 30K TFTM MVOLT	OR APPROVED ALTERNATE
2	C	OUTDOOR AREA LIGHT		LED		38	3585	347	LITHONIA DSX0 LED P1 30K BLC MVOLT	OR APPROVED ALTERNATE
6	D	WALL LIGHT		LED		25	2708	347	LITHONIA DSXW2 LED WITH 2 LIGHT ENGINES, 20 LED'S, 350mA DRIVER, 3000K LED, TYPE 2 MEDIUM OPTIC	OR APPROVED ALTERNATE
9	E	WALL LIGHT		LED		54	6467	347	LITHONIA DSXW2 LED WITH 3 LIGHT ENGINES, 30 LED'S, 530mA DRIVER, 4000K LED, TYPE 3 MEDIUM OPTIC	OR APPROVED ALTERNATE

6848E101-B