


**ORIFICE SUMMARY**

AREA NO	LOCATION	TYPE	RELEASE & HEAD
A1	BUILDING	BUILDING CISTERN WITH SUBM. PUMP	8.28 L/S
A2	RICHMOND ROAD	FREE FLOW	4.12 L/S

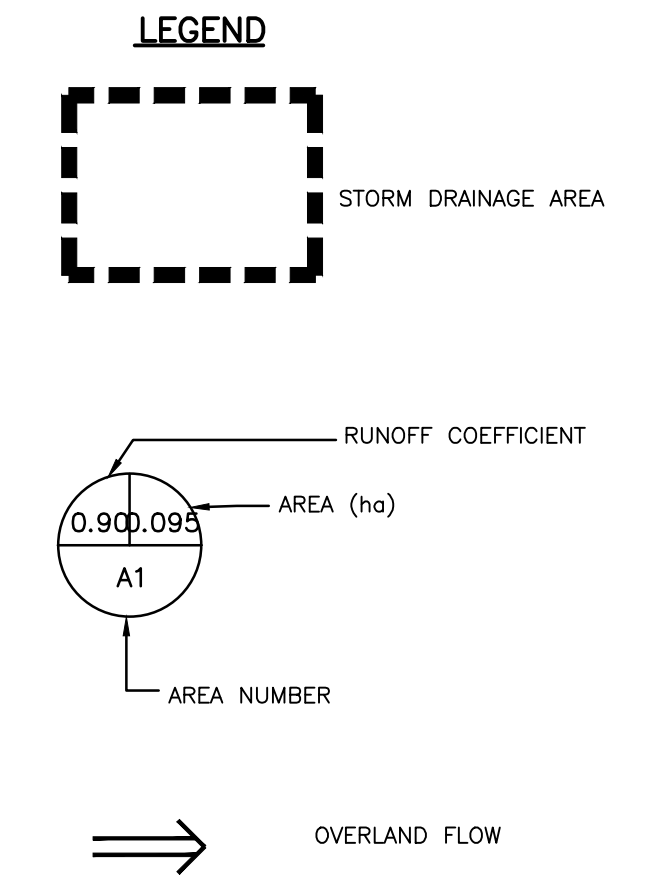

**CONTRACT DRAWINGS:**  
Contractor must verify all dimensions and be responsible for same. Any discrepancies must be reported to the Engineer before commencing work. Drawings are not to be copied, distributed or used by others without the express written consent of Ainley Graham & Associates Limited. Use of these drawings by any party for any other purpose is subject to the following caution.

**CAUTION:** The information contained in this drawing is solely for the intended recipient. Any copying, distribution or use by others without the express written consent of Ainley Graham & Associates Limited is prohibited. The recipient is responsible for confirming the accuracy and completeness of the information with the originator. The recipient assumes all risks and liabilities associated with the use of the drawings. The recipient will save and hold harmless Ainley Graham & Associates Limited for any claims whatsoever associated with or related to the use of the drawings. The recipient will not reuse any portion of the drawings for any future project without the express written permission of Ainley Graham & Associates Limited.

NO.	REVISIONS	DATE	INITIAL
5	ISSUED FOR SPC 2ND RESPONSE TO COMMENTS	JUNE 02/22	JX
4	RE-ISSUED FOR SITE PLAN APPROVAL	FEB 07/22	JX
3	REVISED PER CITY COMMENTS	JAN 03/22	JX
2	ISSUED FOR SITE PLAN APPROVAL	MAY 19/21	JX
1	ISSUED FOR REVIEW/COORDINATION	APR 26/21	JX

Not Valid Unless Signed And Dated

**Professional Engineers**  
Ontario  
June 02, 2022  
**Limited Licensee**  
Name: J.W.XU  
Number: 100171806  
Category: CIVIL-see limitation  
Limitations:  
This licence is subject to the limitations as detailed on the certificate.  
Association of Professional Engineers of Ontario

SCALE: 1 : 125  
DESIGN: JX  
DRAWN: MH  
CHECKED: GSC/JX  
DATE: MARCH 2021

DENTECH HOLDINGS INC  
PROPOSED APARTMENT  
797 RICHMOND ROAD  
CITY OF OTTAWA

PRE-DEVELOPMENT DRAINAGE AREA PLAN  
POST-DEVELOPMENT DRAINAGE AREA PLAN

CONSULTING ENGINEERS PLANNERS

CONTRACT No. 21006 006-21006-STM1