


Copyright Reserved

The Contractor shall verify and be responsible for all dimensions. DO NOT scale the drawing - any errors or omissions shall be reported to Stantec without delay.  
The Copyrights to all designs and drawings are the property of Stantec. Reproduction or use for any purpose other than that authorized by Stantec is forbidden.

Legend

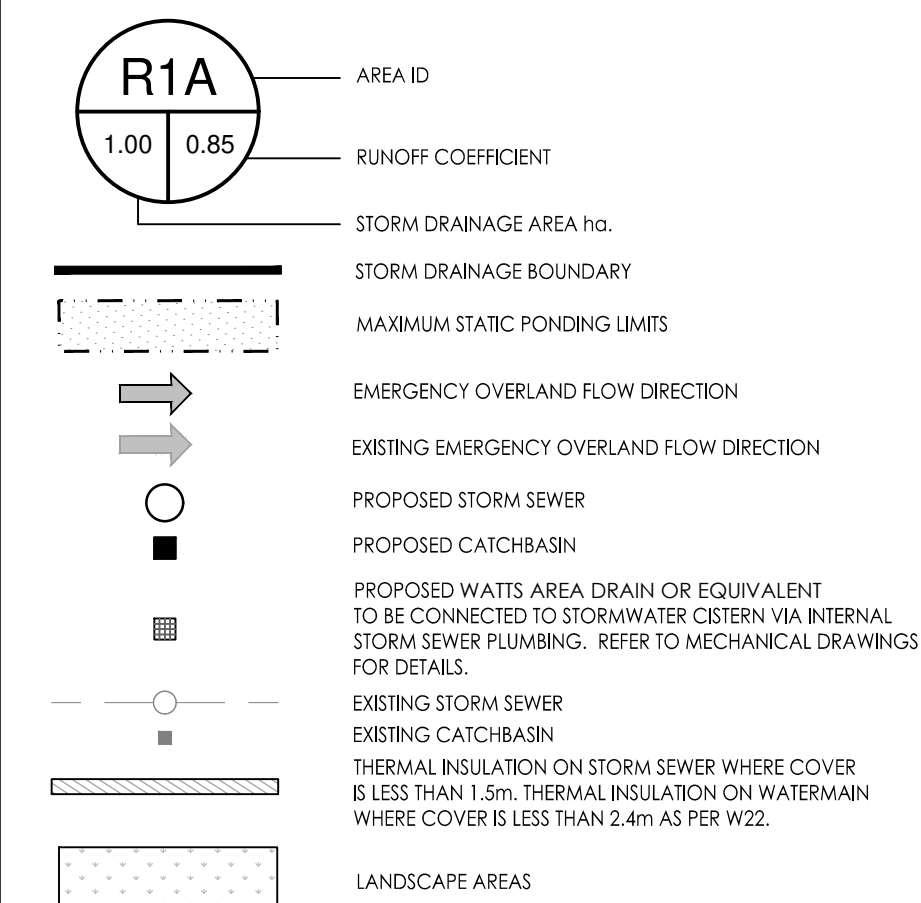

Notes

- INTERNAL PLUMBING AND SUMP PUMPS TO BE DESIGNED BY THE MECHANICAL CONSULTANT.
- ROOF DRAINS CONNECTED TO INTERNAL PLUMBING SYSTEM AND STORMWATER MANAGEMENT CISTERN.
- STORMWATER MANAGEMENT TO BE PROVIDED THROUGH A 120m<sup>3</sup> CISTERN LOCATED IN THE UNDERGROUND PARKING GARAGE.
- PUMP TO BE PROVIDED BY MECHANICAL ENGINEER TO ACHIEVE CISTERN MAX RELEASE RATE OF 38.1 L/s

Revision	By	Appd.	YY.MM.DD
3	MJS	DCT	24.09.18
2	WAJ	DCT	24.07.05
1	MJS	MF	23.03.15
0	MJS	AMP	21.02.17

Revision	By	Appd.	YY.MM.DD
3	MJS	DCT	24.09.18
2	WAJ	DCT	24.07.05
1	MJS	MF	23.03.15
0	MJS	AMP	21.02.17

File Name:	MJS	MF	MJS	21.01.07
160401596-DB	Dwn.	Chkd.	Dgn.	YY.MM.DD

Permit-Seal





Client/Project  
BRIGIL HOMES

2829 DUMAURIER AVENUE  
40 STOREY APARTMENT BUILDING  
OTTAWA, ON, CANADA

Title  
STORM DRAINAGE PLAN

Project No.	Scale	Sheet	Revision
160401596	1:300	7 of 8	3

Drawing No. SD-1  
Revision 3  
Title STORM DRAINAGE PLAN # 18503

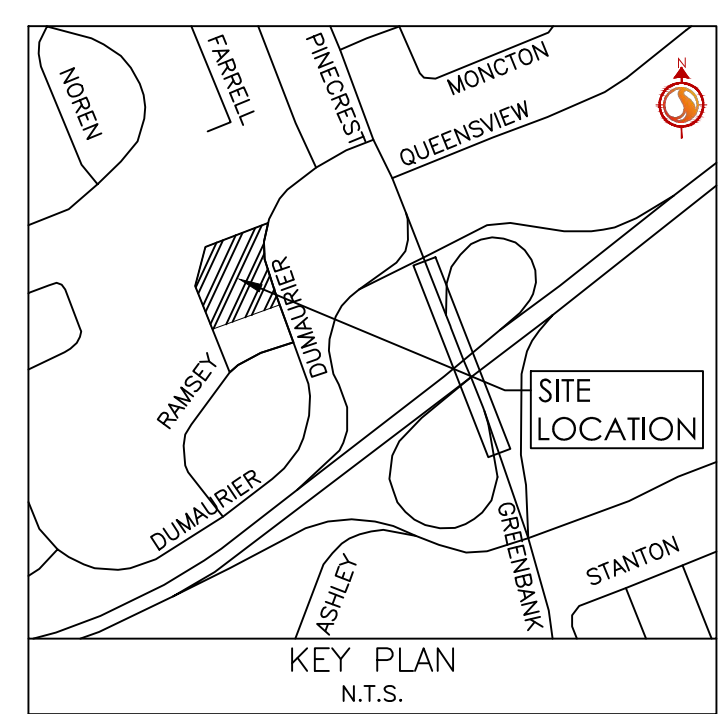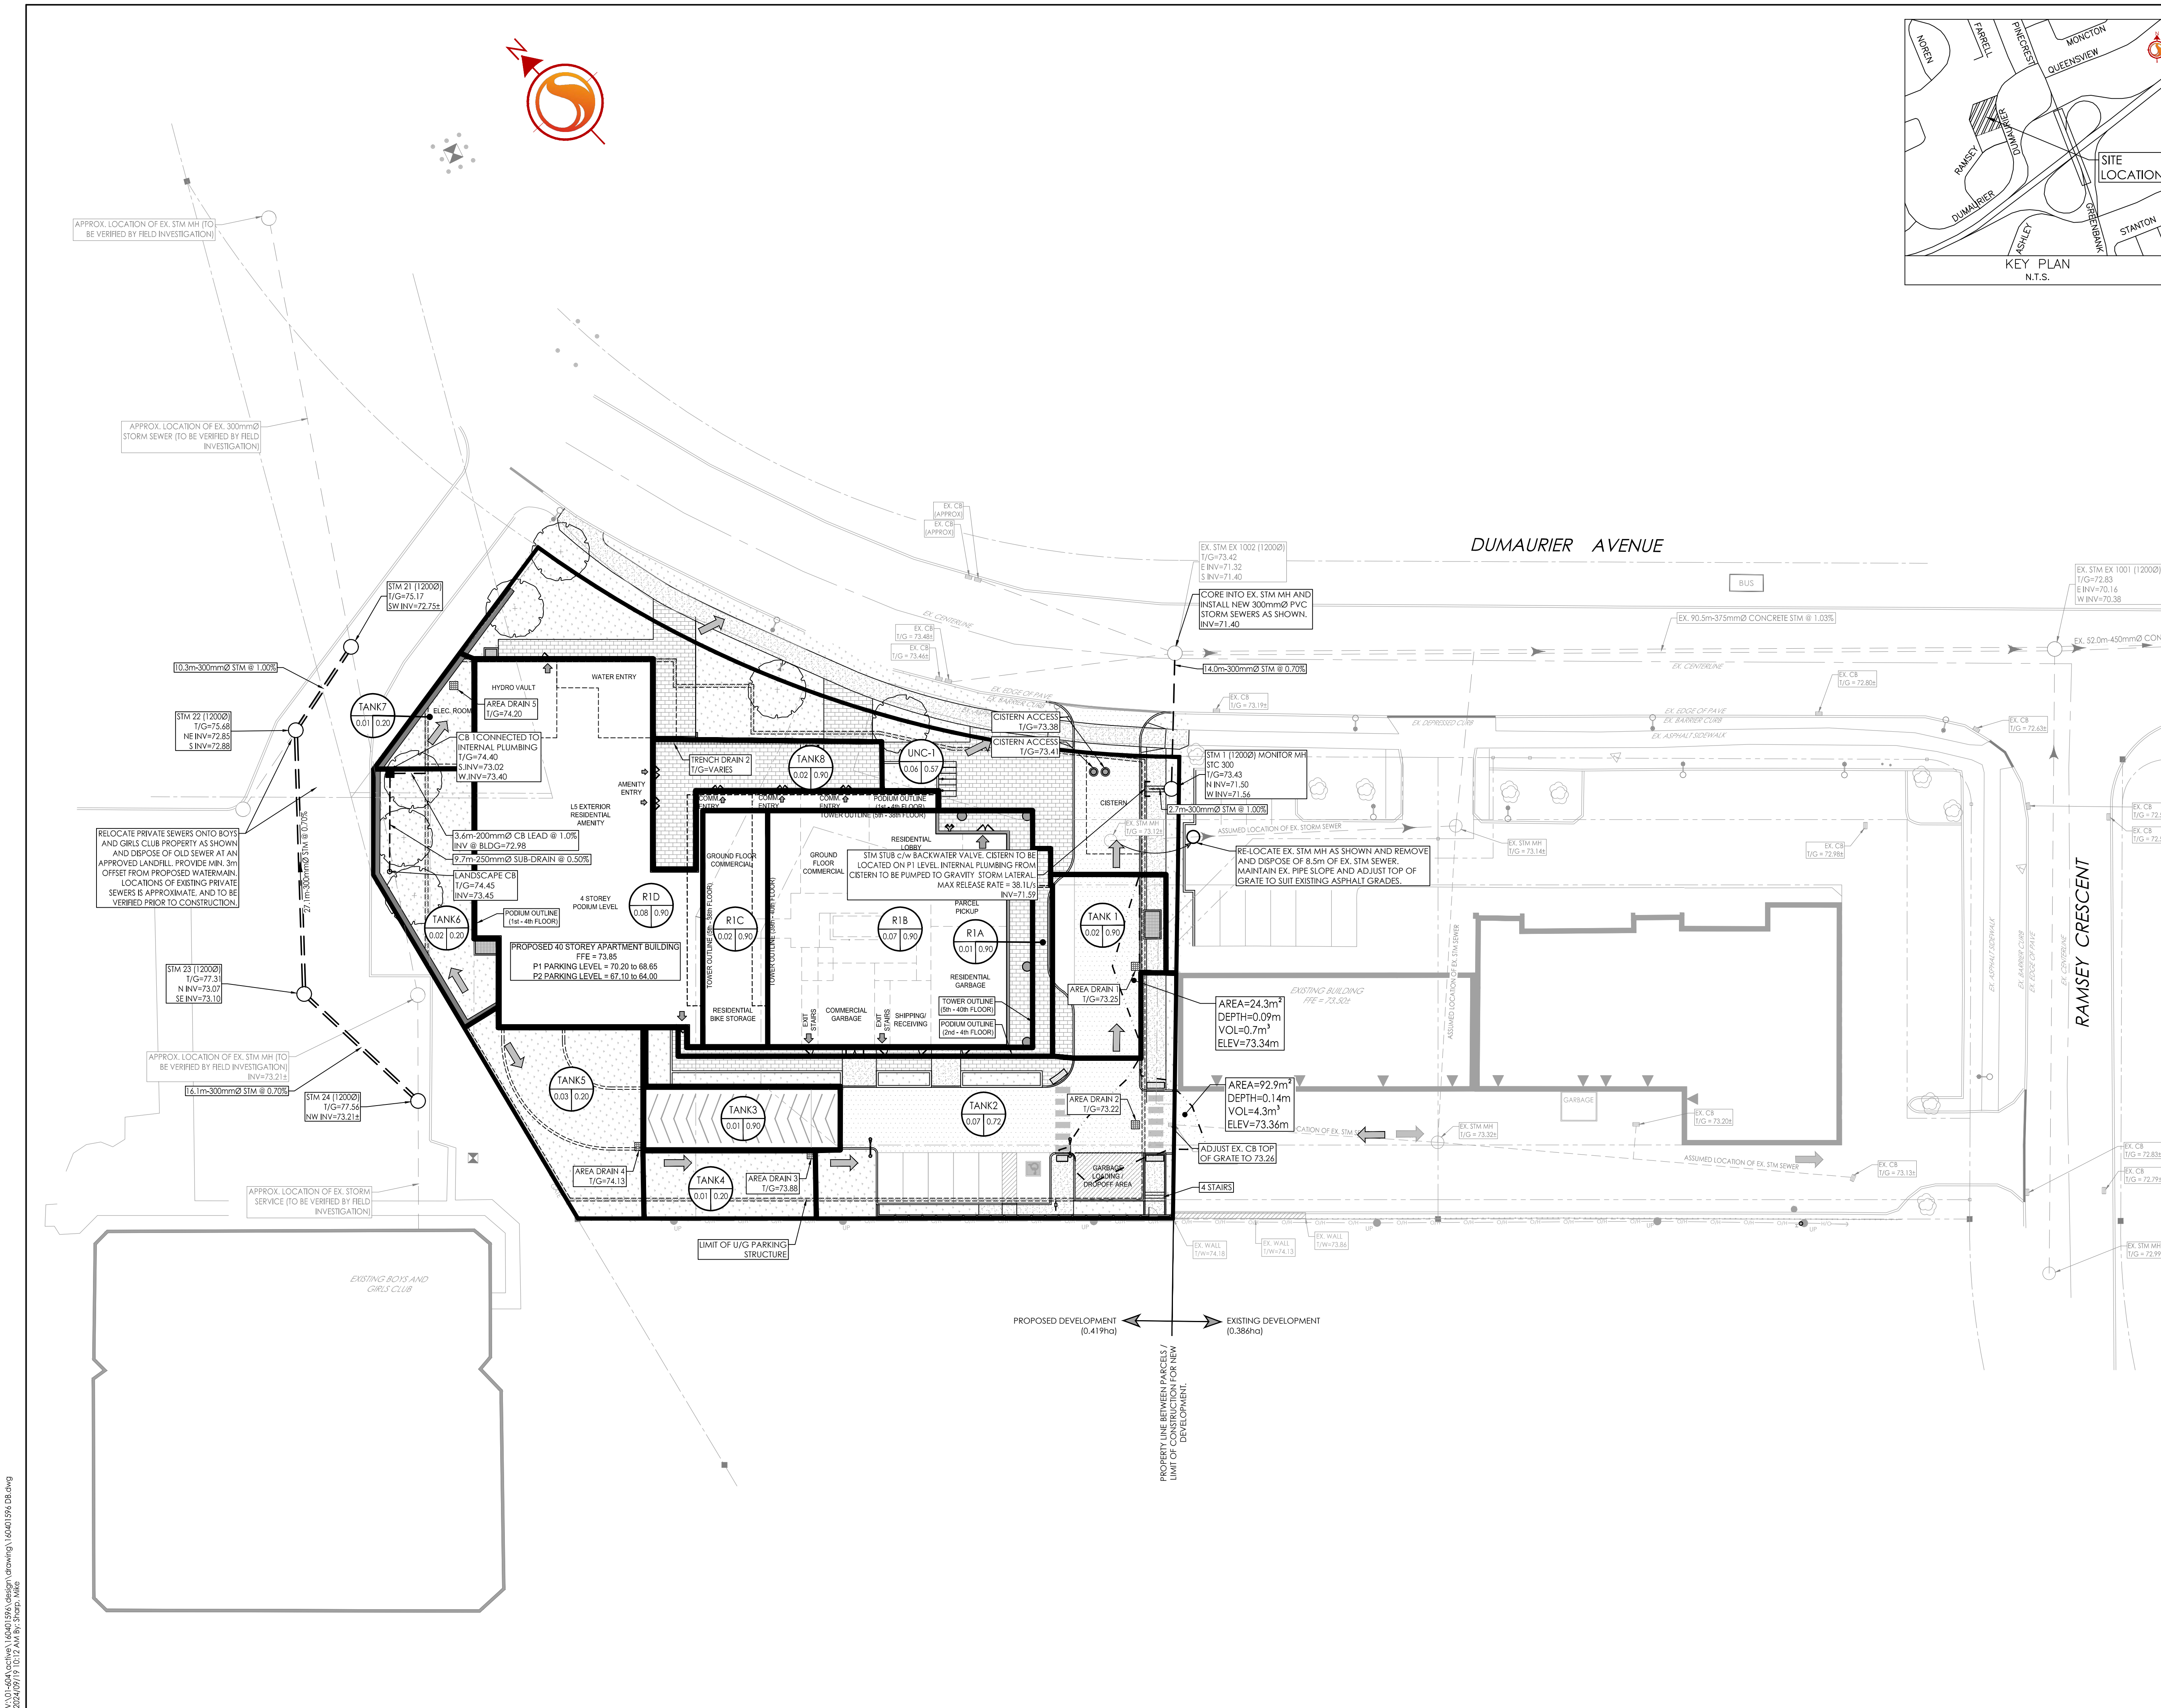

I:\1\160401596\160401596.dwg  
 2024/09/26 10:12 AM  
 160401596-DB.dwg