


DRAWING LEGEND

- MH (Symbol) STORM MANHOLE
- MH (Symbol) SANITARY MANHOLE
- VC (Symbol) VALVE CHAMBER
- SPL SPRINGLINE OF PIPE
- INV INVERT OF PIPE
- SAN SANITARY SEWER
- ST STORM SEWER
- WS/WM WATER SERVICE/WATERMAIN
- CS CURB STOP & STANDPOST
- FH FIRE HYDRANT
- WATER METER
- RM REMOTE WATER METER READOUT
- EXISTING GRADE ELEVATION
- +99.99 PROPOSED GRADE ELEVATION
- 2% PROPOSED SLOPE OF GRADE
- T.O.S TOP OF SLOPE
- PROPERTY LINE
- SILT FENCE BARRIER
- D.C. 150mm CURB/DEPRESSED CURB
- LIGHT DUTY ASPHALT PAVEMENT
- HEAVY DUTY ASPHALT PAVEMENT
- ROAD CUT RESTATEMENT
- CONCRETE
- PAVERS (SEE LANDSCAPE)
- LANDSCAPE
- RIVER WASH STONE
- RIP RAP
- C.R.Z CRITICAL ROOT ZONE
- FFL FIRST FLOOR ELEVATION
- TOF TOP OF FOUNDATION
- USF UNDERSIDE OF FOOTING

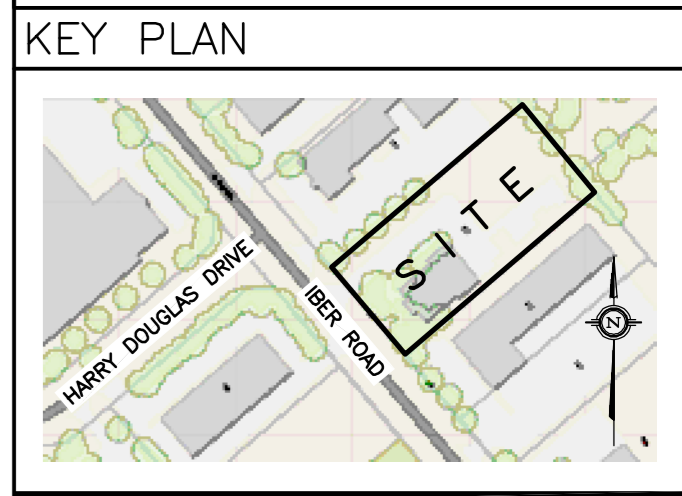

No.	DATE	REVISION
6	MAR 17-23	RE-ISSUED FOR APPROVAL
5	OCT 14-22	RE-ISSUED FOR APPROVAL
4	JAN 20-22	RE-ISSUED FOR APPROVAL
3	AUG 3-21	ISSUED FOR APPROVAL
2	JUL 13-21	ISSUED FOR COORDINATION
1	MAY 10-21	PRELIMINARY

D. B. GRAY ENGINEERING INC.
 Stormwater Management - Grading & Drainage - Storm & Sanitary Sewers - Watermain
 700 Long Point Circle 613-425-8044
 Ottawa, Ontario d.gray@dbgrayengineering.com

Project: **PROPOSED 1-STORY WAREHOUSE 155 IBER ROAD OTTAWA, ONTARIO**

Drawing Title: **GRADING PLAN**

Engineer's Seal: **D.B. GRAY 17016502 MAR 17-23**

Drawn: **D.B.G.**
 H. Scale: 1:250
 V. Scale: 1:250
 Date: MAY 10-21
 Job No.: 21024

Drawing No.: **C-2 of 6**

NOT VALID UNLESS SIGNED & DATED

GRADING PLAN

REFER TO NOTES, DETAILS & SCHEDULES ON DRAWINGS C-4 & C-5

07-12-21-0125
 #18553