


LEGEND

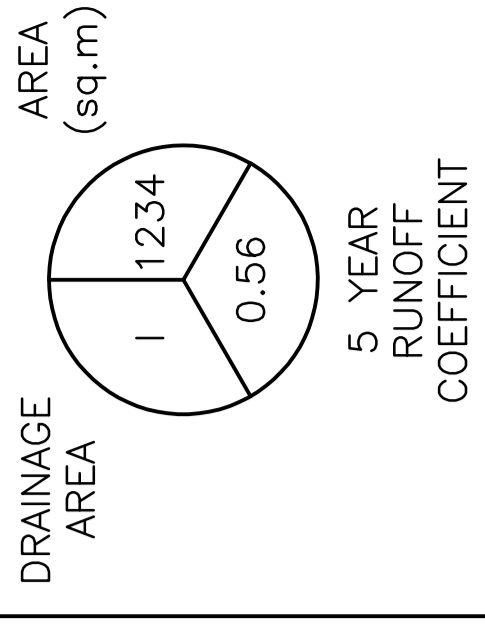

DRAINAGE AREA (sq.m)

5 YEAR RUNOFF COEFFICIENT

DRAINAGE PATTERN

KEY PLAN



No.	DATE	REVISION
3	AUG 3-21	ISSUED FOR APPROVAL
2	JUL 13-21	ISSUED FOR COORDINATION
1	MAY 10-21	PRELIMINARY

D. B. GRAY ENGINEERING INC.
 Professional Engineers
 700 Long Point Circle
 Ottawa, Ontario K1L 1A1
 613-425-8044
 d.gray@dbgrayengineering.com



PROPOSED WAREHOUSE
 155 IBER ROAD
 OTTAWA, ONTARIO

PRE AND POST DEVELOPMENT DRAINAGE PLANS

Engineer's Seal
 D.B.G.
 Drawn: 1:250
 H. Scale: 1:250
 V. Scale: 1:250
 Date: MAY 10-21
 Job No.: 21024

ENGINEERING PROFESSIONAL ENGINEER
 1701 6502
 AUG 3-21
 PROVINCE OF ONTARIO
 NOT VALID UNLESS SIGNED & DATED

Drawing No. **C-6**
 of **6**

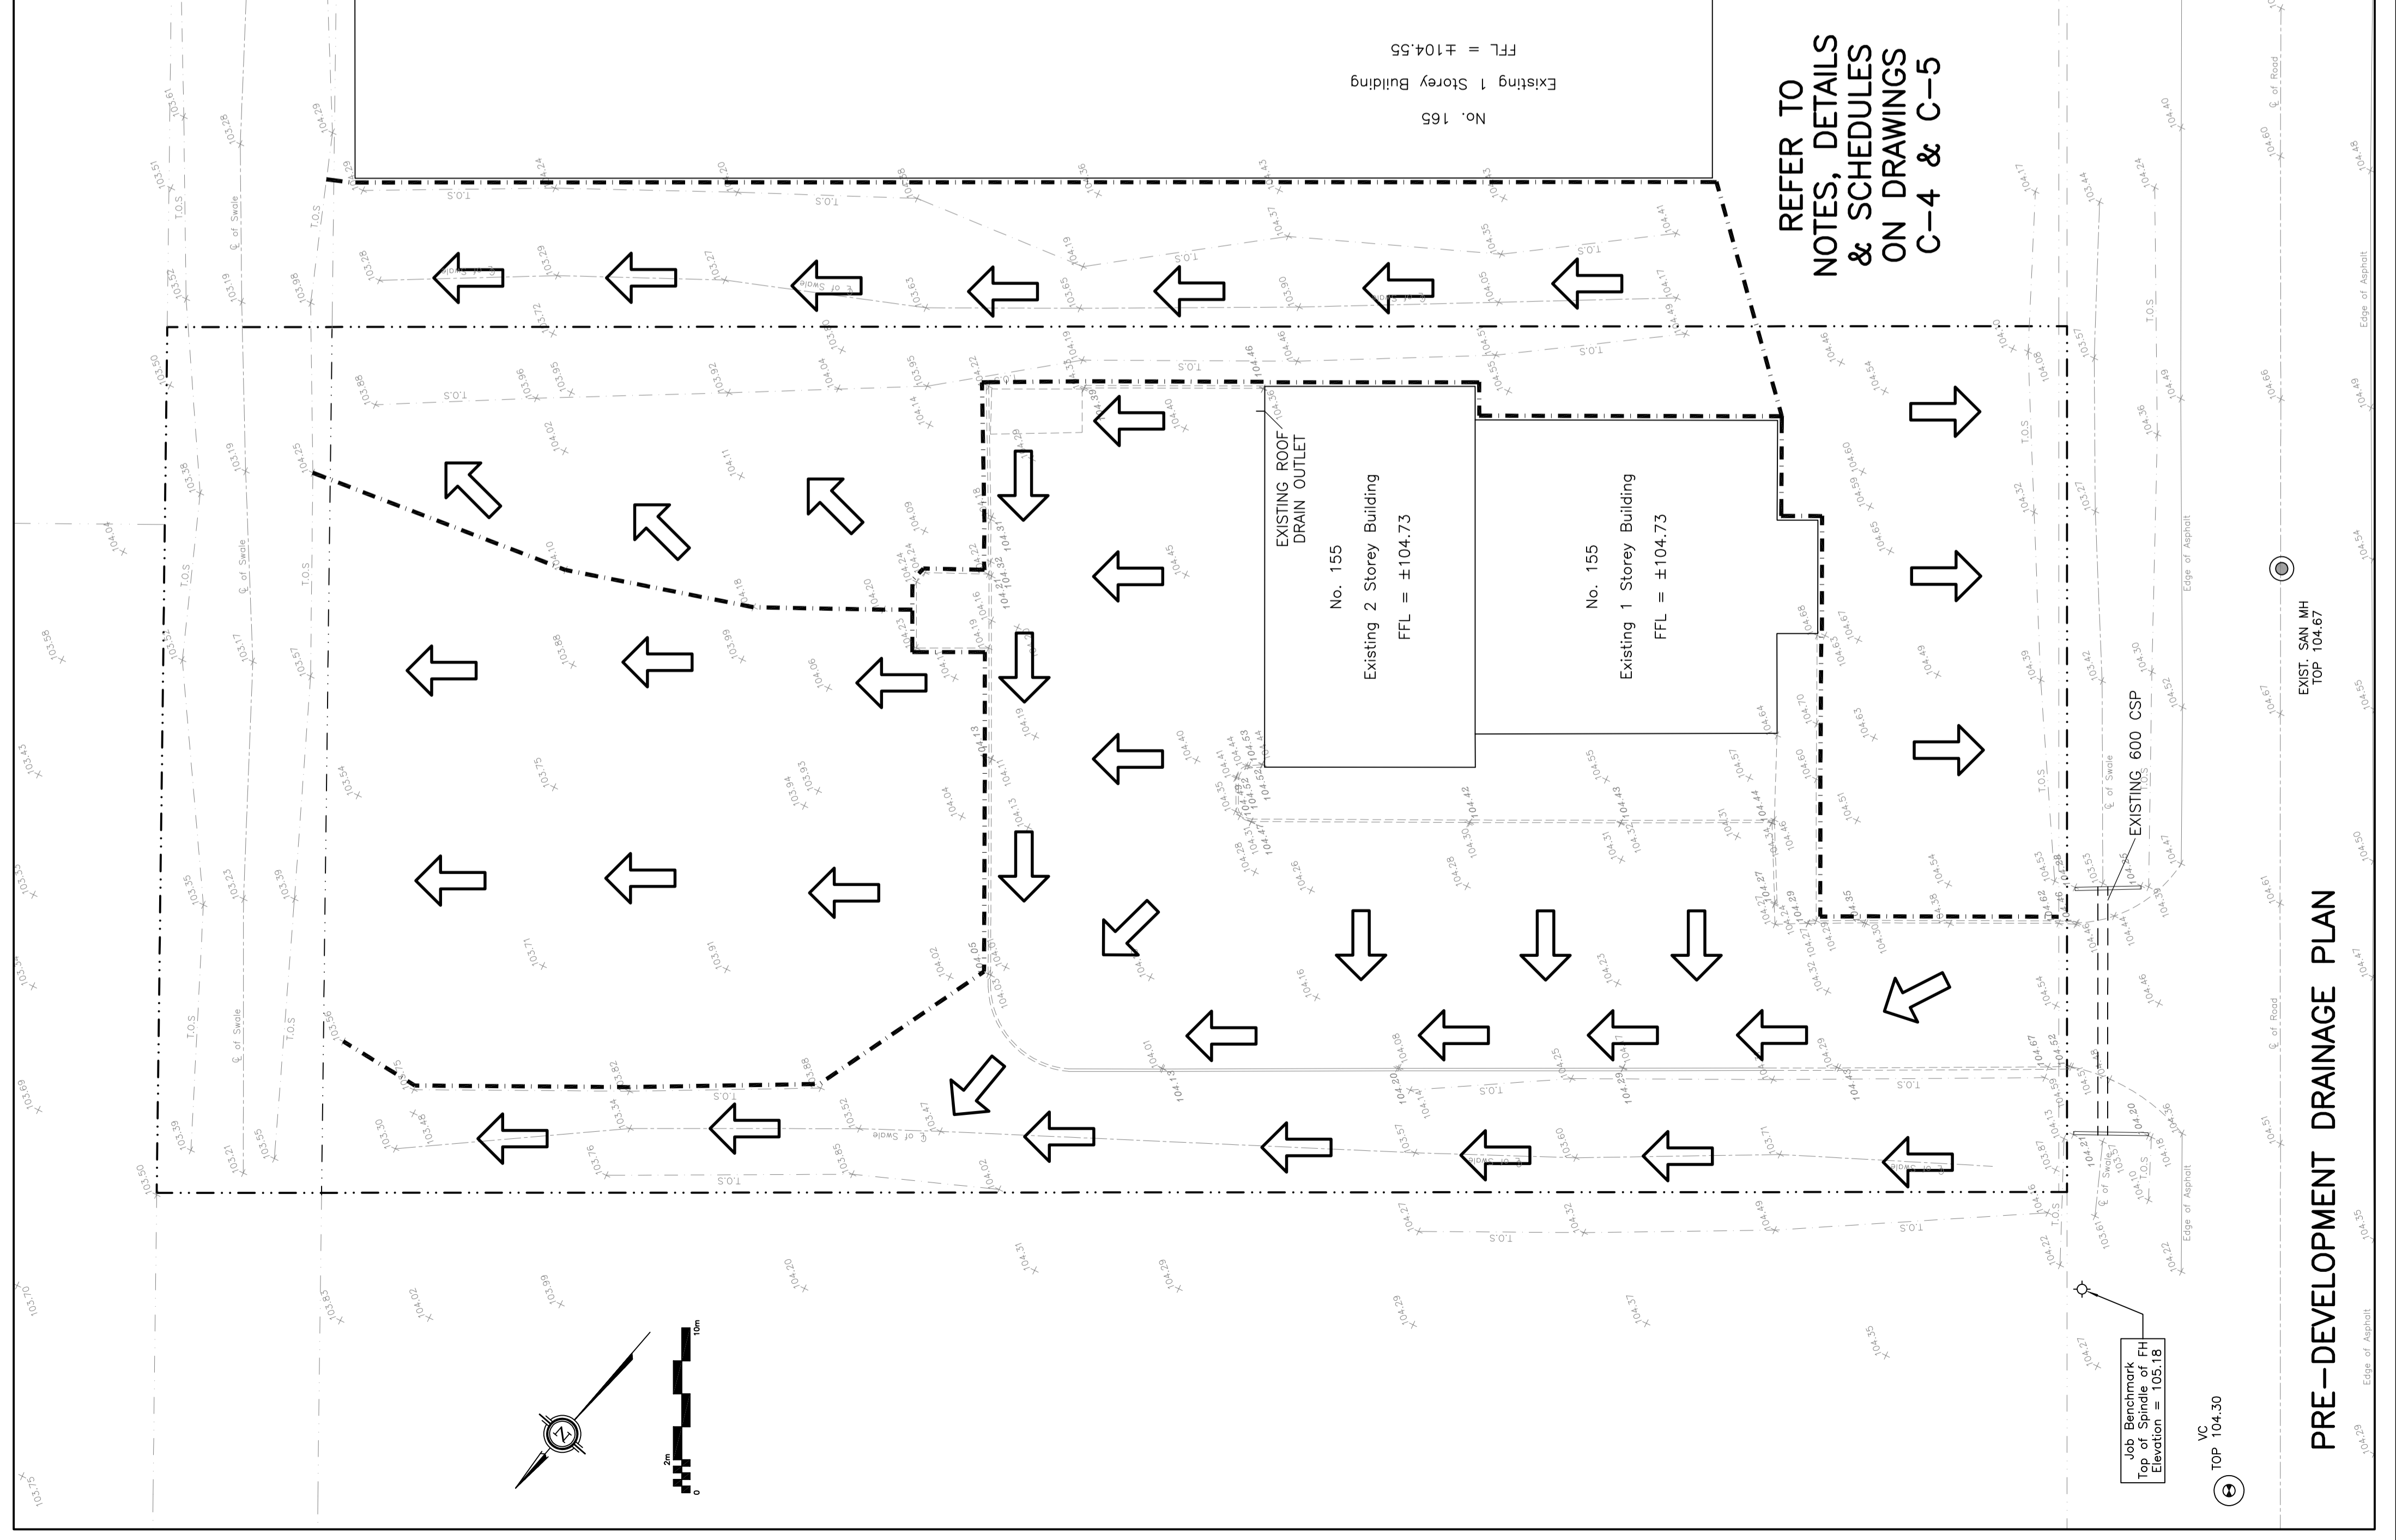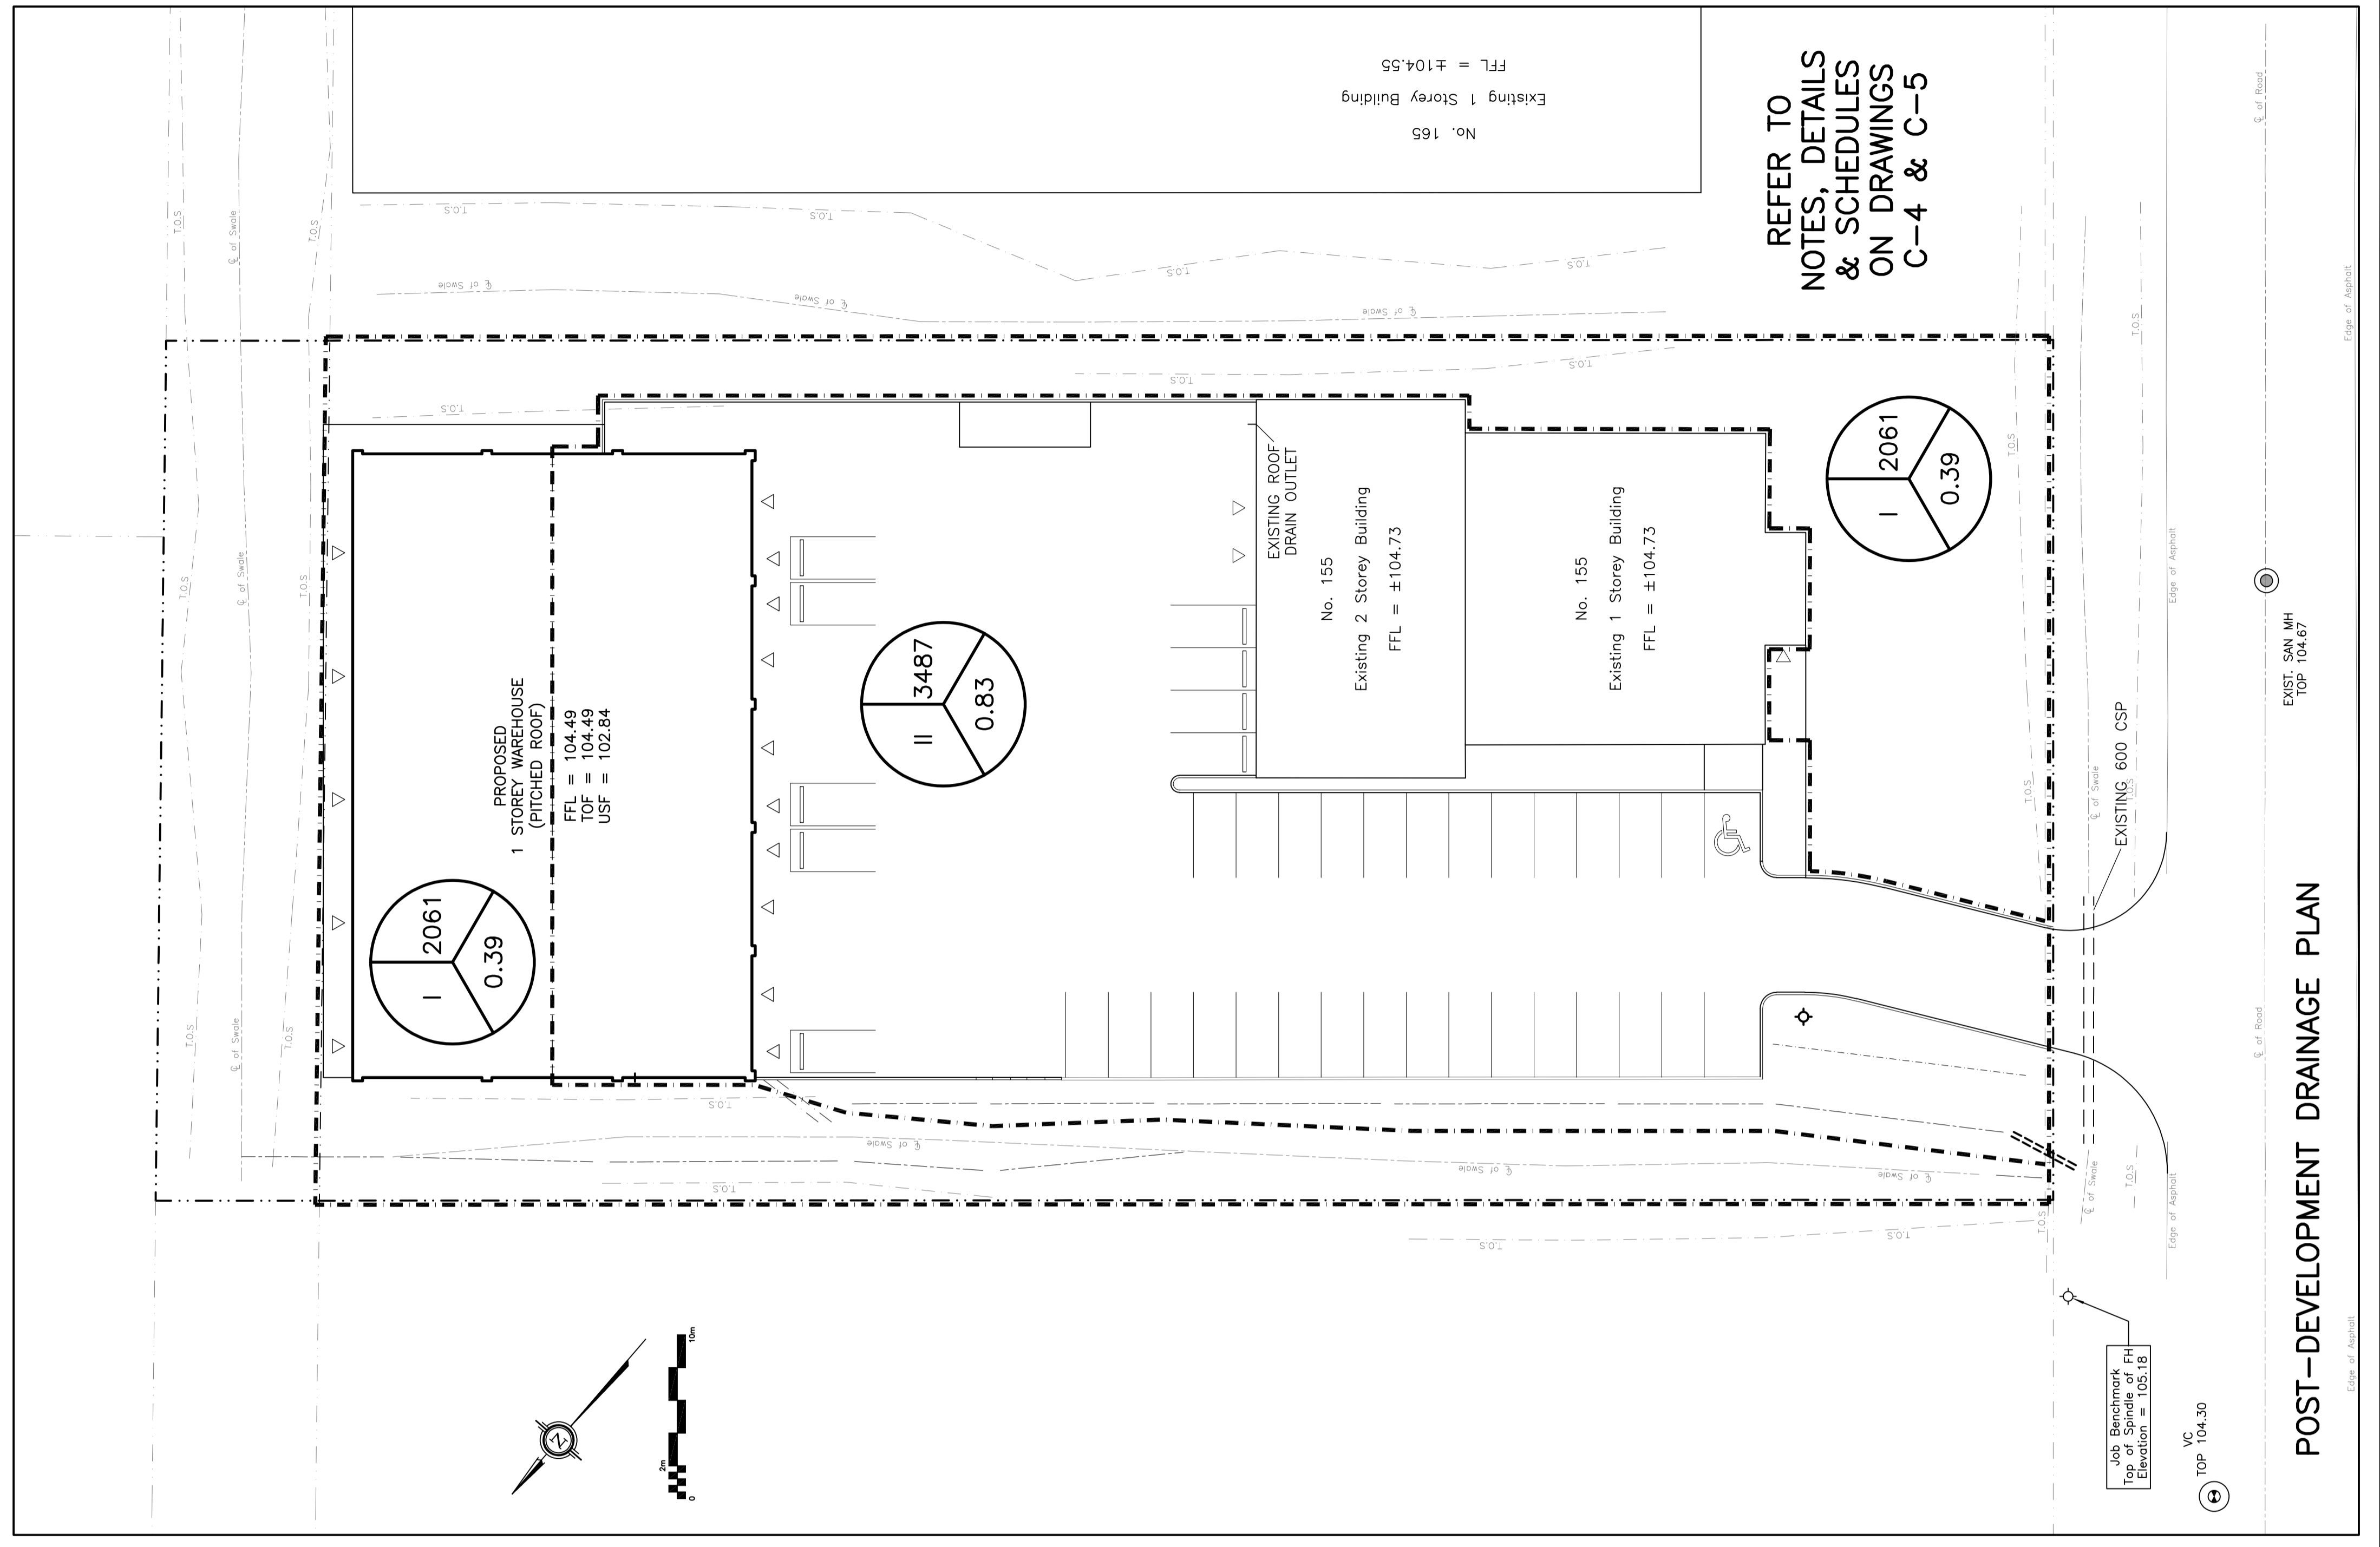

POST-DEVELOPMENT DRAINAGE PLAN

PRE-DEVELOPMENT DRAINAGE PLAN