

# FASTFRATE OTTAWA - NEW FACILITY

301 SOMME STREET, OTTAWA, ON.  
ELECTRICAL

CLIENT LOGO:




KEY PLAN:

DRAWING LIST	
SYMBOL	DESCRIPTION
E1	ELECTRICAL TITLE SHEET
E2	ELECTRICAL LIGHTING SITE PLAN NEW WORK

LIGHTING LEGEND	
SYMBOL	DESCRIPTION
	DOWNLIGHT FIXTURE - TYPE AS SHOWN
	WALL MOUNTED LIGHT FIXTURE - TYPE AS SHOWN
	LIGHT STANDARD SMALL AREA LIGHT- TYPE AS SHOWN

LIGHTING FIXTURE SCHEDULE									
TYPE	DESCRIPTION	CATALOG NUMBER	LAMPS PER FIXTURE			VOLT	MOUNTING	REMARKS	
			QTY	TYPE	WATTS				COLOUR
1	GARDOO SITE & AREA ECOFORM ECF-S SMALL AREA LIGHT	ECF-S-48L-900-NW-G2-AR-4-UNV-BL-IMR03-HIS-BZ	14	LED	135	4000K	347V	POLE MOUNTED	-
2	GARDOO SITE & AREA ECOFORM ECF-S SMALL AREA LIGHT	ECF-S-32L-700-NW-G2-AR-3-UNV-BL-IMR03-HIS-BZ	3	LED	73	4000K	347V	POLE MOUNTED	-
3	GARDOO SITE & AREA ECOFORM ECF-S SMALL AREA LIGHT	ECF-S-32L-700-NW-G2-AR-4-UNV-BL-IMR03-BZ	7	LED	73	4000K	347V	POLE MOUNTED	-
4	GARDOO WALL MOUNTED SCONCE 121	121-32L-1000-NW-G4-4-UNV-BL-IMR03-BZ	11	LED	107	4000K	347V	WALL MOUNTED	-
5	LIGHTOLIER DOWNLIGHTING EASYLYTE	Z4RD120835W0WHZ10U 4RN	54	LED	20	3500K	347V	RECESSED	-

NOTES:  
1. ALL ACRYLIC LENSES SHALL BE MINIMUM 0.125" THICK.  
2. COORDINATE AIMING OF ADJUSTABLE FIXTURES WITH INTERIOR DESIGNER AND CLIENT.

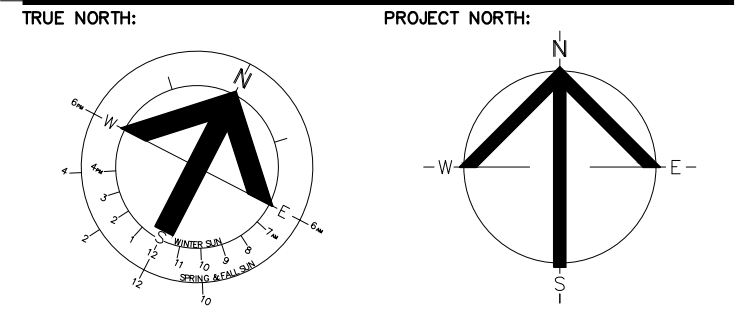

**PRELIMINARY**  
NOT FOR CONSTRUCTION

RECORD OF REVISIONS:	
6	
5	
4	
3	
2	
1	ISSUED FOR SITE PLAN 08/06/21

NUMBER: REVISION: DATE: (MM/DD/YY)  
ISSUE:

PROFESSIONAL STAMP: PROFESSIONAL STAMP:



CIVITAS ARCHITECTURE INC. OTTAWA, ON  
6 4 3 2 7 4 3 2 7 4 8 2  
14 CHAMBERLAIN AVENUE, SUITE 101 CANADA K1S 1V8  
WWW.CIVITAS-INC.CA



GOODKEY WEEDMARK & ASSOCIATES LIMITED  
1688 Woodward Dr. Ottawa Ontario Canada K2C 3R8  
613 727-5111 Voice  
613 727-5115 Fax  
www.gwal.com Web

PROJECT TITLE:  
FASTFRATE OTTAWA  
NEW FACILITY

301 SOMME STREET

DRAWING TITLE:

ELECTRICAL  
TITLE SHEET

DRAWN BY:	N.YARASKAVITCH	DRAWING NUMBER:	
DATE:	21/08/06		
REVIEWED BY:	J.MORFFAT		
APPROVED BY:	J.MORFFAT		E1
PRINT DATE:		REVISION NUMBER:	
ISSUED DATE:	21/08/06		
CLIENT PROJECT #:		PROJECT #:	2020-514


DO NOT SCALE THIS DRAWING. USE FIGURE DIMENSIONS ONLY. THE CONTRACTOR IS RESPONSIBLE FOR VERIFYING ALL DIMENSIONS AND NOTIFYING THE ARCHITECT OF ANY DISCREPANCIES BEFORE CONSTRUCTION COMMENCES. THIS DRAWING IS TO BE READ IN CONJUNCTION WITH ALL STRUCTURAL, MECHANICAL, ELECTRICAL, CIVIL AND OTHER CONSULTANT DRAWINGS. THIS DRAWING SHALL NOT BE USED FOR CONSTRUCTION PURPOSES UNLESS SIGNED BY THE ARCHITECT. COPYRIGHT RESERVED. ALL PARTS OF THIS DRAWING ARE THE EXCLUSIVE PROPERTY OF THE ARCHITECT.



CLIENT LOGO:



KEY PLAN:

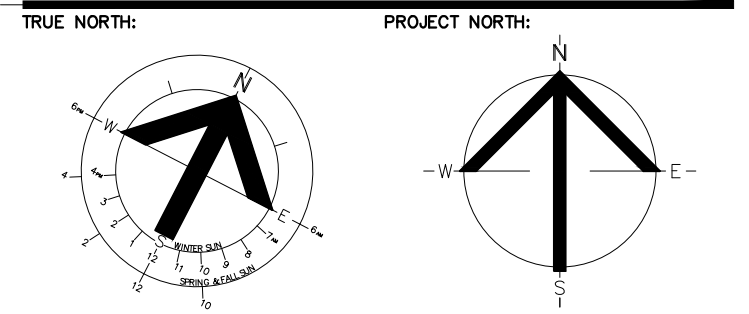

**PRELIMINARY**  
NOT FOR CONSTRUCTION

RECORD OF REVISIONS:

6		
5		
4		
3		
2		
1	ISSUED FOR SITE PLAN	08/06/21
NUMBER: REVISION:		DATE: (MM/DD/YY)

PROFESSIONAL STAMP: PROFESSIONAL STAMP:



CIVITAS ARCHITECTURE INC. OTTAWA, ON  
6 14 CHAMBERLAIN AVENUE, SUITE 101 CANADA K1S 1V8  
WWW.CIVITAS-INC.CA



GOODKEY WEEDMARK & ASSOCIATES LIMITED  
1688 Woodward Dr. Ottawa Ontario Canada K2C 3R8  
613 727-5111 Voice 613 727-5115 Fax www.gwal.com Web

PROJECT TITLE:  
FASTFRATE OTTAWA  
NEW FACILITY

301 SOMME STREET


DRAWING TITLE:

**ELECTRICAL  
LIGHTING SITE PLAN  
NEW WORK**

DRAWN BY:	N.YARASKAVITCH	DRAWING NUMBER:	
DATE:	21/08/06		
REVIEWED BY:	J.MOFFAT		
APPROVED BY:	J.MOFFAT		E2
PRINT DATE:		REVISION NUMBER:	
ISSUED DATE:	21/08/06		
CLIENT PROJECT #:	2021-08-06	PROJECT #:	2020-514

DO NOT SCALE THIS DRAWING. USE FIGURE DIMENSIONS ONLY. THE CONTRACTOR IS RESPONSIBLE FOR VERIFYING ALL DIMENSIONS AND NOTIFYING THE ARCHITECT OF ANY DISCREPANCIES BEFORE CONSTRUCTION COMMENCES. THIS DRAWING IS TO BE READ IN CONJUNCTION WITH ALL STRUCTURAL, MECHANICAL, ELECTRICAL, CIVIL AND OTHER CONSULTANT DRAWINGS. THIS DRAWING SHALL NOT BE USED FOR CONSTRUCTION PURPOSES UNLESS SIGNED BY THE ARCHITECT. COPYRIGHT RESERVED. ALL PARTS OF THIS DRAWING ARE THE EXCLUSIVE PROPERTY OF THE ARCHITECT.

- DRAWING NOTES**
- TYPICAL:** PROVIDE NEW TYPE (1) LIGHT FIXTURE C/W CONDUIT AND WIRE AND CONNECT TO NEW TIME CLOCK SYSTEM AND NEW EXTERIOR LIGHTING CIRCUIT. COORDINATE EXACT LOCATION, MOUNTING AND MOUNTING HEIGHT ON SITE WITH CLIENT REPRESENTATIVE AND ARCHITECT.
  - TYPICAL:** PROVIDE NEW TYPE (2) LIGHT FIXTURE C/W CONDUIT AND WIRE AND CONNECT TO NEW TIME CLOCK SYSTEM AND NEW EXTERIOR LIGHTING CIRCUIT. COORDINATE EXACT LOCATION, MOUNTING AND MOUNTING HEIGHT ON SITE WITH CLIENT REPRESENTATIVE AND ARCHITECT.
  - TYPICAL:** PROVIDE NEW TYPE (3) LIGHT FIXTURE C/W CONDUIT AND WIRE AND CONNECT TO NEW TIME CLOCK SYSTEM AND NEW EXTERIOR LIGHTING CIRCUIT. COORDINATE EXACT LOCATION, MOUNTING AND MOUNTING HEIGHT ON SITE WITH CLIENT REPRESENTATIVE AND ARCHITECT.
  - TYPICAL:** PROVIDE NEW TYPE (4) LIGHT FIXTURE C/W MOTION SENSOR, CONDUIT AND WIRE AND CONNECT TO NEW EXTERIOR LIGHTING CIRCUIT. COORDINATE EXACT LOCATION, MOUNTING AND MOUNTING HEIGHT ON SITE WITH CLIENT REPRESENTATIVE AND ARCHITECT.
  - TYPICAL:** PROVIDE NEW TYPE (5) LIGHT FIXTURE C/W CONDUIT AND WIRE AND CONNECT TO NEW TIME CLOCK SYSTEM AND NEW EXTERIOR LIGHTING CIRCUIT. COORDINATE EXACT LOCATION, MOUNTING AND MOUNTING HEIGHT ON SITE WITH CLIENT REPRESENTATIVE AND ARCHITECT.

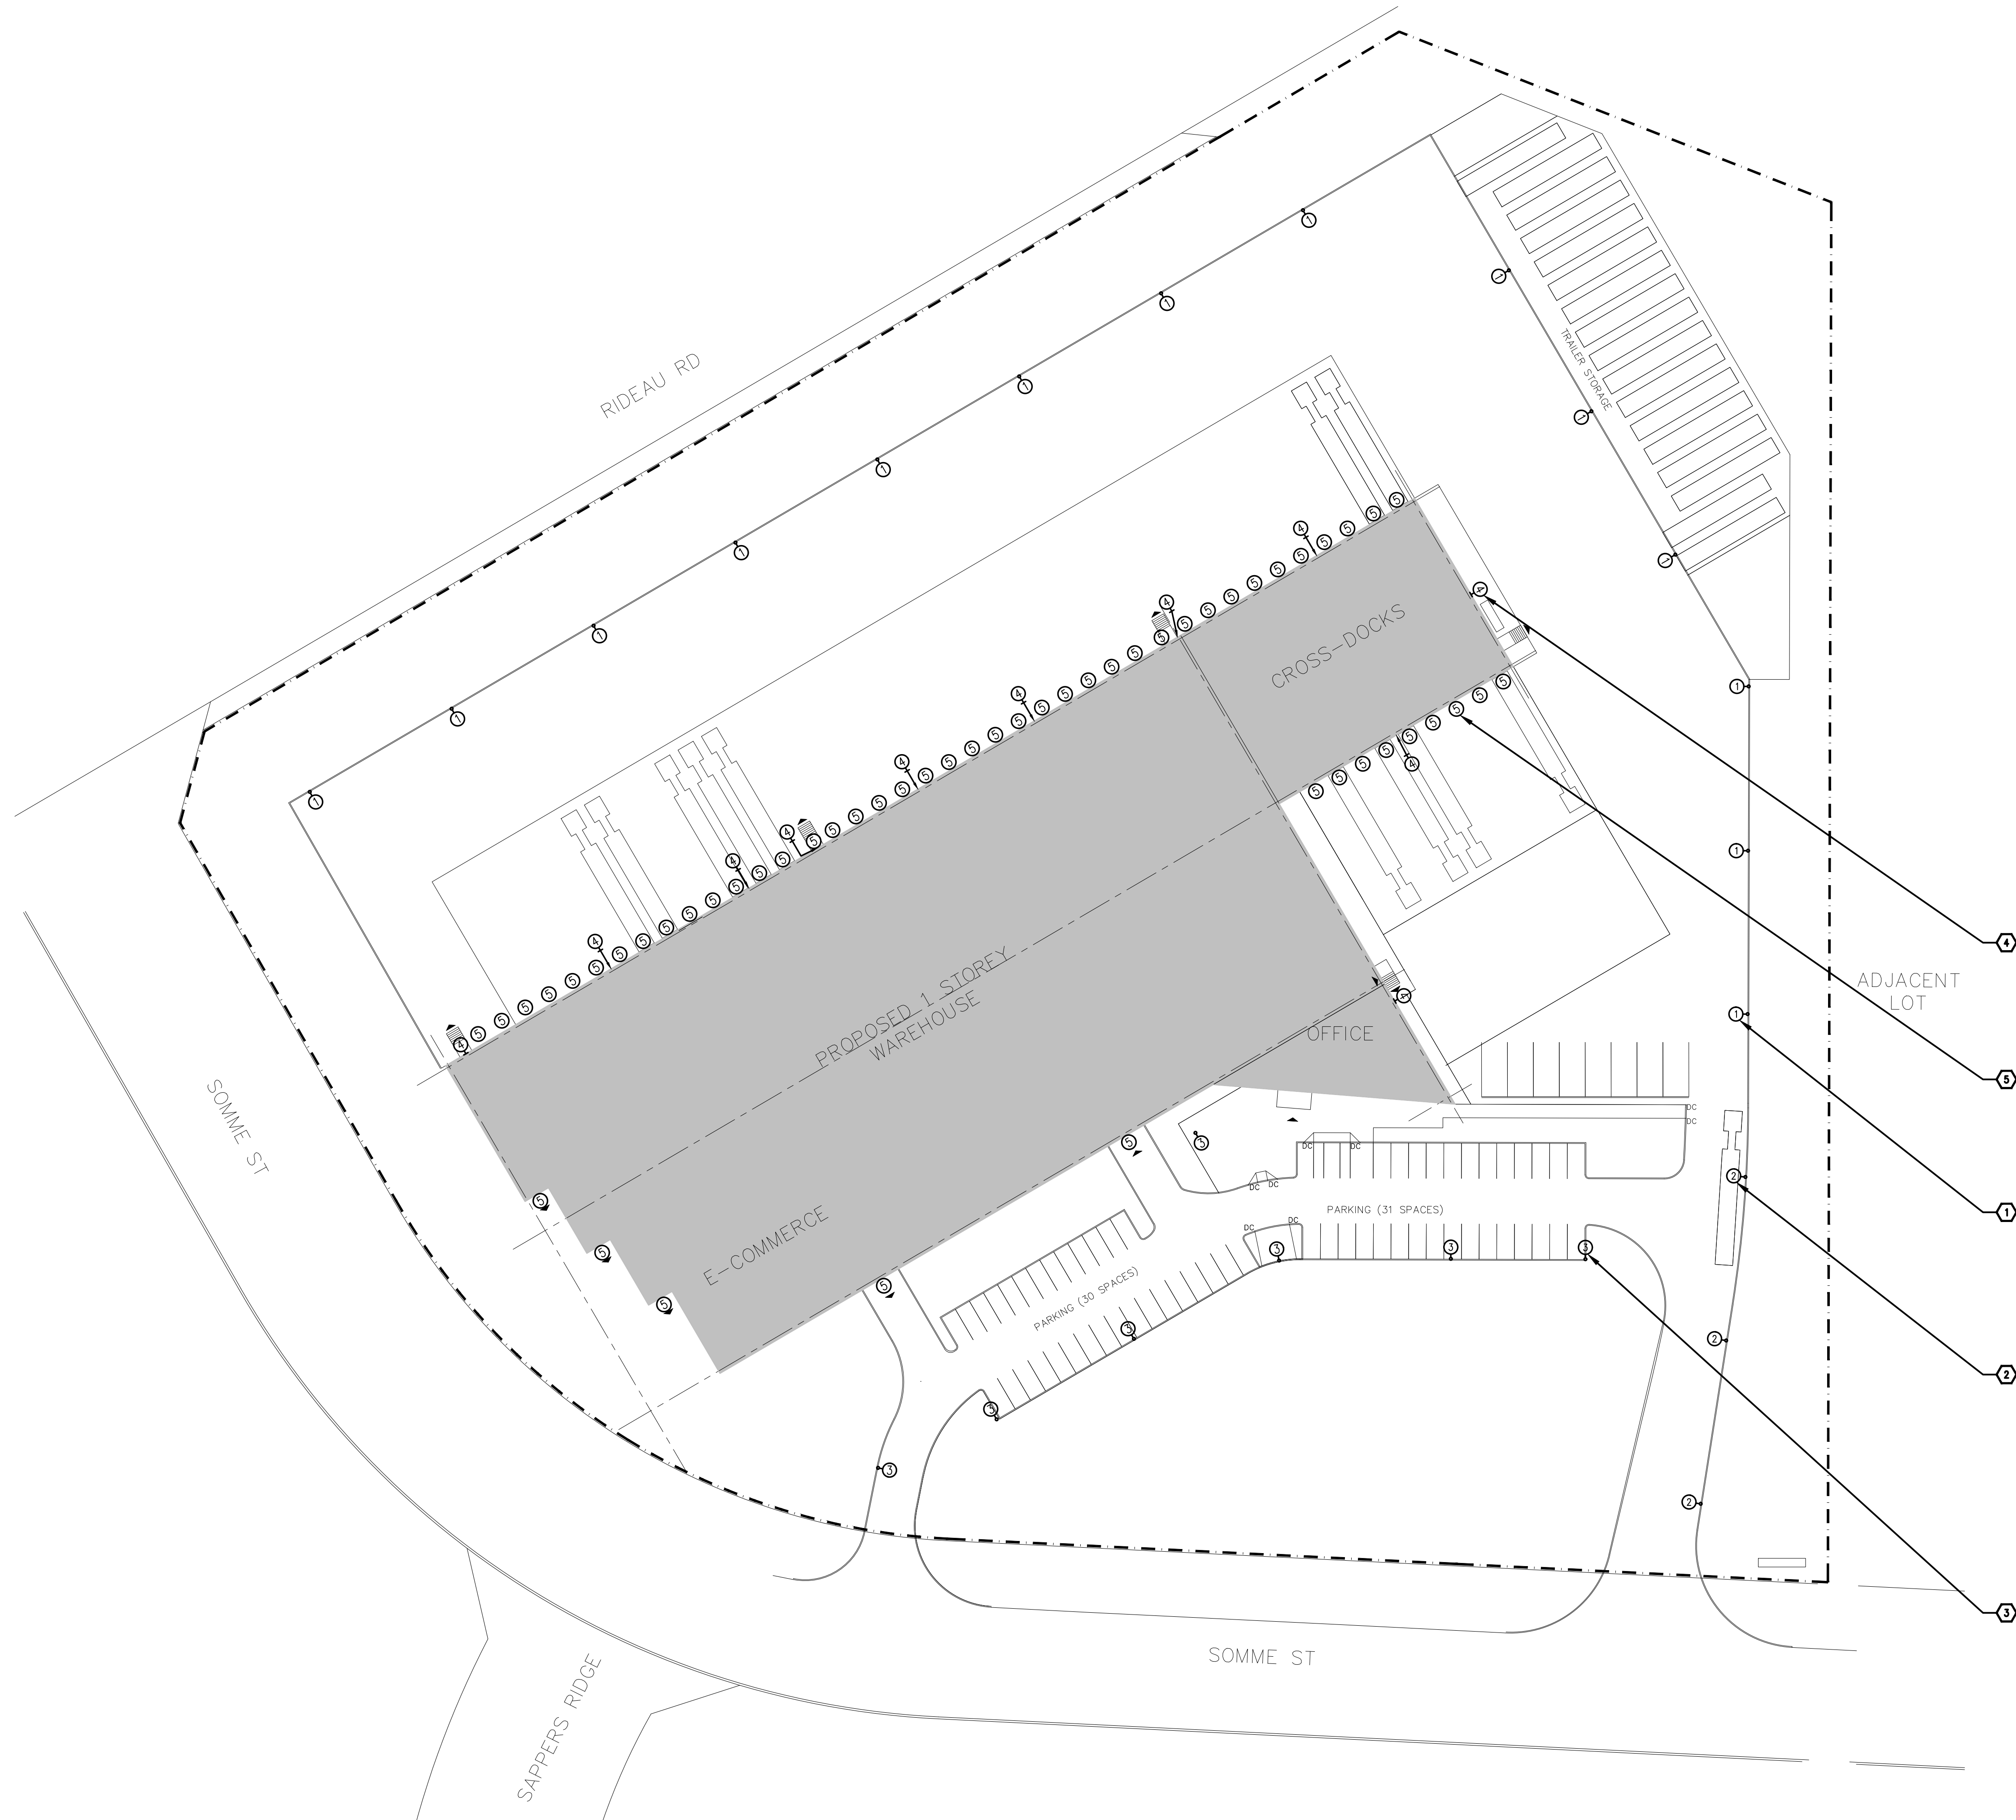

1 SITE PLAN  
E2 1:500



Z:\2020\2020-514\ELECTRICAL