


OWNER:
 SMART LOCAL 47
 TRAINING CENTER INC
 765 GREEN CREEK DR
 GLOUCESTER ON
 K1J 0B2
 613-724-6116

LEGEND

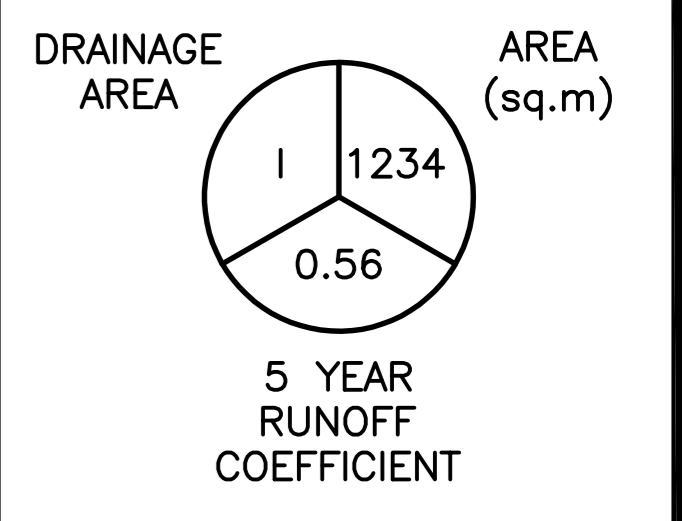


No.	DATE	REVISION
1	APR 21-23	ISSUED FOR APPROVAL

D. B. GRAY ENGINEERING INC.
 Stormwater Management - Grading & Drainage - Storm & Sanitary Sewers - Manholes
 700 Long Point Circle 613-425-8044
 Ottawa, Ontario d.gray@dbgrayengineering.com

Project
**SMART LOCAL 47
 TRAINING CENTRE**
 765 GREEN CREEK DRIVE
 OTTAWA, ONTARIO

Drawing Title
**PRE (EXISTING)
 DEVELOPMENT
 DRAINAGE PLAN**

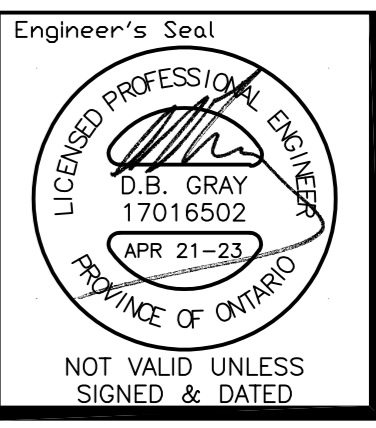

Drawn D.B.G.
 Hor. Scale 1:200
 Vert. Scale
 Date SEP 10-20
 Job 20014
 Drawing No.
C-4
 of 4

NOT VALID UNLESS SIGNED & DATED