


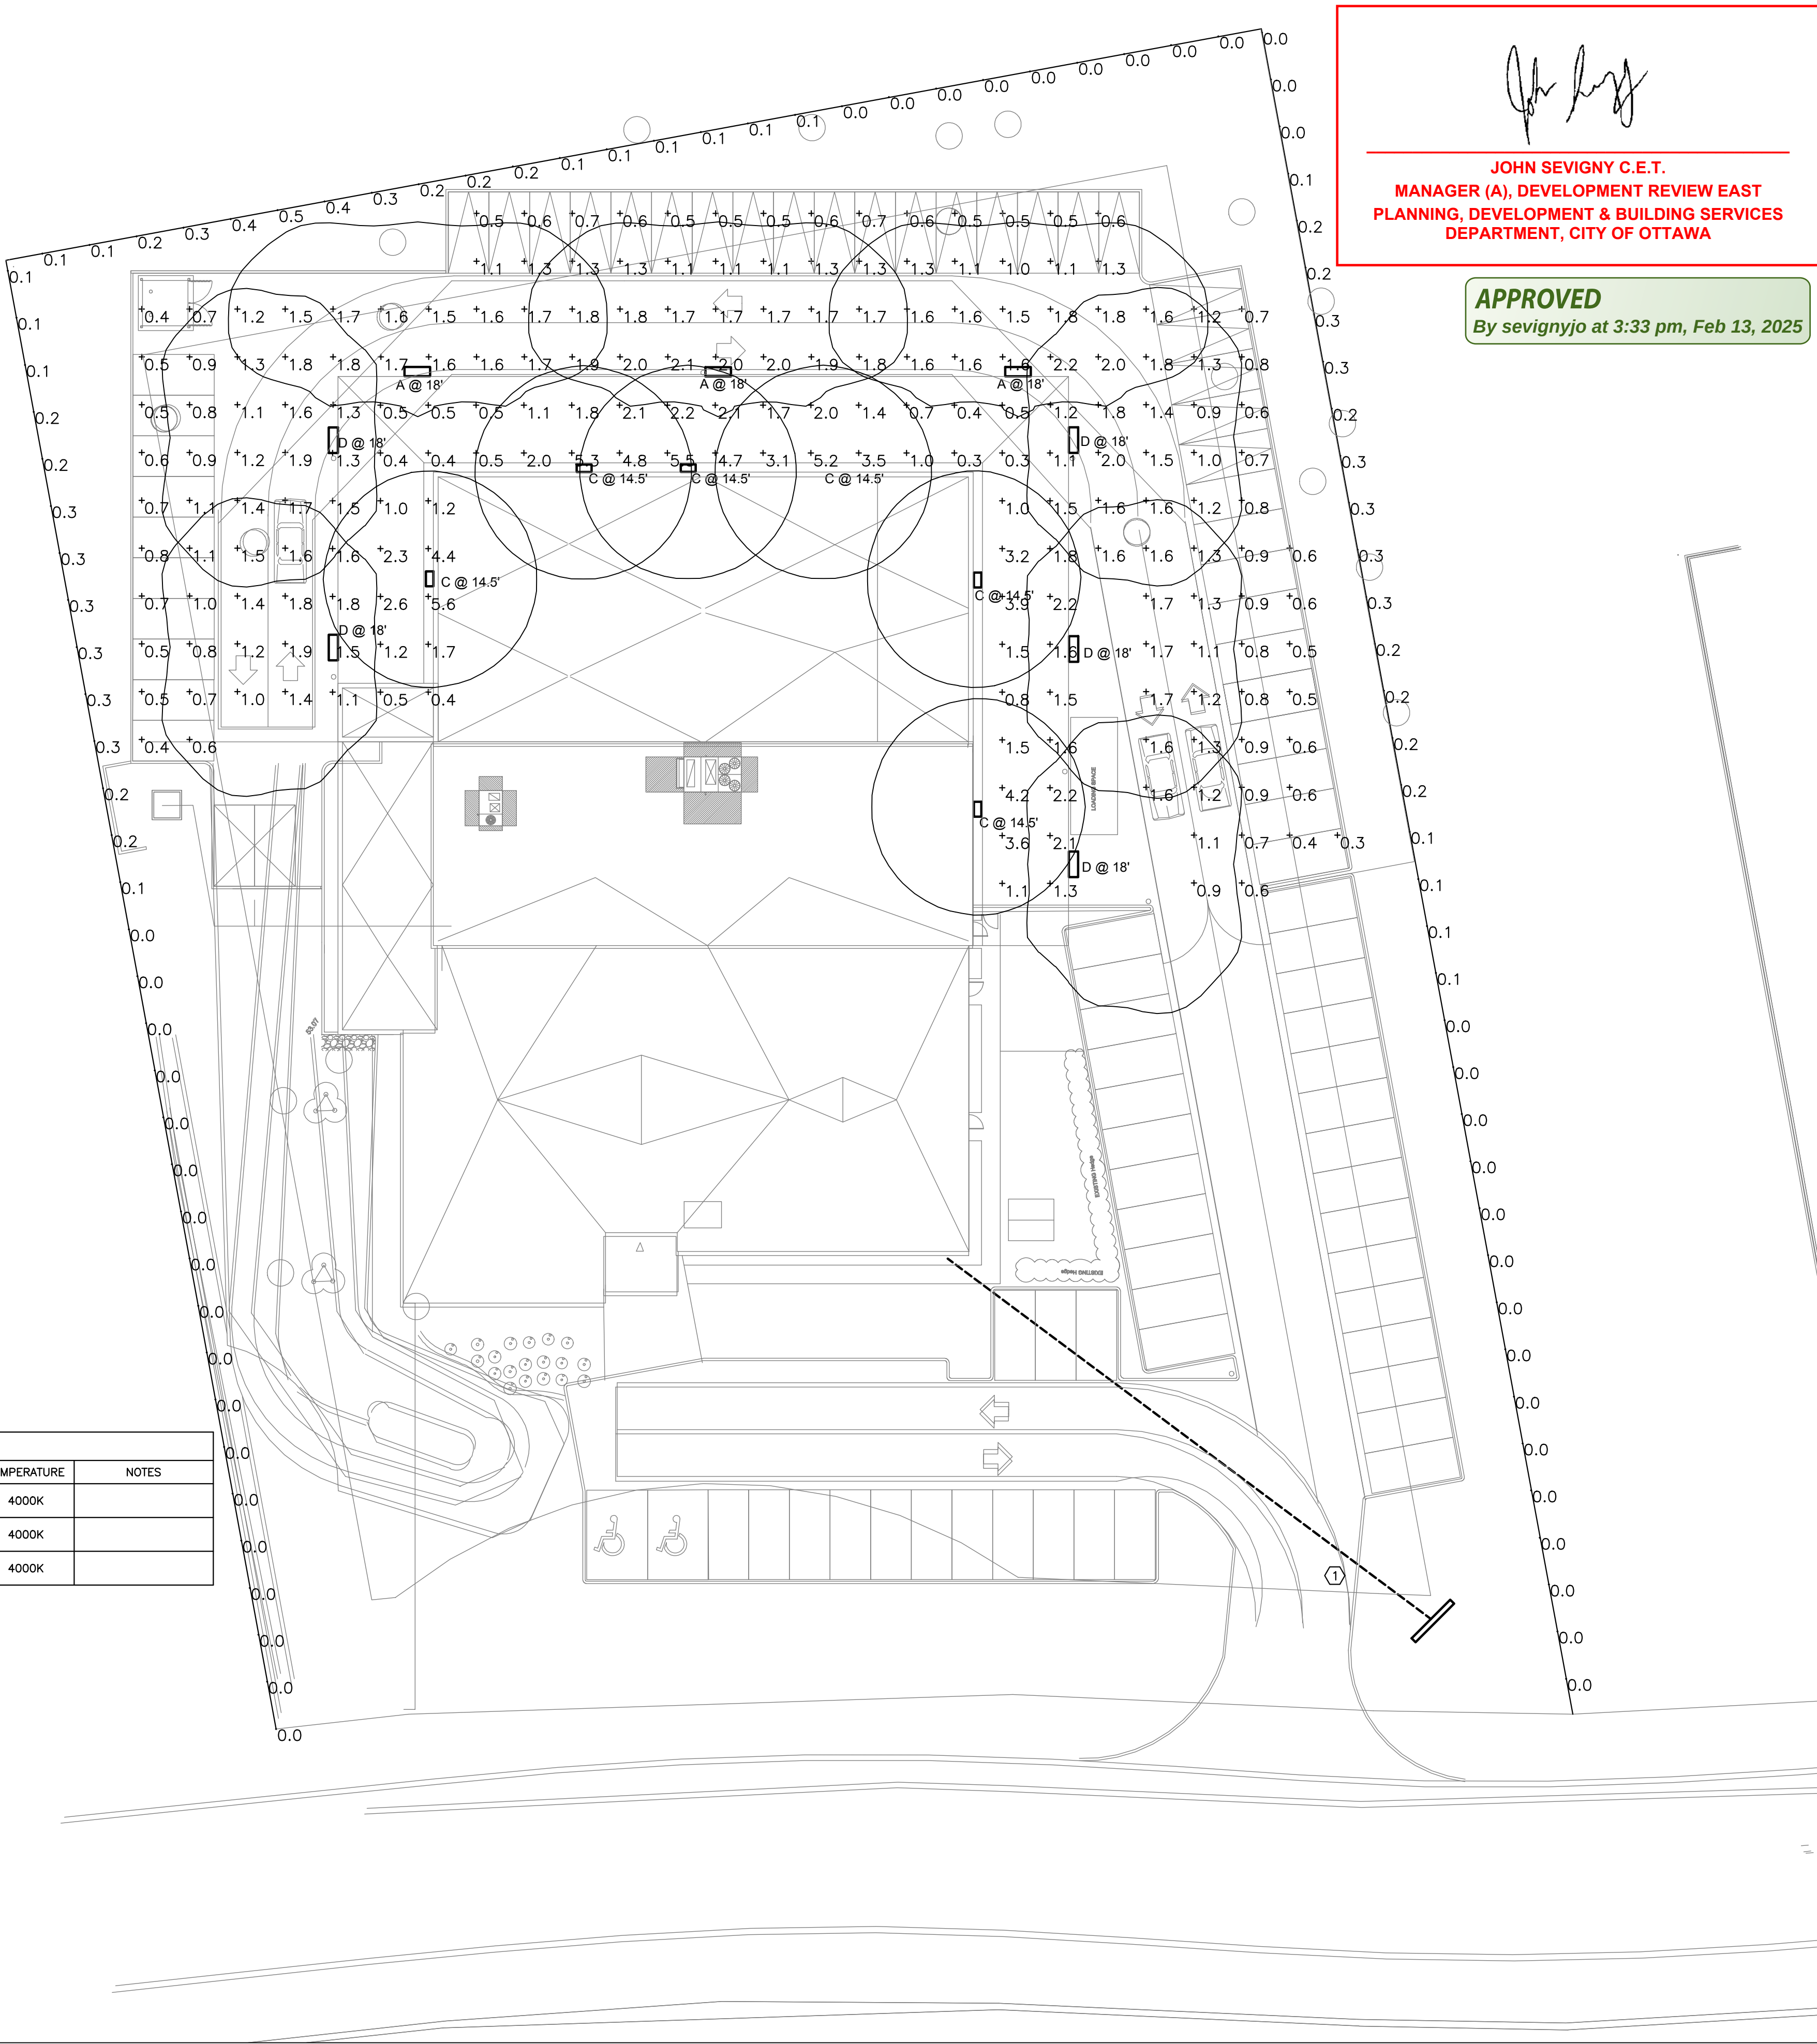

LIGHTING FIXTURE SCHEDULE						
TYPE	MAKE/MODEL	VOLTAGE	MOUNT	LAMPS	TEMPERATURE	NOTES
A	LITHONIA LIGHTING DSXW2 LED 20C 530 40K T3S MVOLT	120V	WALL	LED	4000K	
C	LITHONIA LIGHTING OLWX1 LED 40W 40K DDB	120V	WALL	LED	4000K	
D	LITHONIA LIGHTING DSXW2 LED 20C 530 40K TFTM MVOLT	120V	WALL	LED	4000K	

1 SITE LIGHTING PLAN
E-1 1:250

DRAWING NOTES:

- ① PROVIDE NEW 120V 15A DIRECT CONNECTION TO EXTERIOR SIGNAGE. SIGN TO BE FED FROM EXISTING ELECTRICAL ROOM WITH 21MMC. C/W ALL CONDUIT, WIRING, AND TIMER.
- ② EXTERIOR LIGHTING TO BE CONTROLLED BY PHOTOCELL. C/W ALL CONDUIT AND WIRING.

JOHN SEIGNY C.E.T.
MANAGER (A), DEVELOPMENT REVIEW EAST
PLANNING, DEVELOPMENT & BUILDING SERVICES
DEPARTMENT, CITY OF OTTAWA

APPROVED
By seignyjo at 3:33 pm, Feb 13, 2025

JRP ENGINEERING
Professional Engineers

110 Didsbury Rd - Unit M090, Kanata, ON, K2T 0N6
Tel: (613) 627-2462 Email: admin@jrpeng.com

An exact copy of all working documents including, without limitations, the original of the present document or plan is kept on file by J.R.P. Engineering. Any modification carried out to this document or plan or to accompanying documents without written authorization by the engineer is prohibited.

Authorized modifications must be signed and sealed by an engineer and this engineer will be completely responsible for these modifications. J.R.P. Engineering is not and will not be responsible for the consequences of these modifications or for modifications carried out without its consent.

No	DESCRIPTION	DATE
1	ISSUED FOR SITE PLAN R1-LAYOUT REVISIONS	SEPT 14TH 2021
0	ISSUED FOR SITE PLAN	DEC 10TH 2020

REVISIONS



client:

project:

LOCAL 47
SMART LOCAL
TRAINING CENTER
765 GREEN CREEK DRIVE
OTTAWA, ONTARIO

drawing title:

ELECTRICAL
SITE LIGHTING
PHOTOMETRIC

scale:	AS SHOWN	drawn by:	C.M.
designed by:	C.M.	reviewed by:	M.G.
approved by:	M.G.	date:	DEC 2020

project no.:	190-2001	drawing no.:	E-1
revision:	0		OF 1