

REFER TO NOTES, DETAILS & SCHEDULES ON DRAWINGS C-4 & C-5


*Lucy Ramirez*  
**LUCY RAMIREZ**  
 PLANNER  
 PLANNING, INFRASTRUCTURE & ECONOMIC  
 DEVELOPMENT DEPARTMENT, CITY OF OTTAWA

**APPROVED**  
 By Lucy Ramirez at 1:49 pm, Feb 22, 2024

**LEGEND**

- CB [ ] CATCH-BASIN
- MH [ ] STORM MANHOLE
- CB/MH [ ] CATCH-BASIN/MANHOLE
- MH [ ] SANITARY MANHOLE
- VC [ ] VALVE CHAMBER
- VB [ ] VALVE & VALVE BOX
- FD [ ] FIRE HYDRANT
- FD [ ] FIRE DEPARTMENT CONNECTION
- SAN [ ] SANITARY SEWER
- ST [ ] STORM SEWER
- WS/M [ ] WATER SERVICE WATERMAIN
- SPL [ ] SPRINGLINE OF PIPE
- INV [ ] INVERT OF PIPE
- (M) [ ] WATER METER
- (R) [ ] REMOVE WATER METER
- FTL [ ] FINISHED FLOOR ELEVATION
- USF [ ] UNDERSIDE OF FOOTING
- - - [ ] PROPERTY LINE
- - - - - [ ] EXISTING GRADE ELEVATION
- - - - - [ ] CRITICAL ROOT ZONE

**KEY PLAN**

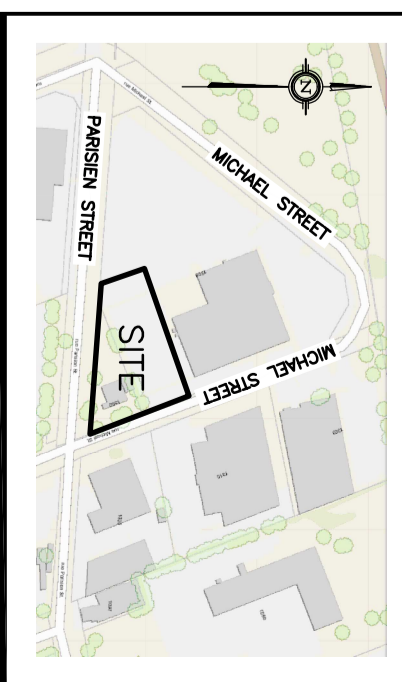

No.	DATE	REVISION
1	JAN 25-23	ISSUED FOR APPROVAL

**D.B. GRAY ENGINEERING, INC.**  
 Professional Engineers & Geotechnical Engineers  
 7901 Long Point Circle  
 Ottawa, Ontario  
 dgray@dbgrayengineering.com  
 613-425-5044

Project  
**PROPOSED 2 STOREY  
 VOLVO DEALERSHIP**  
 1328 MICHAEL STREET  
 OTTAWA, ONTARIO

Drawing Title  
**PRE-DEVELOPMENT  
 DRAINAGE PLAN**

Engineer's Seal  
**LICENSÉD PROFESSIONNEL**  
**D.B. GRAY**  
 17016502  
 (KIN 25-23)

Drawing No.  
**C-8**  
 of **8**  
**#18651**

Drawn: D.B.G.  
 H. Scale: 1:200  
 V. Scale: DEG 7-22  
 Date: 08G 7-22  
 Job No.: 21014

NOT VALID UNLESS  
 SIGNED & DATED