


LEGEND

CB	CATCH-BASIN
MH	STORM MANHOLE
CB/MH	CATCH-BASIN/MANHOLE
MH	SANITARY MANHOLE
VC	VALVE CHAMBER
VB	VALVE & VALVE BOX
FH	FIRE HYDRANT
FDC	FIRE DEPARTMENT CONNECTION
SAN	SANITARY SEWER
ST	STORM SEWER
WS/WM	WATER SERVICE/WATERMAIN
SPL	SPRINGLINE OF PIPE
INV	INVERT OF PIPE
(M)	WATER METER
(R)	REMOTE WATER METER
FFL	FINISHED FLOOR ELEVATION
USF	UNDERSIDE OF FOOTING
---	PROPERTY LINE
- - - -	EXISTING GRADE ELEVATION
- - - -	CRITICAL ROOT ZONE

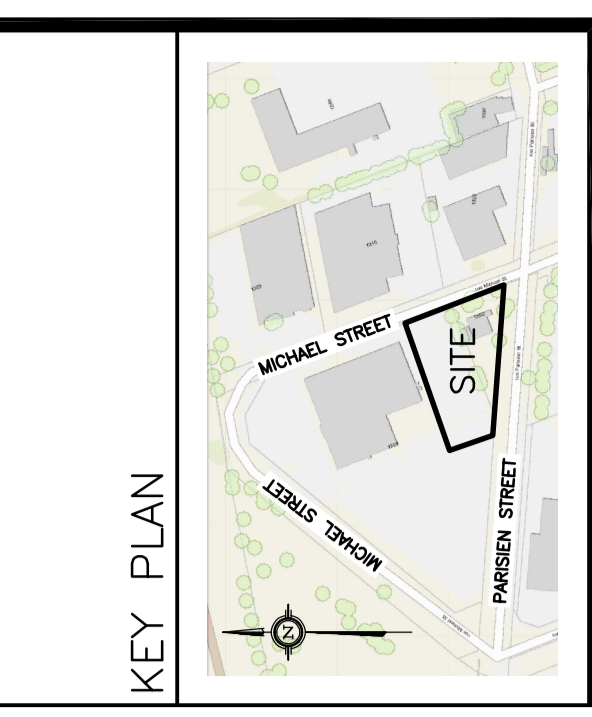

No.	DATE	REVISION
1	JAN 11-22	ISSUED FOR COORDINATION
2	JAN 12-22	ISSUED FOR APPROVAL
3	JUL 28-22	RE-ISSUED FOR APPROVAL
4	JAN 25-23	RE-ISSUED FOR APPROVAL

D. B. GRAY ENGINEERING INC.
 Professional Engineers
 700 Long Point Circle
 Ottawa, Ontario
 613-425-8044
 d.gray@dbgrayengineering.com

**PROPOSED 2 STOREY
 VOLVO DEALERSHIP
 1328 MICHAEL STREET
 OTTAWA, ONTARIO**


**EXISTING DRAINAGE PLAN AND
 EXISTING CONDITIONS,
 REMOVALS & DECOMMISSIONING**

Engineer's Seal
 D.B. GRAY
 PROFESSIONAL ENGINEER
 17016502
 JAN 25-23
 BOARD OF ENGINEERS
 OF ONTARIO

Drawn: D.B.G.
 H. Scale: 1:200
 V. Scale: NOV 2-21
 Date: NOV 2-21
 Job No.: 21014

Drawing No.: **C-2**
 of **8**

NOT VALID UNLESS
 SIGNED & DATED

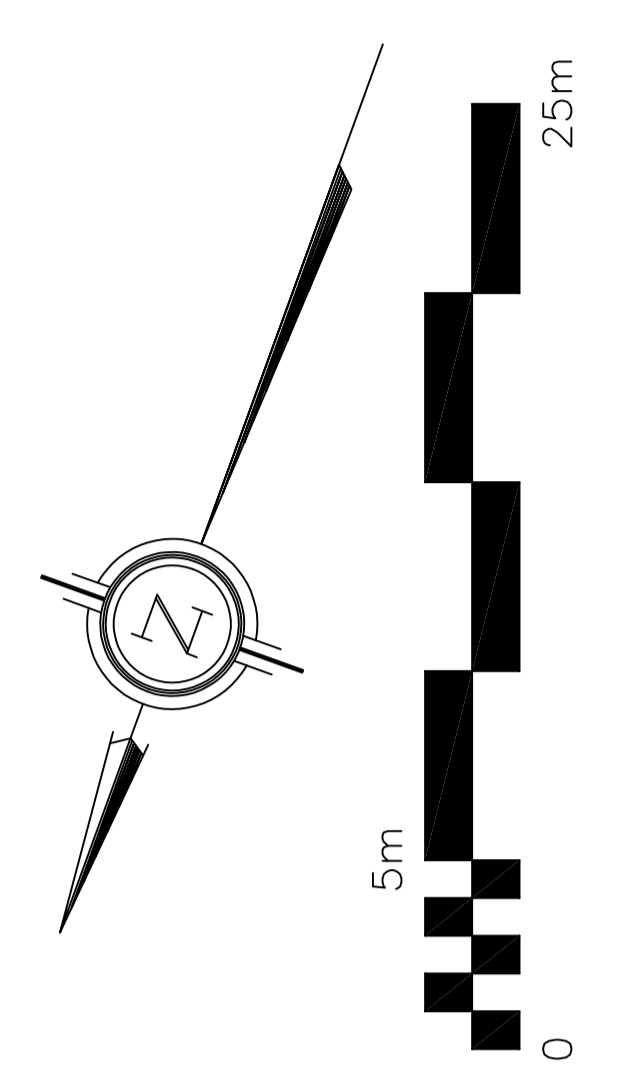

**REFER TO NOTES, DETAILS &
 SCHEDULES ON DRAWINGS C-4 & C-5**