


LEGEND

DRAINAGE AREA

AREA (sq.m)

I 1234
0.56

5 YEAR RUNOFF COEFFICIENT

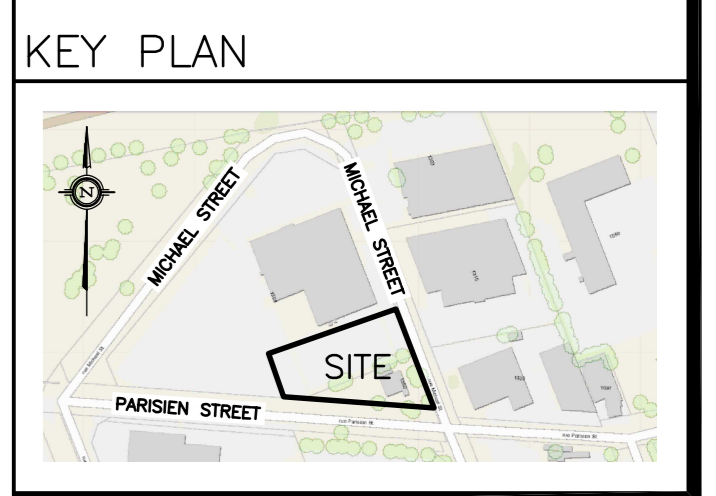


No.	DATE	REVISION
2	JAN 12-22	ISSUED FOR APPROVAL
1	JAN 11-22	ISSUED FOR COORDINATION

D. B. GRAY ENGINEERING INC.
 Stormwater Management - Grading & Drainage - Storm & Sanitary Sewers - Watermain
 700 Long Point Circle 613-425-8044
 Ottawa, Ontario d.gray@dbgrayengineering.com

Project
PROPOSED 2 STOREY VOLVO DEALERSHIP
1328 MICHAEL STREET
 OTTAWA, ONTARIO

Drawing Title
DRAINAGE PLAN

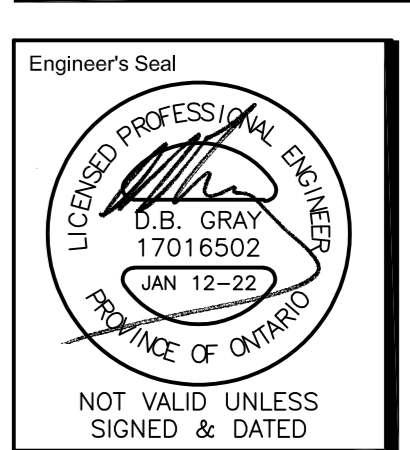

Drawn D.B.G.
 H. Scale 1:200
 V. Scale
 Date NOV 2-21
 Job No. 21014

Drawing No.
C-6
 of 6

