



REFER TO NOTES, DETAILS &
SCHEDULES ON DRAWINGS C-5 & C-6

LEGEND

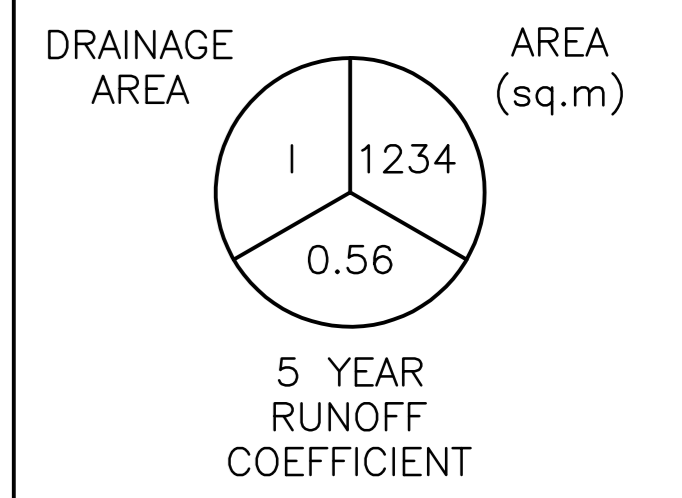

KEY PLAN

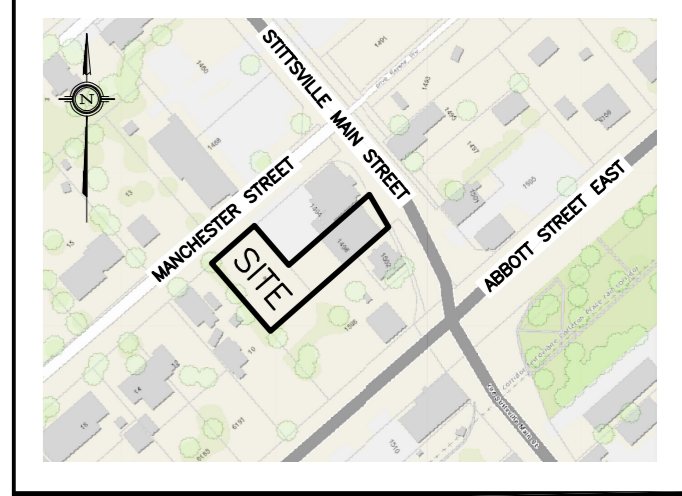


| No. | DATE | REVISION |
|-----|-----------|-------------------------|
| 3 | JUL 15-22 | RE-ISSUED FOR APPROVAL |
| 2 | MAY 7-21 | ISSUED FOR APPROVAL |
| 1 | MAY 4-21 | ISSUED FOR COORDINATION |

D. B. GRAY ENGINEERING INC.
Stormwater Management - Grading & Drainage - Sewer & Sanitary Sewers - Watermain
 700 Long Point Circle 613-425-8044
 Ottawa, Ontario d.gray@dbgrayengineering.com

Project
**PROPOSED
 2 STOREY DISTILLERY
 1498 STITTSVILLE MAIN STREET
 OTTAWA, ONTARIO**

Drawing Title
DRAINAGE PLAN

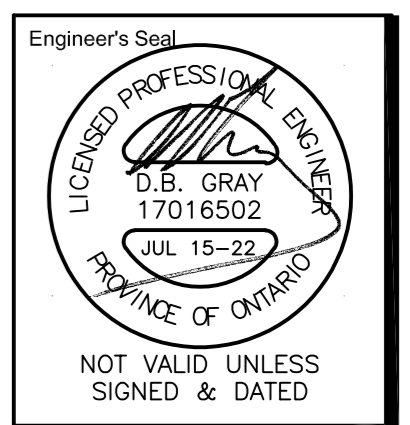

Drawn D.B.G.
 H. Scale 1:100
 V. Scale
 Date APR 21-21
 Job No. 21029

Drawing No.
**C-7
 of 7**

#18651

D07-12-22-0035