


REFER TO NOTES, DETAILS &  
SCHEDULES ON DRAWINGS C-5 & C-6

LEGEND

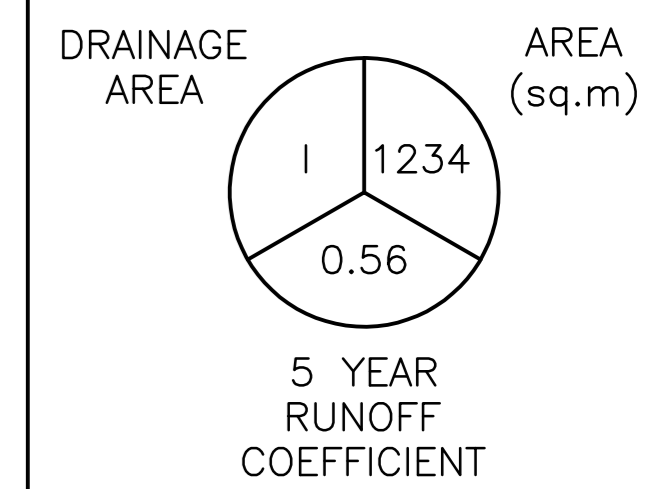

KEY PLAN




No.	DATE	REVISION
2	MAY 7-21	ISSUED FOR APPROVAL
1	MAY 4-21	ISSUED FOR COORDINATION

**D. B. GRAY ENGINEERING INC.**  
Stormwater Management - Grading & Drainage - Storm & Sanitary Sewers - Watermain  
 700 Long Point Circle 613-425-8044  
 Ottawa, Ontario d.gray@dbgrayengineering.com

Project  
**PROPOSED  
 2 STOREY DISTILLERY  
 1498 STITTSVILLE MAIN STREET  
 OTTAWA, ONTARIO**

Drawing Title  
**DRAINAGE PLAN**

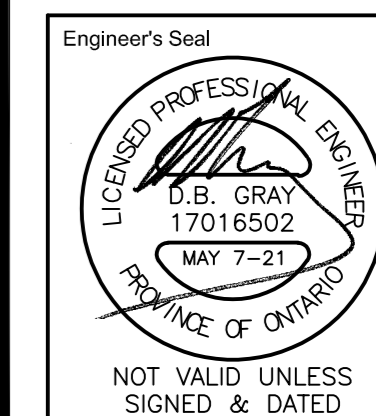

Drawn D.B.G.  
 H. Scale 1:100  
 V. Scale  
 Date APR 21-21  
 Job No. 21029

Drawing No.  
**C-7  
 of 7**

NOT VALID UNLESS  
SIGNED & DATED