


EXTERIOR FIXTURE SCHEDULE			
TYPE	DESCRIPTION	LAMPS	MTG HT Ⓞ
A	12"W x 7"D x 9"H LED, 120V, 60W, WALL PACK WEDGED FIXTURE, SINGLE CAST ALUMINUM HOUSING, FULLY GASKETED FOR MOISTURE AND DUST, FINISH ARCH SELECT POWDER COATED MODEL: WDGE2-LED-P2-30K-80CRI-VF-MVOLT-SRM OR APPROVED EQUIVALENT	2000 LUMEN 3000K	WALL PACK

LEGEND		
SYMBOL	DESCRIPTION	MTG HT Ⓞ
• □	POLE MOUNTED LIGHT FIXTURE	AS NOTED
□	WALL MOUNTED LIGHT FIXTURE	AS NOTED
□	WALL MOUNTED LIGHT FIXTURE (WALLPACK TYPE)	AS NOTED
☉	DIRECTIONAL/AIMED FIXTURE	GROUND
☐	FLOOD LIGHT	GROUND
☐	PHOTO SENSOR	AS NOTED
☐	TIME CLOCK	AS NOTED

ELECTRICAL DRAWING LIST	
E000	ELECTRICAL DRAWING LIST, LEGEND, NOTES AND SCHEDULES
E001	ELECTRICAL SITE LIGHTING PLAN

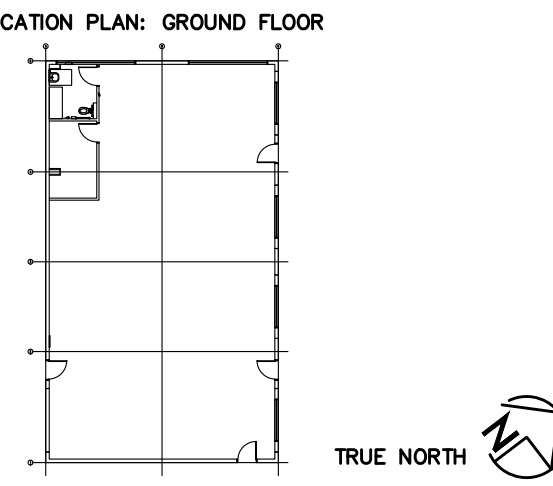

CONTRACTOR SHALL CHECK AND VERIFY ALL DIMENSIONS AND REPORT ANY OMISSIONS OR DISCREPANCIES TO THE ARCHITECT BEFORE PROCEEDING WITH THE WORK.
DO NOT SCALE DRAWINGS.

REVISIONS		
NO.	DESCRIPTION	DATE
1	Issued for Class D estimate	Feb 22, 2021
2	Issued for Permit	Feb 28, 2022

PROJECT NORTH	DATE
	•
	DRAWN
	AK
	CHECKED
	DATE PRINTED
	-

NOT TO BE USED FOR CONSTRUCTION PURPOSES UNTIL SIGNED BY THE ARCHITECT.

DYMECH WAREHOUSE ADDITION


ADDRESS: 1383 OGDEN STREET, GORELY, ON, N4P 1A1

DRAWING TITLE

ELECTRICAL DRAWING LIST, LEGEND, NOTES AND SCHEDULES

SCALE	DRAWING NO. :
NTS	E-000
PROJECT NO.	
059-20	



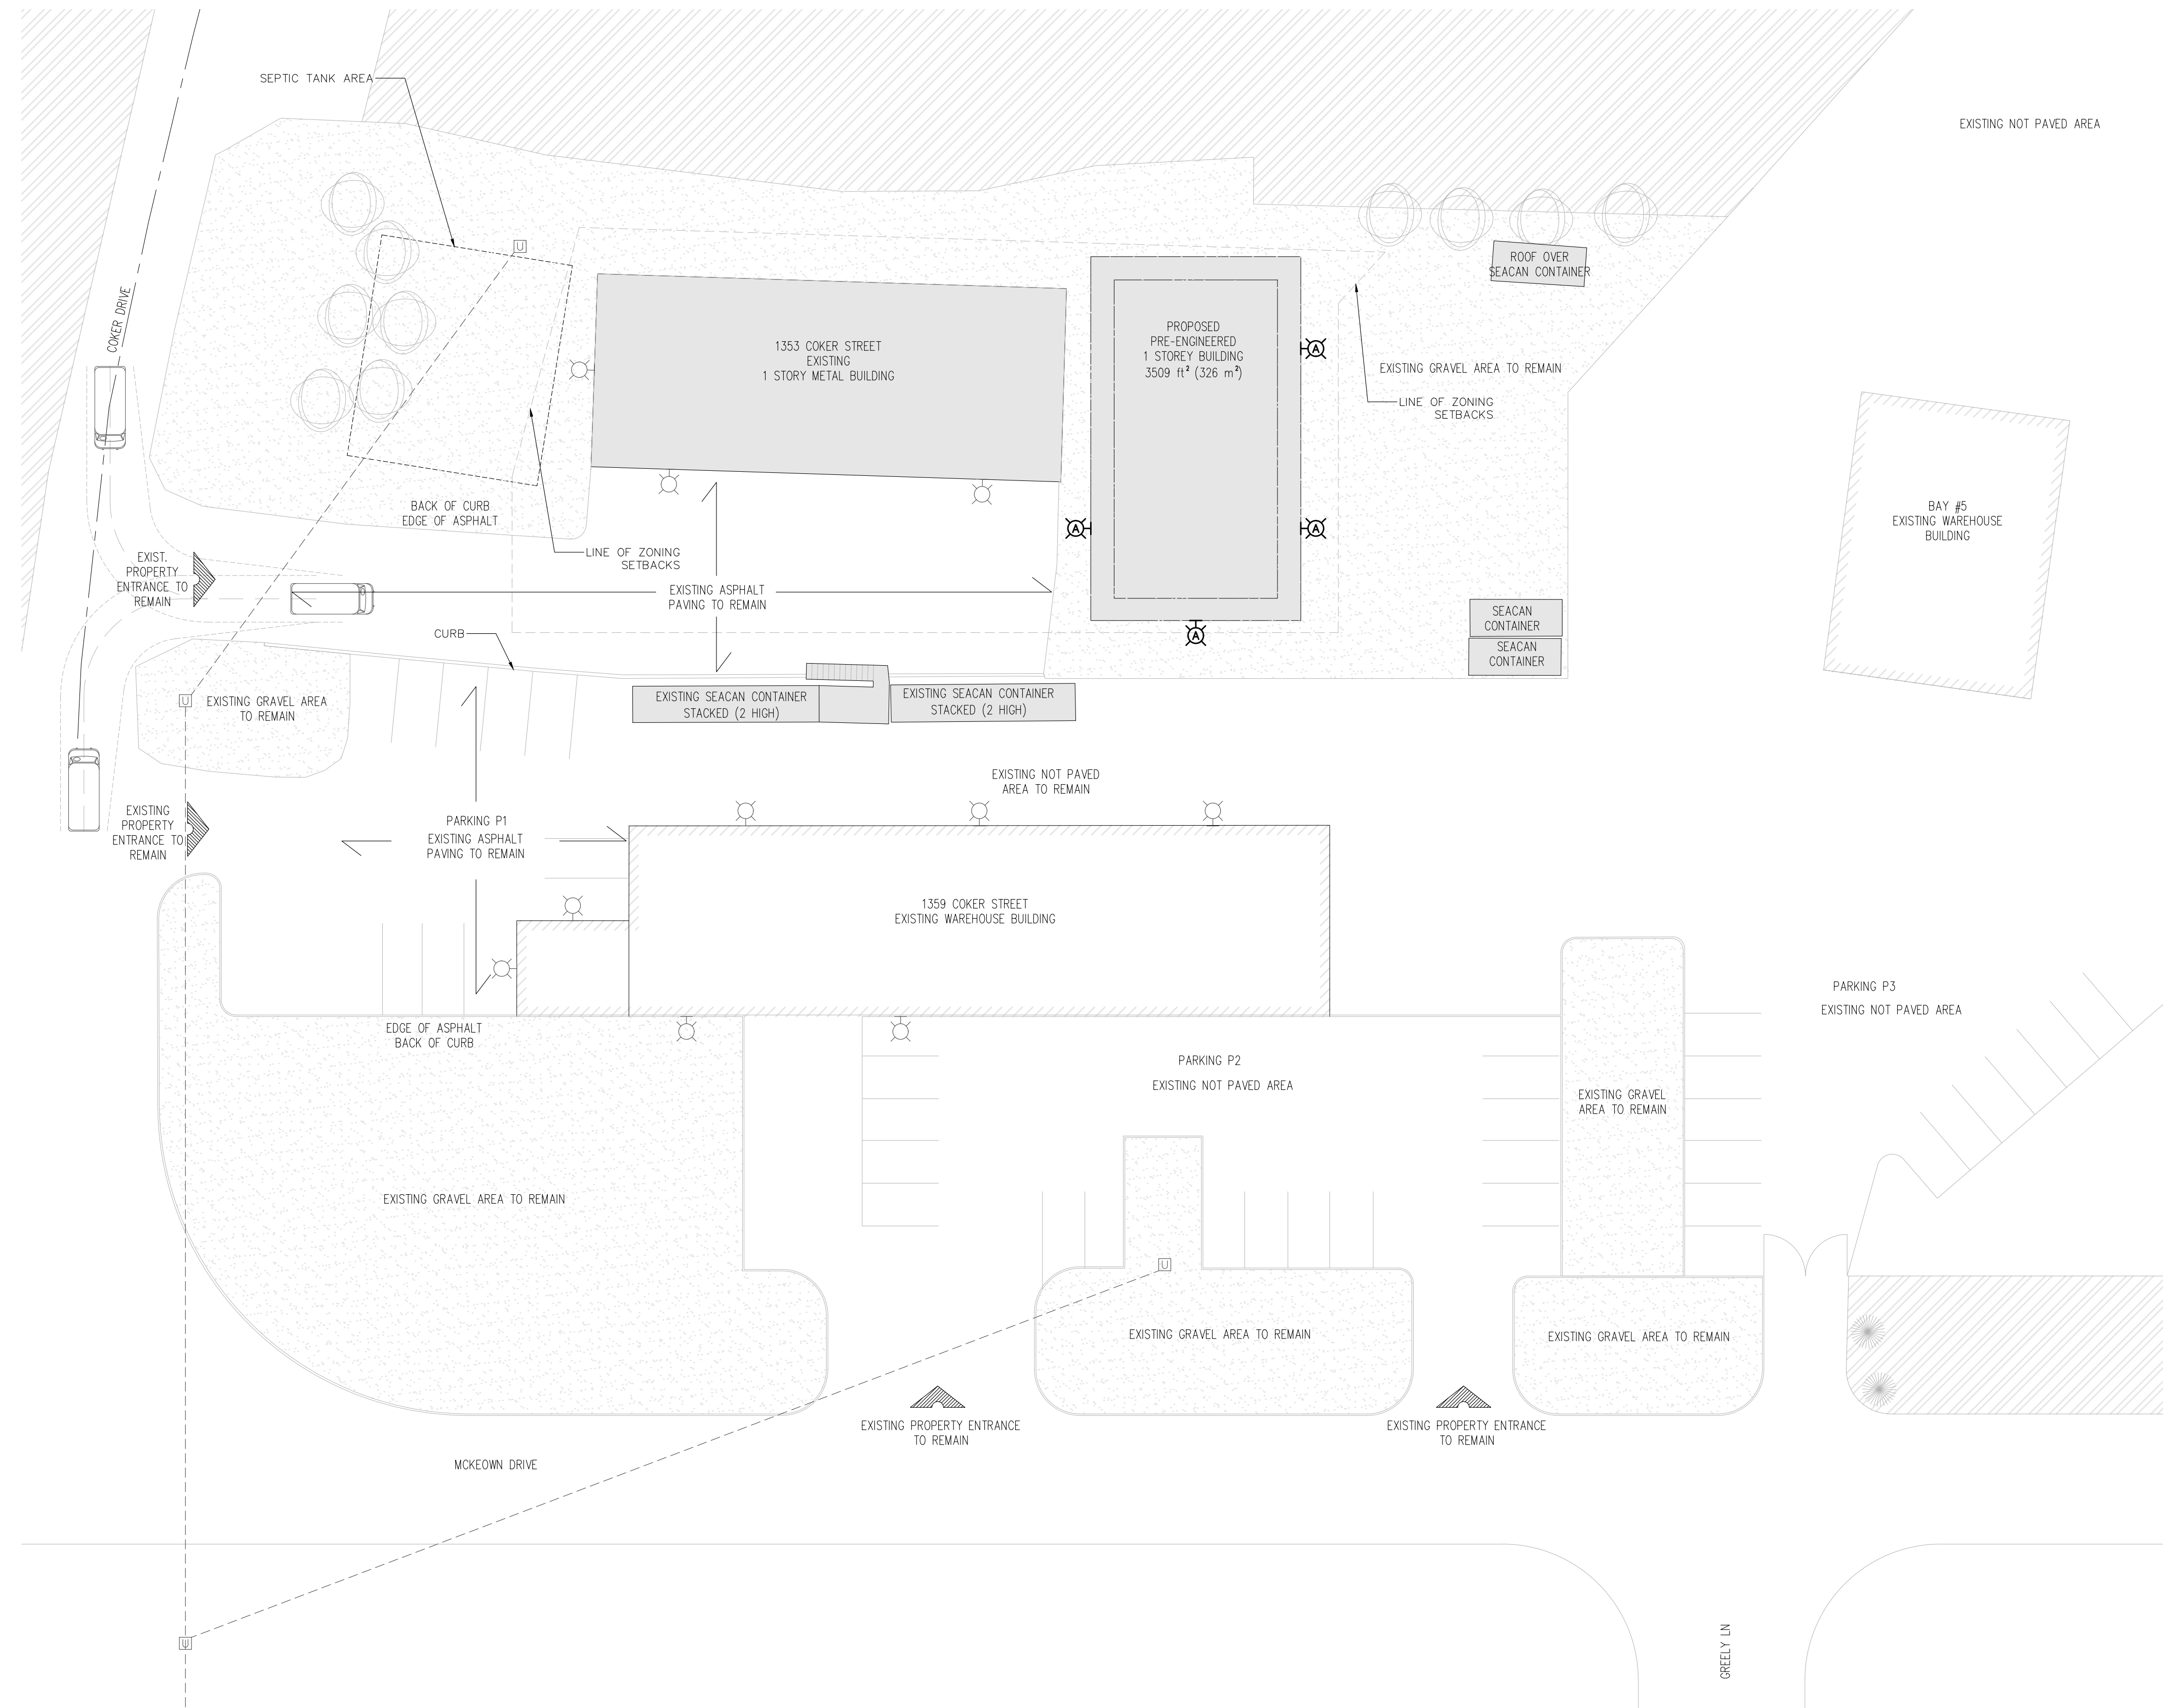

NEW SITE LIGHTING NOTES
 1. PROVIDE NEW SITE LIGHTING AS SHOWN IN BOLD. CONNECT TO EXISTING PANEL. REFER TO ARCHITECTURAL DRAWINGS FOR EXACT LOCATIONS AND MOUNTING HEIGHTS.


DYMECH
 ENGINEERING INC.

arbaum
 ARCHITECTS
 535 LEGGETT DRIVE, SUITE 102
 KANATA, ONTARIO K2K 3B8

CLELAND JARDINE
 ENGINEERING LTD

D.B. Gray Engineering Inc.

VR
 ENGINEERING FORWARD
 Vanderweest & Rutherford Associates Inc.
 Mechanical & Electrical Engineers
 London - Windsor - Ottawa
 www.vreng.ca | 613-563-2100
 21-013

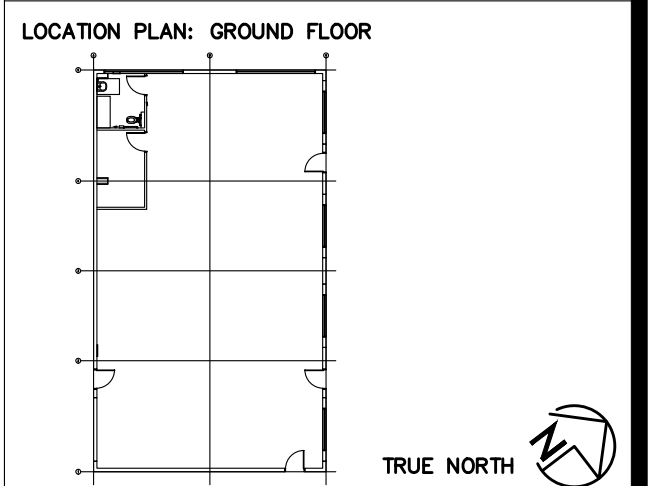

CONTRACTOR SHALL CHECK AND VERIFY ALL DIMENSIONS AND REPORT ANY OMISSIONS OR DISCREPANCIES TO THE ARCHITECT BEFORE PROCEEDING WITH THE WORK.
 DO NOT SCALE DRAWINGS.

REVISIONS		
NO.	DESCRIPTION	DATE
1	Issued for Class D estimate	Feb 22, 2021
2	Issued for Permit	Feb 28, 2022

PROJECT NORTH	DATE
	•
	DRAWN
	AK
	CHECKED
	DATE PRINTED
	-

NOT TO BE USED FOR CONSTRUCTION PURPOSES UNTIL SIGNED BY THE ARCHITECT.

DYMECH WAREHOUSE ADDITION

ADDRESS: 1303 COKER STREET, GREELEY, ON, N4P 1A1

DRAWING TITLE

ELECTRICAL SITE LIGHTING PLAN

SCALE: AS SHOWN
 PROJECT NO: 059-20
 DRAWING NO.: E-001

1 ELECTRICAL SITE PLAN
 E004 1:250

