

| No. | DATE | REVISION |
|-----|-----------|-------------------------|
| 3 | FEB 7-23 | RE-ISSUED FOR APPROVAL |
| 2 | MAR 7-22 | ISSUED FOR APPROVAL |
| 1 | FEB 15-22 | ISSUED FOR COORDINATION |

D. B. GRAY ENGINEERING INC.
Stormwater Management - Grading & Drainage - Storm & Sanitary Sewers - Watermain
700 Long Point Circle
Ottawa, Ontario
613-425-8044
d.gray@dbgrayengineering.com

Project
PROPOSED 1-STOUREY WAREHOUSE
1353 COKER STREET
OTTAWA, ONTARIO

Drawing Title
DETAILS



Engineer's Seal
LICENSED PROFESSIONAL ENGINEER
D.B. GRAY
17016502
FEB 7-23
PROVINCE OF ONTARIO

NOT VALID UNLESS SIGNED & DATED

Drawn D.B.G.
H. Scale
V. Scale
Date FEB 15-22
Job No. 20127

Drawing No.
C-3
of 5

D07-12-22-0038

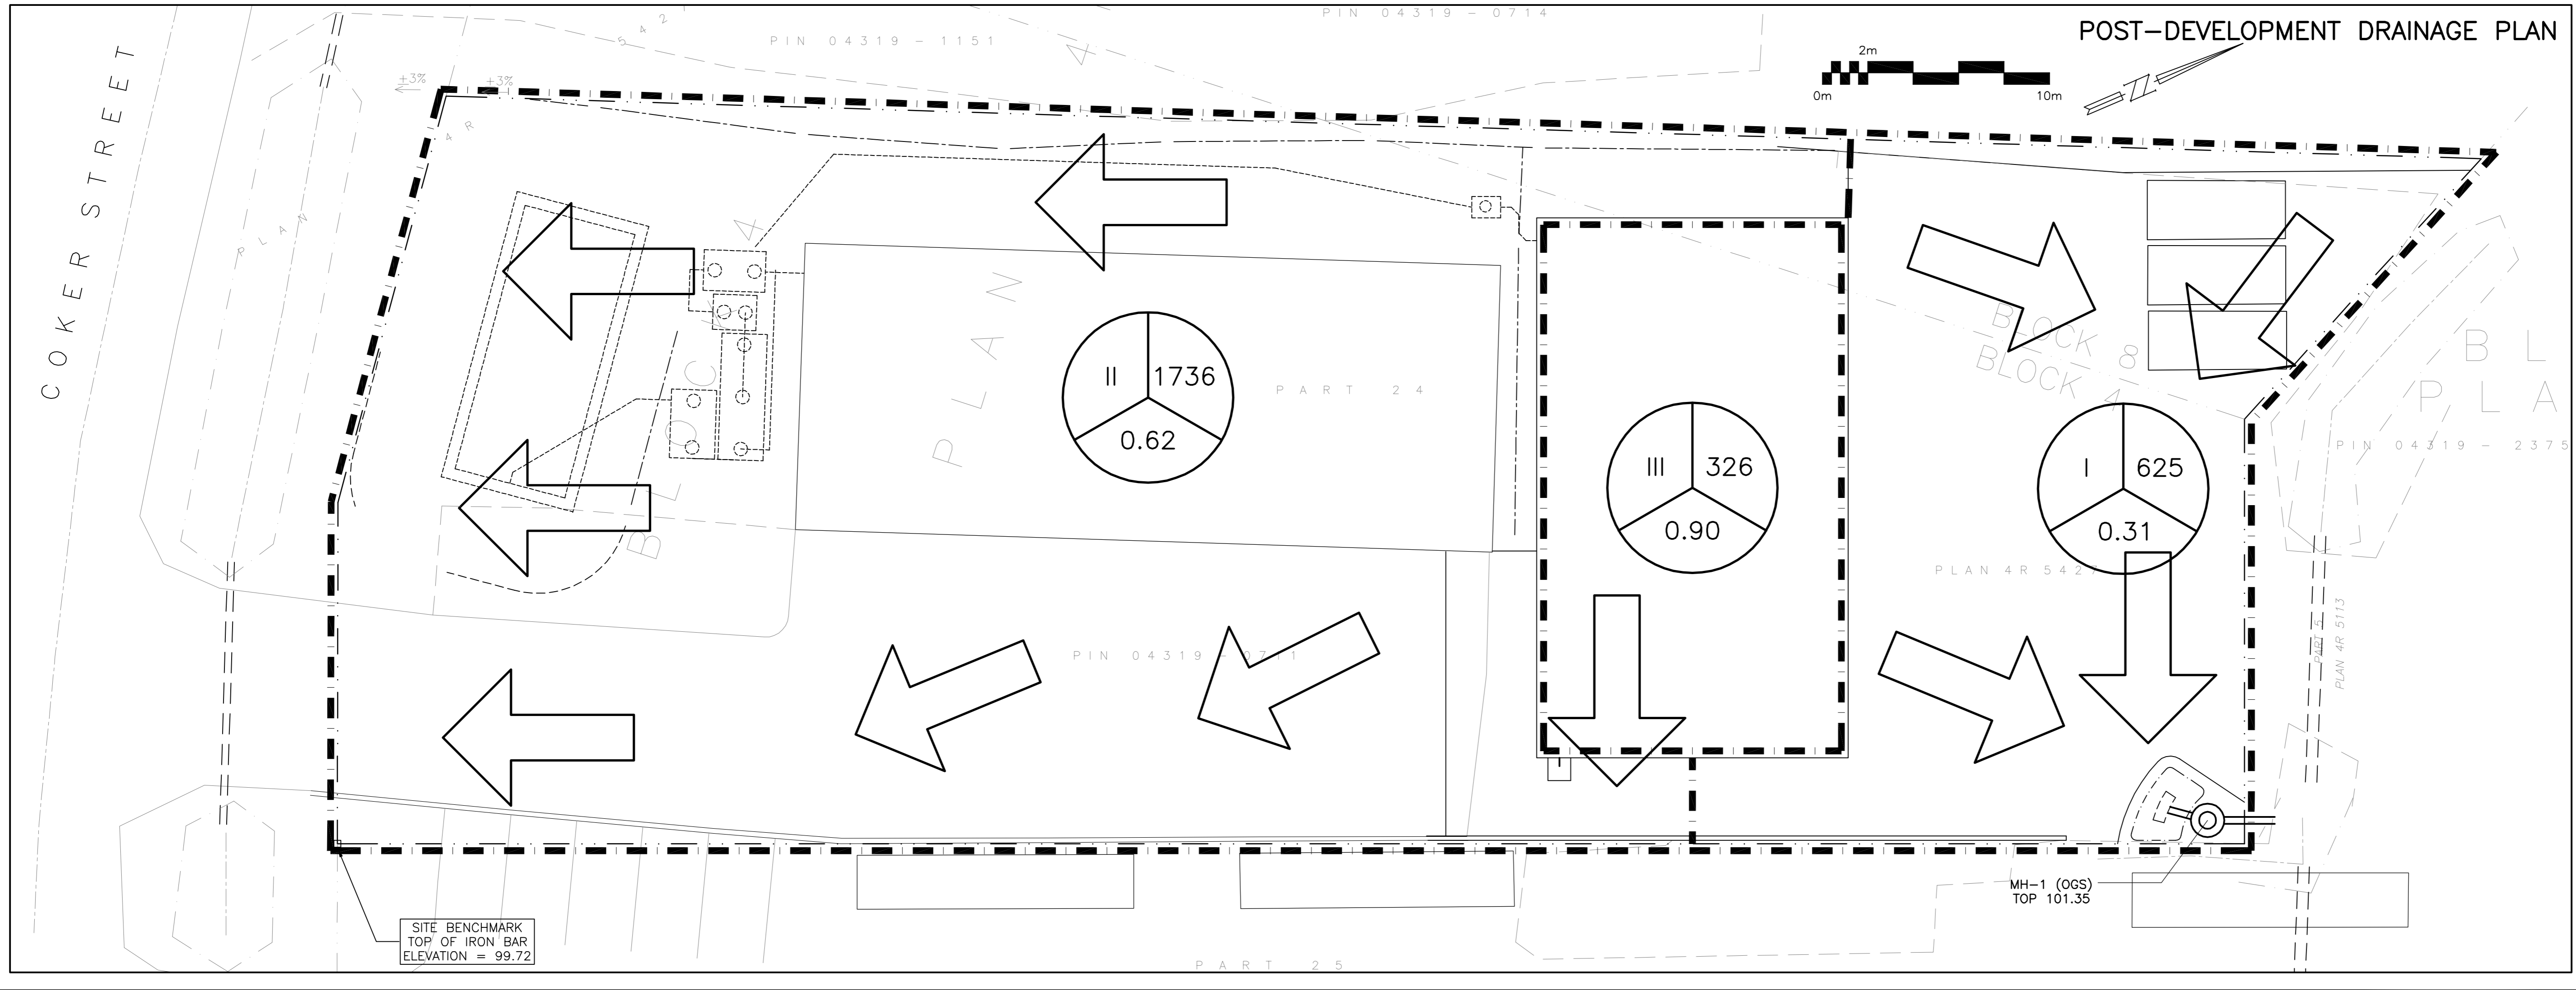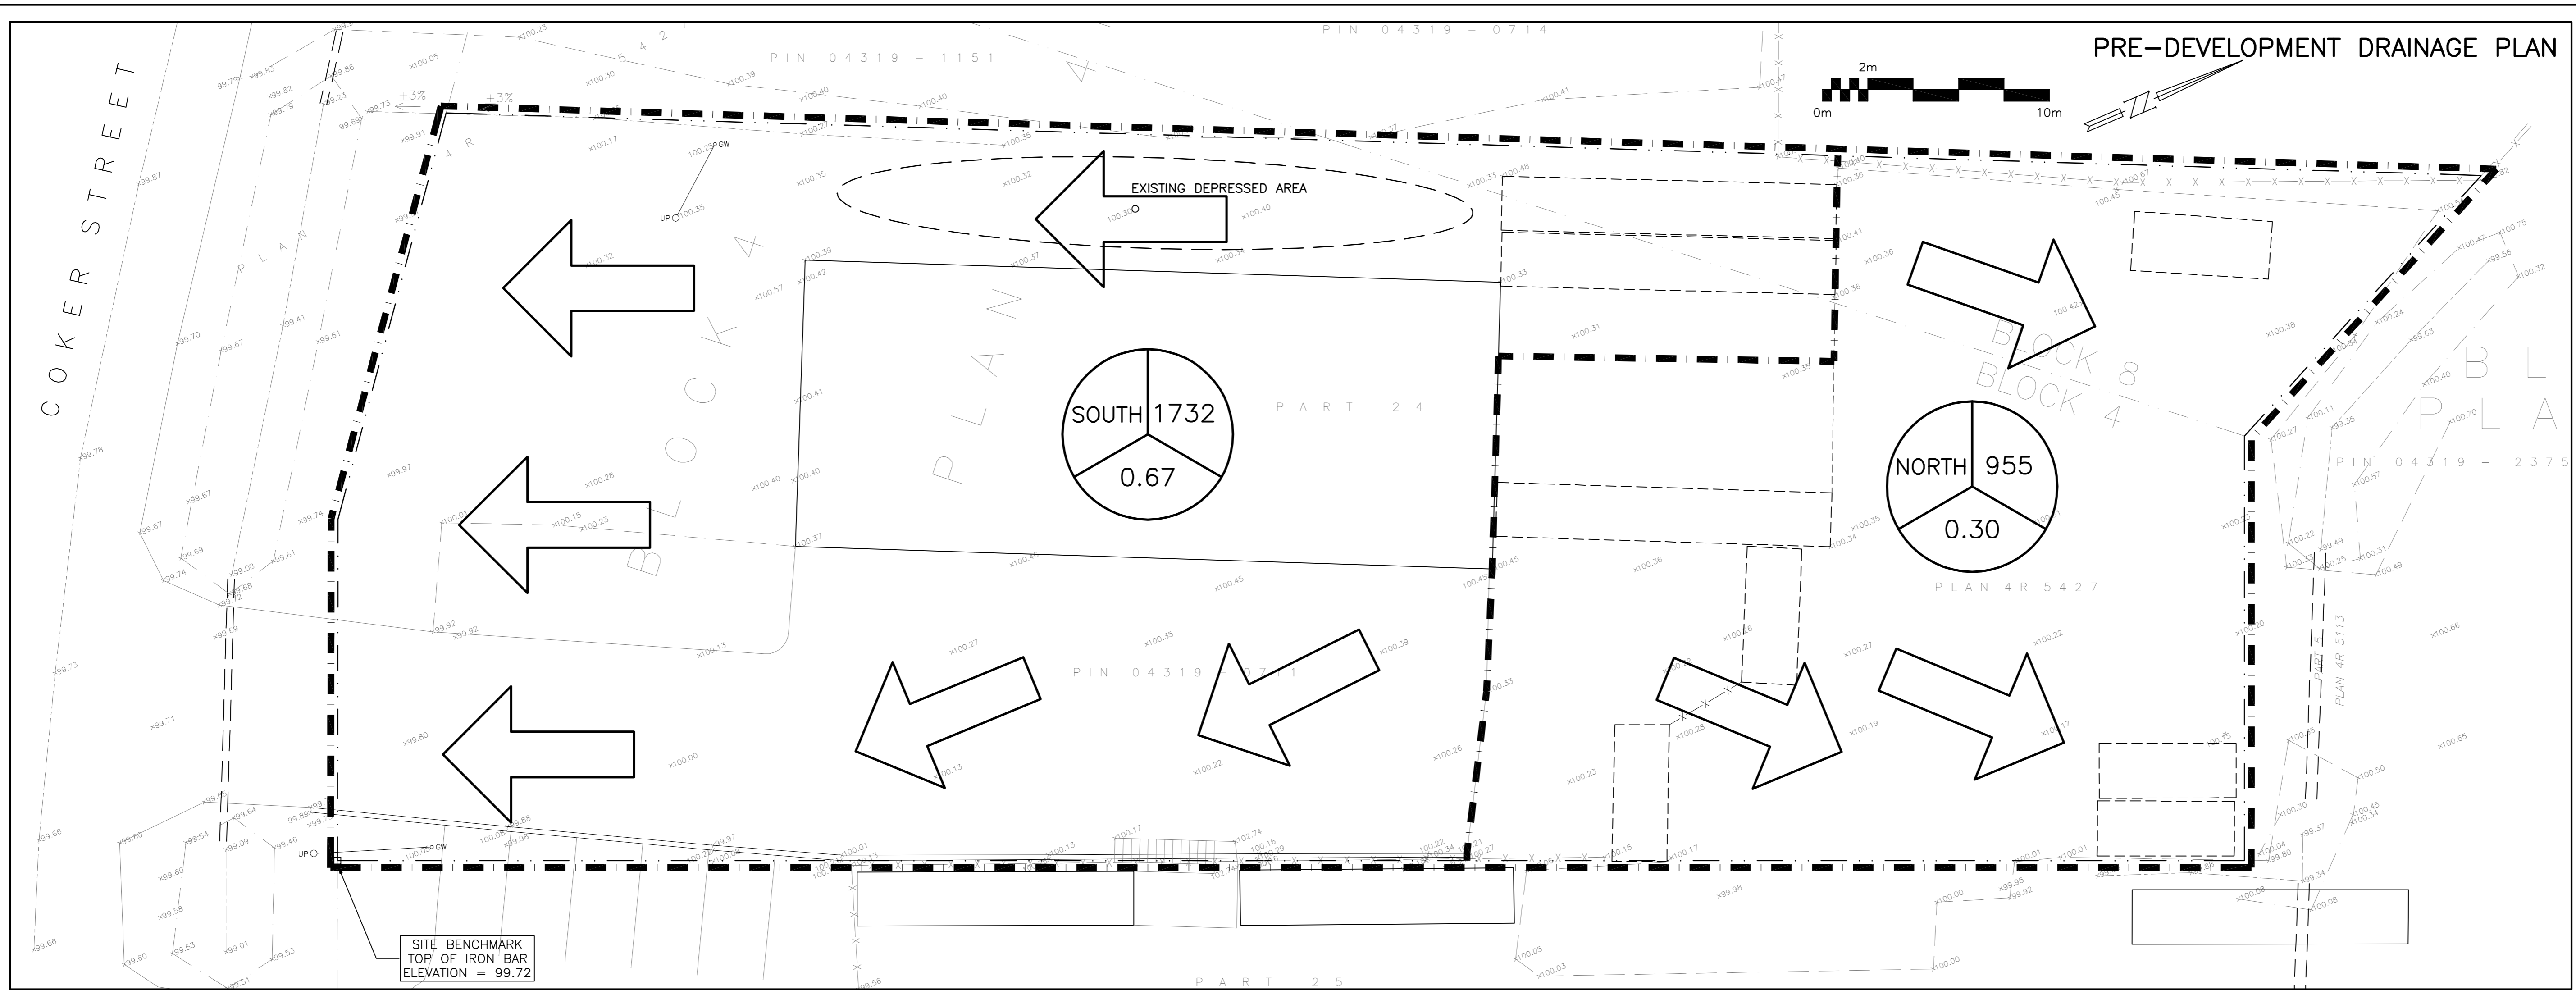

LEGEND


DRAINAGE AREA

AREA (sq.m)

X XXX
0.XX

5 YEAR RUNOFF COEFFICIENT

← DRAINAGE PATTERN

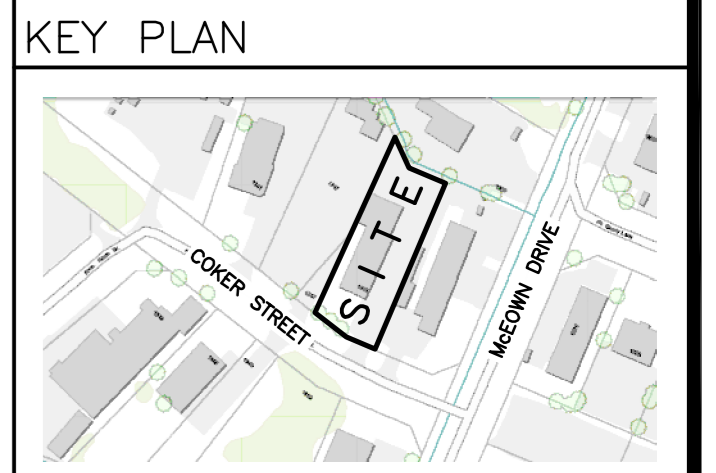


| No. | DATE | REVISION |
|-----|-----------|-------------------------|
| 3 | FEB 7-23 | RE-ISSUED FOR APPROVAL |
| 2 | MAR 7-22 | ISSUED FOR APPROVAL |
| 1 | FEB 15-22 | ISSUED FOR COORDINATION |

D. B. GRAY ENGINEERING INC.
 Stormwater Management - Grading & Drainage - Storm & Sanitary Sewers - Watermain
 700 Long Point Circle 613-425-8044
 Ottawa, Ontario d.gray@dbgrayengineering.com

Project
**PROPOSED
 1-STORY WAREHOUSE
 1353 COKER STREET
 OTTAWA, ONTARIO**

Drawing Title
**PRE- AND POST-
 DEVELOPMENT
 DRAINAGE PLANS**

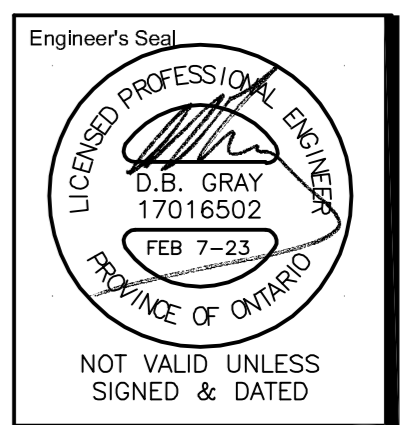

Drawn D.B.G.
 H. Scale 1:150
 V. Scale 1:150
 Date FEB 15-22
 Job No. 20127

Drawing No.
**C-5
 of 5**

D07-12-22-0038