

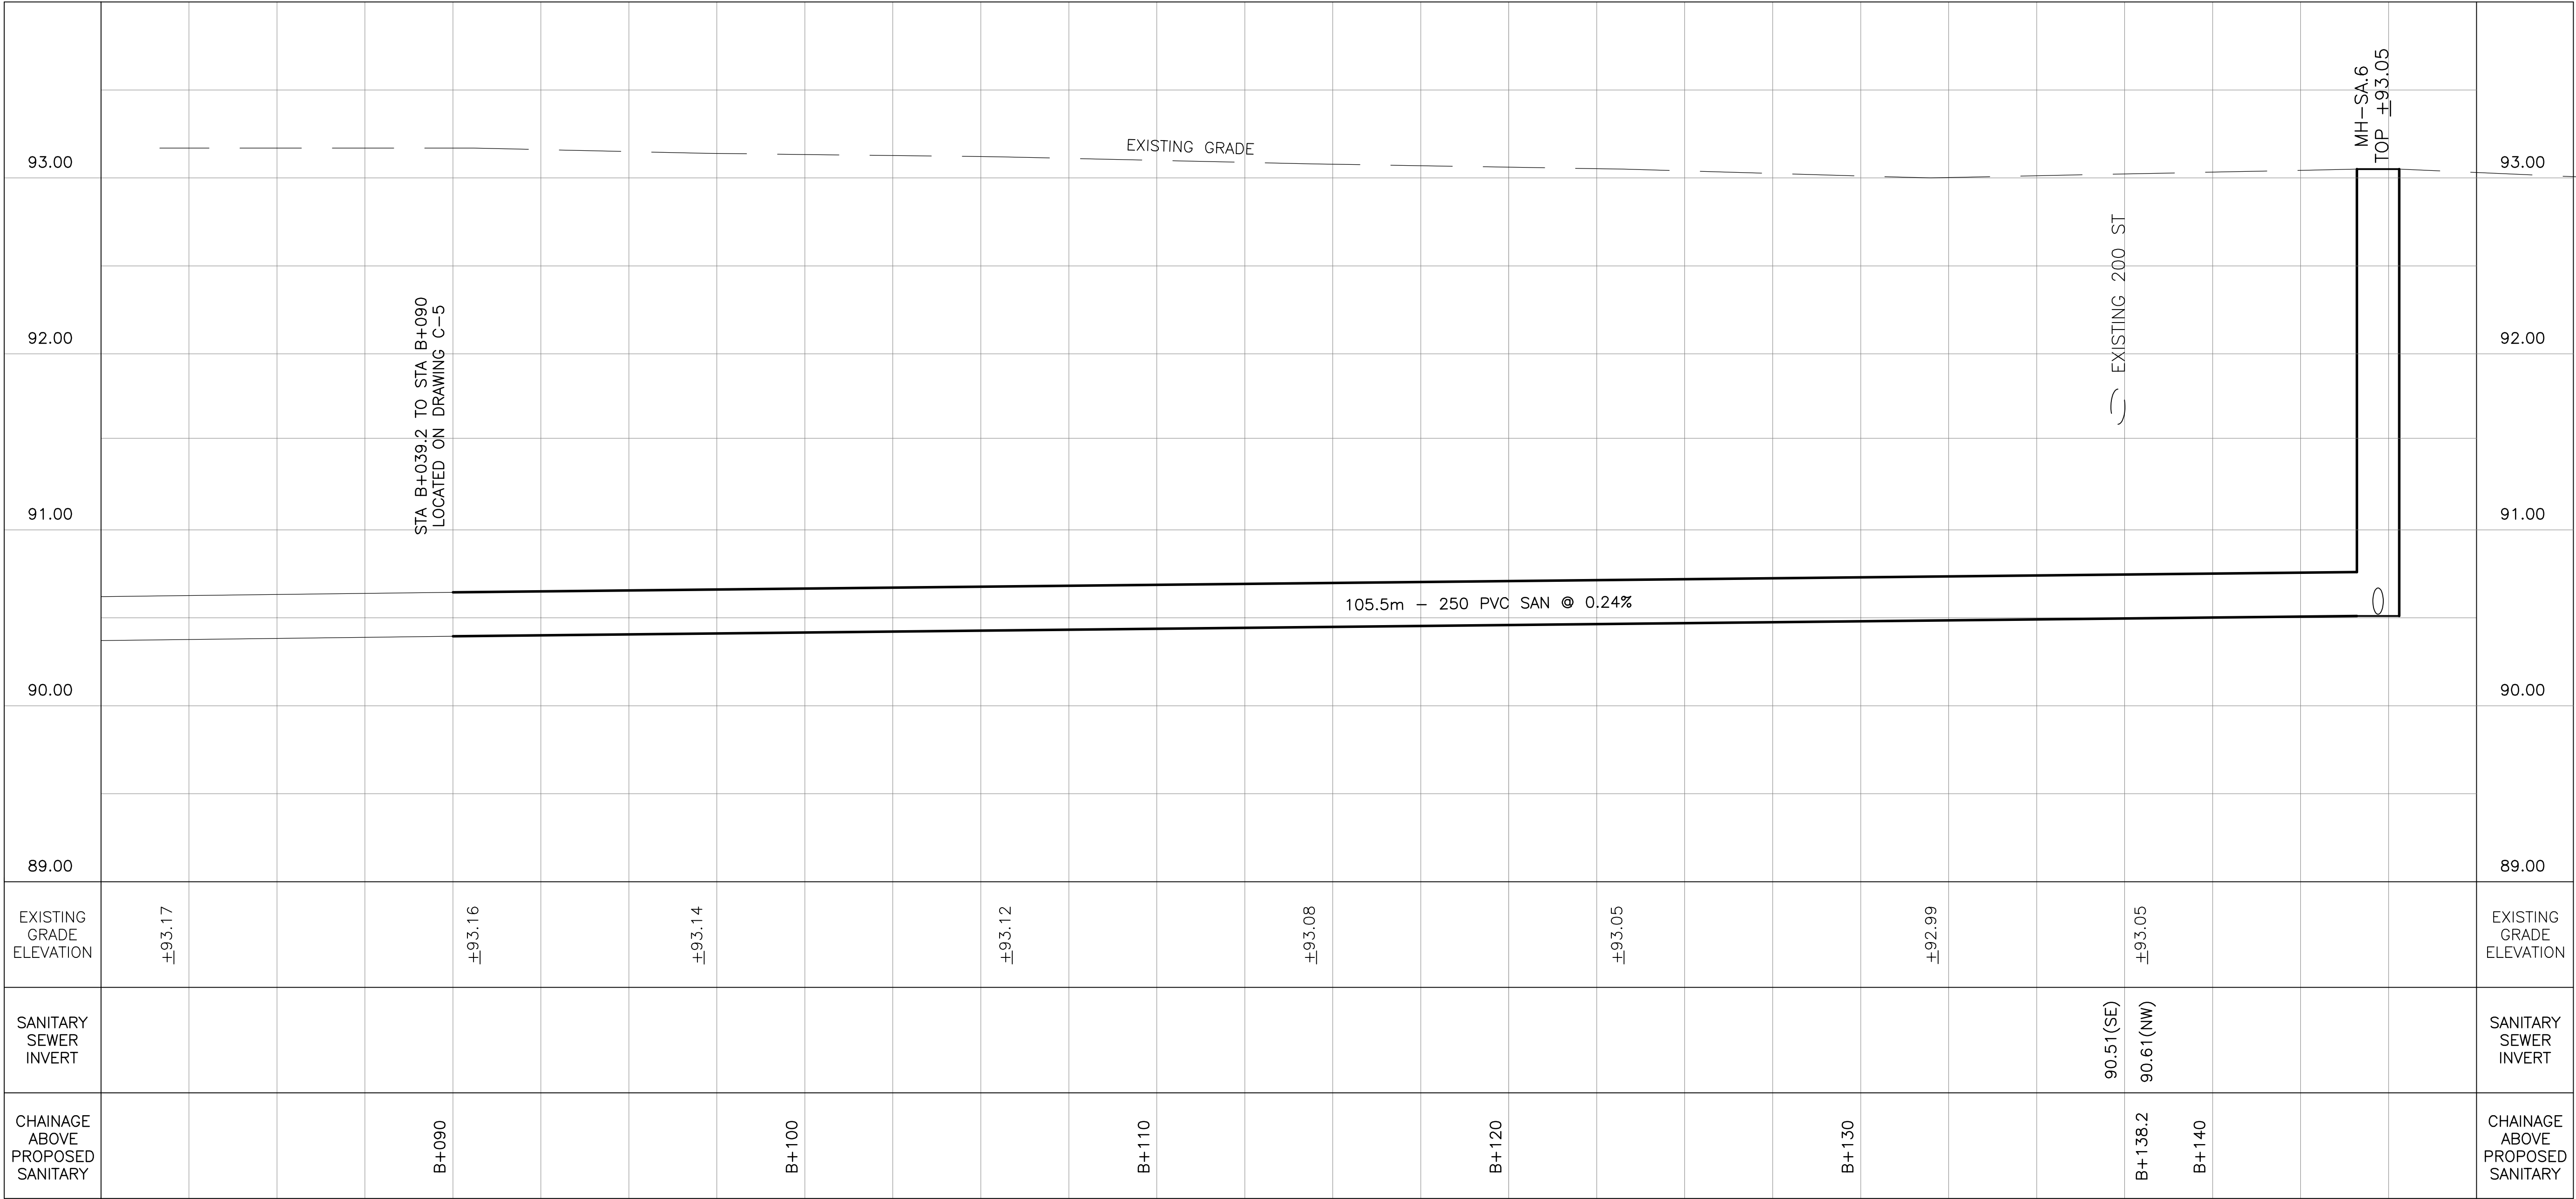


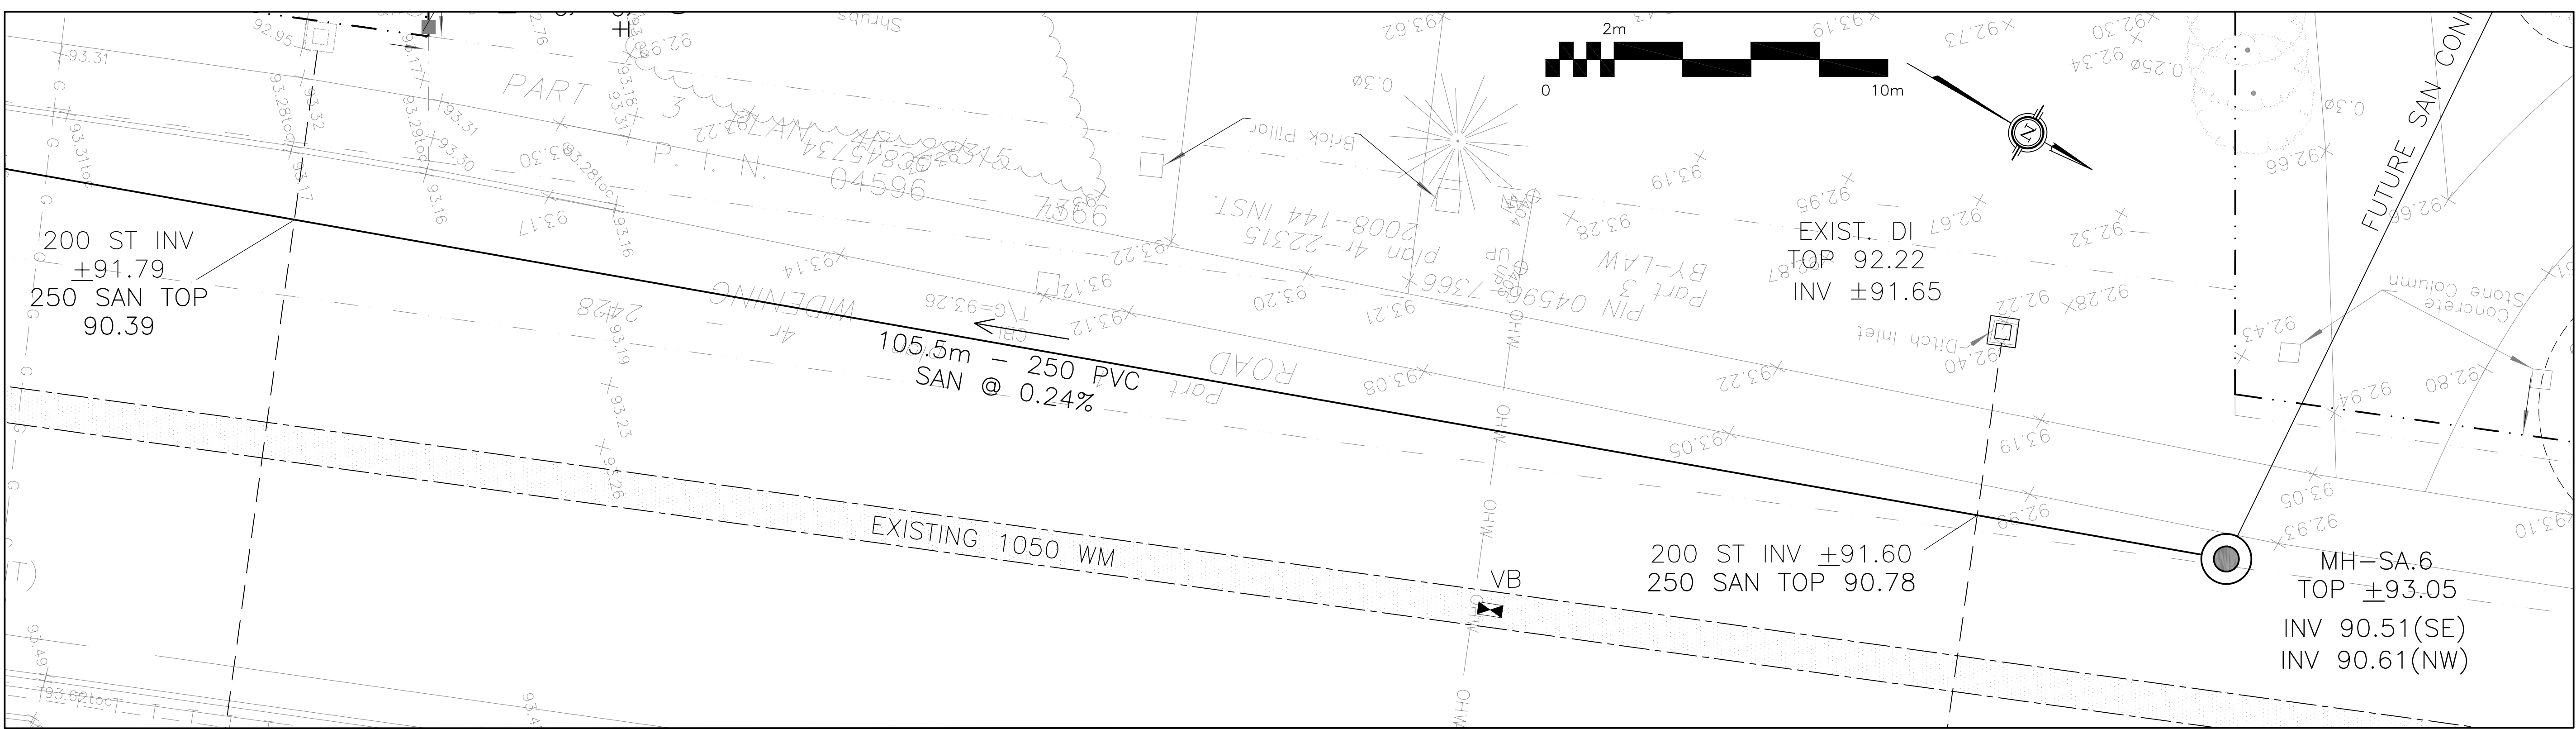

|       |                          |
|-------|--------------------------|
| CB    | CATCH-BASIN              |
| MH    | STORM MANHOLE            |
| CB/MH | CATCH BASIN/MANHOLE      |
| MH    | SANITARY MANHOLE         |
| VC    | VALVE CHAMBER            |
| SPL   | SPRINGLINE OF PIPE       |
| INV   | INVERT OF PIPE           |
| SAN   | SANITARY SEWER           |
| ST    | STORM SEWER              |
| WS/WM | WATER SERVICE/WATERMAIN  |
| CS    | CURB STOP & STANDPOST    |
| VB    | VALVE & VALVE BOX        |
| FF    | FIRE HYDRANT             |
|       | EXISTING GRADE ELEVATION |
|       | OVER HEAD WIRE           |
|       | HYDRO                    |
| B     | BELL TELEPHONE           |
|       | CABLE                    |
| G     | GAS                      |
| T     | TRAFFIC                  |
|       | PROPERTY LINE            |

KEY PLAN

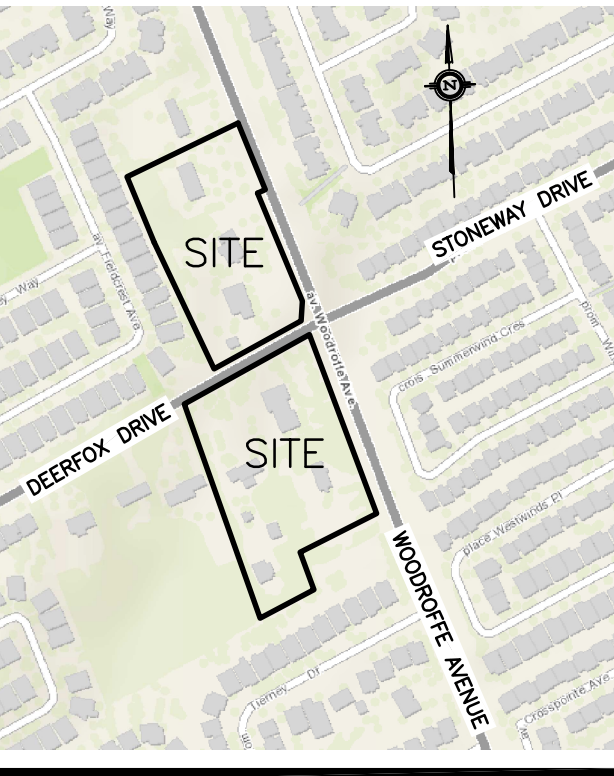


|     |           |                                |
|-----|-----------|--------------------------------|
|     |           |                                |
|     |           |                                |
|     |           |                                |
|     |           |                                |
|     |           |                                |
|     |           |                                |
| 3   | MAR 17-22 | RE-ISSUED TO CITY FOR APPROVAL |
| 2   | DEC 21-21 | ISSUED TO CITY FOR APPROVAL    |
| 1   | SEP 28-21 | PRELIMINARY                    |
| No. | DATE      | REVISION                       |

D. B. GRAY ENGINEERING INC.  
Stormwater Management - Grading & Drainage - Storm & Sanitary Sewers - Watermain  
700 Long Point Circle 613-425-8044  
Ottawa, Ontario d.gray@dbgrayengineering.com

Project MUNICIPAL SANITARY SEWER EXTENSION  
CROSSING WOODROFFE AVE  
WEST FROM STONEWAY DR  
NORTH ON WOODROFFE AVE &  
WEST ON DEERFOX DR  
OTTAWA, ONTARIO

Drawing Title  
PLAN AND PROFILE  
STA A 0+090 TO A 0+144.7

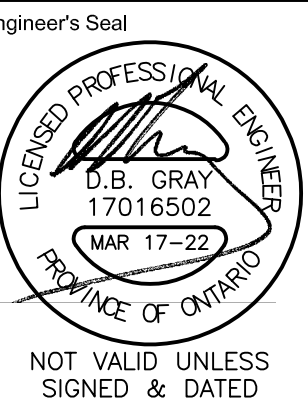

Drawn D.B.G.  
Hor. Scale 1:100  
Vert. Scale 1:20  
Date OCT 1-21  
Job No. 20055

Drawing No.  
C-6  
of 9