

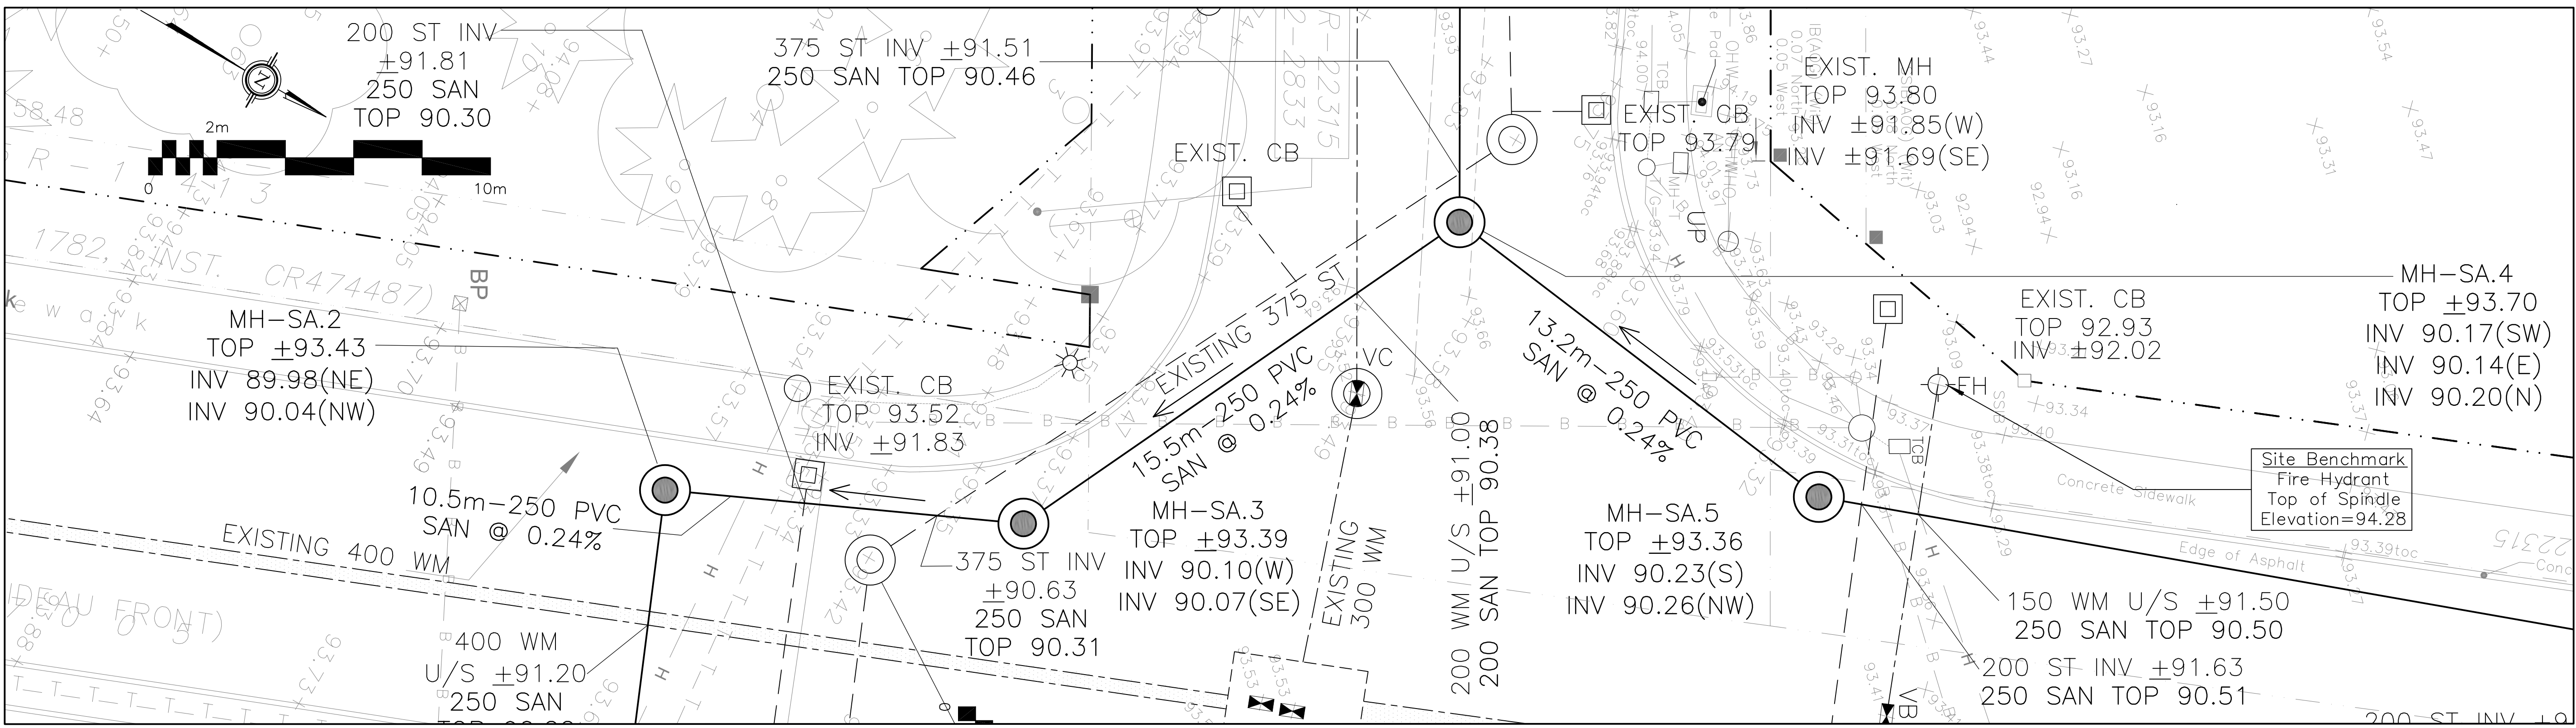


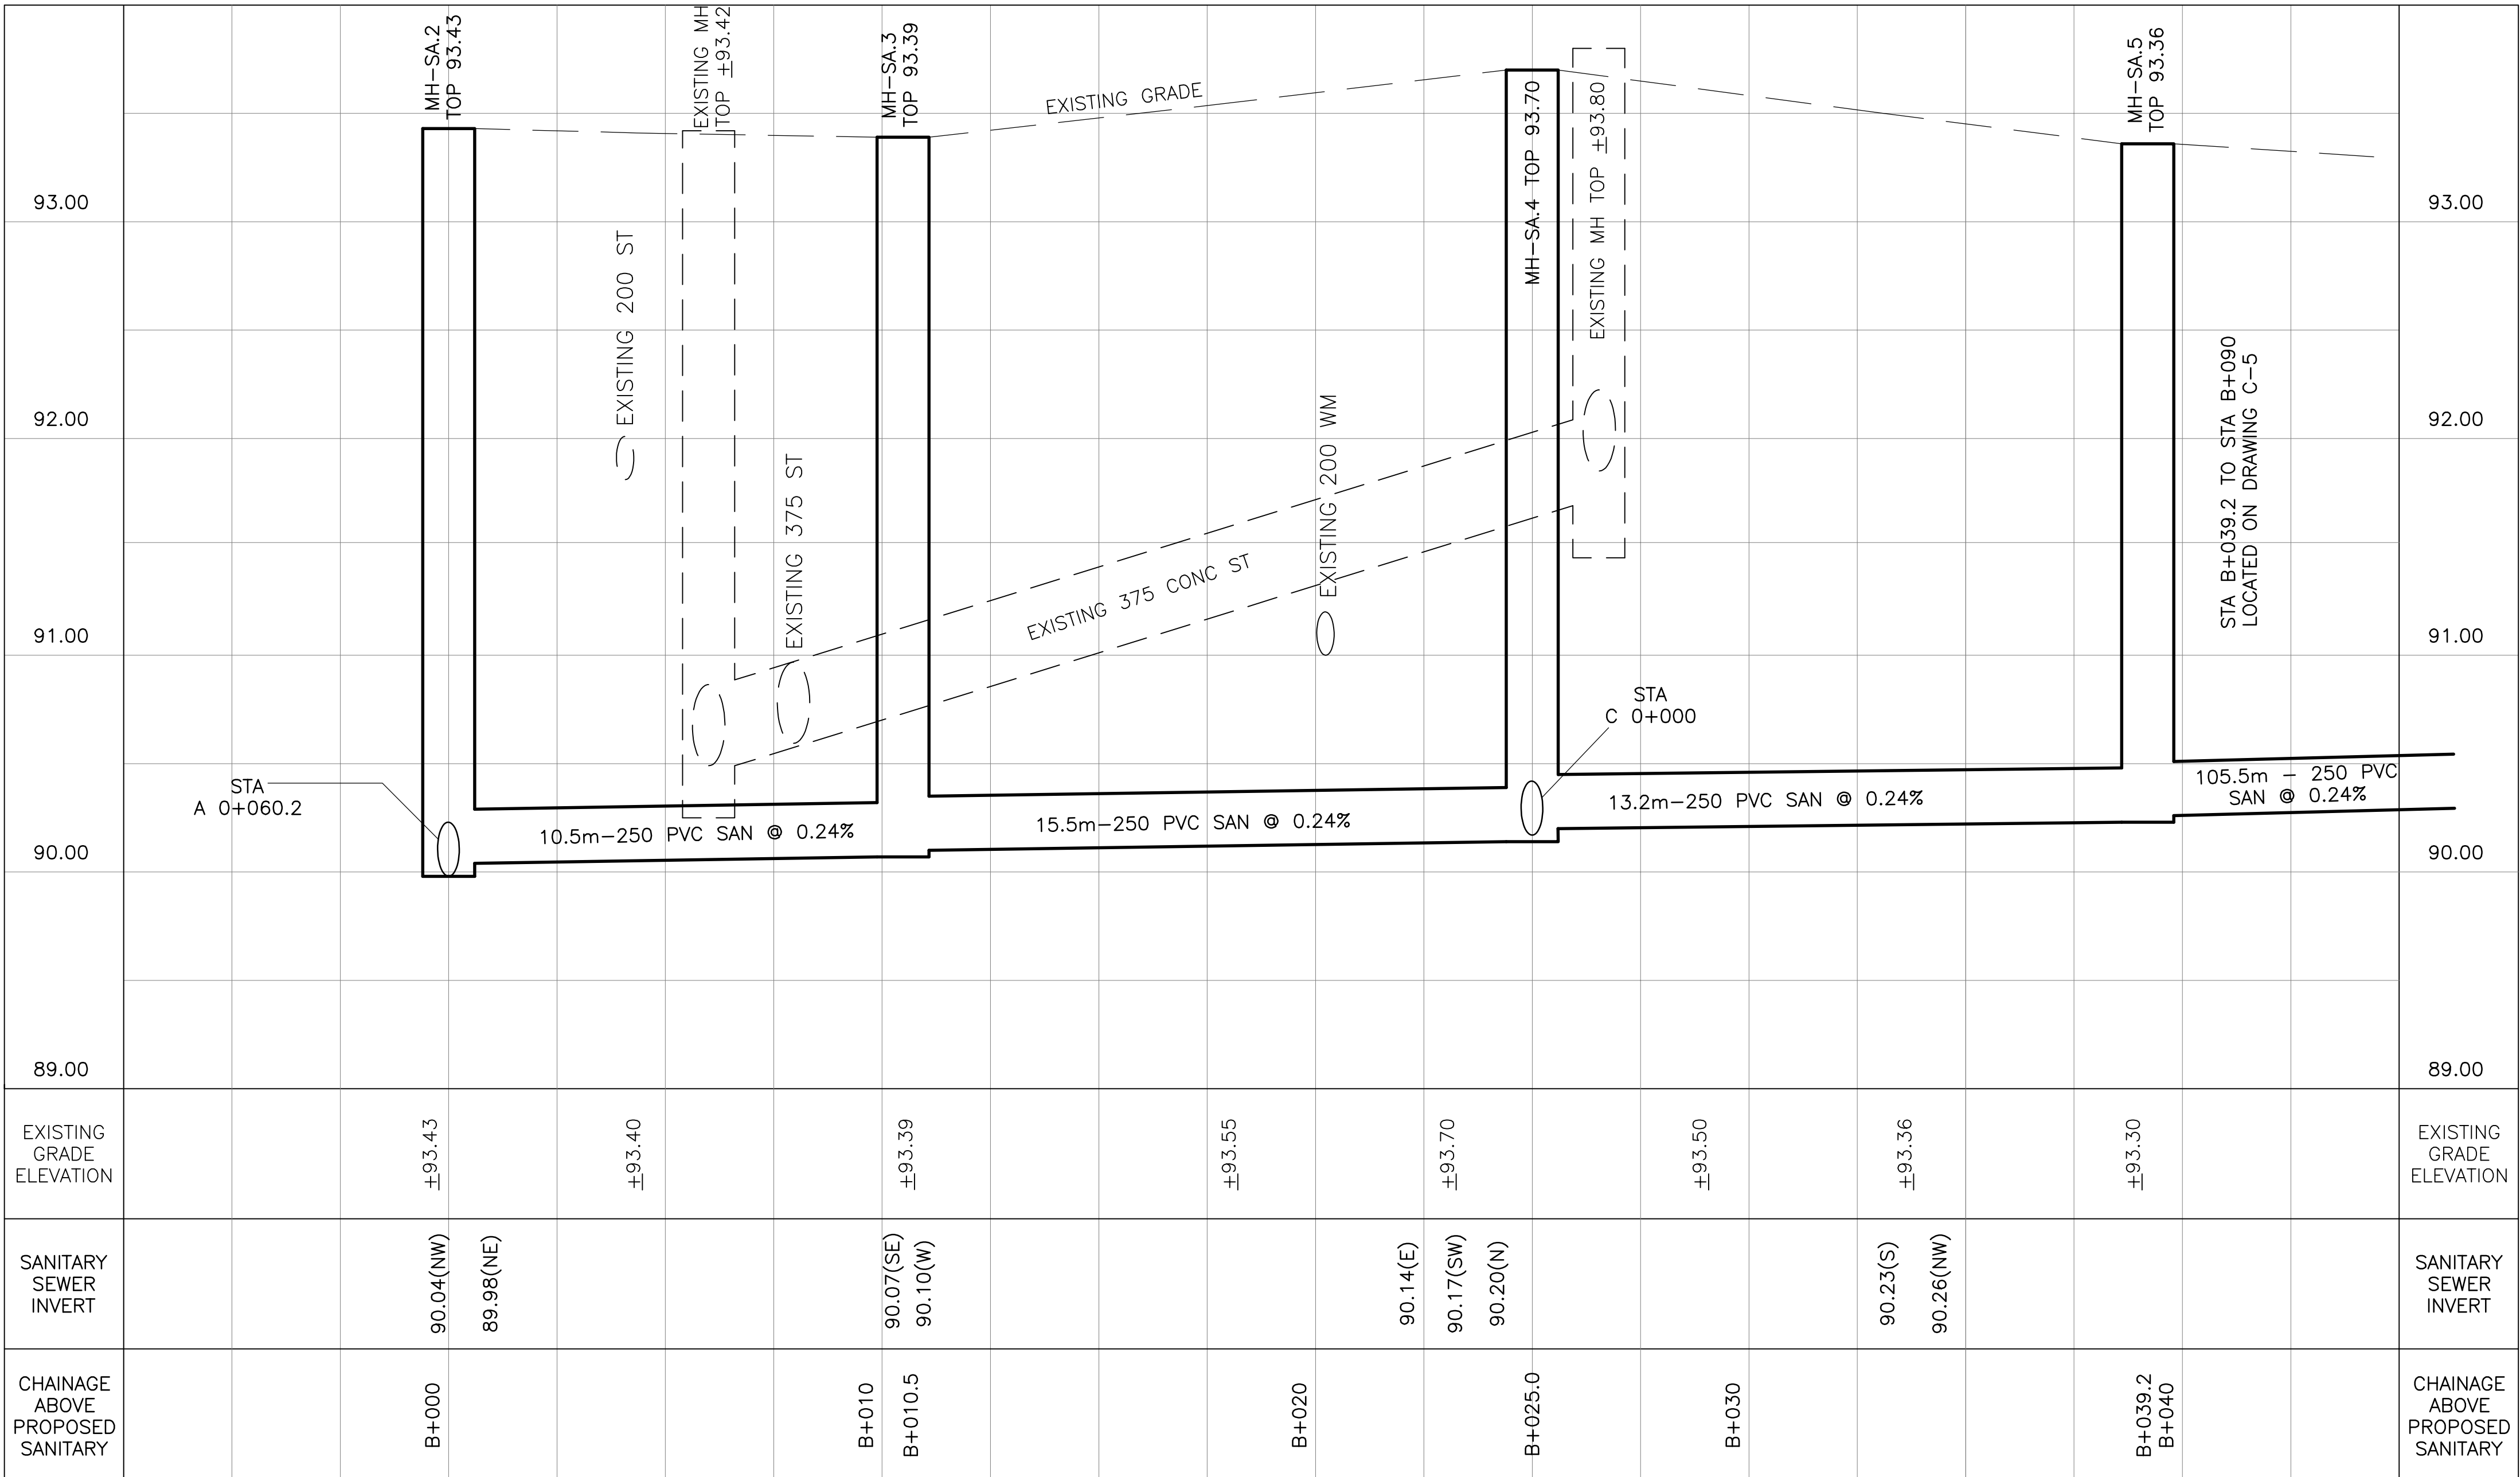

CB	CATCH-BASIN
MH	STORM MANHOLE
CB/MH	CATCH BASIN/MANHOLE
MH	SANITARY MANHOLE
VC	VALVE CHAMBER
SPL	SPRINGLINE OF PIPE
INV	INVERT OF PIPE
SAN	SANITARY SEWER
ST	STORM SEWER
WS/WM	WATER SERVICE/WATERMAIN
CS	CURB STOP & STANDPOST
VB	VALVE & VALVE BOX
FF	FIRE HYDRANT
X 99.99	EXISTING GRADE ELEVATION
—	OVER HEAD WIRE
.....	HYDRO
— B —	BELL TELEPHONE
— C —	CABLE
— G —	GAS
— T —	TRAFFIC
- - -	PROPERTY LINE

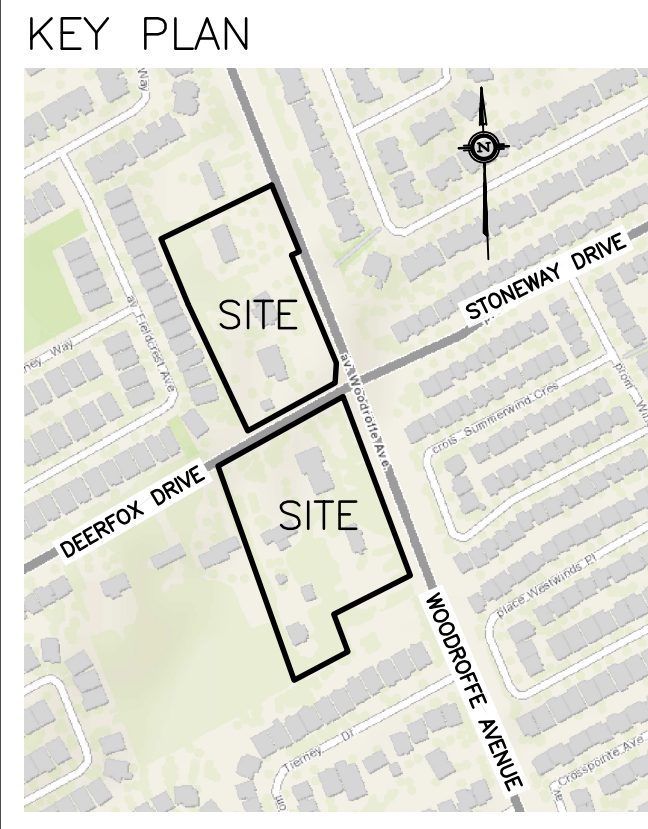

3	MAR 17-22	RE-ISSUED TO CITY FOR APPROVAL
2	DEC 21-21	ISSUED TO CITY FOR APPROVAL
1	SEP 28-21	PRELIMINARY
No.	DATE	REVISION

D. B. GRAY ENGINEERING INC.
Stormwater Management - Grading & Drainage - Storm & Sanitary Sewers - Watermain
700 Long Point Circle
Ottawa, Ontario
613-425-8044
d.gray@dbgrayengineering.com

Project **MUNICIPAL SANITARY SEWER EXTENSION CROSSING WOODROFFE AVE WEST FROM STONEWAY DR NORTH ON WOODROFFE AVE & WEST ON DEERFOX DR OTTAWA, ONTARIO**

Drawing Title
PLAN AND PROFILE
STA B+000 TO STA B+039.2

Engineer's Seal
D.B. GRAY
17016502
MAR 17-22
PROVINCE OF ONTARIO

Drawn: D.B.G.
Hor. Scale: 1:100
Vert. Scale: 1:20
Date: OCT 1-21
Job No.: 20055

Drawing No.
C-4
of 9

NOT VALID UNLESS SIGNED & DATED