



REFER TO NOTES
ON DRAWING C-4

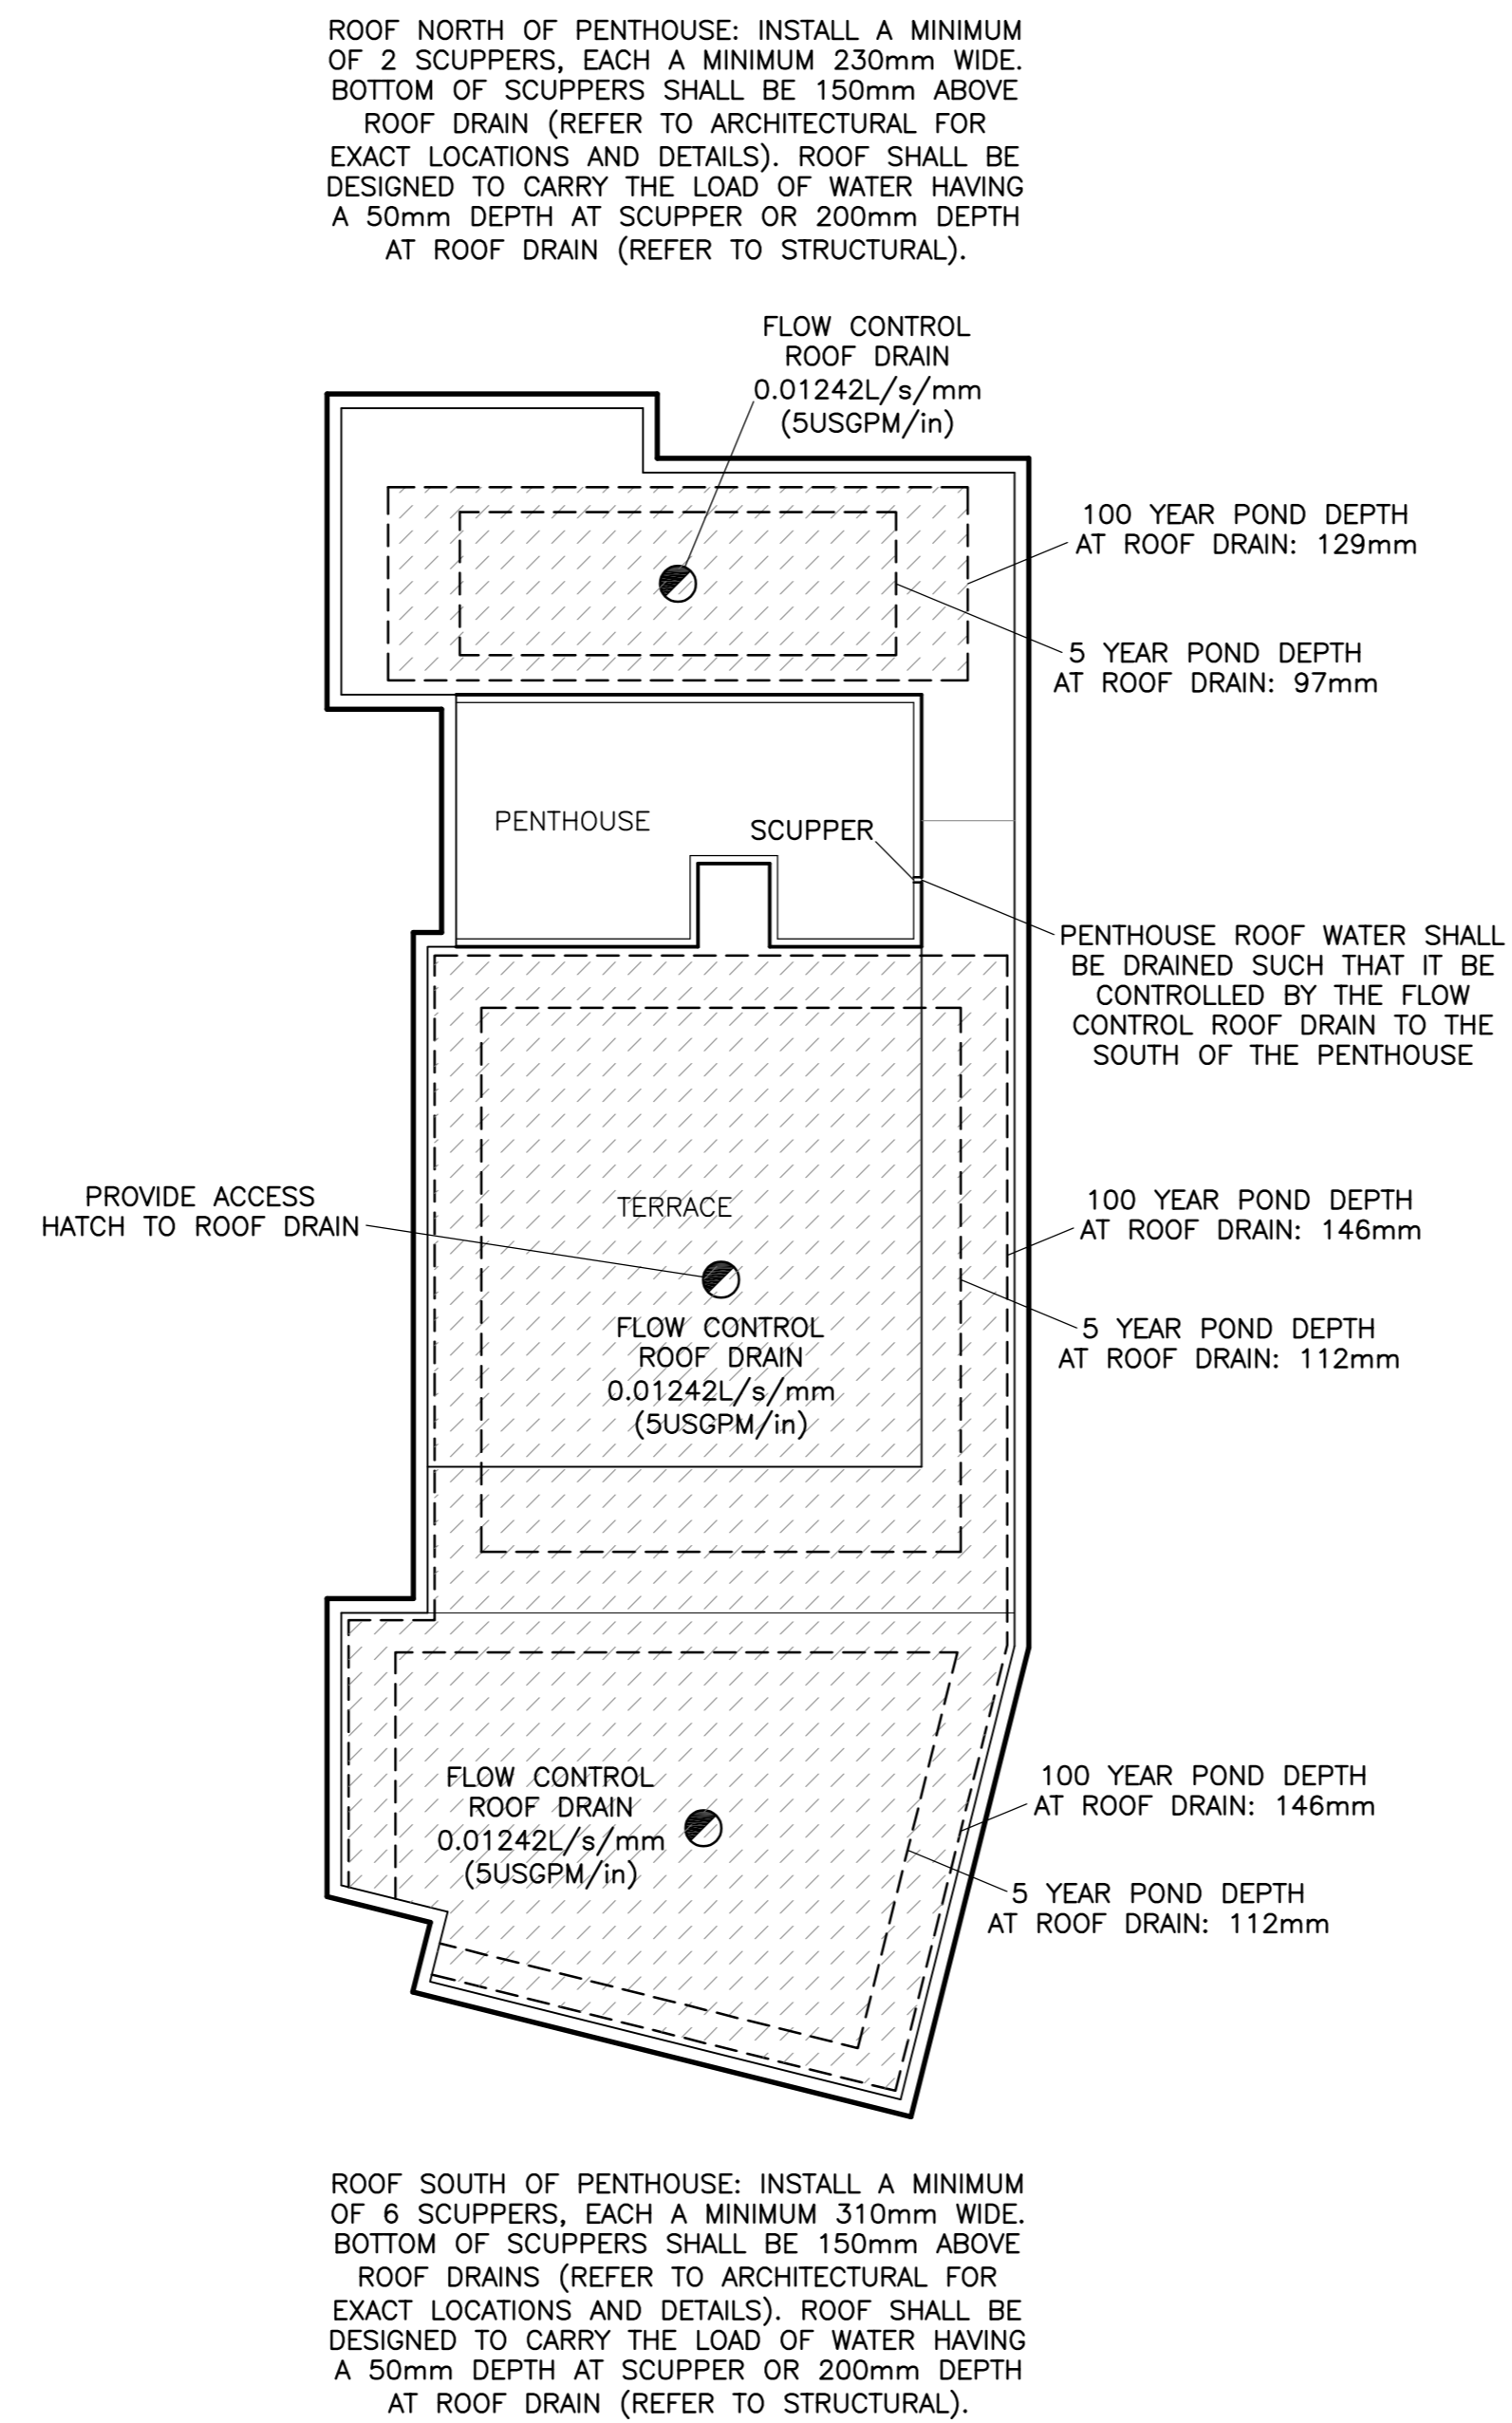


ROOF PLAN

REFER TO NOTES
ON DRAWING C-4

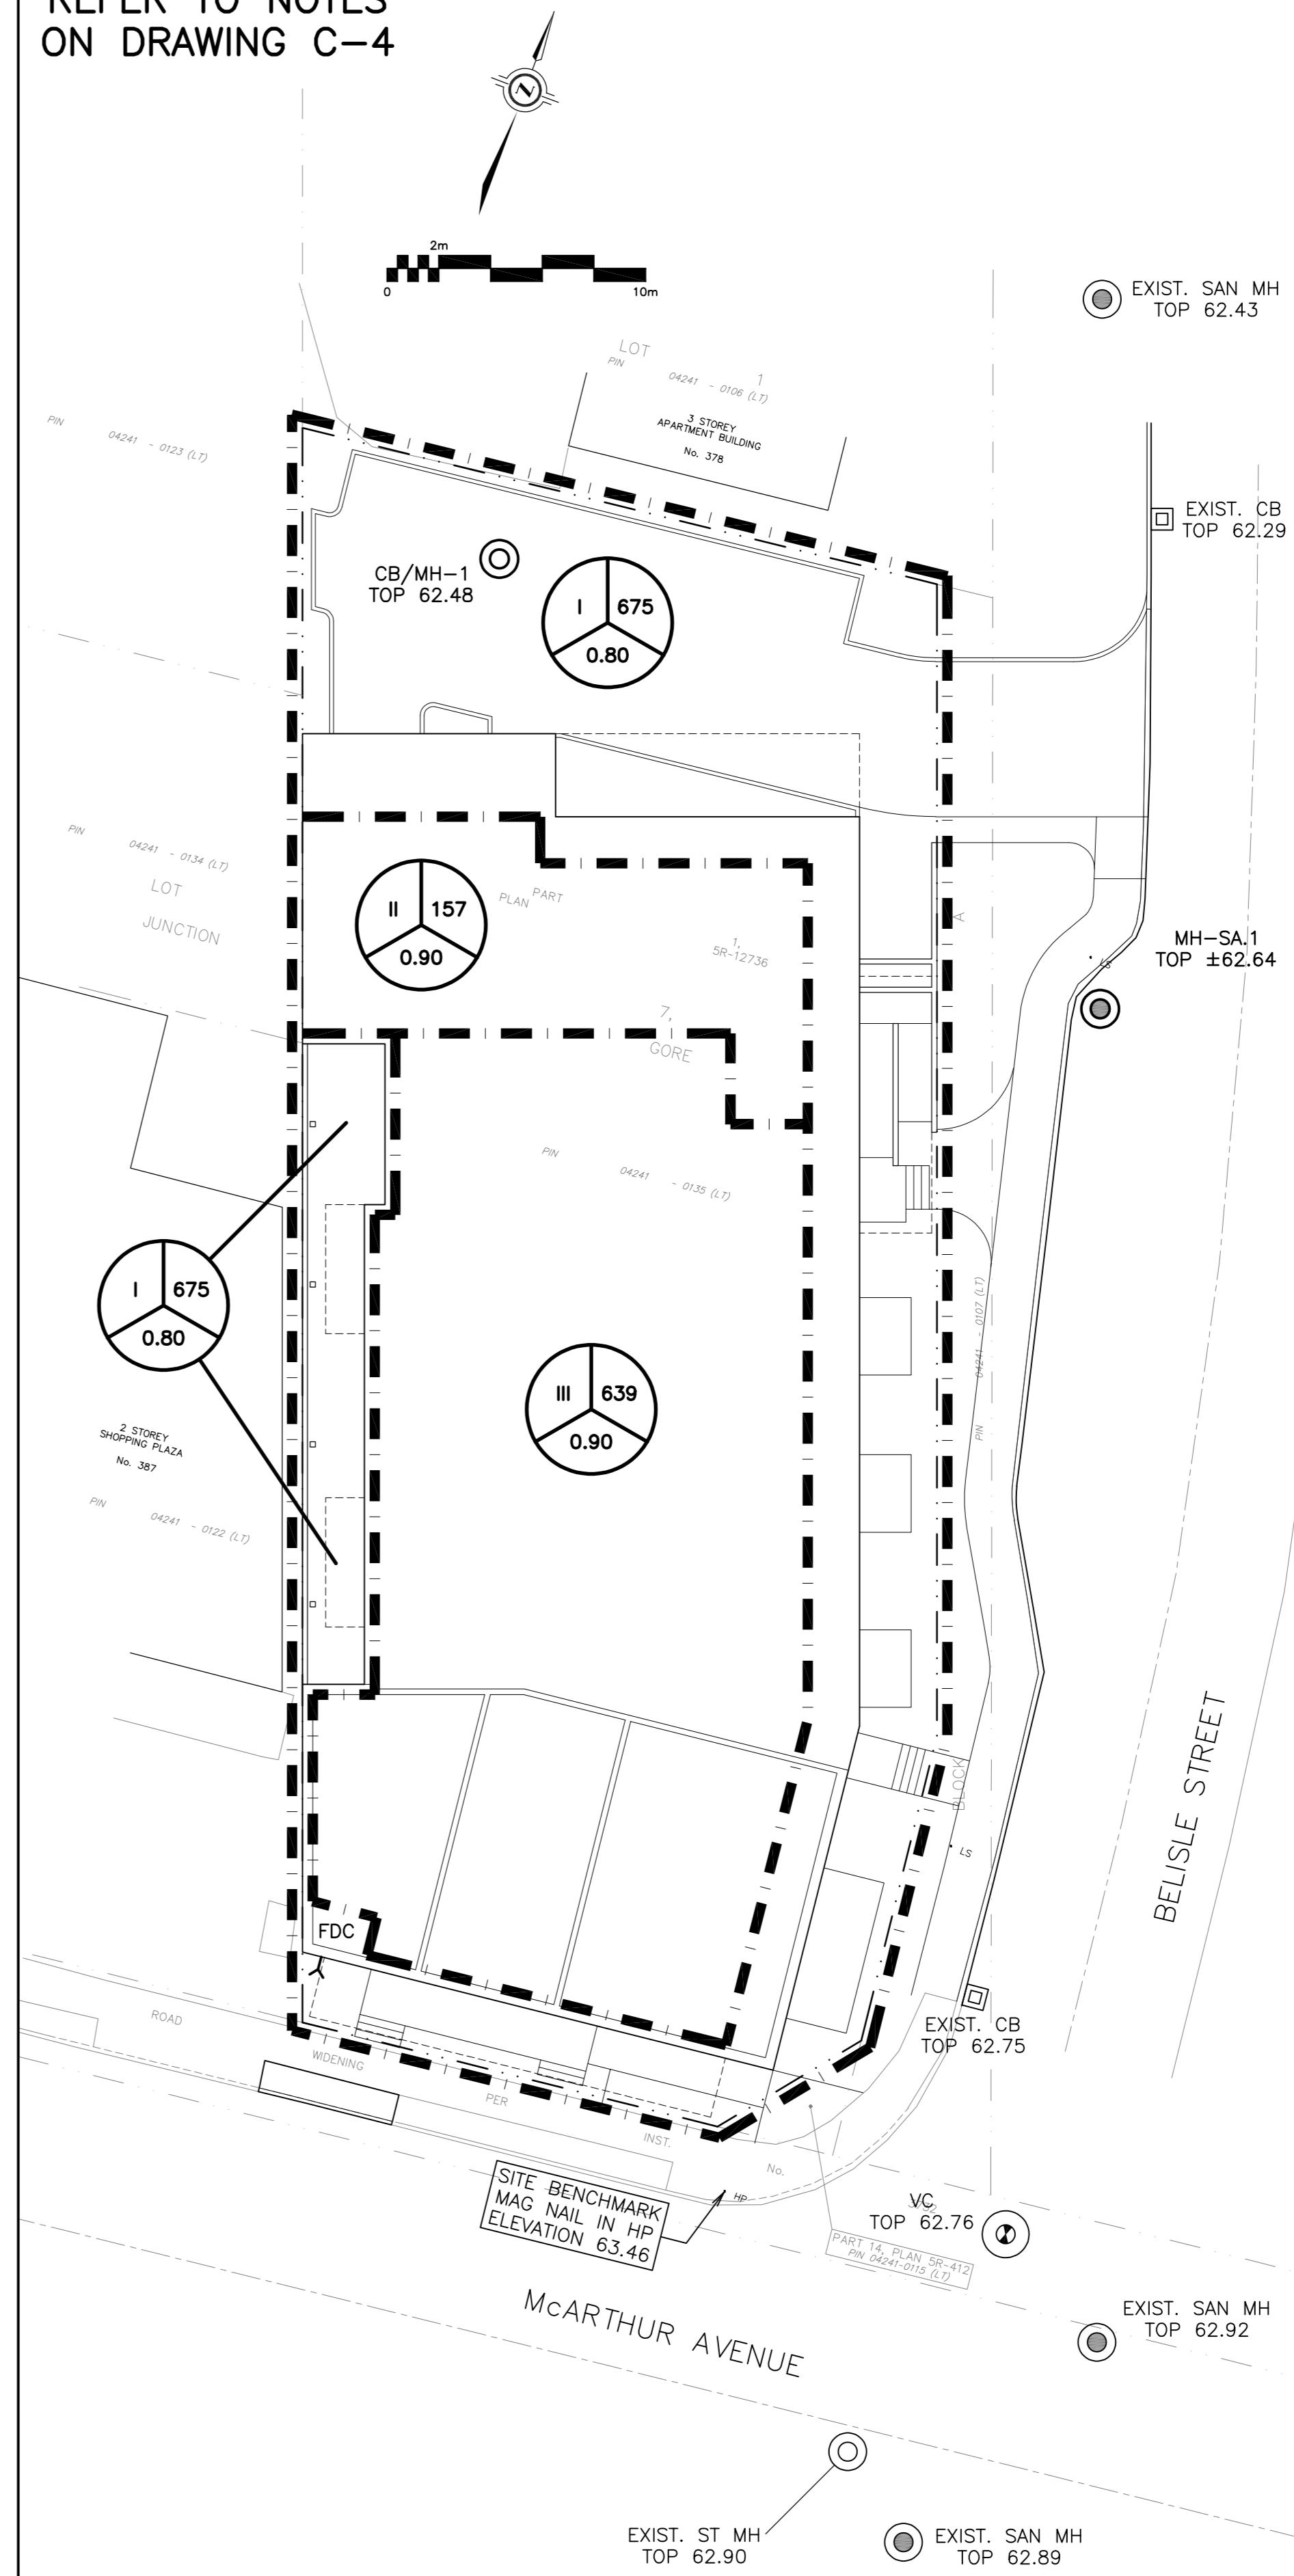


DRAINAGE PLAN

LEGEND

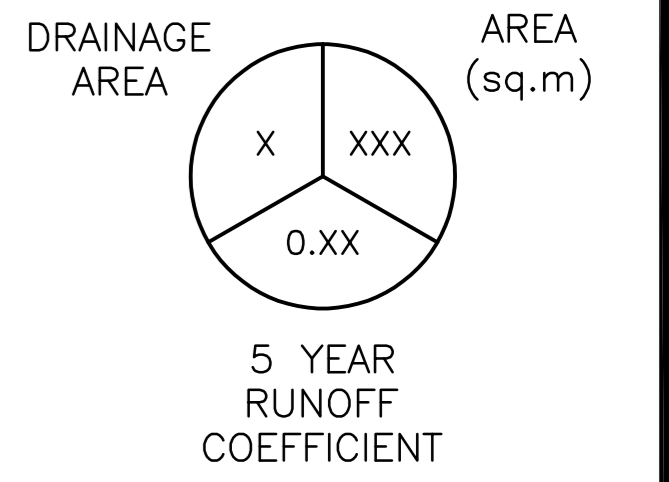

KEY PLAN

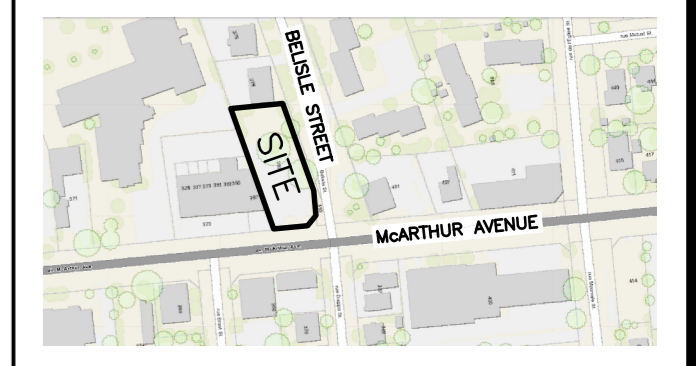

No.	DATE	REVISION
2	JUN 15-22	ISSUED FOR APPROVAL
1	APR 27-22	ISSUED FOR COORDINATION

D. B. GRAY ENGINEERING INC.
 Stormwater Management - Grading & Drainage - Storm & Sanitary Sewers - Watermain
 700 Long Point Circle 613-425-8044
 Ottawa, Ontario d.gray@dbgrayengineering.com

Project
**PROPOSED 6-STOREY
 MIXED-USE BUILDING
 393 McARTHUR AVENUE
 OTTAWA, ONTARIO**

Drawing Title
**ROOF PLAN AND
 DRAINAGE PLAN**

Engineer's Seal:

Drawn: D.B.G.
 H. Scale: 1:200
 V. Scale:
 Date: APR 27-22
 Job No.: 21111

Drawing No.
**C-3
 of 4**

NOT VALID UNLESS
 SIGNED & DATED