

**LEGEND**


DRAINAGE AREA

AREA (sq.m)

X XXX

0.XX

5 YEAR RUNOFF COEFFICIENT

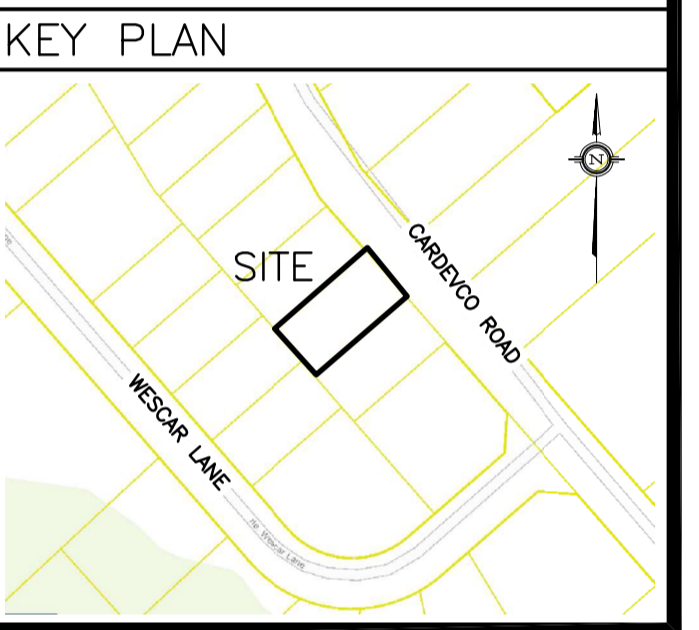


No.	DATE	REVISION
2	NOV 24-22	ISSUED FOR APPROVAL
1	NOV 15-22	ISSUED FOR COORDINATION

**D. B. GRAY ENGINEERING INC.**  
 Stormwater Management - Grading & Drainage - Storm & Sanitary Sewers - Watermain  
 700 Long Point Circle 613-425-8044  
 Ottawa, Ontario d.gray@dbgrayengineering.com

Project  
**PROPOSED ADDITION  
 135 CARDEVCO ROAD  
 OTTAWA, ONTARIO**

Drawing Title  
**PRE & POST DEVELOPMENT  
 DRAINAGE PLAN**

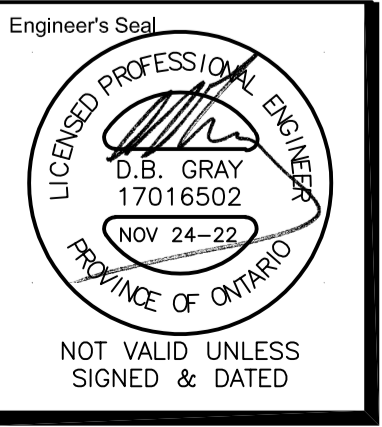

Engineer's Seal  
 Drawn D.B.G.  
 H. Scale 1:200  
 V. Scale  
 Date NOV 15-22  
 Job No. 21081

Drawing No.  
**C-4  
 of 4**