


# ACCESS STORAGE

60 DENZIL DOYLE COURT, OTTAWA, ON  
ELECTRICAL



Client

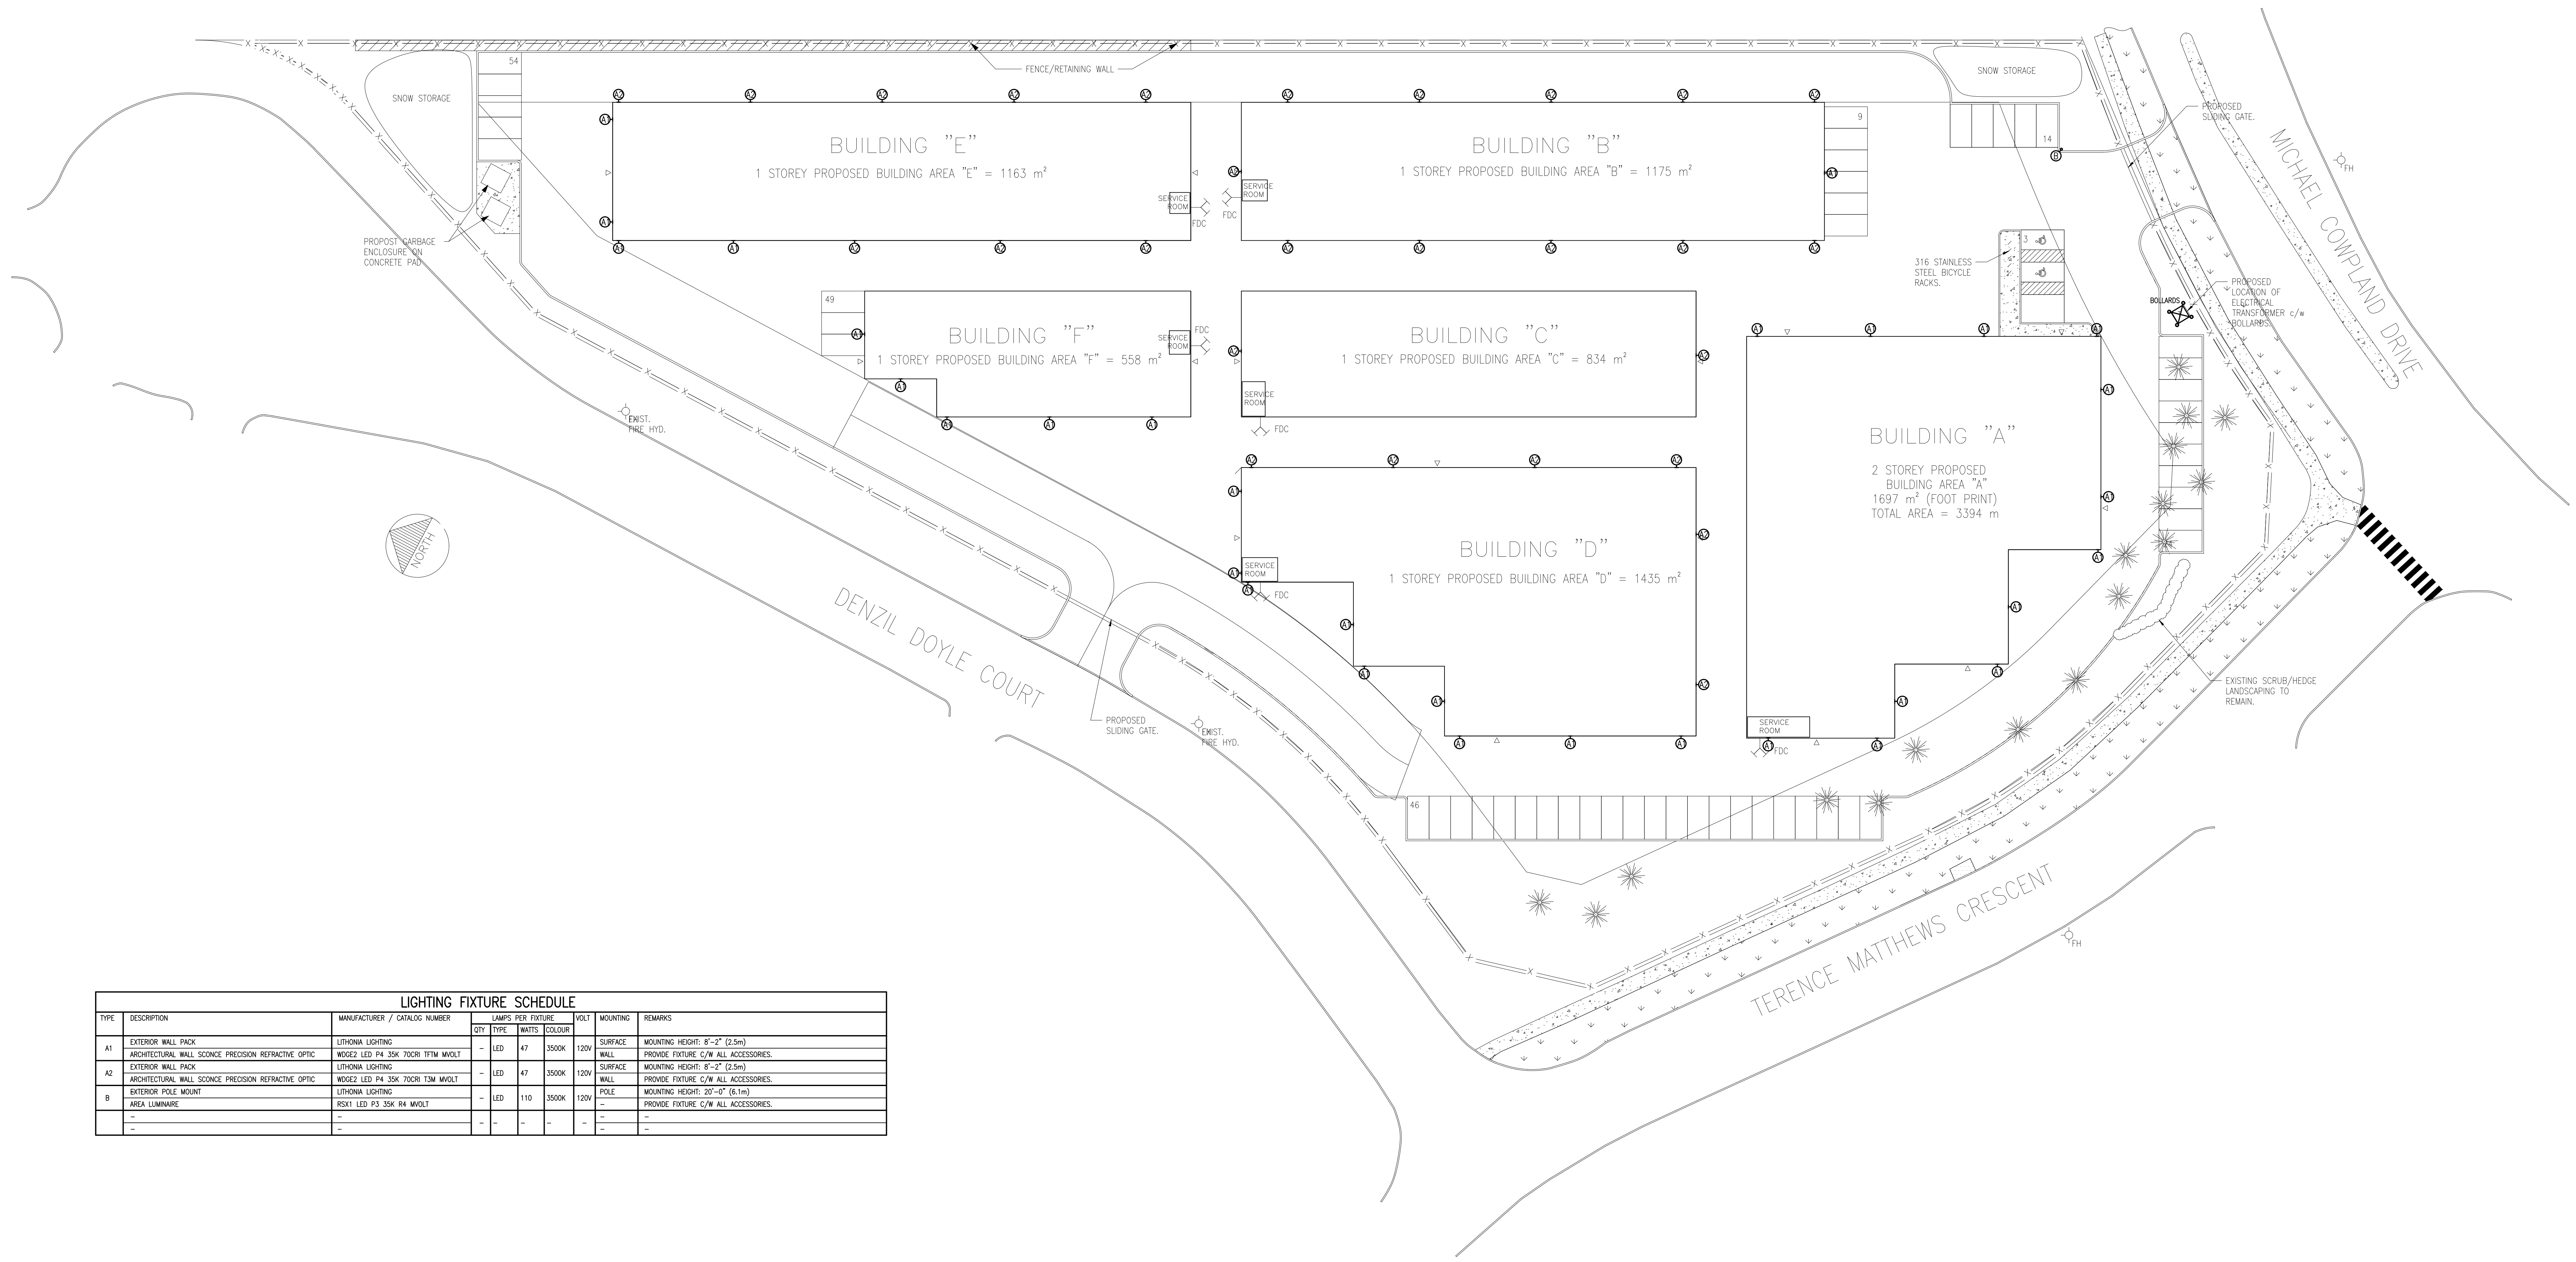

LIGHTING FIXTURE SCHEDULE							
TYPE	DESCRIPTION	MANUFACTURER / CATALOG NUMBER	QTY	LAMPS PER FIXTURE	VOLTS	MOUNTING	REMARKS
A1	EXTERIOR WALL PACK ARCHITECTURAL WALL SOURCE PRECISION REFRACTIVE OPTIC	LITHONIA LIGHTING WIDE2 LED P4 35K 700R 157M MWSLT	47	1	3500K	120V SURFACE WALL	MOUNTING HEIGHT: 8'-2" (2.5m) PROVIDE FIXTURE C/W ALL ACCESSORIES.
A2	EXTERIOR WALL PACK ARCHITECTURAL WALL SOURCE PRECISION REFRACTIVE OPTIC	LITHONIA LIGHTING WIDE2 LED P4 35K 700R 157M MWSLT	47	1	3500K	120V SURFACE WALL	MOUNTING HEIGHT: 8'-2" (2.5m) PROVIDE FIXTURE C/W ALL ACCESSORIES.
B	EXTERIOR POLE MOUNT AREA LUMINAIRE	LITHONIA LIGHTING P5X1 LED P3 35K R4 MWSLT	110	1	3500K	120V POLE	MOUNTING HEIGHT: 20'-0" (6.1m) PROVIDE FIXTURE C/W ALL ACCESSORIES.
-	-	-	-	-	-	-	-

**1**  
**E1** ELECTRICAL SITE PLAN  
1:300

DATE	REVISION	REF
2021-12-16	ISSUED FOR SITE PLAN	0

THE ENGINEER MAKES NO WARRANTY AND ALL RESPONSIBILITY AND LIABILITY FOR PROBLEMS WITHIN THESE PLANS SHALL BE THE RESPONSIBILITY OF THE CLIENT. THE ENGINEER'S LIABILITY IS LIMITED TO THE DESIGN AND CONSTRUCTION OF THE PROJECT AND NOT TO ANY OTHER MATTERS. THE ENGINEER'S LIABILITY IS LIMITED TO THE DESIGN AND CONSTRUCTION OF THE PROJECT AND NOT TO ANY OTHER MATTERS. THIS DRAWING IS THE PROPERTY OF GOODKEY WEEDMARK & ASSOCIATES LIMITED AND ALL RIGHTS ARE RESERVED. NO USE OF THIS DRAWING MAY BE MADE WITHOUT EXPRESS WRITTEN CONSENT. DO NOT SCALE DRAWINGS.

**Goodkey Weedmark Consulting Engineers**  
GOODKEY WEEDMARK & ASSOCIATES LIMITED  
1688 Woodward Dr. Ottawa, Ontario K2C 3J8  
613 727-5111 Voice  
613 727-5115 Fax  
www.gwe.com Web

Project north  
Scale  
Professional Engineer  
B. B. VIVAS  
100123120  
PROVINCE OF ONTARIO

Project/Proprietor  
**ACCESS STORAGE**  
60 DENZIL DOYLE CT.  
OTTAWA ON  
ELECTRICAL SITE PLAN


Scale: AS NOTED  
Project no./No. du projet: 2021-566

Design by: D.V.  
Drawing/Desain: **E1**


Checked by: B.P.  
Reviewed by: D.V.  
Examined by: **2**

Date: DECEMBER 2022  
Revision no.:  
Acad file/Excerpt:




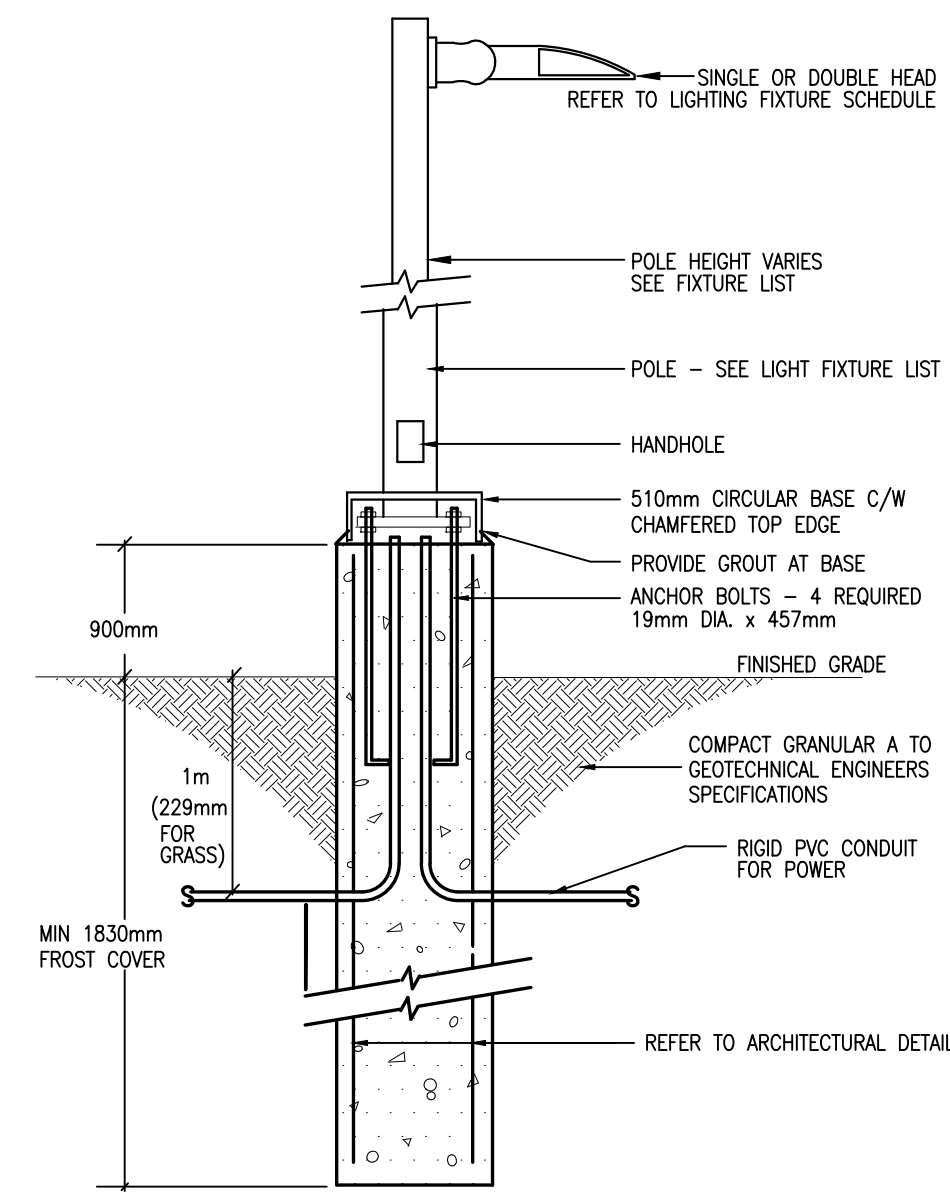


**1**  
**E2** TYPICAL BASE DETAIL FOR EXTERIOR LIGHT STANDARD  
N.T.S.

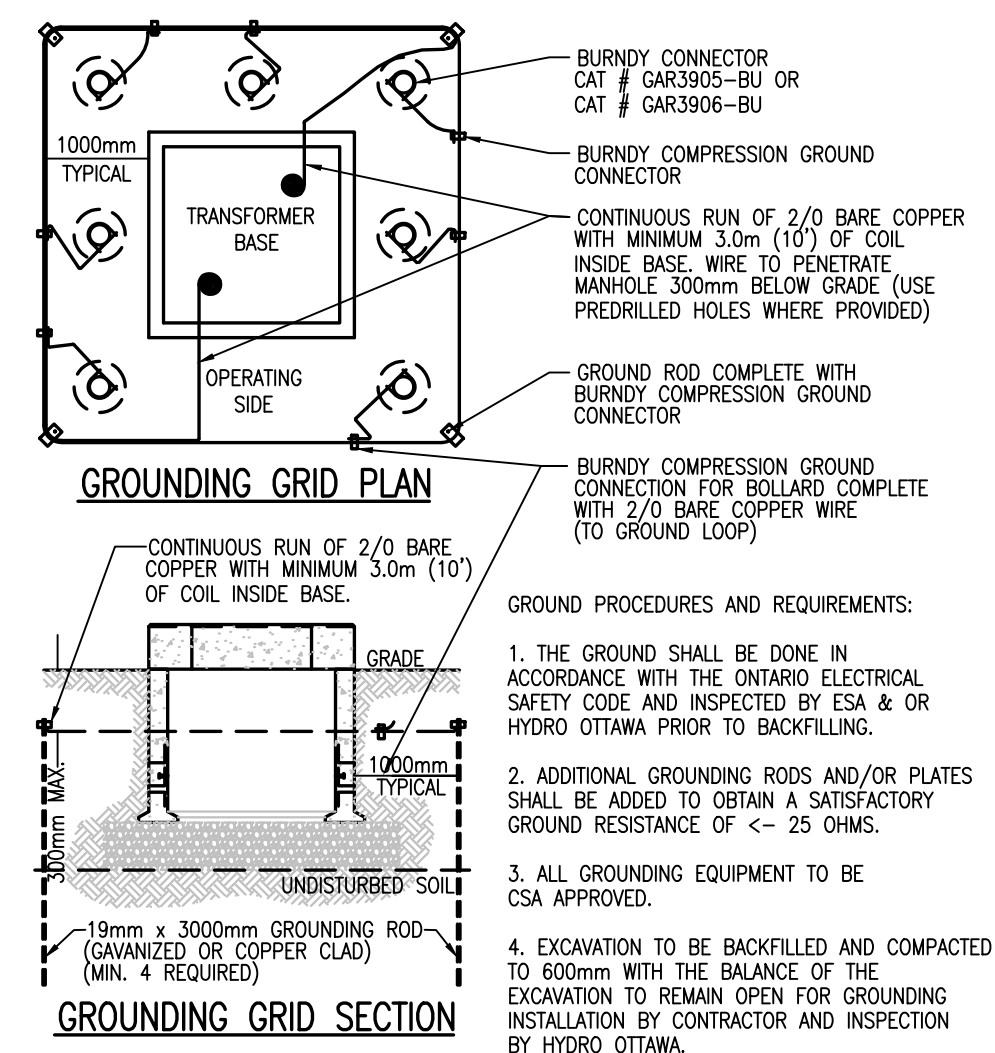


**2**  
**E2** PAD MOUNTED TRANSFORMER BASE GROUNDING DETAIL  
N.T.S.

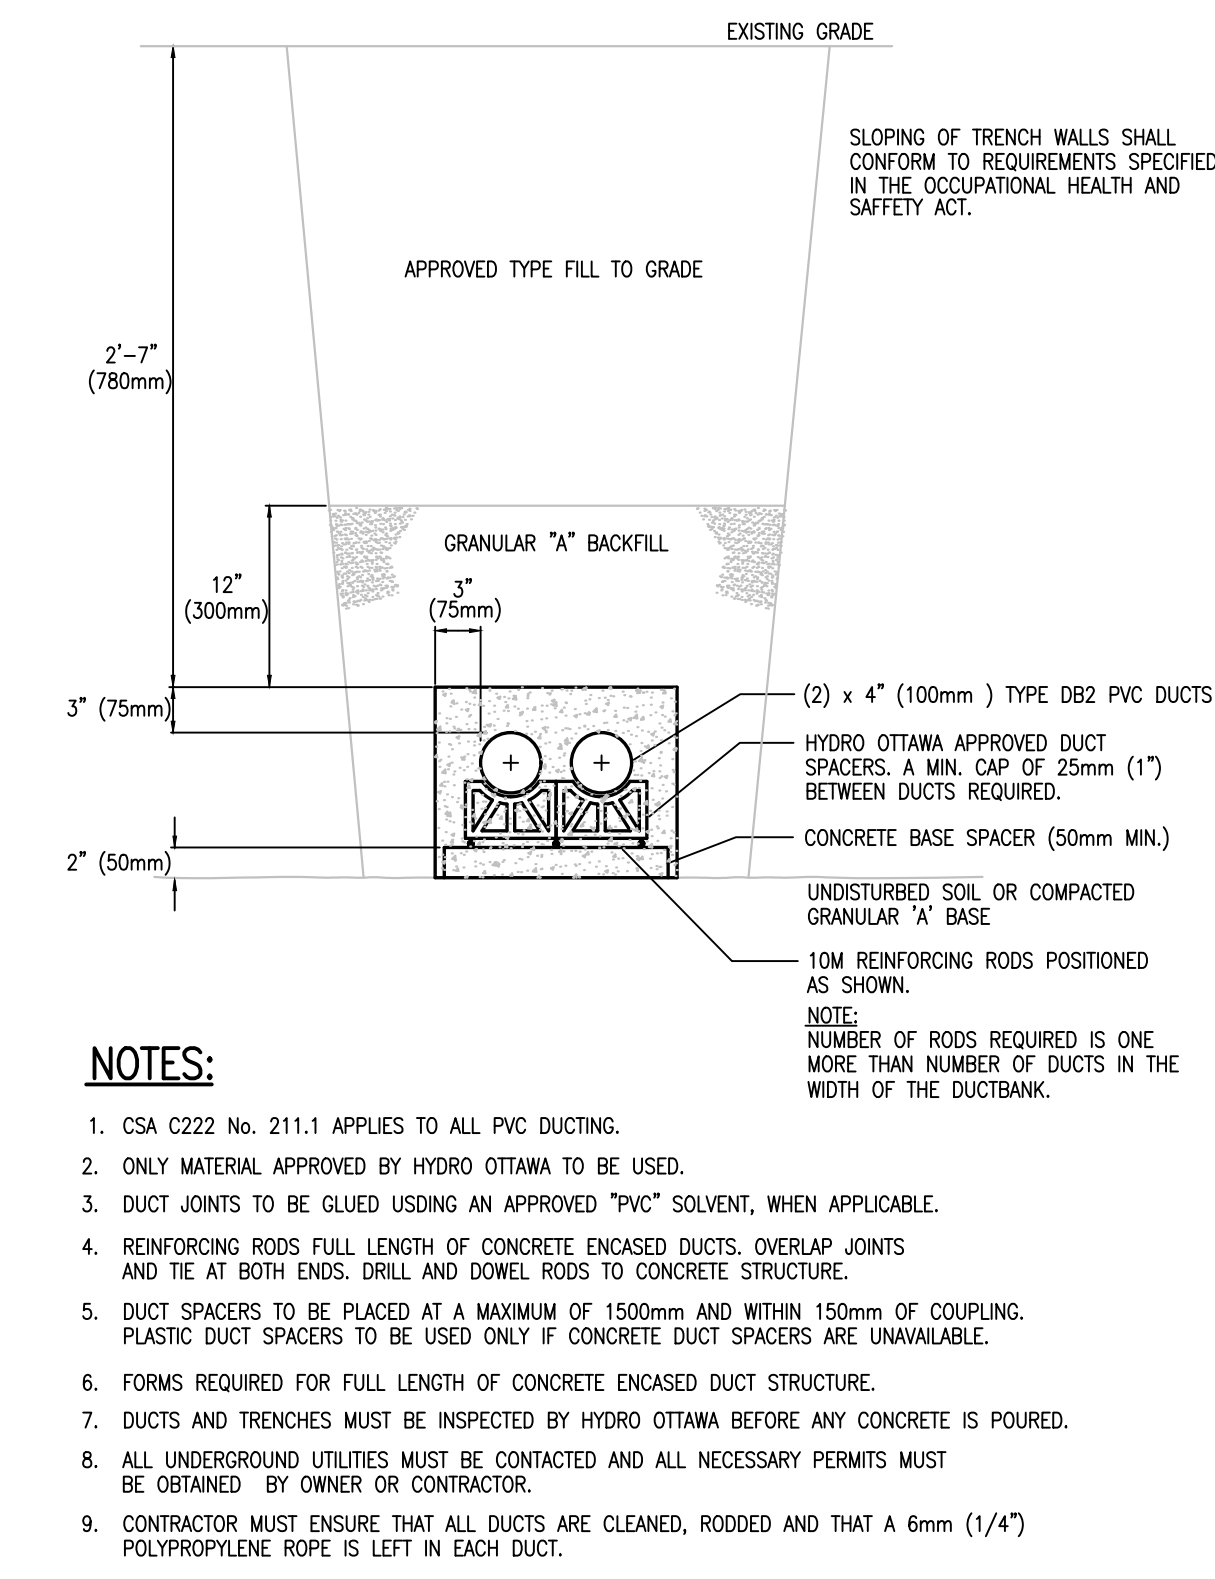

**3**  
**E2** 2-CELL CONCRETE DUCT BANK FOR SECONDARY SERVICE  
N.T.S.

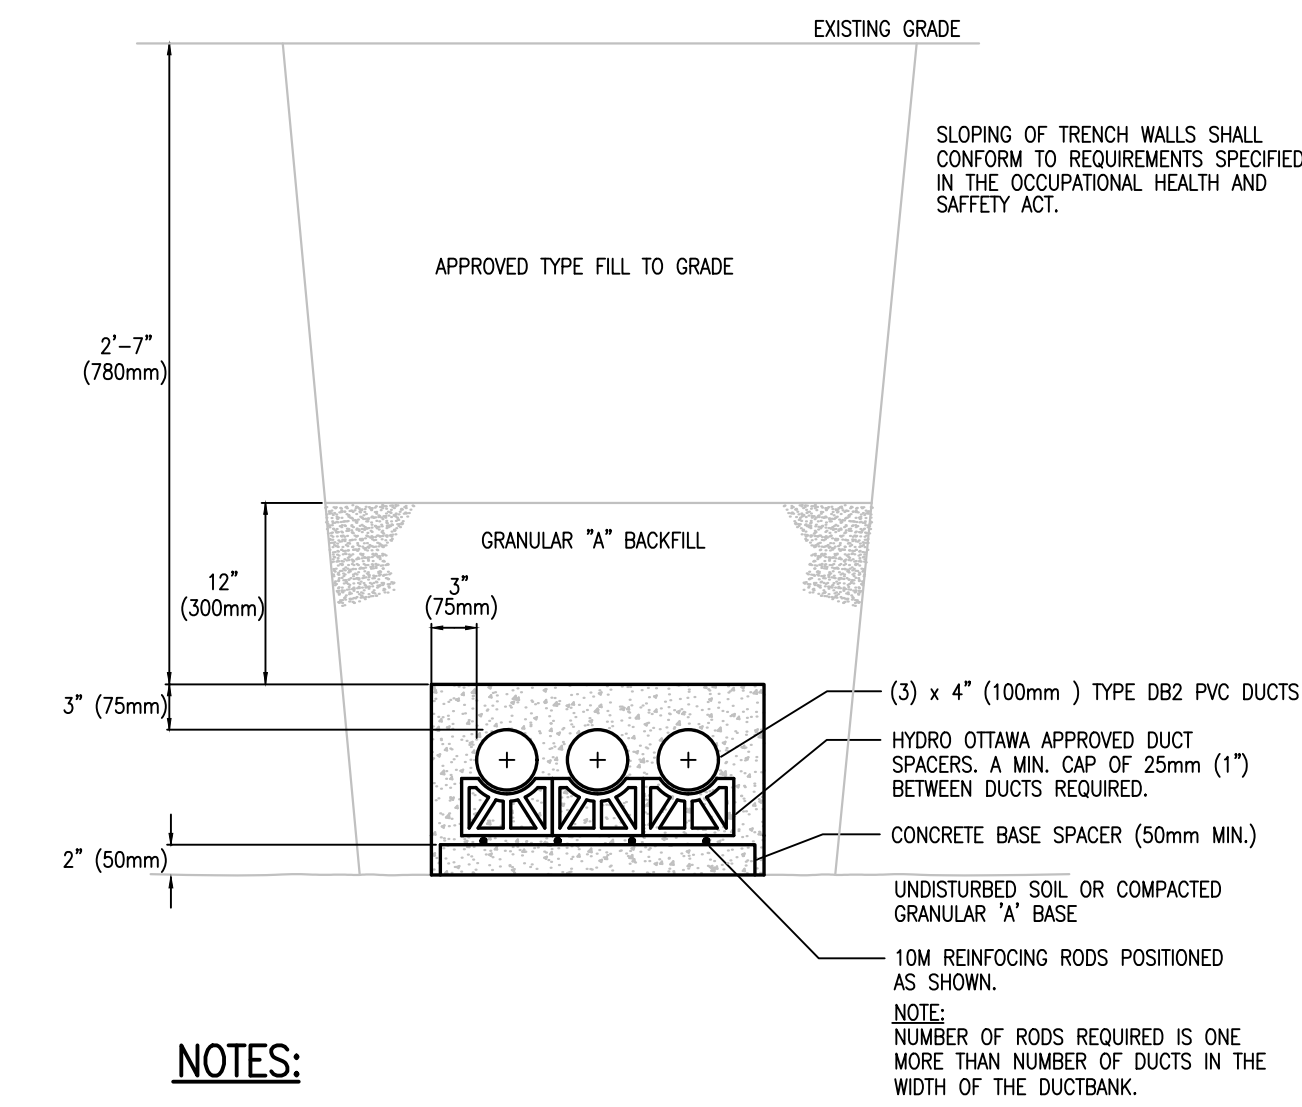

**4**  
**E2** 3-CELL CONCRETE DUCT BANK FOR SECONDARY SERVICE  
N.T.S.

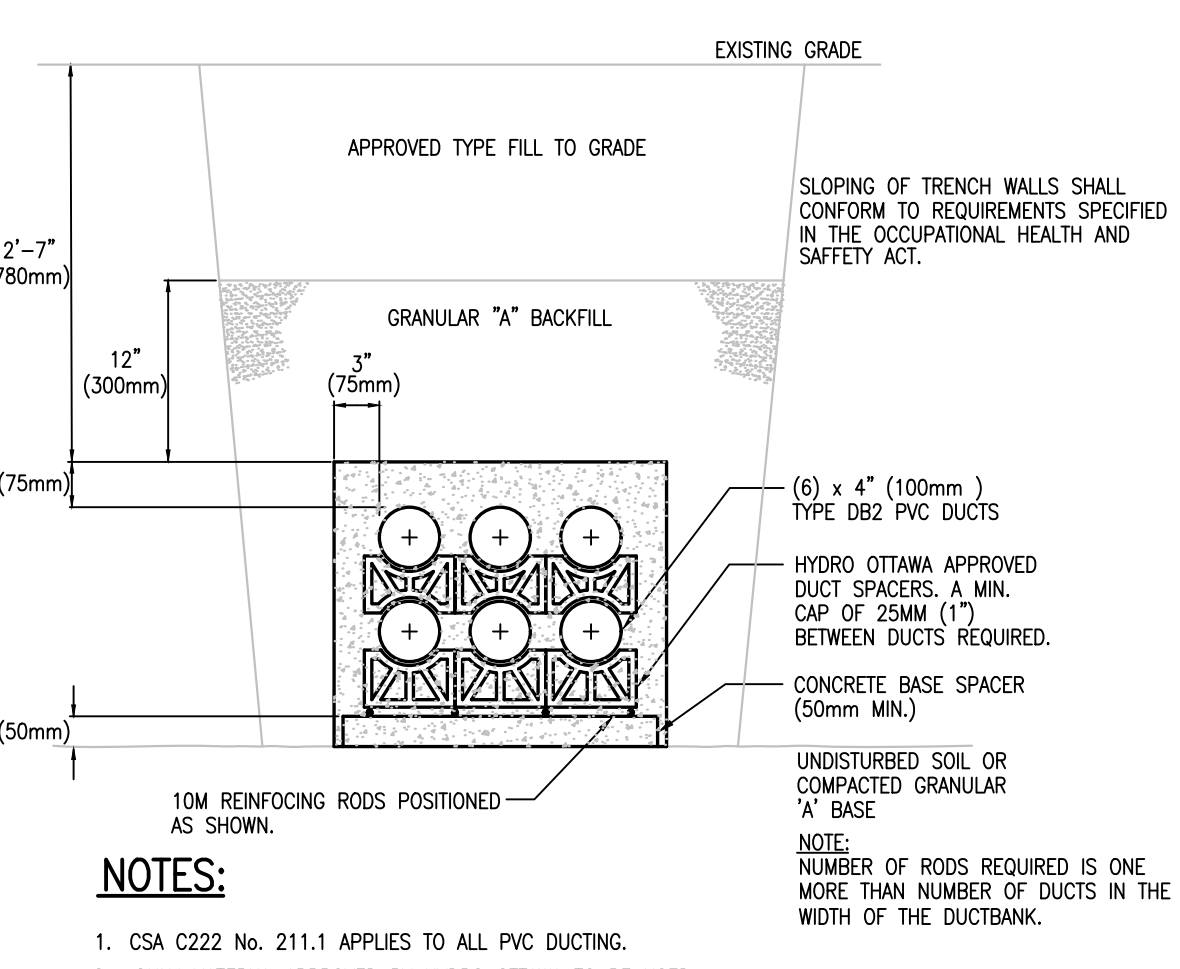

**5**  
**E2** 5-CELL CONCRETE DUCT BANK FOR SECONDARY SERVICE  
N.T.S.

DATE	REVISION	REF
2021-12-16	ISSUED FOR SITE PLAN	0

THE ENGINEER MAKES NO AND ALL RESPONSIBILITY AND LIABILITY FOR PROBLEMS WHICH MAY BE CAUSED BY FAILURE TO FOLLOW THESE PLANS, SPECIFICATIONS AND THE DESIGN INTENT. THE ENGINEER'S LIABILITY IS LIMITED TO THE DESIGN AND THE DESIGN INTENT. THE ENGINEER'S LIABILITY IS LIMITED TO THE DESIGN AND THE DESIGN INTENT. THE ENGINEER'S LIABILITY IS LIMITED TO THE DESIGN AND THE DESIGN INTENT.

**Goodkey Weedmark Consulting Engineers**  
 GOODKEY WEEDMARK & ASSOCIATES LIMITED  
 1688 Woodward Dr.  
 Ottawa, Ontario  
 K2C 3J8  
 613 727-5111  
 613 727-5115  
 www.gwe.com

Project north  
 Seal/Stamp

Project/Client  
**ACCESS STORAGE**  
 60 DENZIL DOYLE CT.  
 OTTAWA ON

Drawing Title/Rev. No. des. dessin  
**SINGLE LINE DIAGRAM, EXTERIOR LIGHT SCHEDULE, ELECTRICAL DETAILS**

Scale  
 Etchelle AS NOTED  
 Project no./No. du projet 2021-566

Design by D.V.  
 Conçu par D.V.  
 Drawn by B.P.  
 Dessiné par B.P.  
 Reviewed by D.V.  
 Revisé par D.V.

Date DECEMBER 2022  
 Révisé par  
 Appr. l'ing./Factor

**E2**

or 2