


LEGEND

DRAINAGE AREA (x) AREA (xxx) (ha.)

0.xx

5 YEAR RUNOFF COEFFICIENT

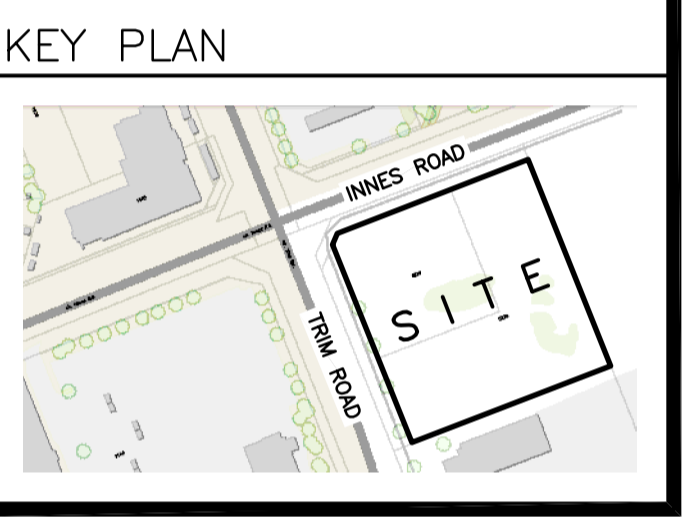


No.	DATE	REVISION
2	MAR 26-24	RE-ISSUED FOR APPROVAL
1	NOV 15-23	ISSUED FOR APPROVAL

D. B. GRAY ENGINEERING INC.
 Stormwater Management - Grading & Drainage - Storm & Sanitary Sewers - Watermain
 700 Long Point Circle 613-425-8044
 Ottawa, Ontario d.gray@dbgrayengineering.com

Project
PROPOSED 3-STORY DYMON STORAGE BUILDING
 5210 INNES ROAD
 OTTAWA, ONTARIO

Drawing Title
PRE-DEVELOPMENT DRAINAGE PLAN

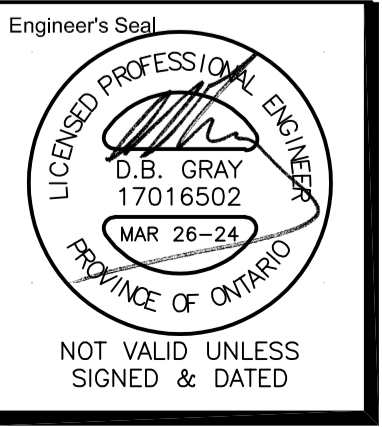

Engineer's Seal
 Drawn D.B.G.
 H. Scale 1:250
 V. Scale
 Date DEC 19-22
 Job No. 21025
 Drawing No.
C-7
 of 9

