


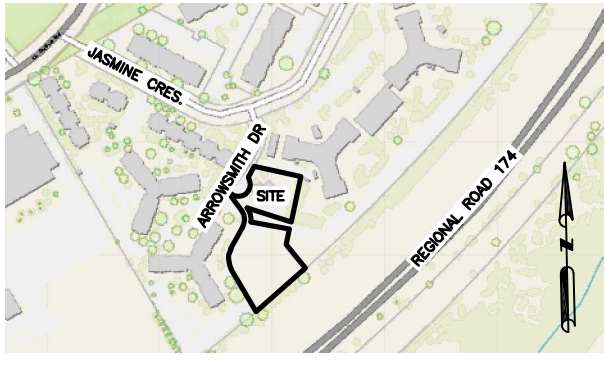

KEY PLAN



5	DEC 10-25	RE-ISSUED FOR APPROVAL
4	JAN 17-25	ISSUED FOR ZONING
3	DEC 6-24	ISSUED FOR BUILDING PERMIT
2	DEC 21-22	ISSUED FOR APPROVAL
1	DEC 19-22	ISSUED FOR COORDINATION
No.	DATE	REVISION


D. B. GRAY ENGINEERING INC.

Stormwater Management - Grading & Drainage - Storm & Sanitary Sewers - Watermain

700 Long Point Circle  
Ottawa, Ontario  
613-425-8044  
d.gray@dbgrayengineering.com

Project  
**PROPOSED 6-STORY  
MIXED-USE BUILDING  
2040 ARROWSMITH DRIVE  
OTTAWA, ONTARIO**

Drawing Title  
**PRE-DEVELOPMENT  
DRAINAGE PLAN**

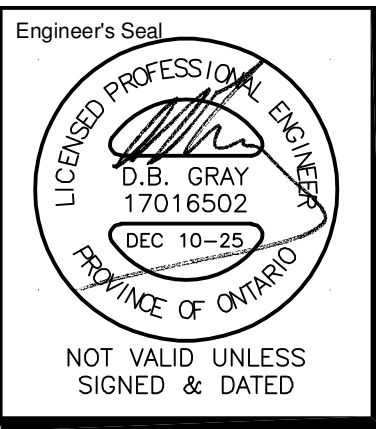

Drawn D.B.G.  
H. Scale 1:400  
V. Scale  
Date NOV 29-22  
Job No. 22062

Drawing No.  
**C-12  
of 17**