


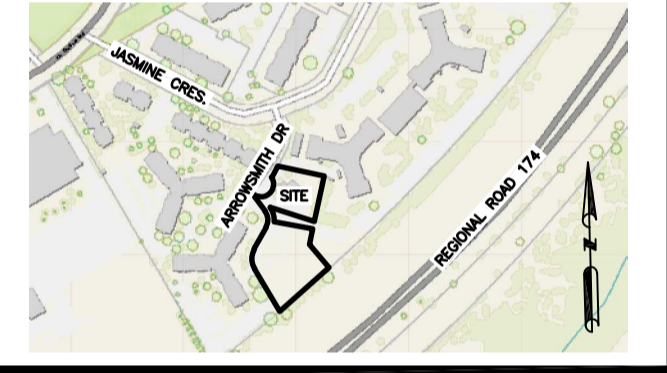

KEY PLAN



| No. | DATE      | REVISION                |
|-----|-----------|-------------------------|
| 2   | DEC 21-22 | ISSUED FOR APPROVAL     |
| 1   | DEC 19-22 | ISSUED FOR COORDINATION |

**D. B. GRAY ENGINEERING INC.**  
 Stormwater Management - Grading & Drainage - Storm & Sanitary Sewers - Watermain  
 700 Long Point Circle 613-425-8044  
 Ottawa, Ontario d.gray@dbgrayengineering.com

Project  
**PROPOSED 6-STOREY  
 MIXED-USE BUILDING  
 2040 ARROWSMITH DRIVE  
 OTTAWA, ONTARIO**

Drawing Title  
**PRE-DEVELOPMENT  
 DRAINAGE PLAN**

Engineer's Seal  
  
 NOT VALID UNLESS  
 SIGNED & DATED

Drawn D.B.G.  
 H. Scale 1:400  
 V. Scale  
 Date DEC 19-22  
 Job No. Z2062  
 Drawing No.  
**C-12  
 of 14**