


LEGEND

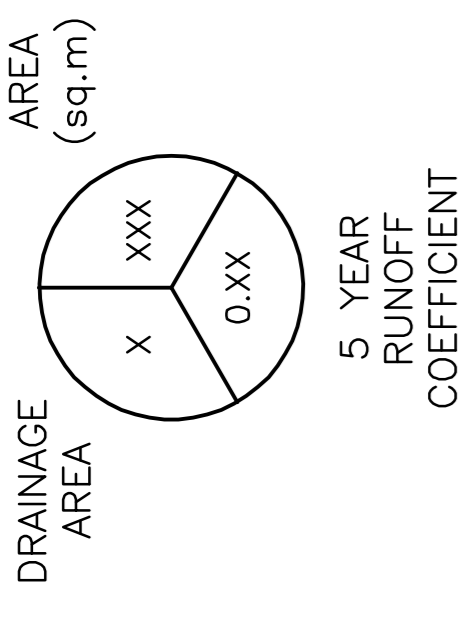

KEY PLAN




No.	DATE	REVISION
1	MAR 27-23	ISSUED FOR APPROVAL

D. B. GRAY ENGINEERING INC.
 Professional Engineer - Ontario
 700 Long Point Circle
 Ottawa, Ontario
 d.gray@dbgrayengineering.com
 613-425-8044


PROPOSED 3-STORY APARTMENT BUILDING
 266 PARK STREET
 OTTAWA, ONTARIO

PRE- & POST- DEVELOPMENT DRAINAGE PLANS

Engineer's Seal
 D.B.G.
 H. Scale 1:100
 V. Scale MAR 27-23
 Date MAR 27-23
 Job No. 22892
 Drawing No. C-5 of 5
 NOT VALID UNLESS SIGNED & DATED

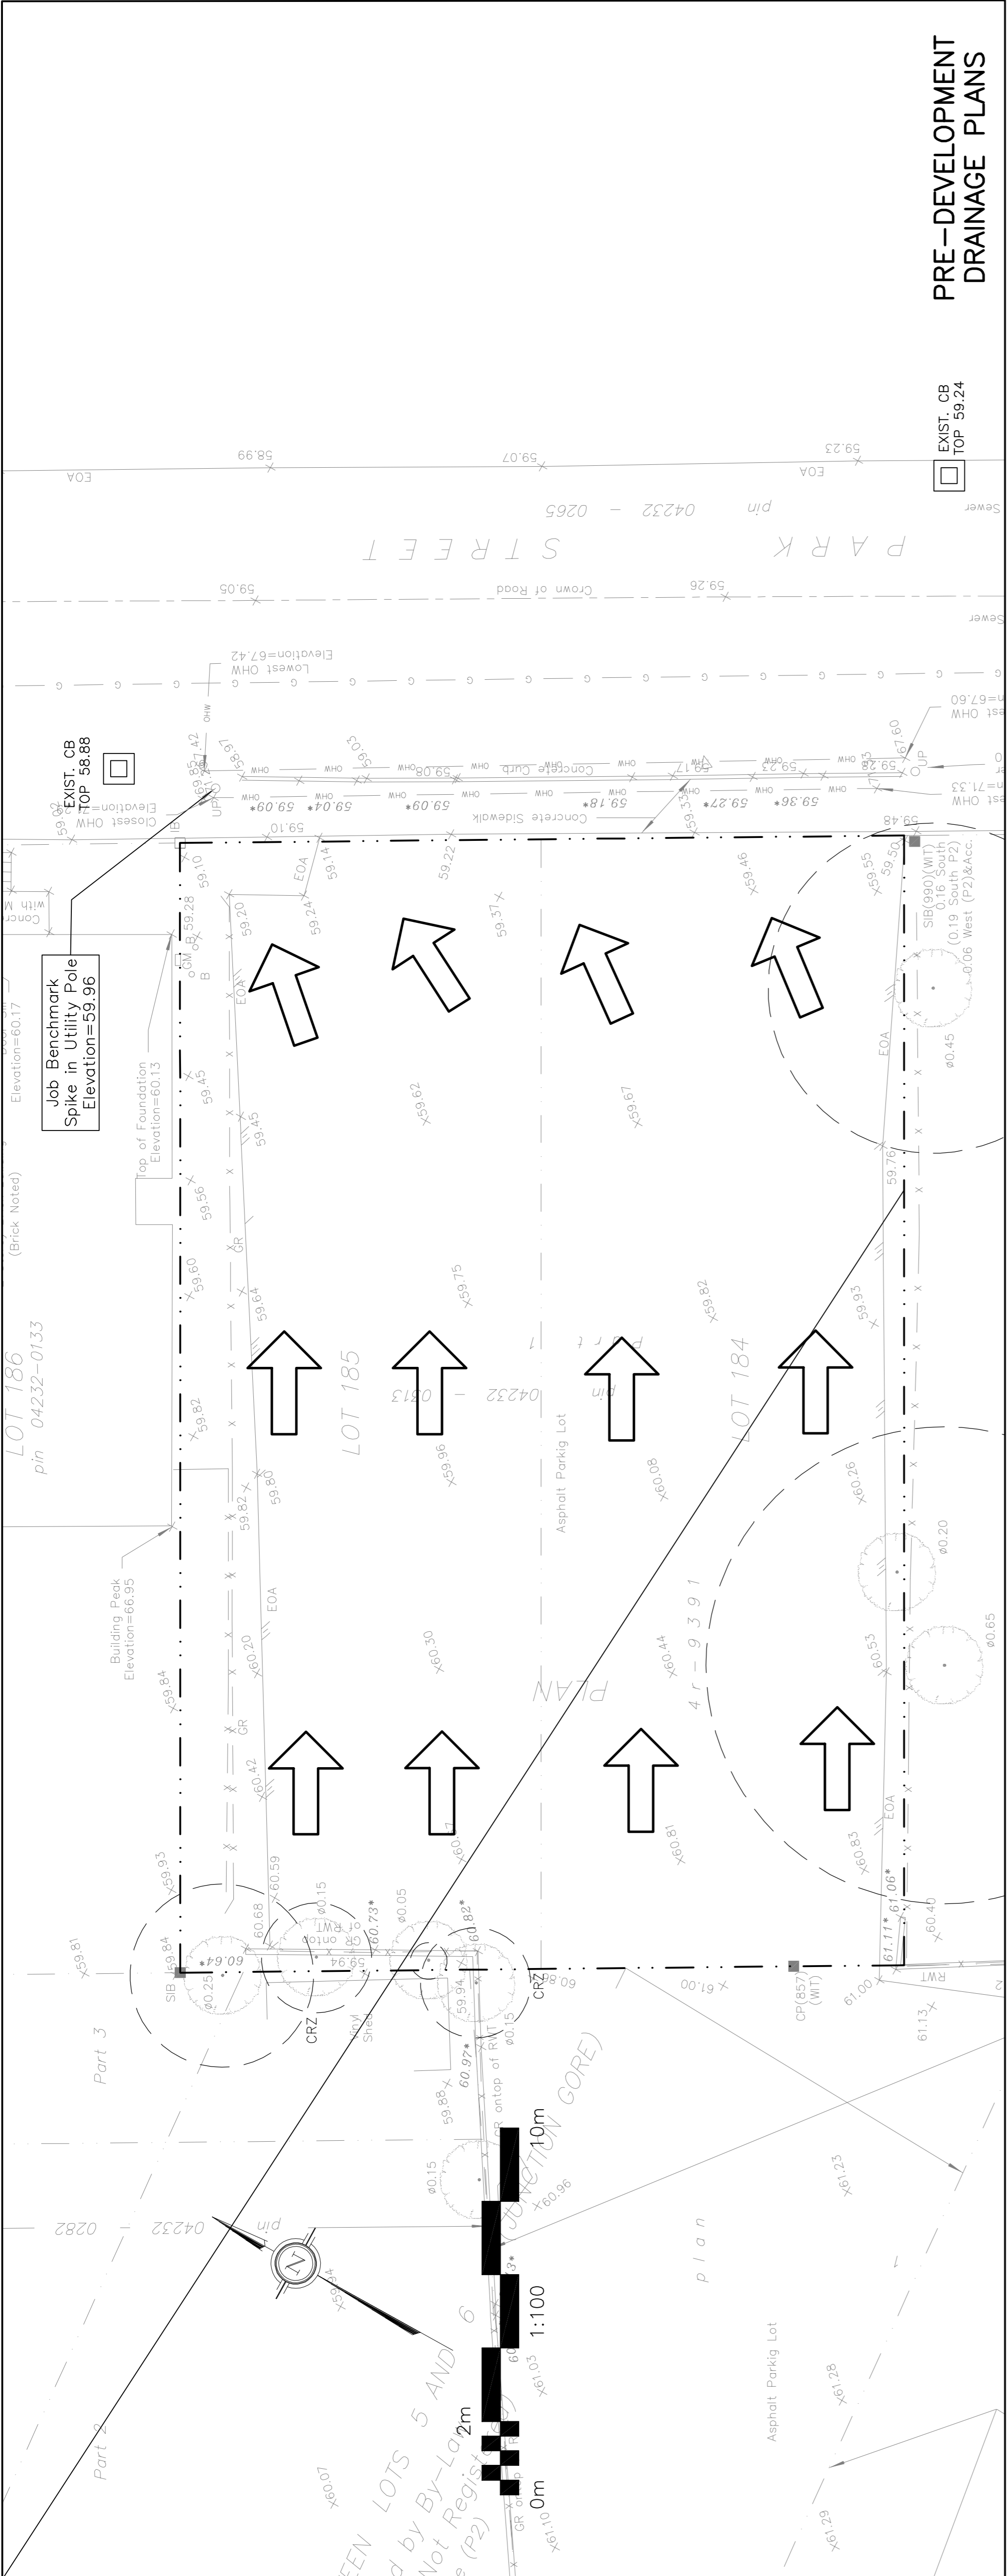

PRE-DEVELOPMENT DRAINAGE PLANS

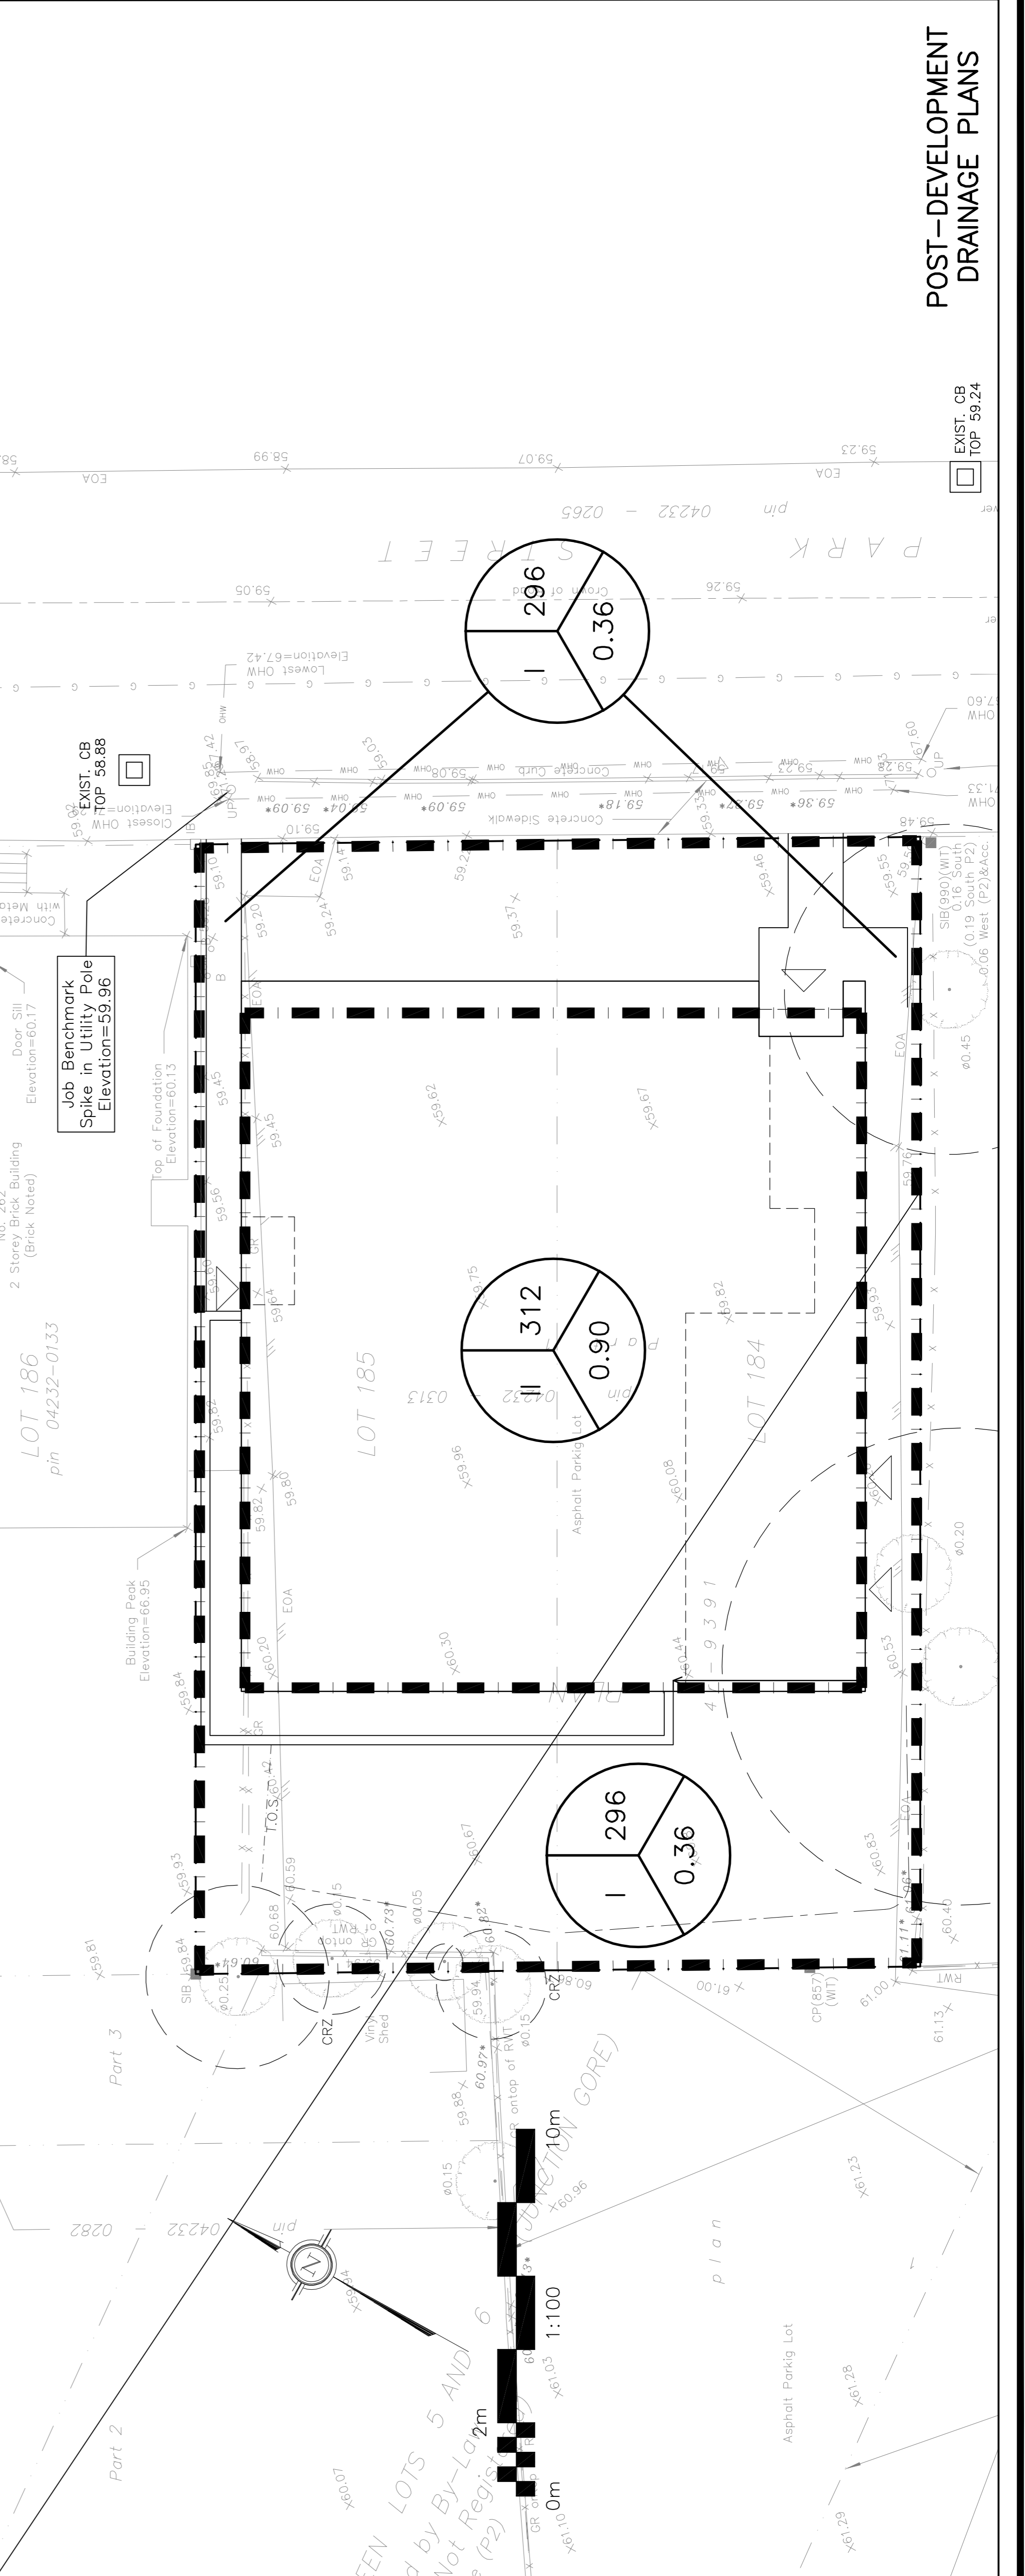

POST-DEVELOPMENT DRAINAGE PLANS